




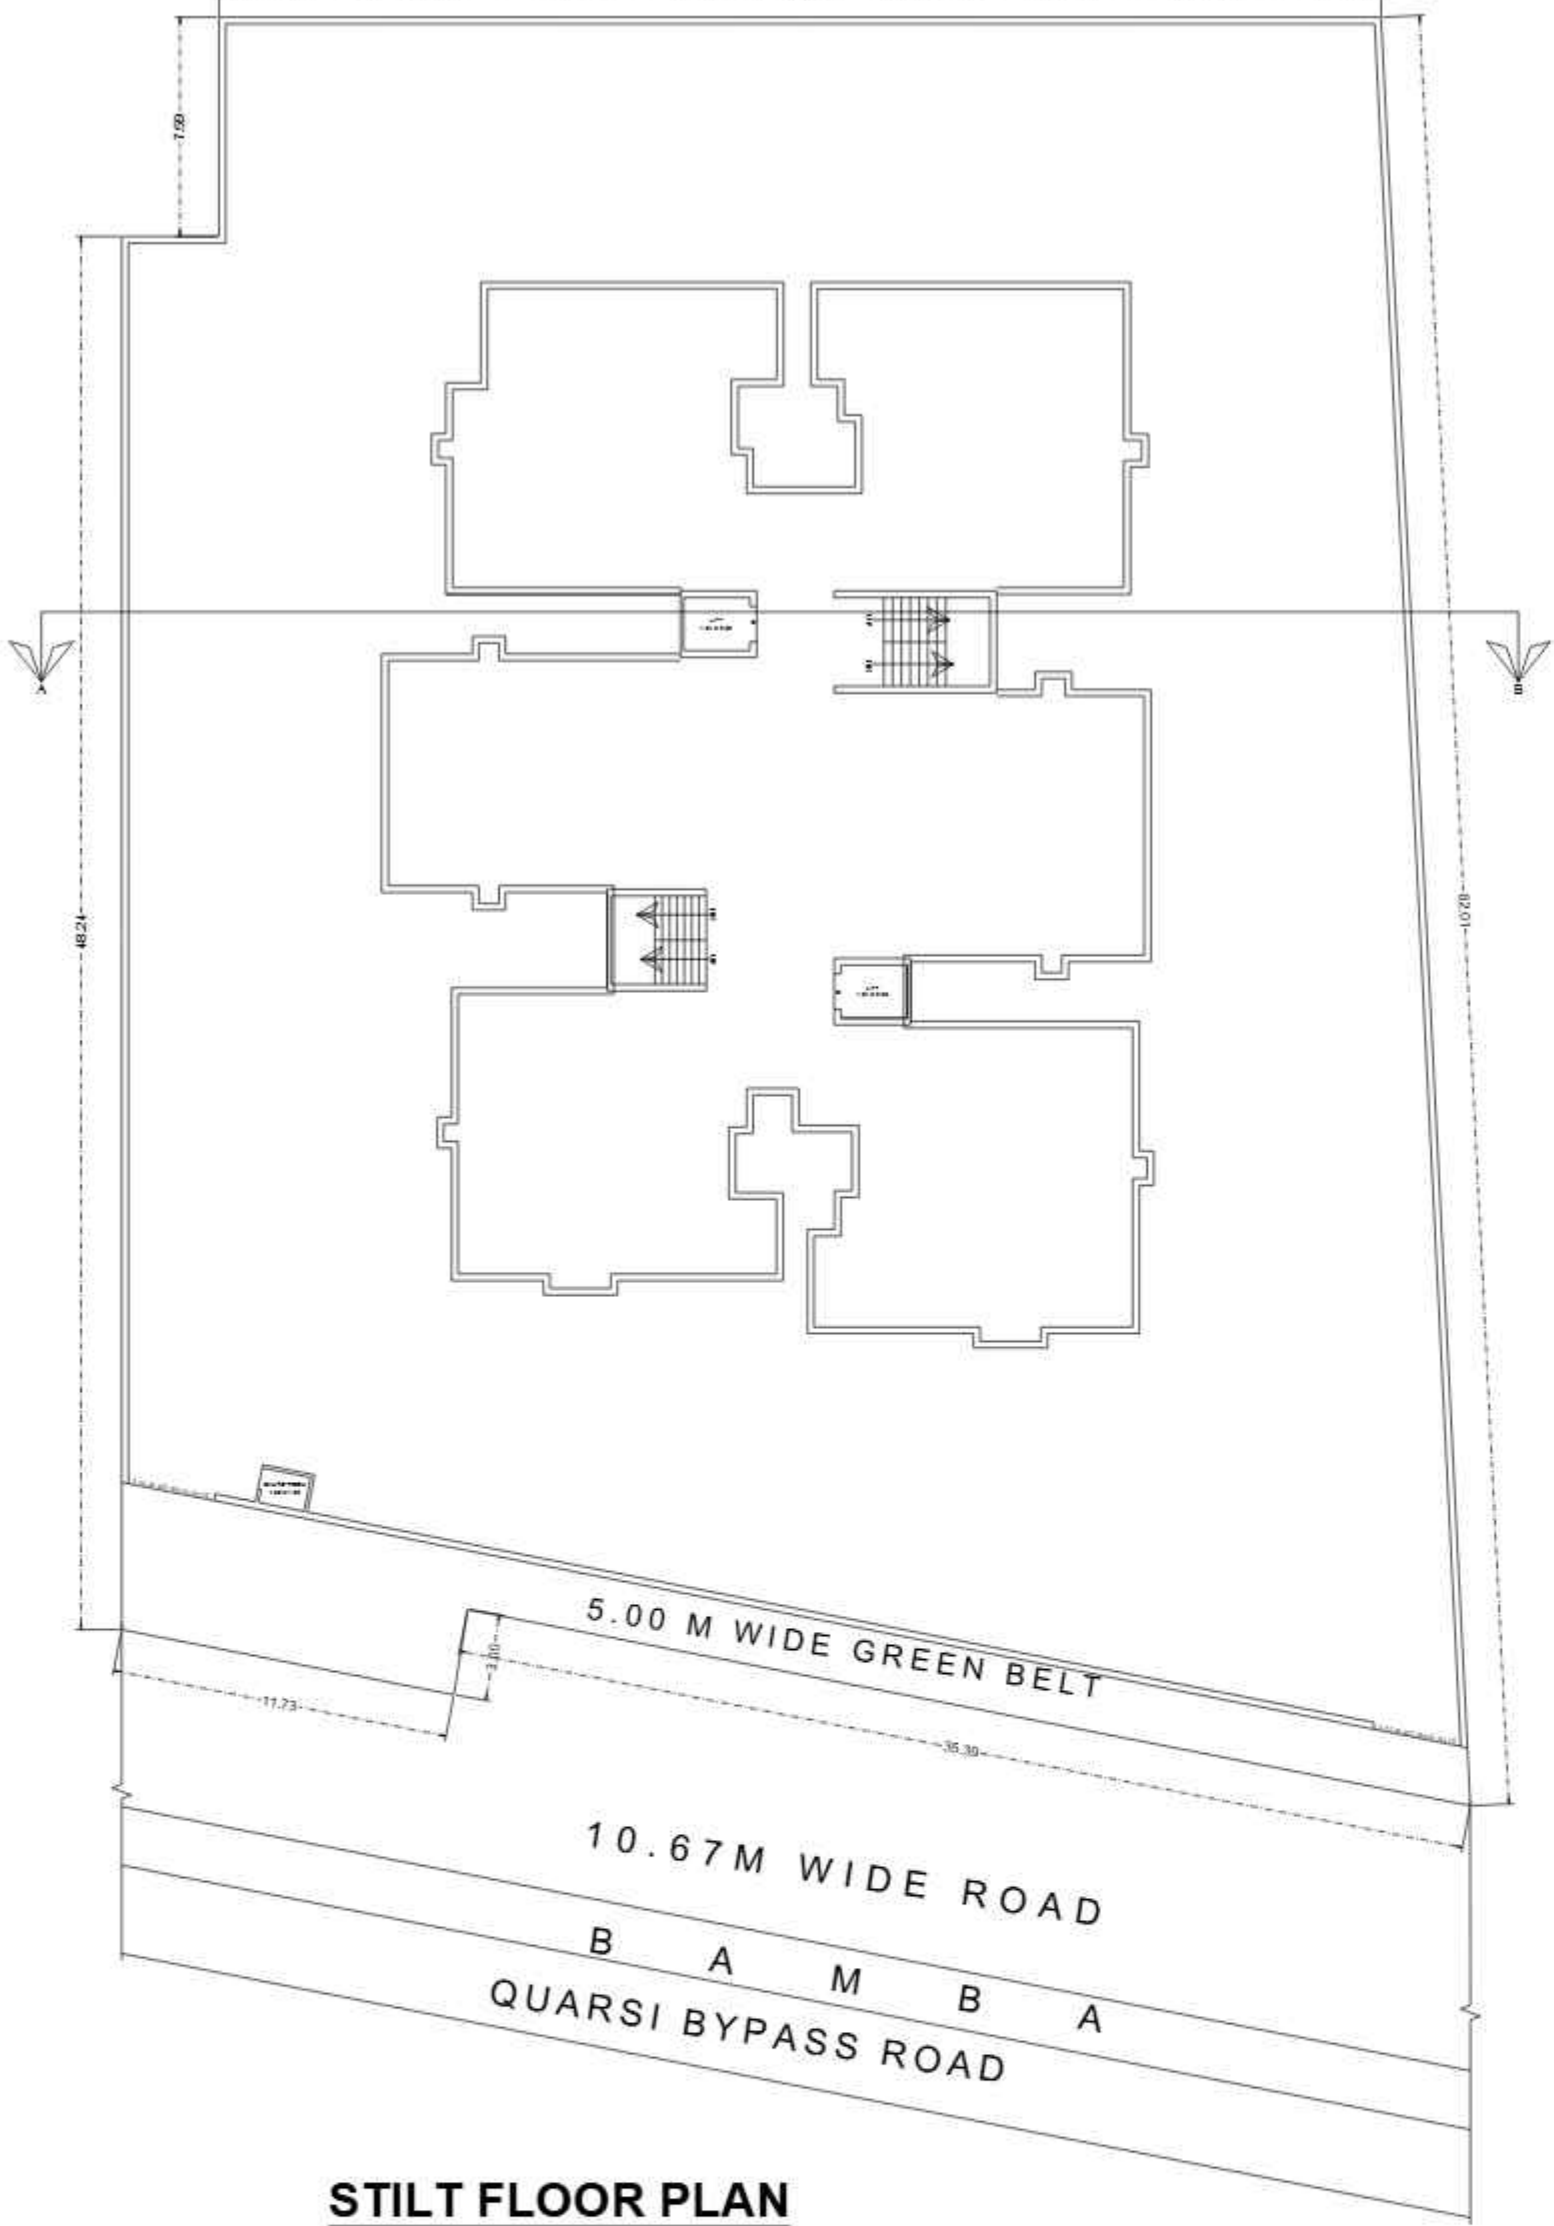


STILT FLOOR PLAN

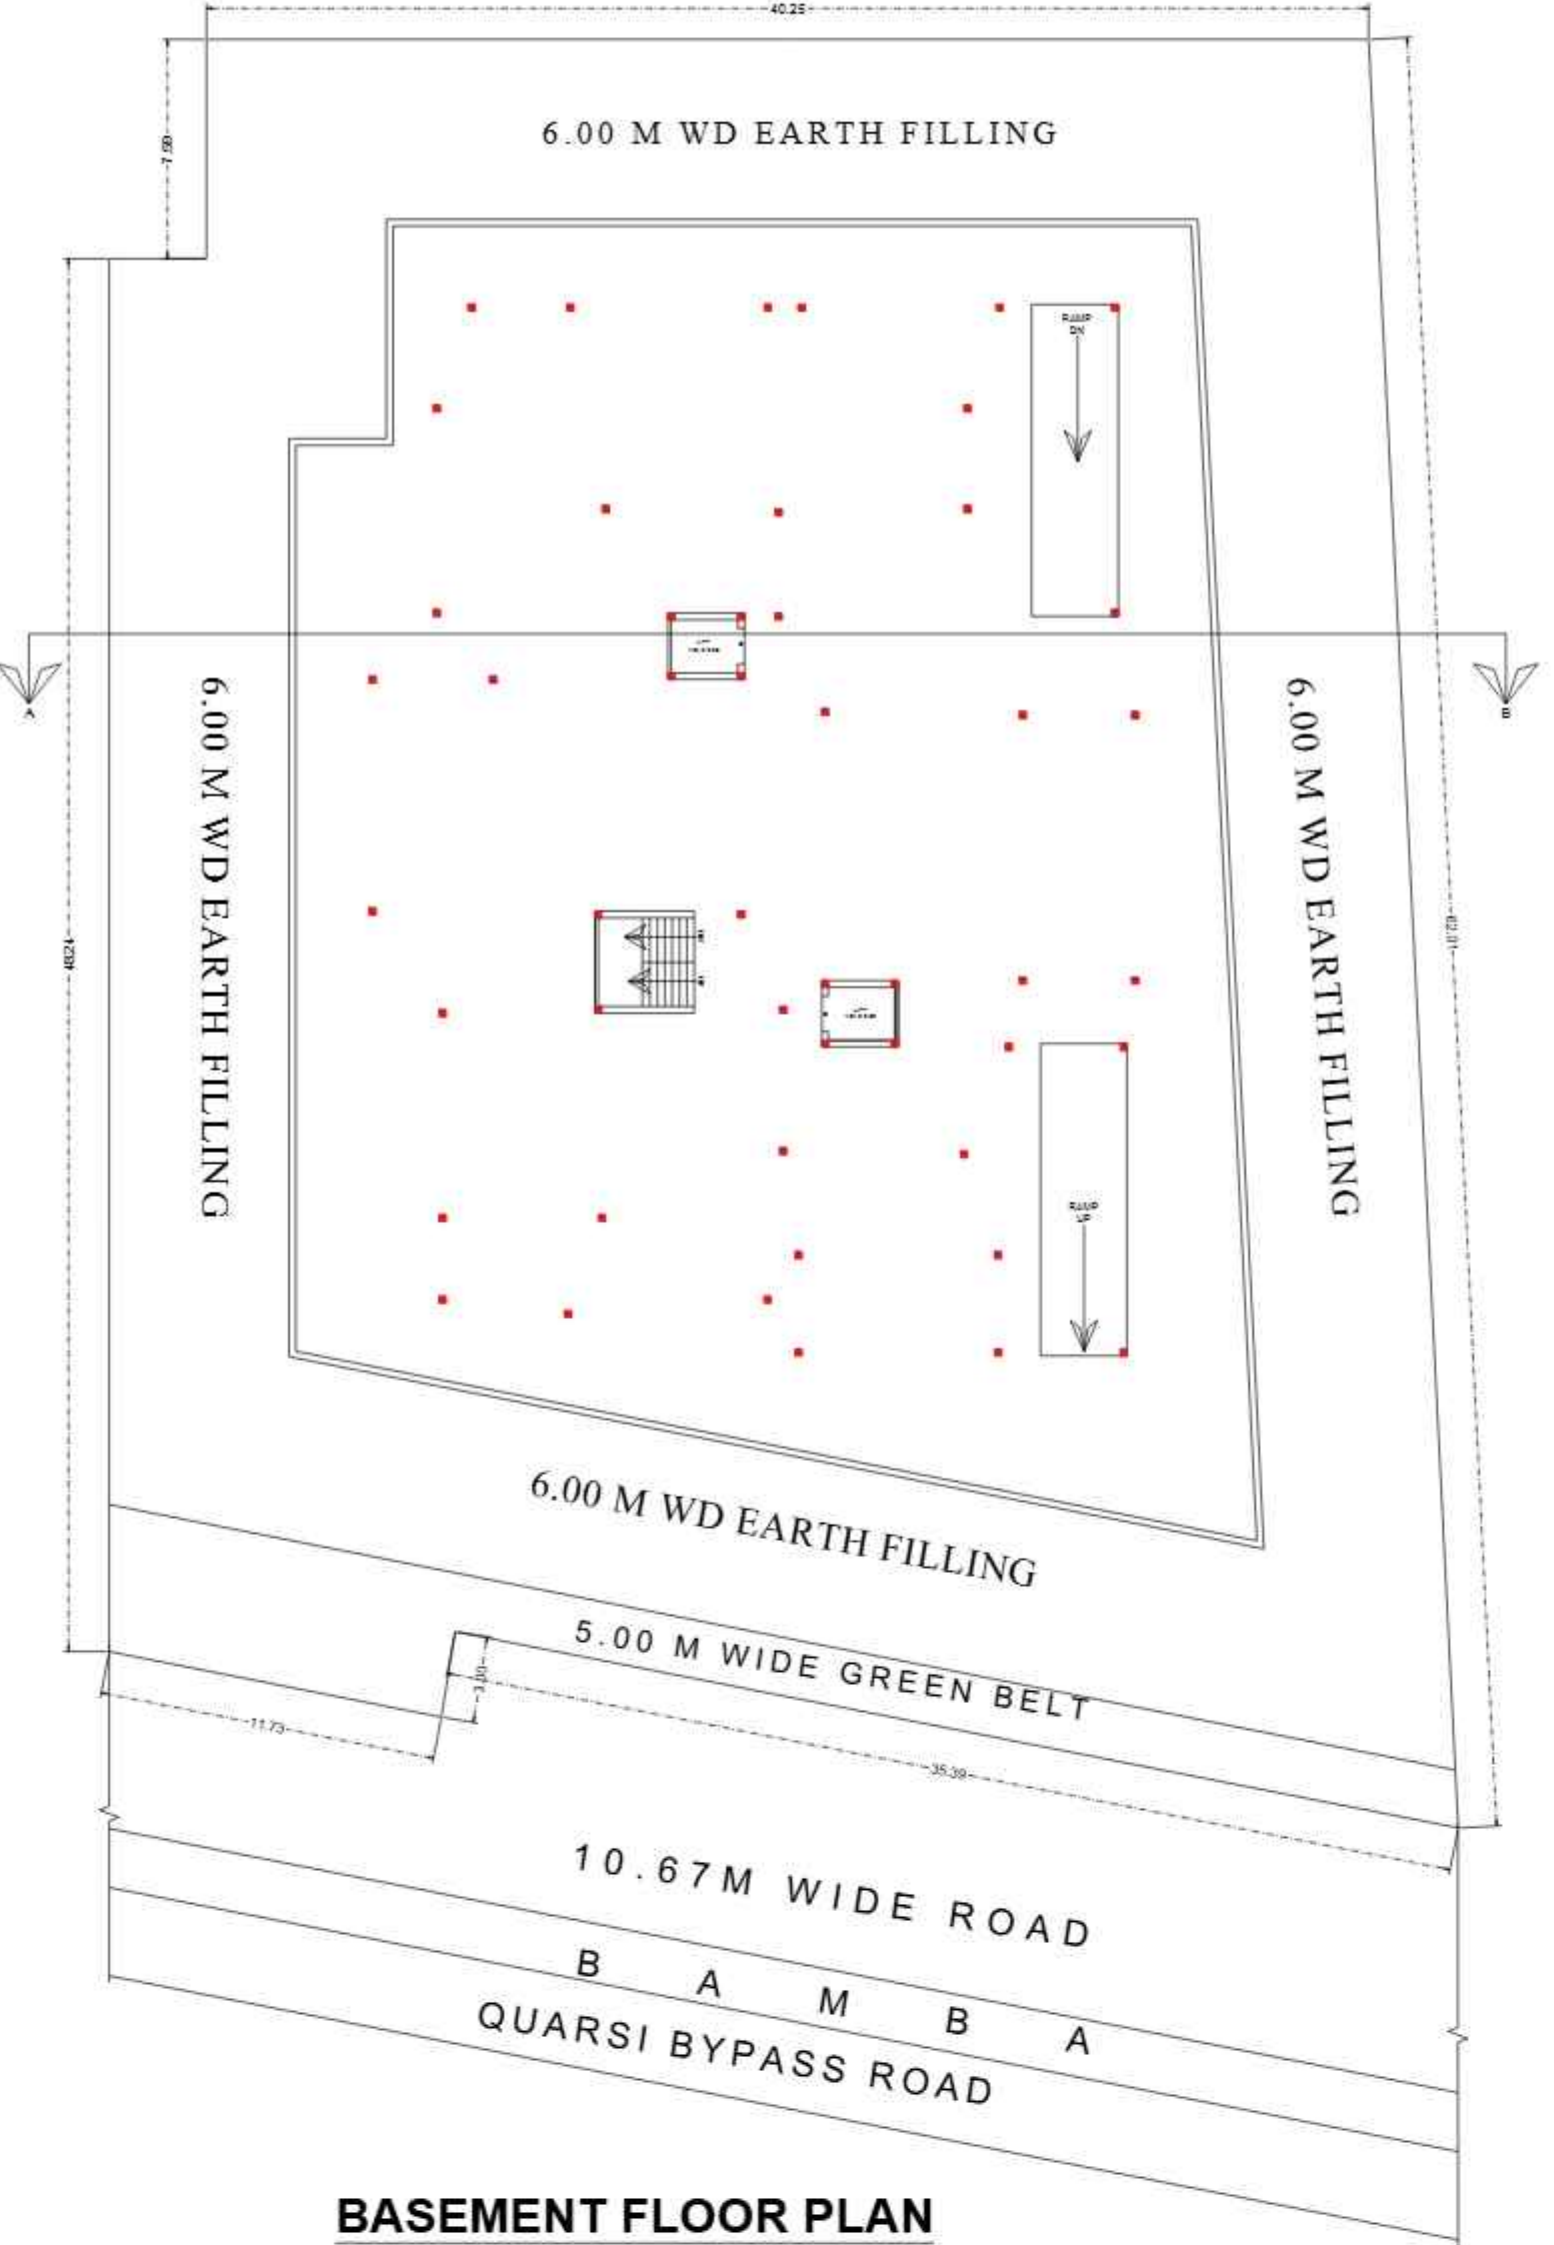


BASEMENT FLOOR PLAN

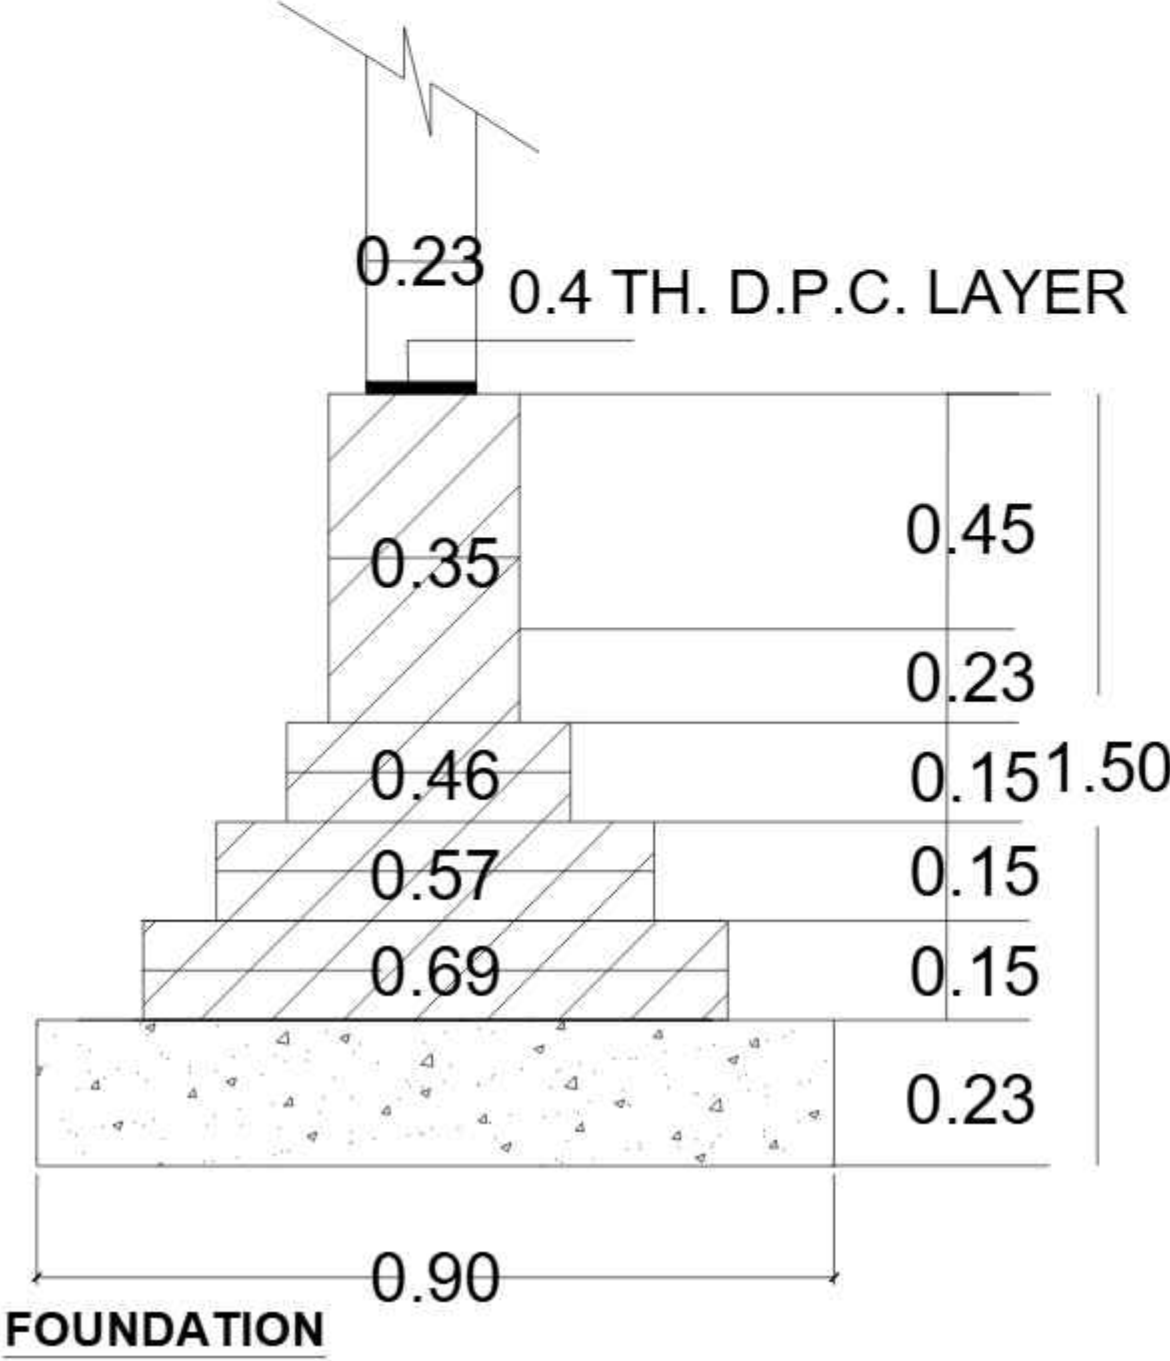

FOUNDATION

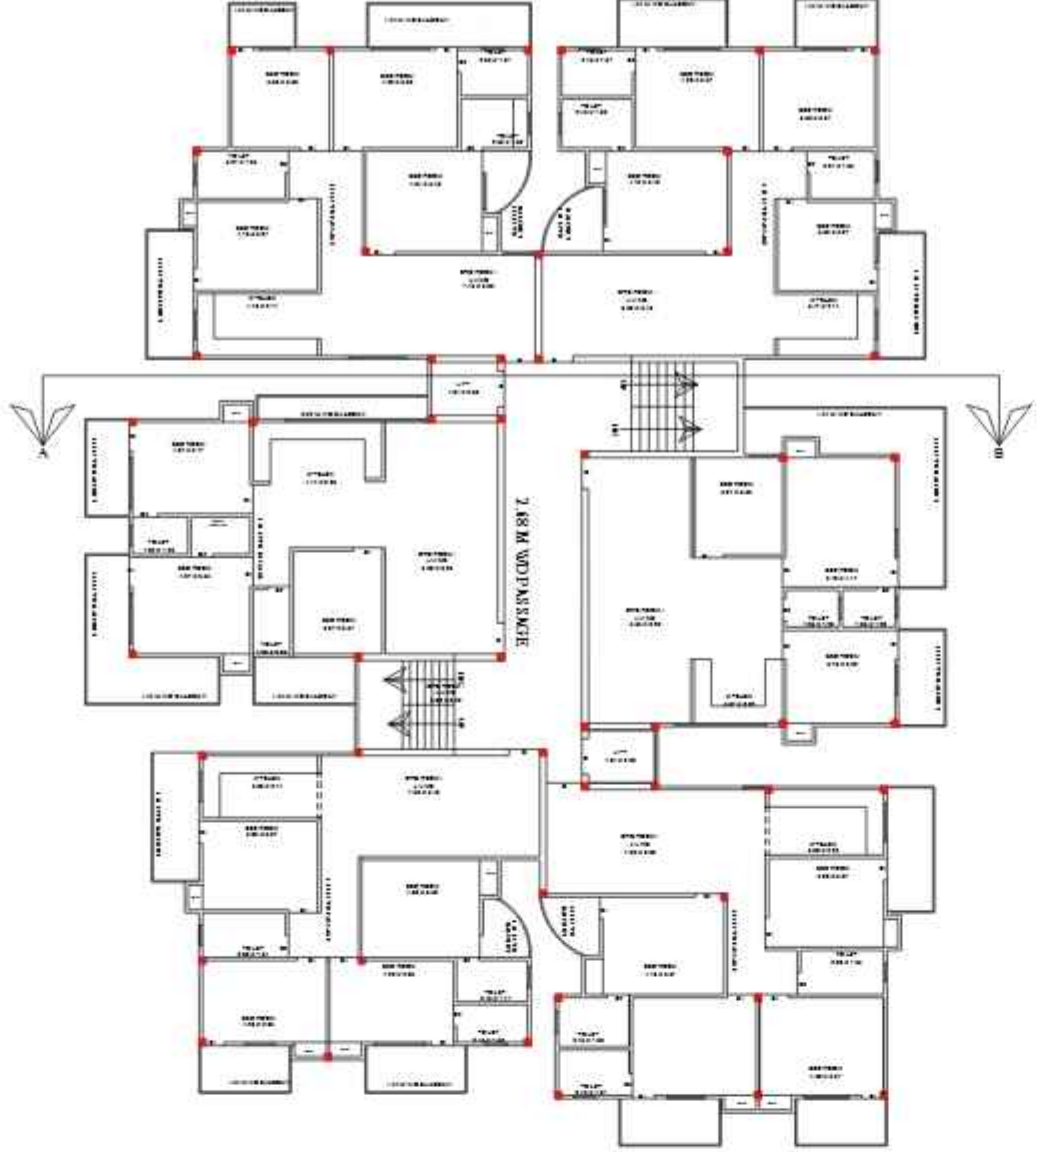


TYPICAL FLOOR PLAN -
1, 2, 3, 4, 5, 6, 7, 8

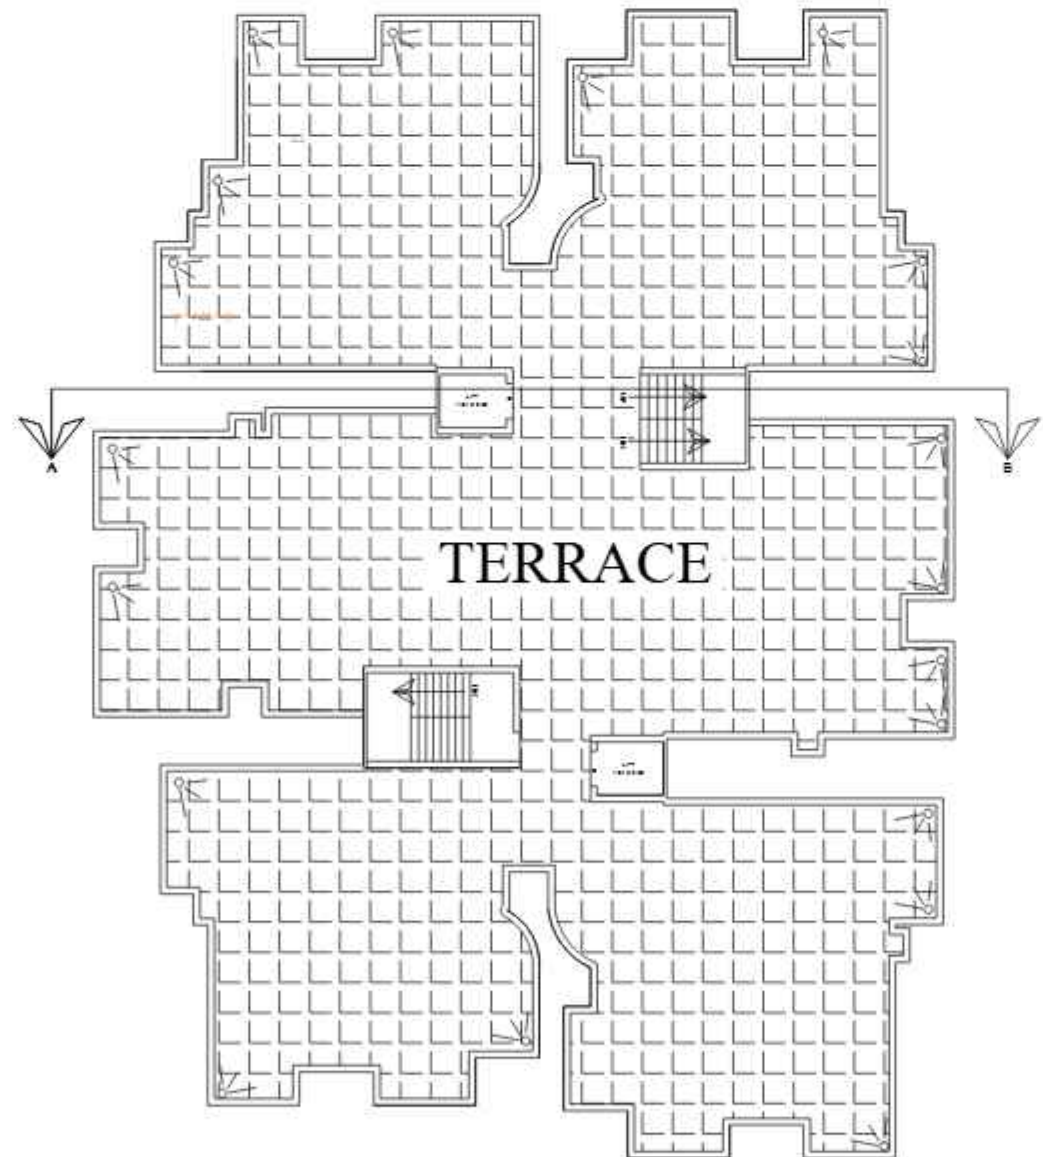



TERRACE FLOOR PLAN




STILT FLOOR ELECTRICAL PLAN

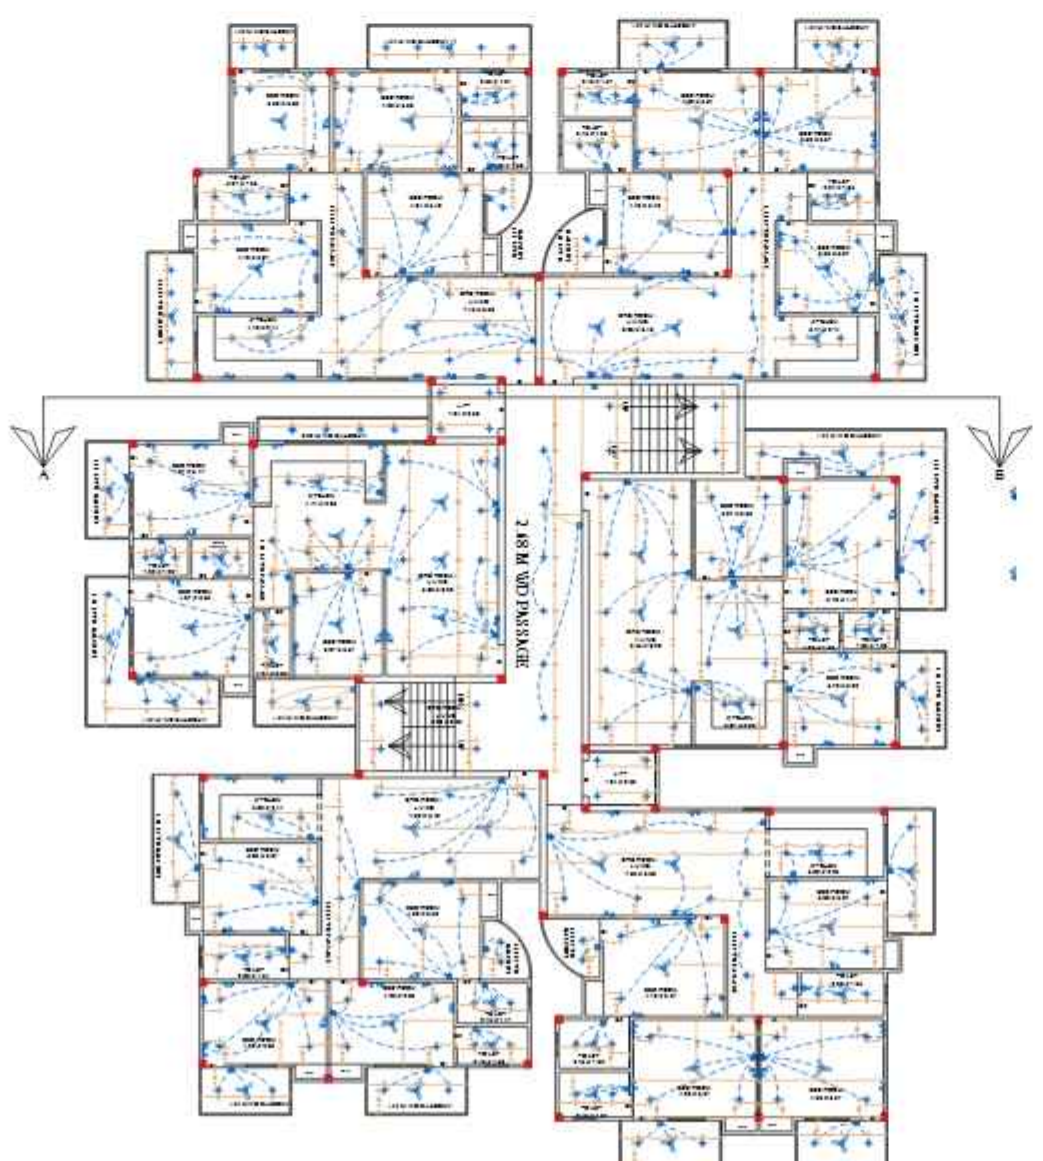


TYPICAL FLOOR ELECTRICAL PLAN - 1, 2, 3, 4, 5,

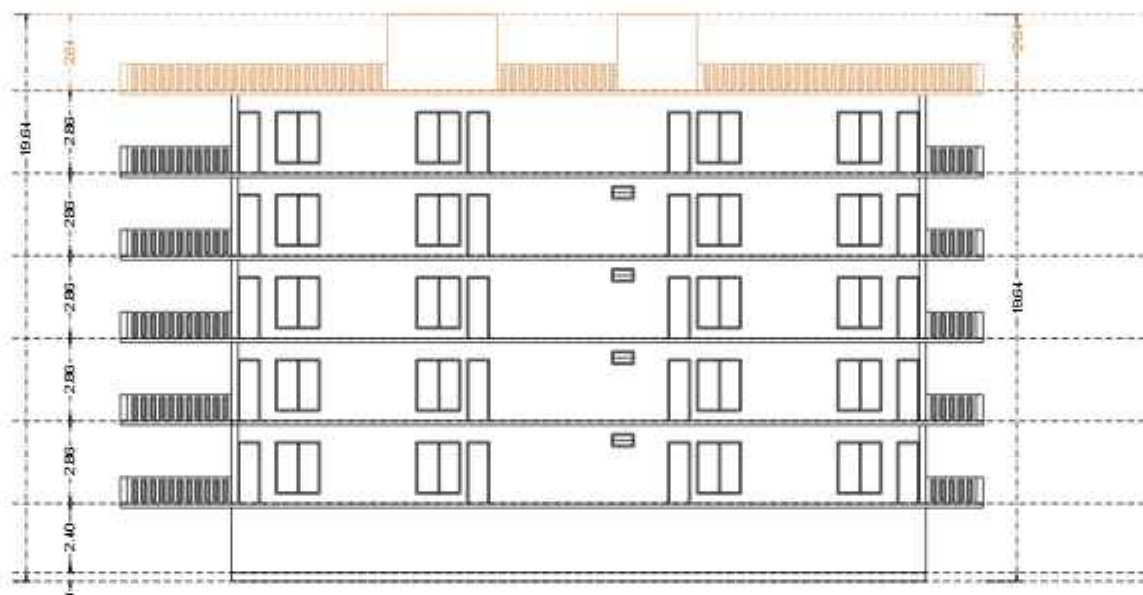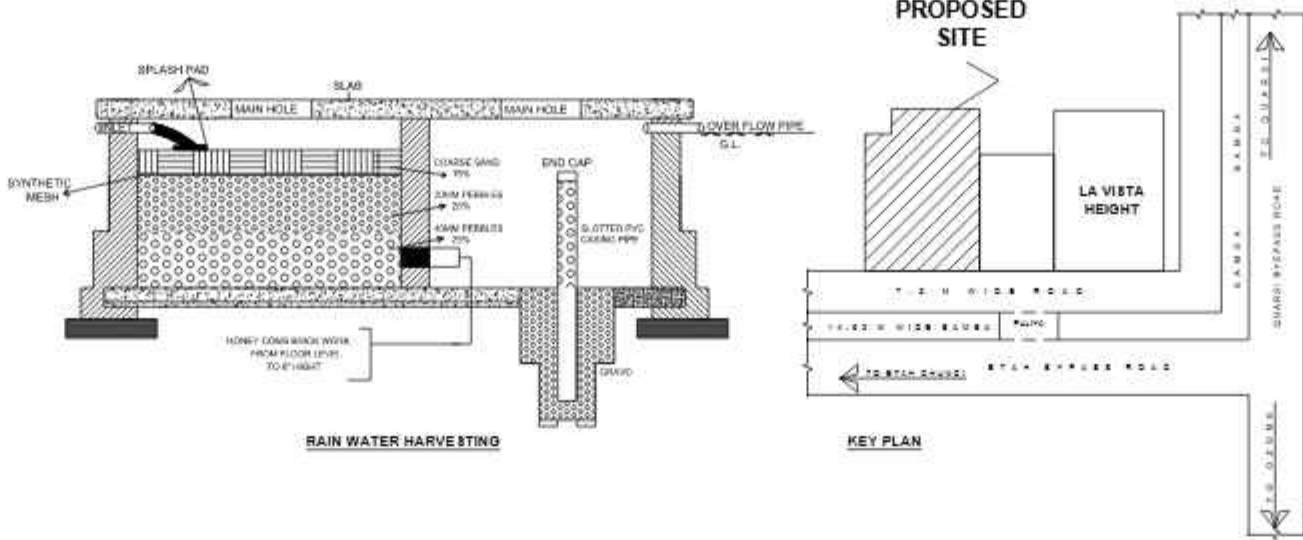


FRONT ELEVATION

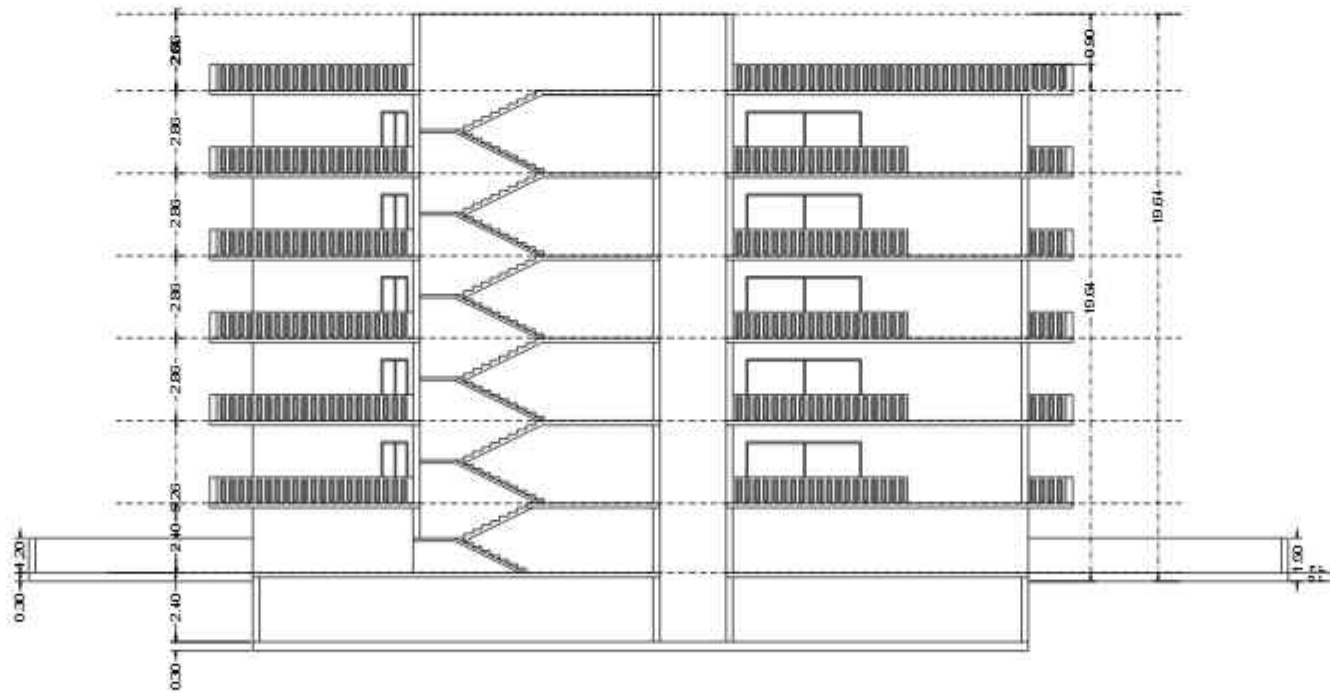


SECTION A-B

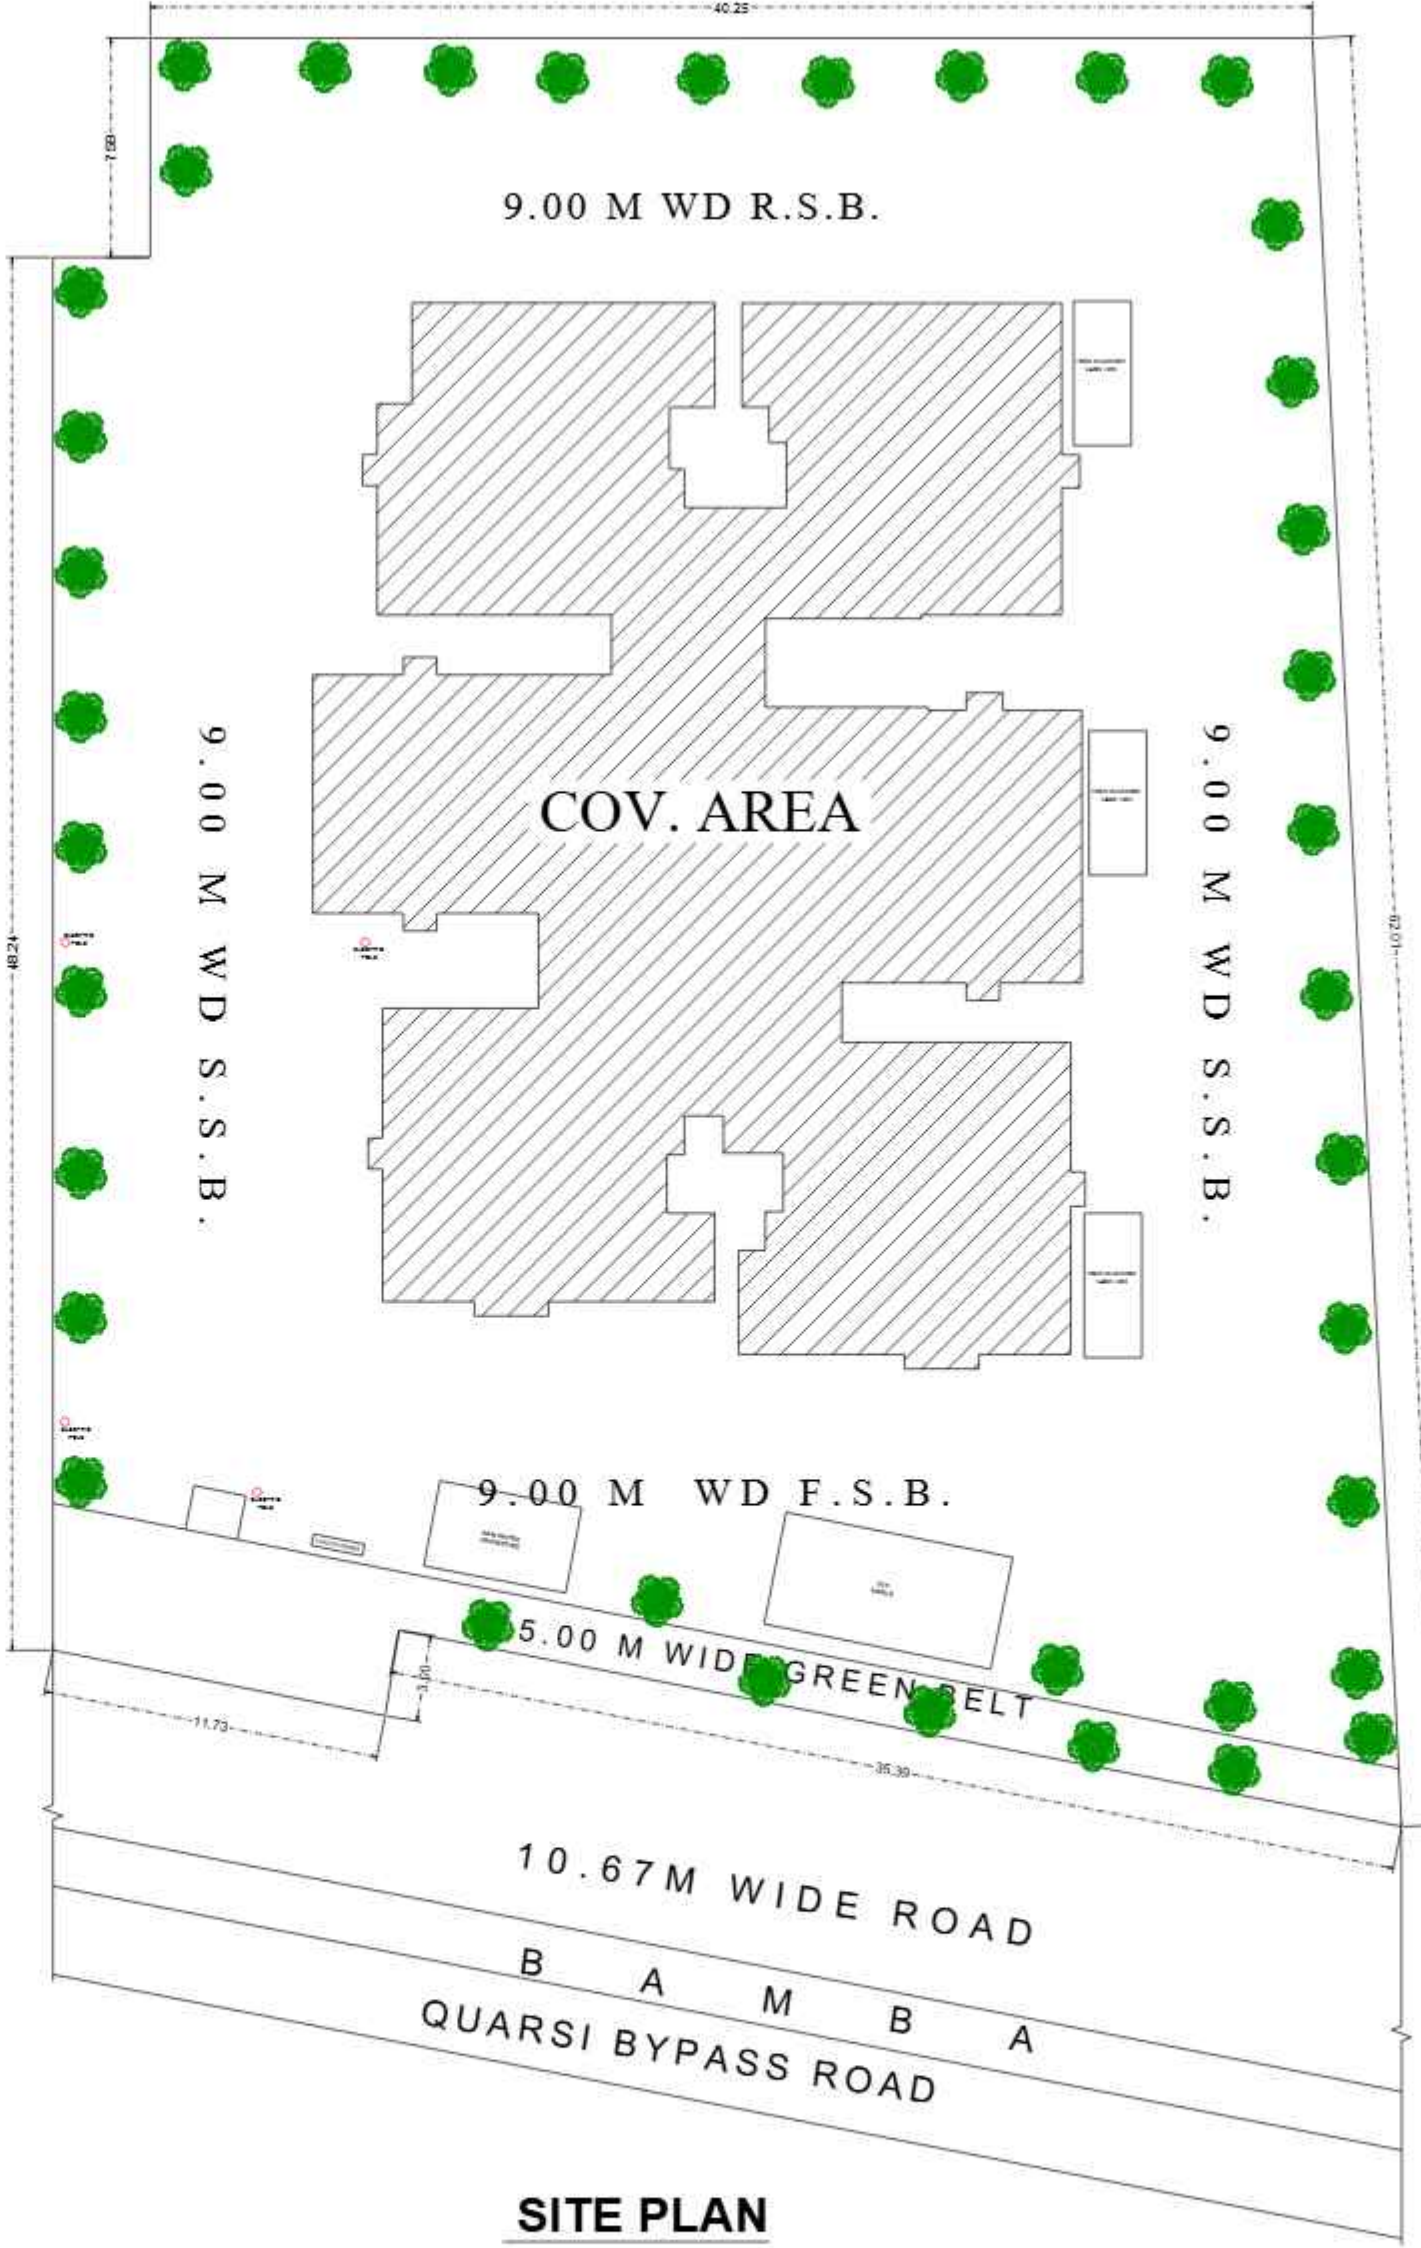

SITE PLAN

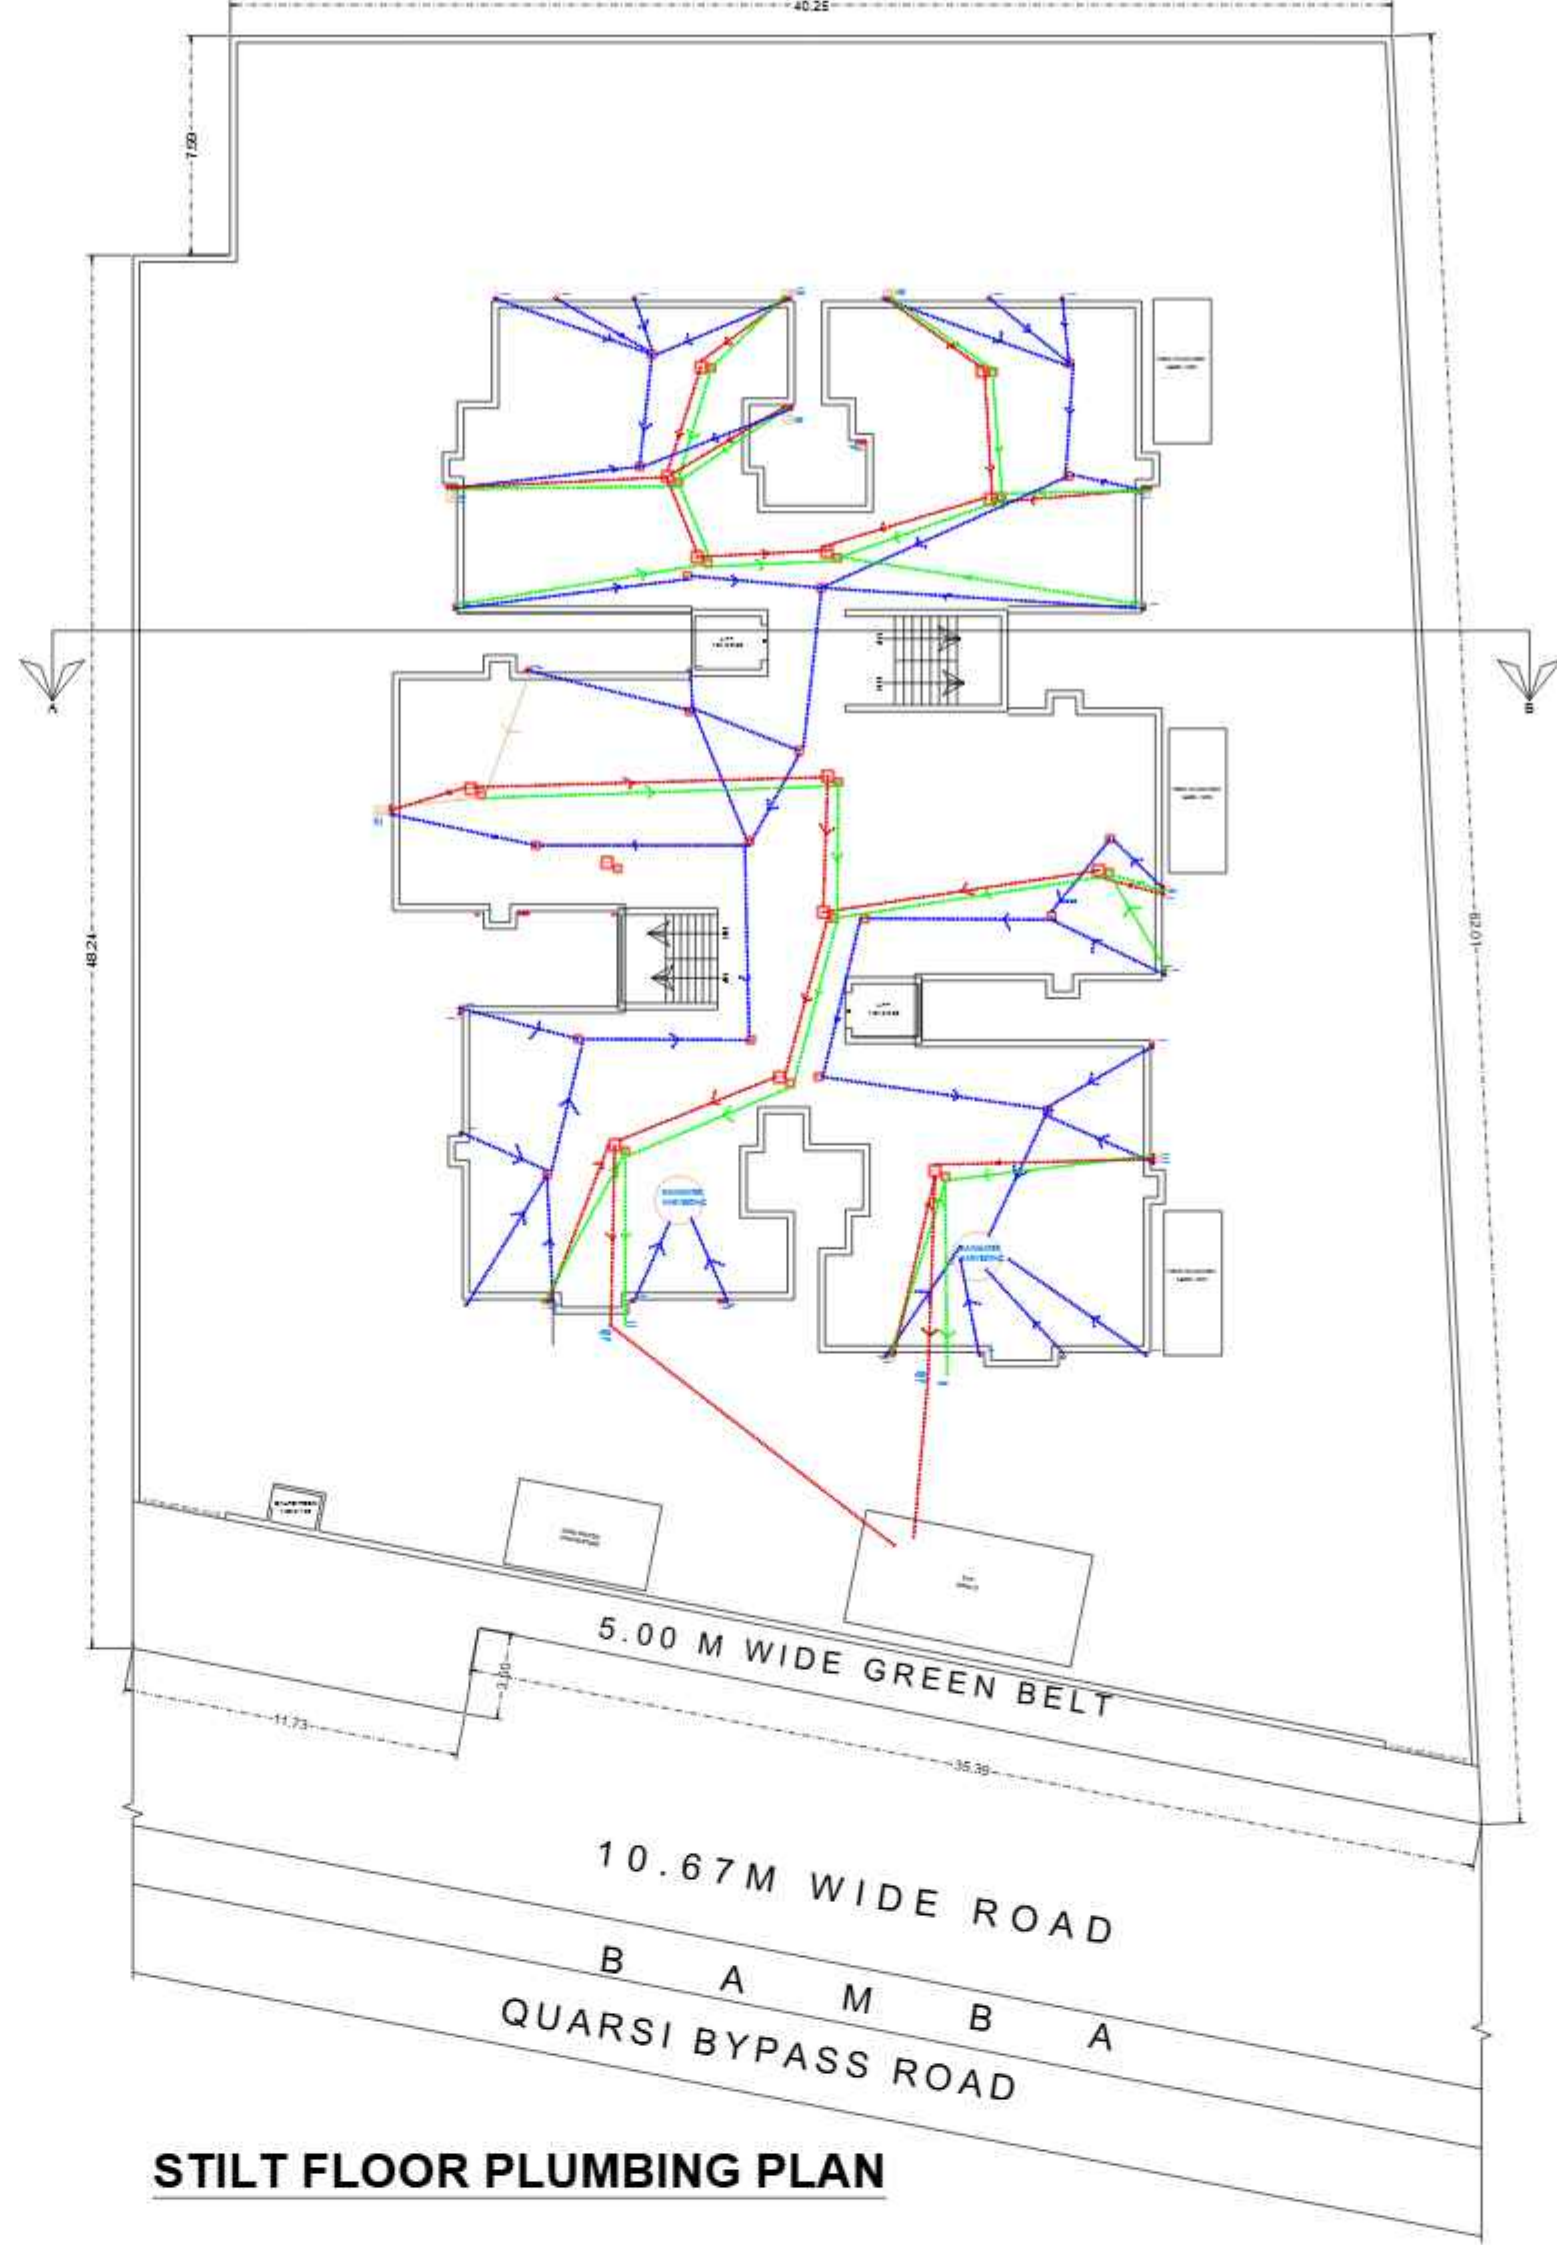

STILT FLOOR PLUMBING PLAN

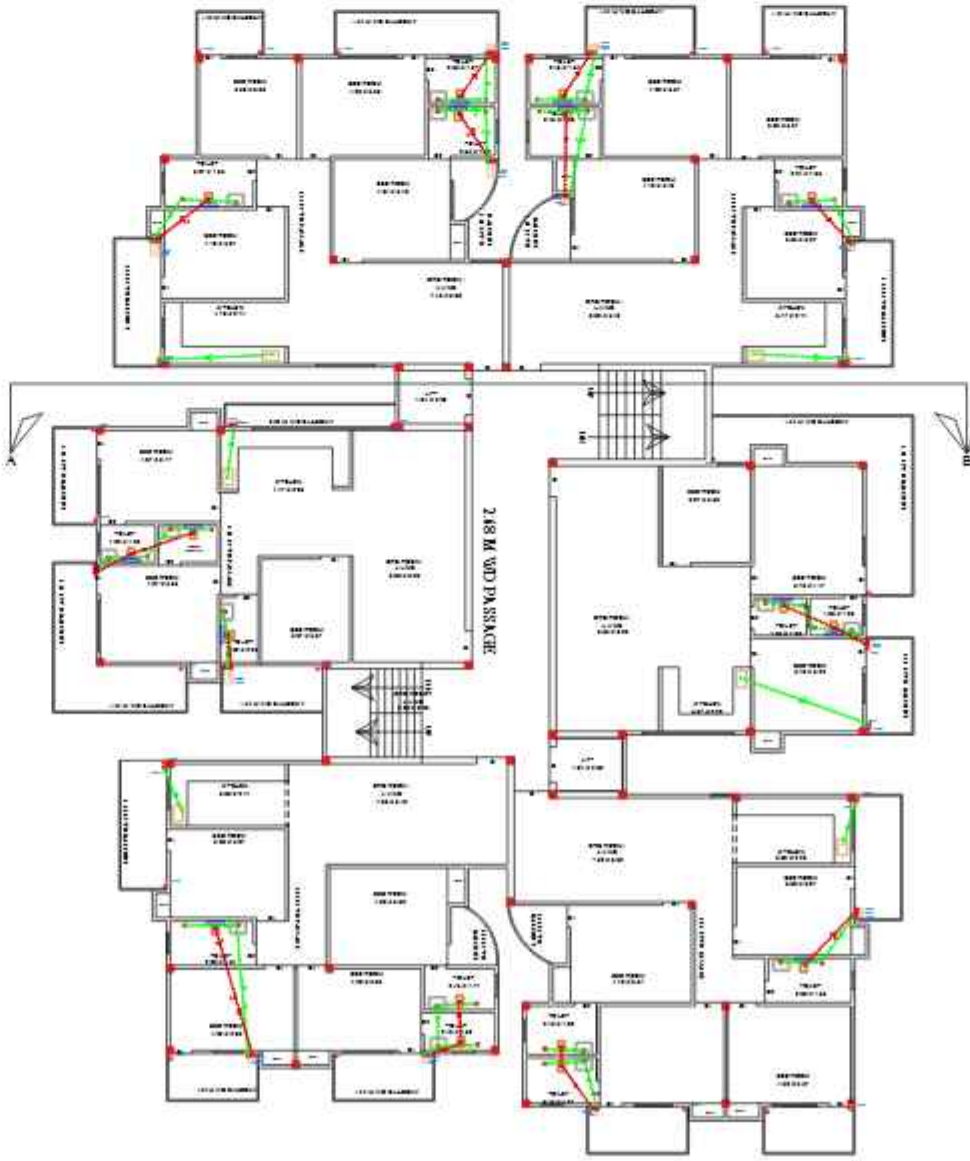

TYPICAL FLOOR PLUMBING PLAN - 1, 2, 3, 4, 5,

DRG. TITLE: ELECTRICAL LEGENDS			
S.NO.	SYMBOL	DESCRIPTION	HEIGHT
1	[Symbol]	SWITCH BOARD	4'10"
2	[Symbol]	THIRD WAY SWITCH BOARD	X
3	[Symbol]	CEILING LIGHT	X
4	[Symbol]	TELEVISION	2'10"
5	[Symbol]	POWER POINT	2'10"
6	[Symbol]	PLUG POINT	2'10"
7	[Symbol]	TELEPHONE POINT	2'10"
8	[Symbol]	WALL LIGHT	8'10"
9	[Symbol]	CEILING FAN	X
10	[Symbol]	DELUXE FAN	X
11	[Symbol]	A.C. POINT	1'10"
12	[Symbol]	DISTRIBUTION BOARD	X
13	[Symbol]	DESIGN	X
14	[Symbol]	DRAINAGE SYSTEM	X
15	[Symbol]	WATER SUPPLY	7'10"
16	[Symbol]	WATER SUPPLY	X
17	[Symbol]	WATER SUPPLY	X

[Red Line]	SOIL WASTE PIPE
[Green Line]	WASTE WASTE PIPE
[Blue Line]	RAIN WATER PIPE

DRAWING FOR THE PROPOSED GROUP
HOUSING PROJECT MADHAVAS
EMPYREAN OF BUOYANT BUILDTECH
PVT.LTD. DIRECTOR VIJAY YADAV

SITE AT: PART OF DATA NO 404,RAJIV
NAGAR,ASADPUR QYAM,PER & TEH
KOIL,ALIGARH.

SCH. OF AREAS	
TOTAL PLOT AREA(AS PER SITE)	2594.10 SQM
GREEN BELT AREA	133.16 SQM
NET PLOT AREA	2460.94 SQM
BASEMENT COV. AREA	1398.63 SQM
STILT FLOOR COV. AREA	756.95 SQM
OPEN AREA	1703.99 SQM
FIRST FLOOR COV. AREA	756.95 SQM
SECOND FLOOR COV. AREA	756.95 SQM
THIRD FLOOR COV. AREA	756.95 SQM
FORTH FLOOR COV. AREA	756.95 SQM
FIFTH FLOOR COV. AREA	756.95 SQM
MUMTY COV. AREA	19.14 SQM
TOTAL COV. AREA	3803.89 SQM
GAURD ROOM AREA	2.83 SQM
G.F. COVERAGE AREA	30.75%
F.A.R.	2.46

SCH. OF OPENINGS		
	D/ W/ V	SIZE
DOORS	D	1.50 X 2.13
	D1	1.25 X 2.13
	D2	1.00 X 2.13
	D3	0.75 X 2.13
WINDOWS	W	2.50 X 1.80
	W1	2.25 X 1.80
	W2	2.00 X 1.80
VENTILATION	V	1.00 X 60

OWNER SIGN :-

NORTH DIRECTION



DESIGNER

Ar. SHAIKH FAISAL ALI
B. ARCH, M. ARCH
(BUILDING SERVICES)
CA/2015/72639