



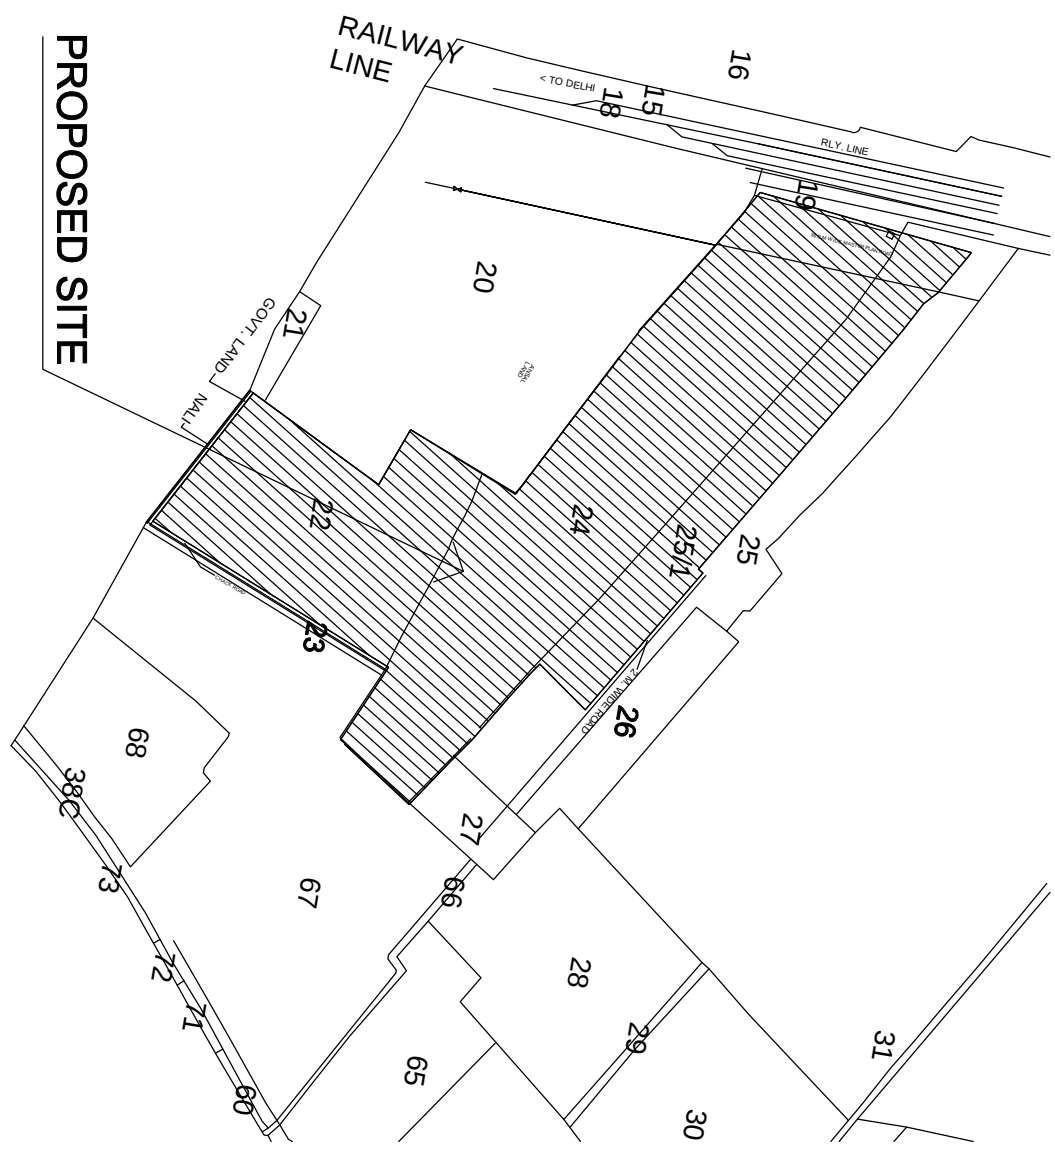


SAJIRA PLAN

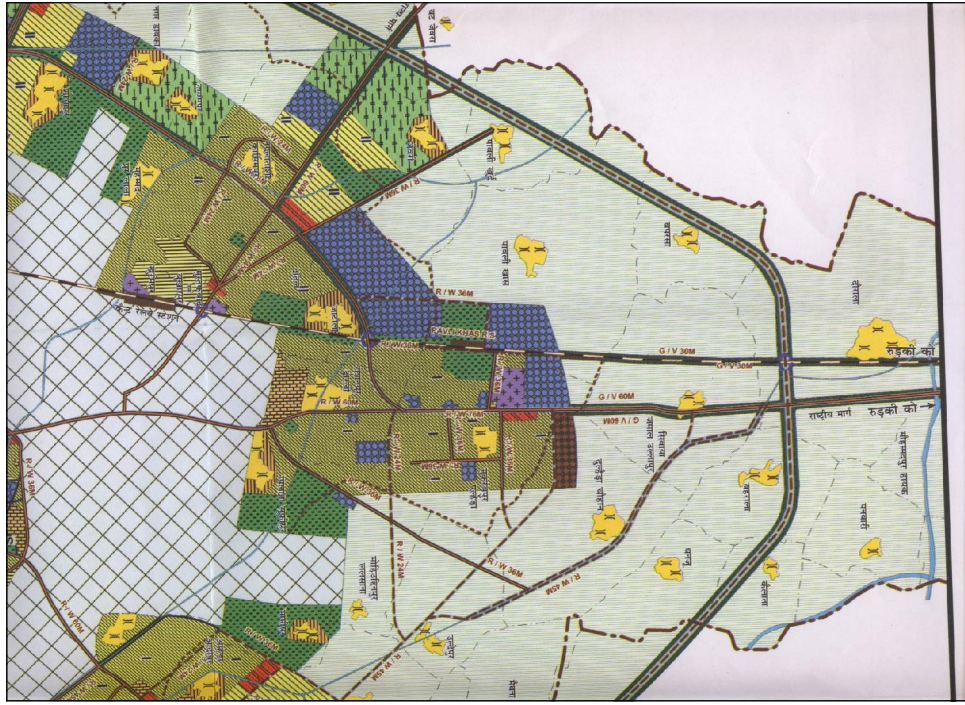

MASTER PLAN

LEGENDS:-	
	GARDEN HYDRANT
	WATER SUPPLY LINE (HPE)
	VALVE CHAMBER (600x600mm)
	HUME PIPE FOR ROAD CROSSING
	EXTERNAL FIRE HYDRANT (16 NOS)
	BOREWELL

ALREADY
SANCTIONED

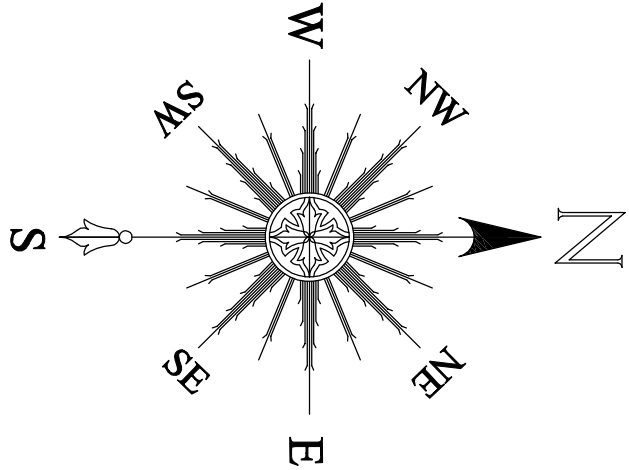

02	16.08.15	REVISION: LUG TANK ON TANK AND SLIDE VALVE
01	23.02.15	GFC
REV. NO.	DATE	DESCRIPTION

GOOD FOR CONSTRUCTION (PHASE-5)

PROPOSED RESIDENTIAL LAYOUT PLAN ON
KHASRA NOS. 22, 24 & 25/1 OF VILLAGE
MUGARRAPUR PALHERA ROORKEE ROAD, MEERUT
PHASE-5

DRG. TITLE

SITE PLAN FOR WATER SUPPLY LAYOUT (PHASE-5)

DRG. NO. SERV/02/MEERUT-A.T.P.-VMSRP-03

TITLE SITE PLAN FOR STORM WATER LAYOUT

DATE: 23.02.15 SCALE: 1:500

CHECKED BY: M.K. DATE: 20.01.15

DRG. NO. SERV/02/MEERUT-A.T.P.-VMSRP-02

MANOJ KUMAR SR. MANAGER PHE. (SERVICES)
PK SINGHAL VP (SERVICES)

OWNER

- M/S. SHRI SHIV ASSOCIATES.
- M/S. ANSAL HOUSING CONSTRUCTION LTD.