


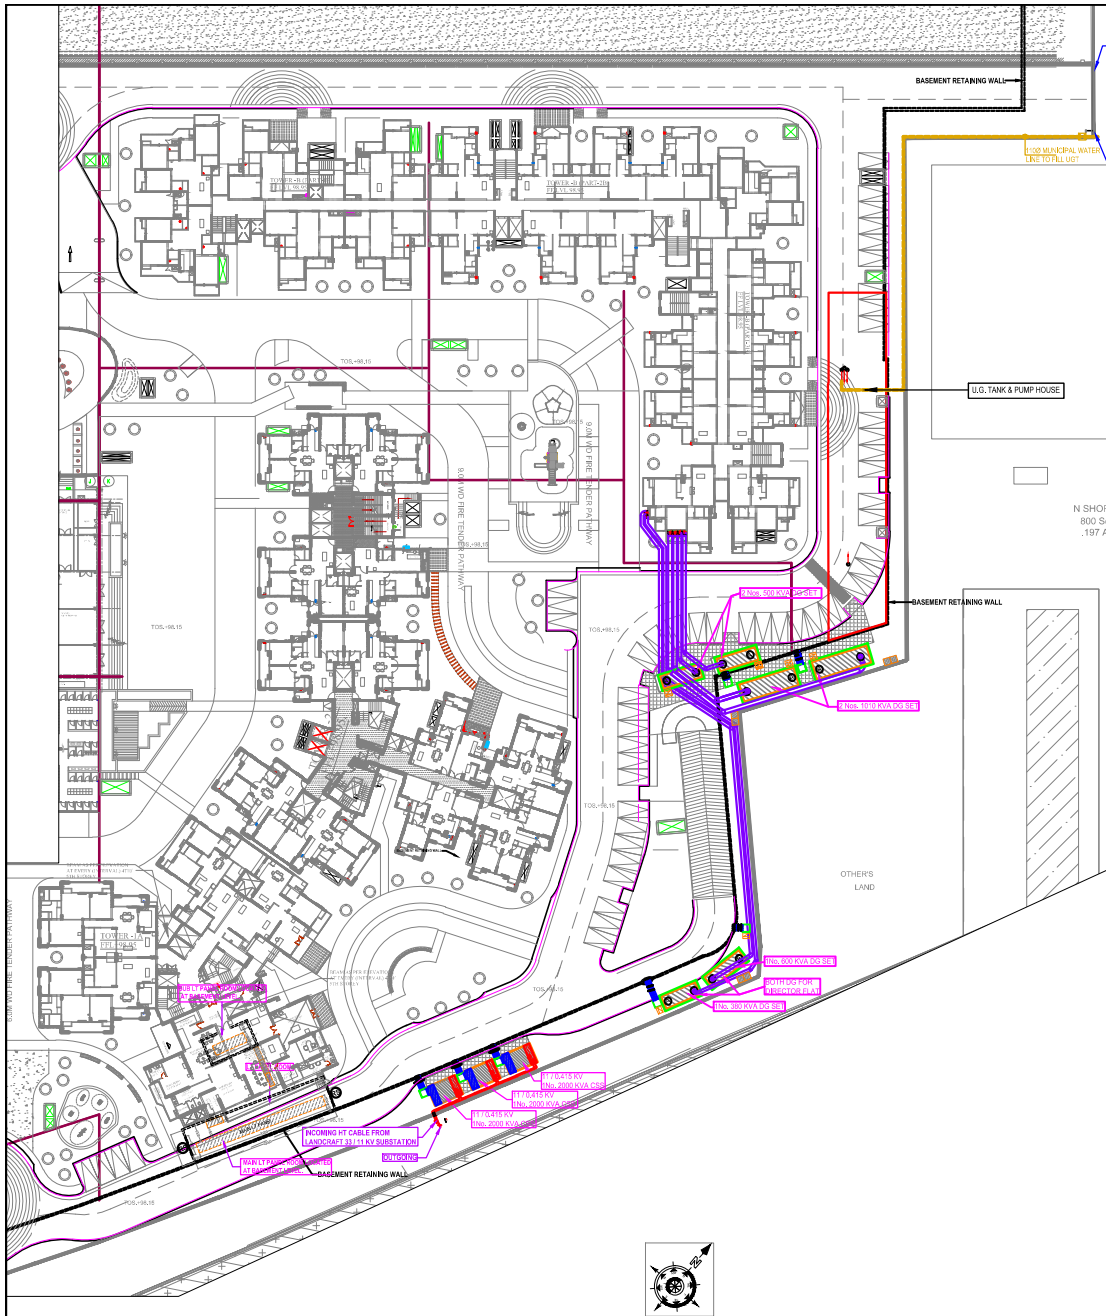

rev. no.	date	revision
R1	11.12.2017	TOWER-1A REVISED
R2	15.09.2015	GFC ISSUED.

project
"LANDSCAPE GOLF LINKS"
VILLAGE MEHRAULI, DIST. GHAZIABAD, U.P.

title
ELECTRICAL DRAWING (PHASE-02)

subtitle
**ELECTRICAL SETTING-OUT LAYOUT
(AT SITE PLAN)**

drawing released for
☐ APPROVAL ☐ SUBMISSION
☐ TENDER COPY ☒ CONSTRUCTION

des. no. GU/ELEC/EXT-81 drawn by Chandrapal

scale 1 : 375 @ A1 designed by Atous Ur Rehman

date Sep. 2015 checked by Anand Hasella

architects
Space Designers International Architects Pvt. Ltd.
 B-34, Sector 47, Noida 201301 (U.P.)
 Ph: 0120-2484445, 4444444, 4444444, 4444444, 4444444
 e-mail : spacedes@gmail.com, www.spacedes.com

services consultant
Consummate Engineering Services (P) Ltd.
 Noida Office : B-47, Sector 47, Noida - 201301
 Tel : 0120-4420001 (24 Lines)
 Lko Office : R-006, Rohas Plumeria, Gomti Nagar, Lucknow
 e-mail : mail@cesp.in, website : www.cesp.in