


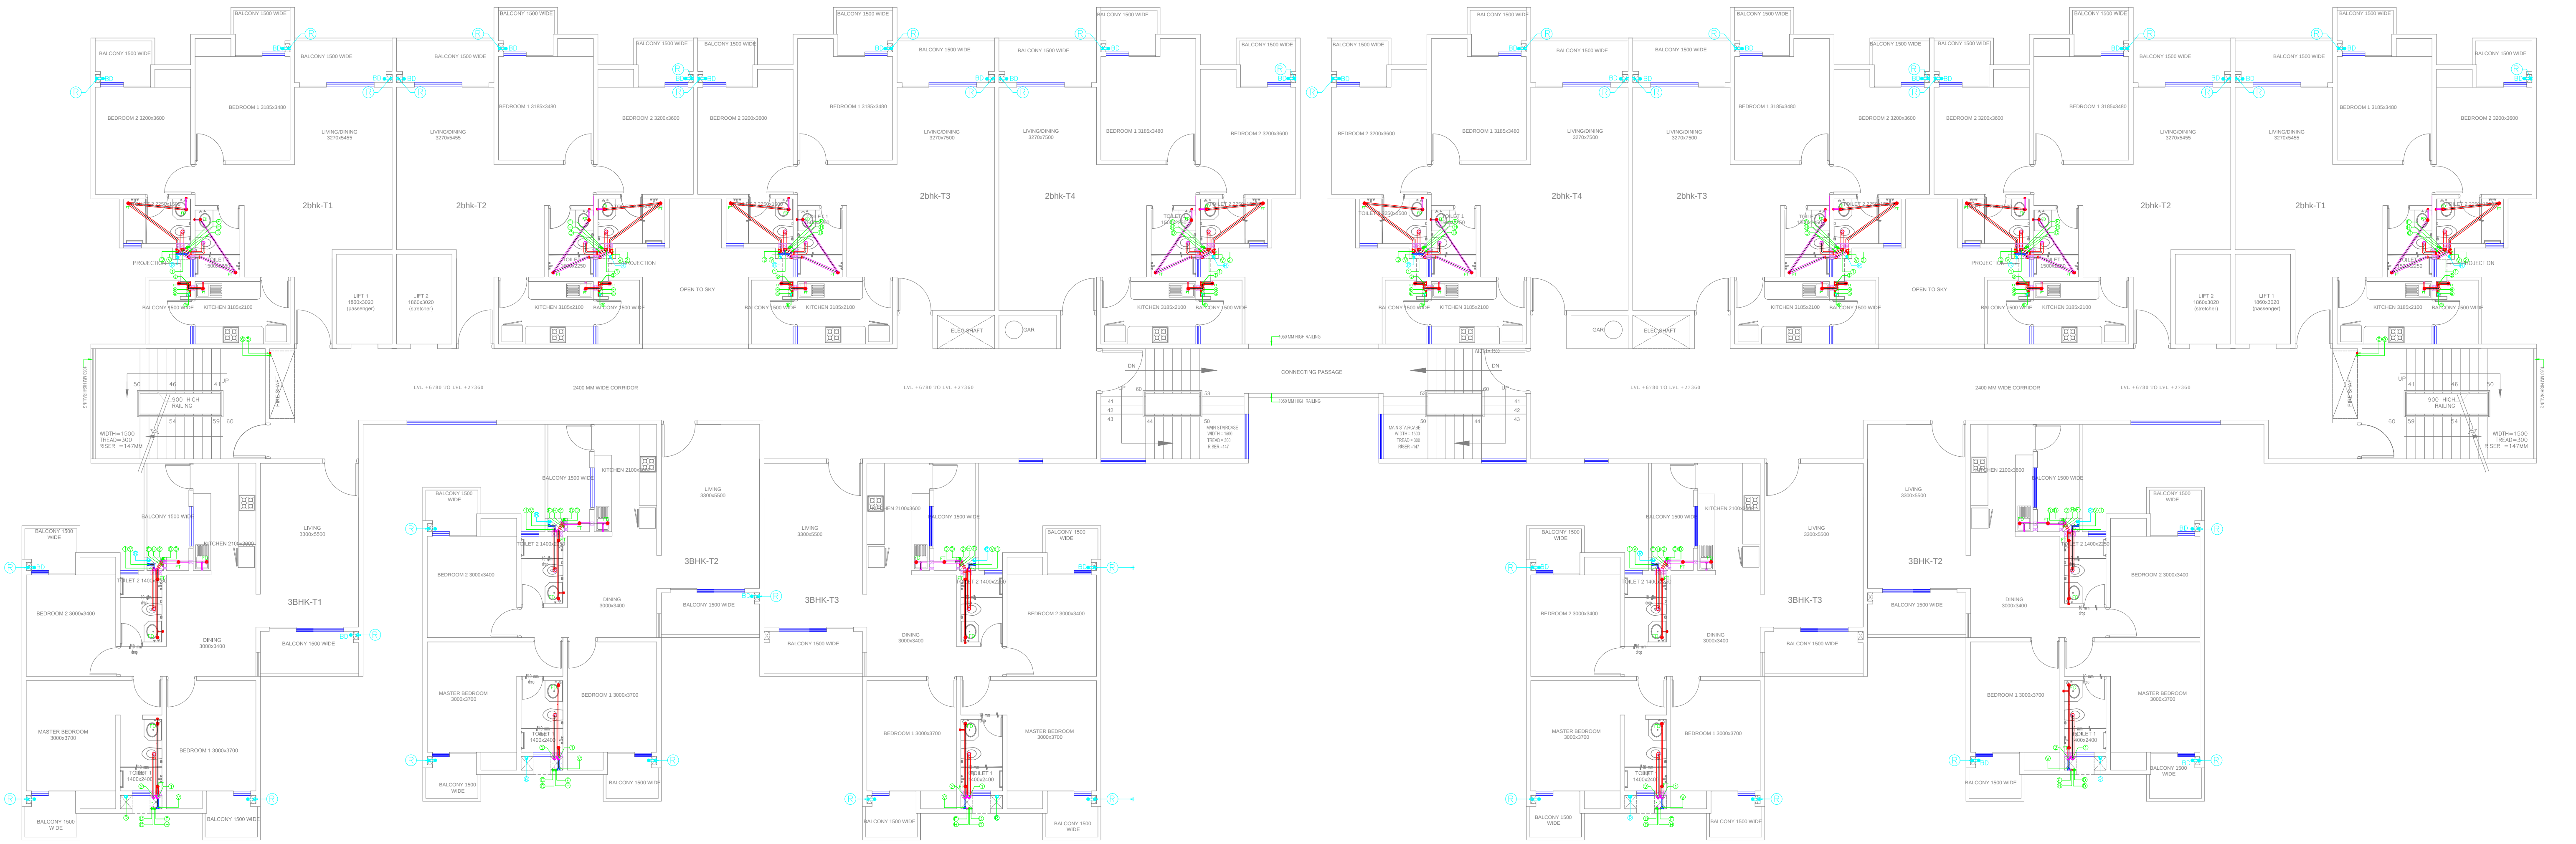


LEGEND

(R)	100Ø RAIN WATER
(V)	75Ø ANTI-SYPHONAGE VENT PIPE
FT	FLOOR TRAP
FD	FLOOR DRAIN
BD	BALCONY DRAIN

LEGEND

(1)	100Ø SOIL PIPE
(2)	100Ø WASTE PIPE
(D)	DOMESTIC WATER DOWN TAKE
(H)	SOLAR HOT WATER DOWN TAKE
(F)	FLUSHING WATER DOWN TAKE

Revision	DATE	DESCRIPTION	BY	CHECKED	APPROVED	PROJECT ENGINEER
ENVIROCON ENGINEERING SERVICES MEP CONSULTANT MEP CONSULTING ENGINEERS 225, Krishna Apartments, D-Block, Vikaspuri New Delhi - 110018 Ph. No : 011-45506669/9818007611 E-Mail : envirocon23@gmail.com						
STRUCTURAL CONSULTANT ACECON ENGINEERS A-289, L.G.F, SHIVALIK, MALVIYA NAGAR N. DELHI-17 TEL. + 91-11-46089284.5.6, FAX- +91-11-46089287 E-Mail - ace@acecon.in, URL: www.acecon.in						
ARCH CONSULTANT: DESIGN COLLABORATIVE CONSULTING ENGINEERS, PLANNERS, PROJECT MANAGERS (An Integrated Real Estate an Infrastructure Consultant) 512, Aggarwal Prestige Mall, Near MDR, Plot No.-2, Road 44, Pitampura, New Delhi - 110034 EMAIL: designcollaborativeconsulting@gmail.com						
TITLE: PLUMBING LAYOUT - TOWER 16-17 & 17-18						
DRAWING STATUS: ☐ FOR INFORMATION ☐ ADVANCE COPY ☐ GFC						
DRAWING NO. DCC/P/DM/CH-1B/2019/PL-01						REV
DRAWN BY		CHECKED BY		SCALE		

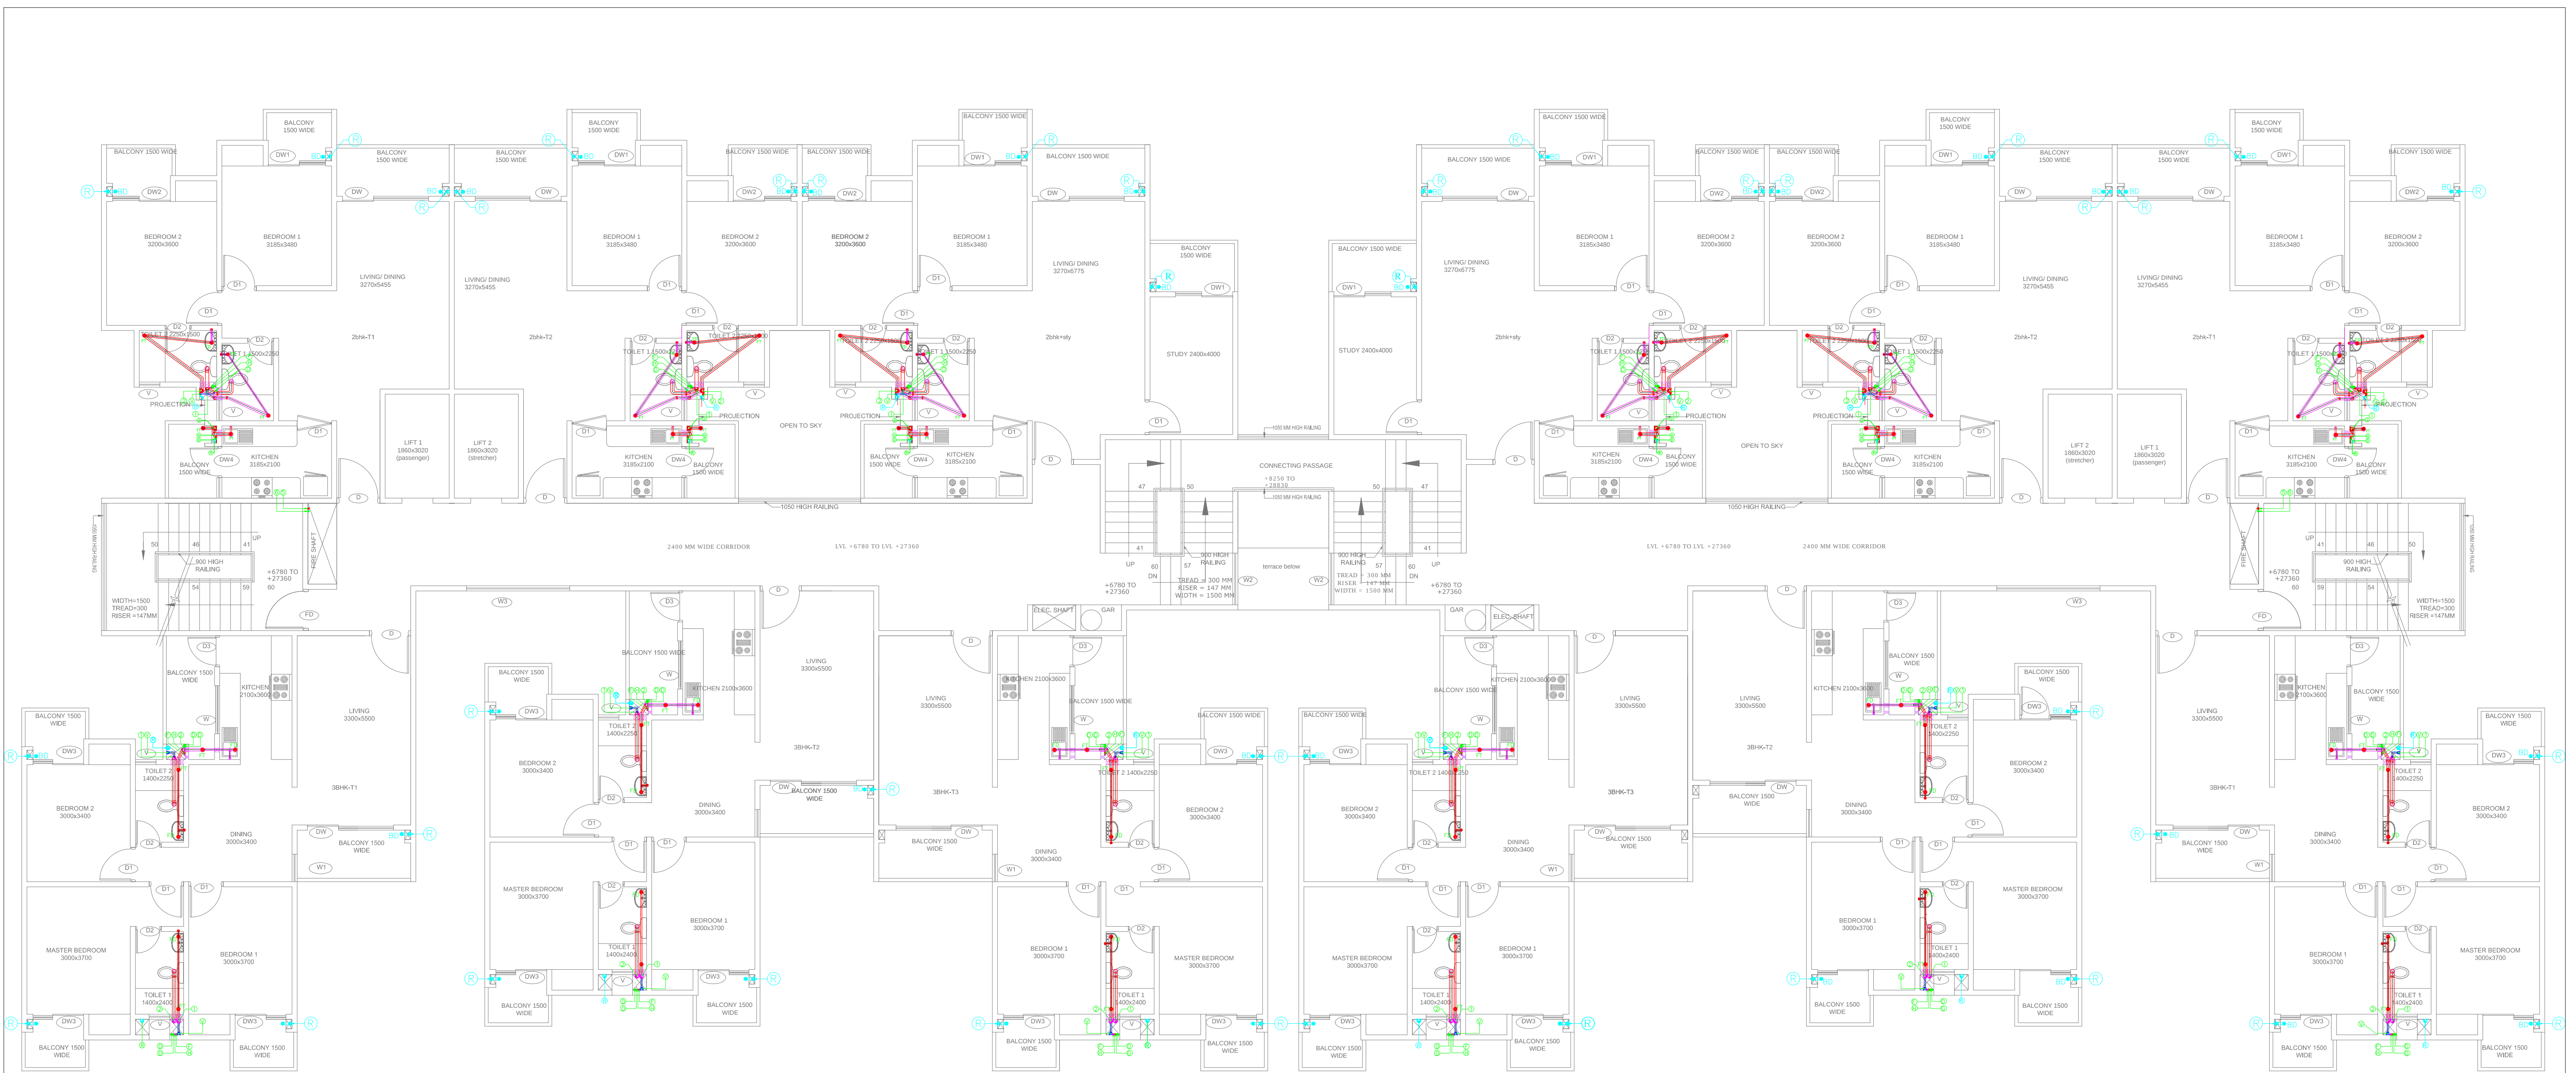

TYPICAL FLOOR PLAN - PLUMBING LAYOUT
(TOWER 19 & TOWER 20)

LEGEND	
(R)	100ø RAIN WATER
(V)	75ø ANTI-SYPHONAGE VENT PIPE
FT	FLOOR TRAP
FD	FLOOR DRAIN
BD	BALCONY DRAIN

LEGEND	
①	100ø SOIL PIPE
②	100ø WASTE PIPE
(D)	DOMESTIC WATER DOWN TAKE
(H)	SOLAR HOT WATER DOWN TAKE
(F)	FLUSHING WATER DOWN TAKE

Revision	DATE	DESCRIPTION	BY	CHECKED	APPROVED	PROJECT ENGINEER
ENVIROCON ENGINEERING SERVICES MEP CONSULTANTS 225, Krishna Apartments, D-Block, Vikasuri New Delhi - 110018 Ph. No : 011-45506669/9818007611 E-Mail : envirocon23@gmail.com						
STRUCTURAL CONSULTANT ACECON ENGINEERS A-289, L.G.F, SHIVALIK, MALVIYA NAGAR N. DELHI -17 TEL. + 91-11-46089284,5,6, FAX- +91-11-46089287 E-Mail - ace@acecon.in, URL: www.acecon.in						
ARCHITECTURAL CONSULTANT DESIGN COLLABORATIVE CONSULTING ENGINEERS, PLANNERS, PROJECT MANAGERS (An Integrated Real Estate an Infrastructure Consultant) 512, Aggarwal Prestige Mall, Near MDR, Plot No.-2, Road 44, Pitampura, New Delhi - 110034 EMAIL: designcollaborativeconsulting@gmail.com						
TITLE: PLUMBING LAYOUT - TOWER 19 & 20						
DRAWING STATUS: ☐ FOR INFORMATION ☐ ADVANCE COPY ☐ GFC						
DRAWING NO. DCC/P/DM/18/2019/PL-01						REV
DRAWN BY CHECKED BY						SCALE