


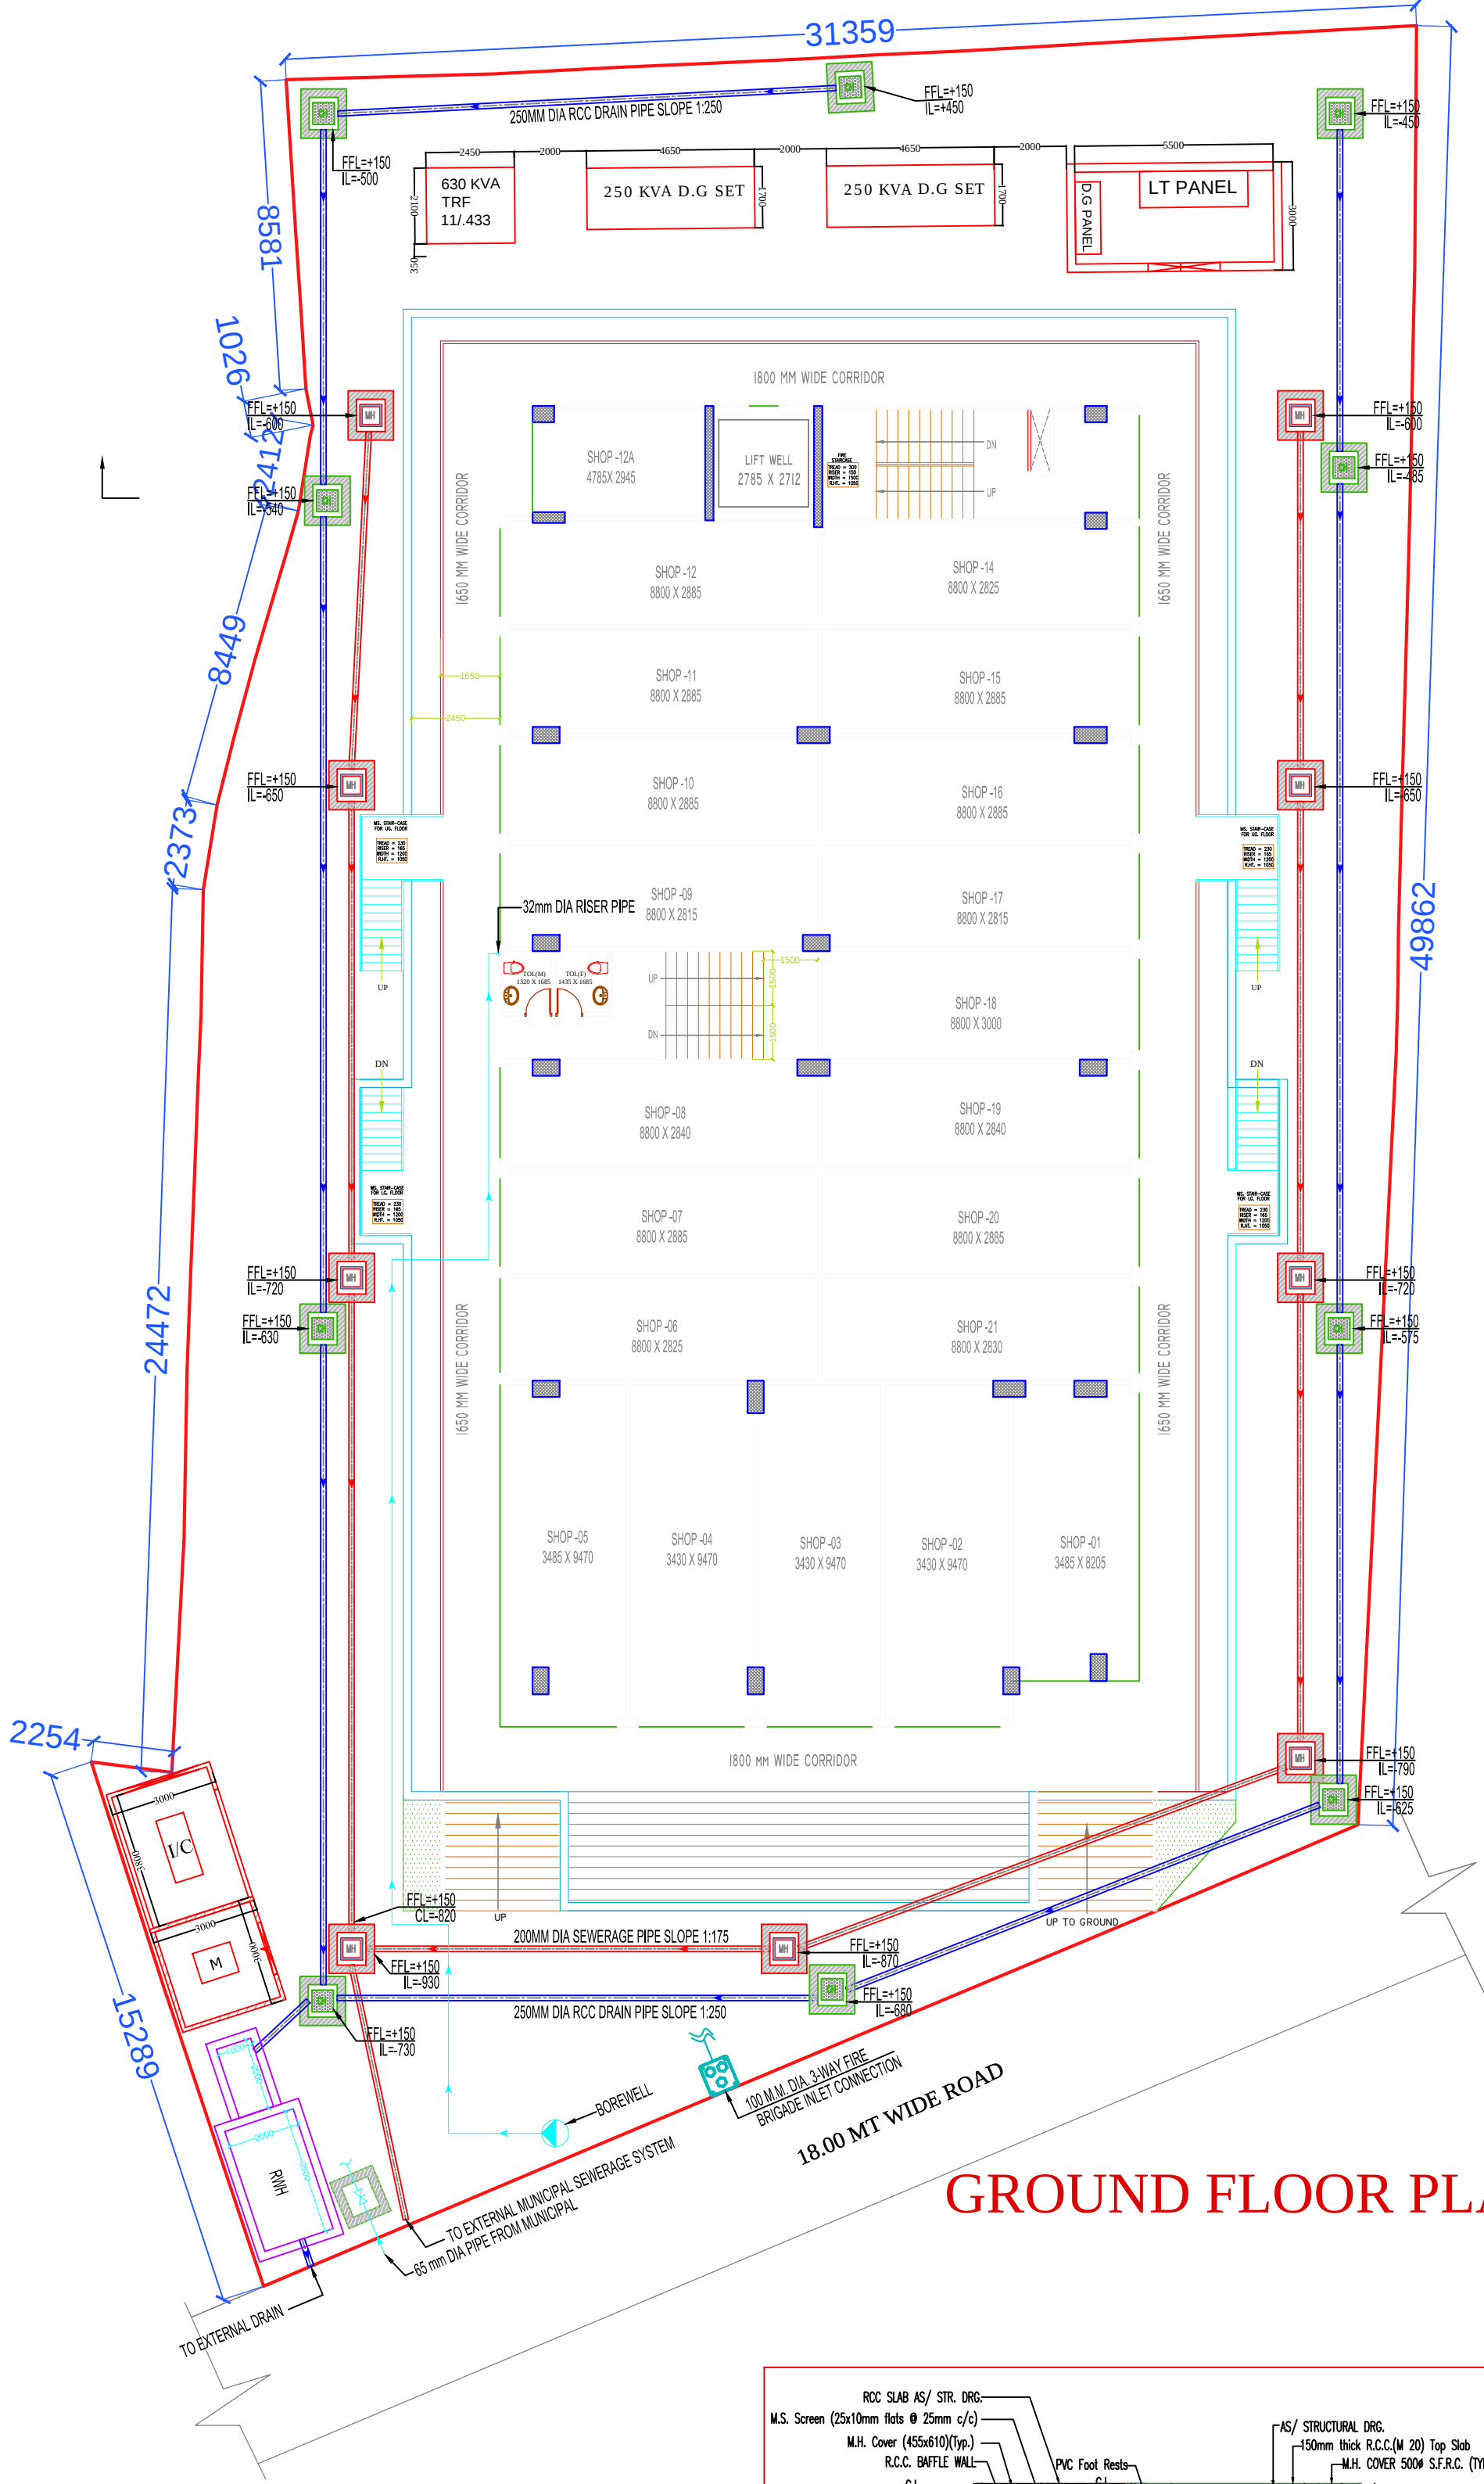
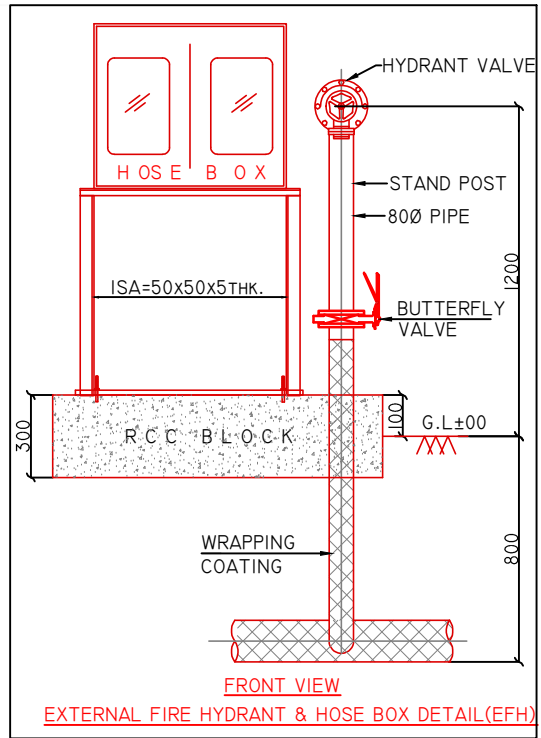


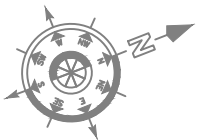

GROUND FLOOR PLAN

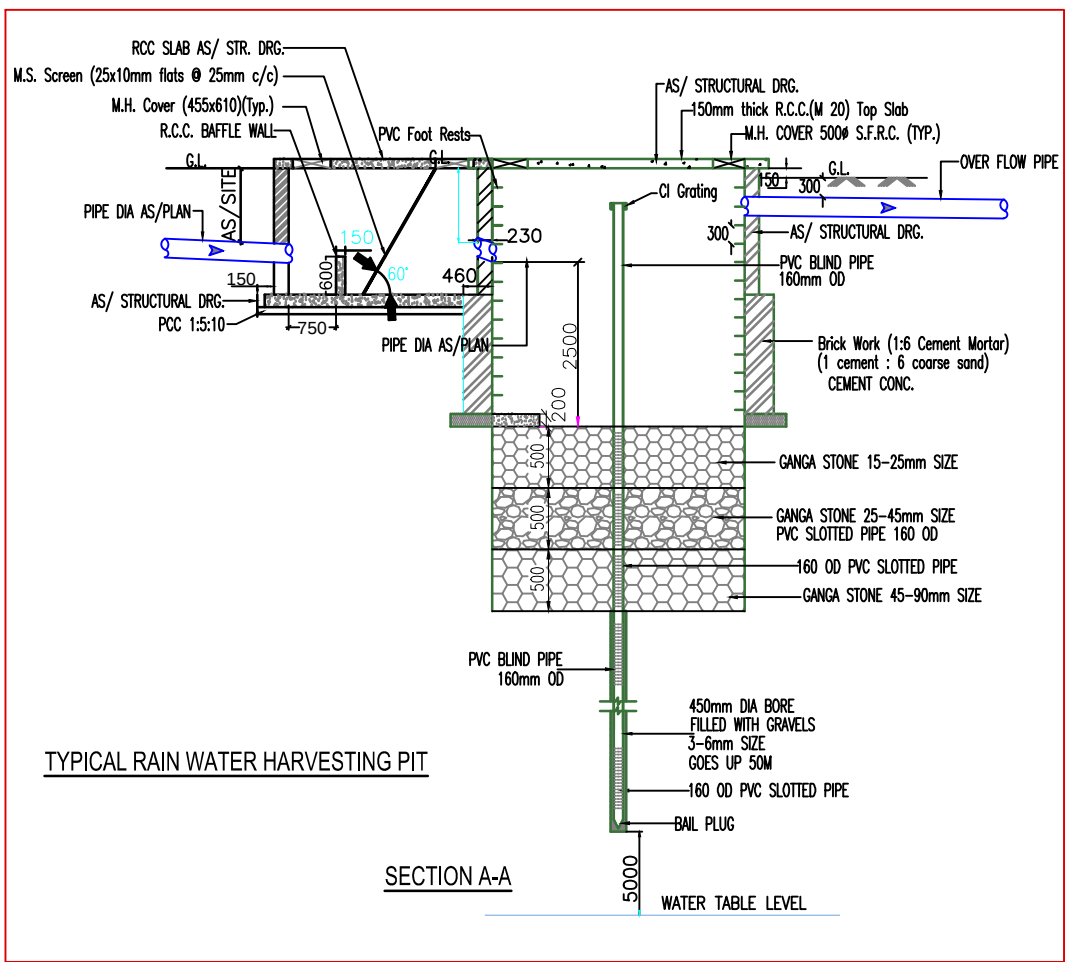

S.NO.	LEGEND:-	
1.	EXTERNAL DRAINAGE PIPE	
2.	EXTERNAL SEWERAGE PIPE	
3.	MANHOLE SIZE 800 X 0900MM DRAINAGE	
4.	MANHOLE SIZE 800 X 0900MM SEWERAGE	
5.	RECHARGE WELL	

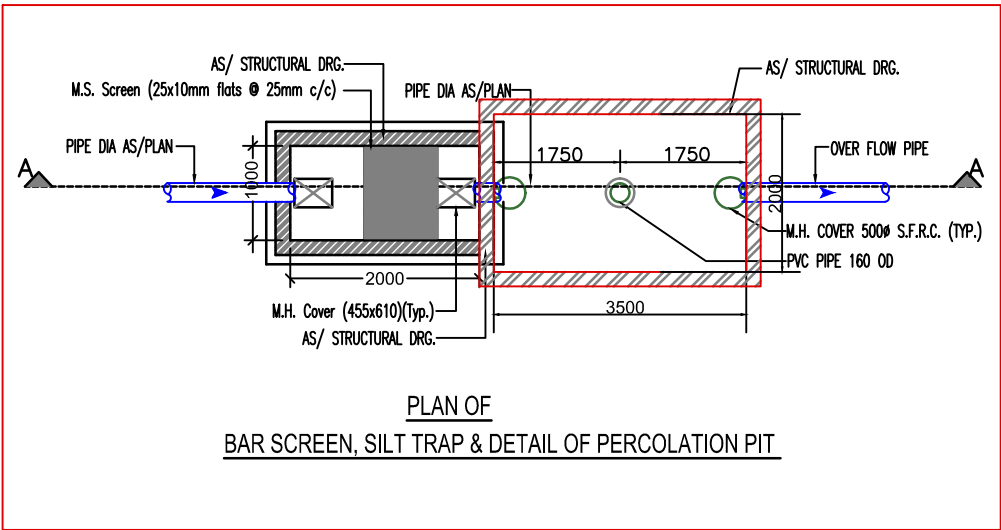

PROJECT - PROPOSED COMMERCIAL AT PLOT NO.- C-1, AVANTIKA VILLAGE HARSAON GHAZIABAD (U.P)				
OWNER - FOR M/s. GHAZIABAD INFRAGOAL PVT. LTD.				
DRAWING TITLE :- EXTERNAL PLAN				
OWNER SIGN		ARCHITECT SIGN		
ARCHITECTS & PLANNERS:- SINGLA ARCHITECTS & ASSOCIATES EROS MARKET PLACE, PLOT NO-02, SHOP - 87 1ST FLOOR SHAKTI KHAND - 2, INDIRAPURAM, GHAZIABAD (U.P.) Mob: 99199848 e-mail: singla33@gmail.com				
MEP Consultant:- WeDESIGN Consultants "Engineered to perfection" Email: vedesignconsultants@gmail.com Mob: 9992288516, 9992288507, 9882244495				
DESIGN BY:- VIBHOR	CHECKED BY:- DINESH	SCALE:- NTS	DATE:-	DRG. NO.:- 04