


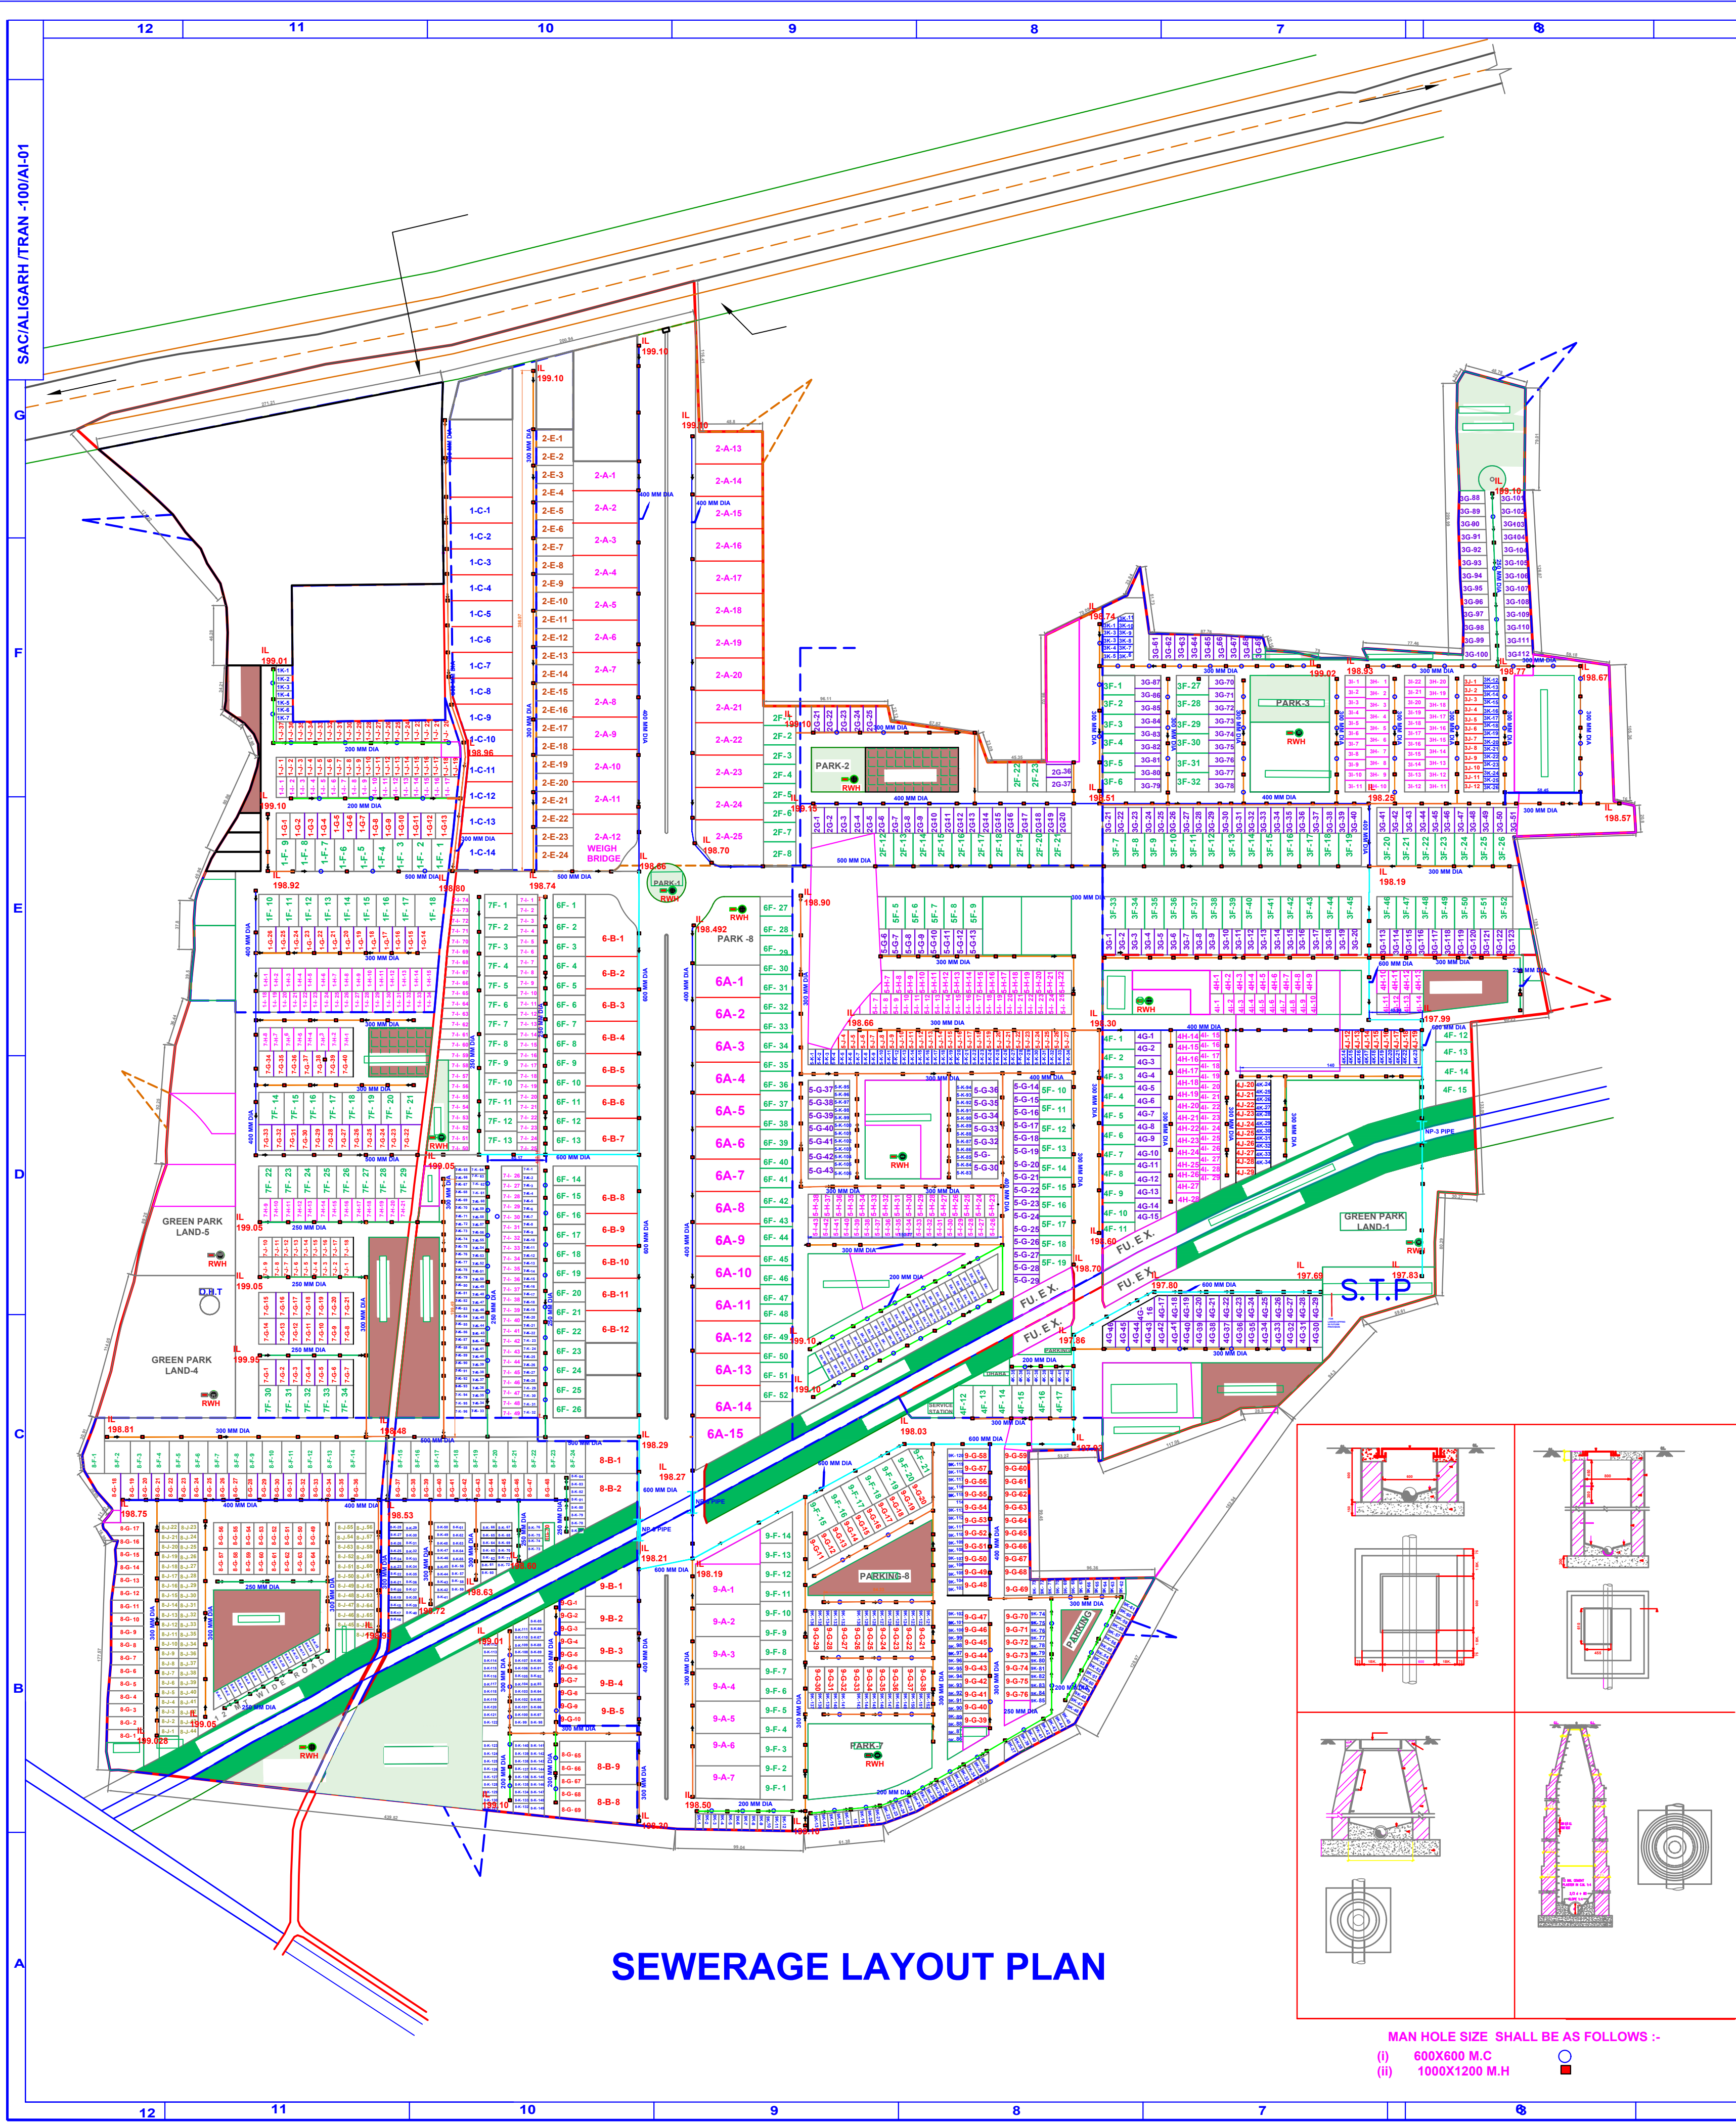

REVISED LAYOUT PLAN OF
TRANSPORT NAGAR SCHEME ALIGARH.

SITE AT :-
LOHSARA BISAWAN, KHAIR ROAD, ALIGARH U.P.

NOTES -

THIS DRAWING IS CONFIDENTIAL AND SHOULD NOT
BE DISCLOSED, COPIED OR LENT TO A THIRD PARTY
WITHOUT WRITTEN CONSENT OF
SKYLINE ARCHITECTURAL CONSULTANTS
EXCEPT THE SYSTEM FOR WHICH THE
DRAWING IS MEANT.

DO NOT SCALE DRAWING ONLY WRITTEN DIMENSIONS ARE TO BE FOLLOWED

SYMBOL	PLUMBING LEGEND:- DESCRIPTION
STP	SEWAGE TREATMENT PLANT
M.H.	MASONAR CHAMBER-342
M.H.	SEWER MAN HOLE- 746 NOS
	SEWAGE LINE 200 MM DIA-1318 MTR
	SEWAGE LINE 250 MM DIA-1850 MTR
	SEWAGE LINE 300MM DIA- 8521 MTR
	SEWAGE LINE 400 MM DIA-2010 MTR
	SEWAGE LINE 500 MM DIA-1115 MTR
	SEWAGE LINE 600 MM DIA-1541 MTR
	O.H.T
IL	INVERT LEVEL
	CROSSING RCC HUME PIPE NP-3
	CULVERT
B.M	REFERENCE LEVEL 200.00 LVL

NOTES:-
RCC HUME PIPE NP-2 FOR EXTERNAL SEWER
RCC HUME PIPE NP-3 FOR CROSSING ROAD
SLOPE 1: 400 FOR 200 MM DIA PIPE
SLOPE 1:500 FOR 250 MM DIA PIPE
SLOPE 1:600 FOR 300 MM DIA PIPE
SLOPE 1:800 FOR 400 MM DIA PIPE
SLOPE 1:1000 FOR 500 MM DIA PIPE
SLOPE 1:1200 FOR 600 MM DIA PIPE
REFERENCE LEVEL 200.00 LVL

REVISIONS			
SL. NO.	DESCRIPTION	BY	DATE

CLIENT
GOVERNMENT OF UTTAR PRADESH

PROJECT
REVISED LAYOUT PLAN OF
TRANSPORT NAGAR, ALIGARH

PROJECT MANAGEMENT CONSULTANT
ALIGARH DEVELOPMENT AUTHORITY, ALIGARH

ARCHITECT

Skyline
architectural consultant
architects, engineers, planner
landscape design, & value
engineering

Office :- 11th & 12th floor Iqbal Vardan commercial complex at patrakar puram crossing
g o m t i n a g a r , l u c k n o w
Dial :- +91-522-2393123, 2394123, 4044123
E mail I d :- skyline @ u s a h c c . c o m
Asso. office:- 516A & 516B, 5TH floor world trade center near hotel lalit , barbar road,
new delhi, 110001, Dial - 011-43575123, 43575124

ARCHITECTS :- SANJAY & VIJAY SINHA

TITLE	SCALE -	DATE
DRAWING NO. SAC/ALIGARH /TRAN -100/SWG-01	PREP. BY	
	CHKD. BY	
	APPRD. BY	
SHEET NO.	4	REV.