


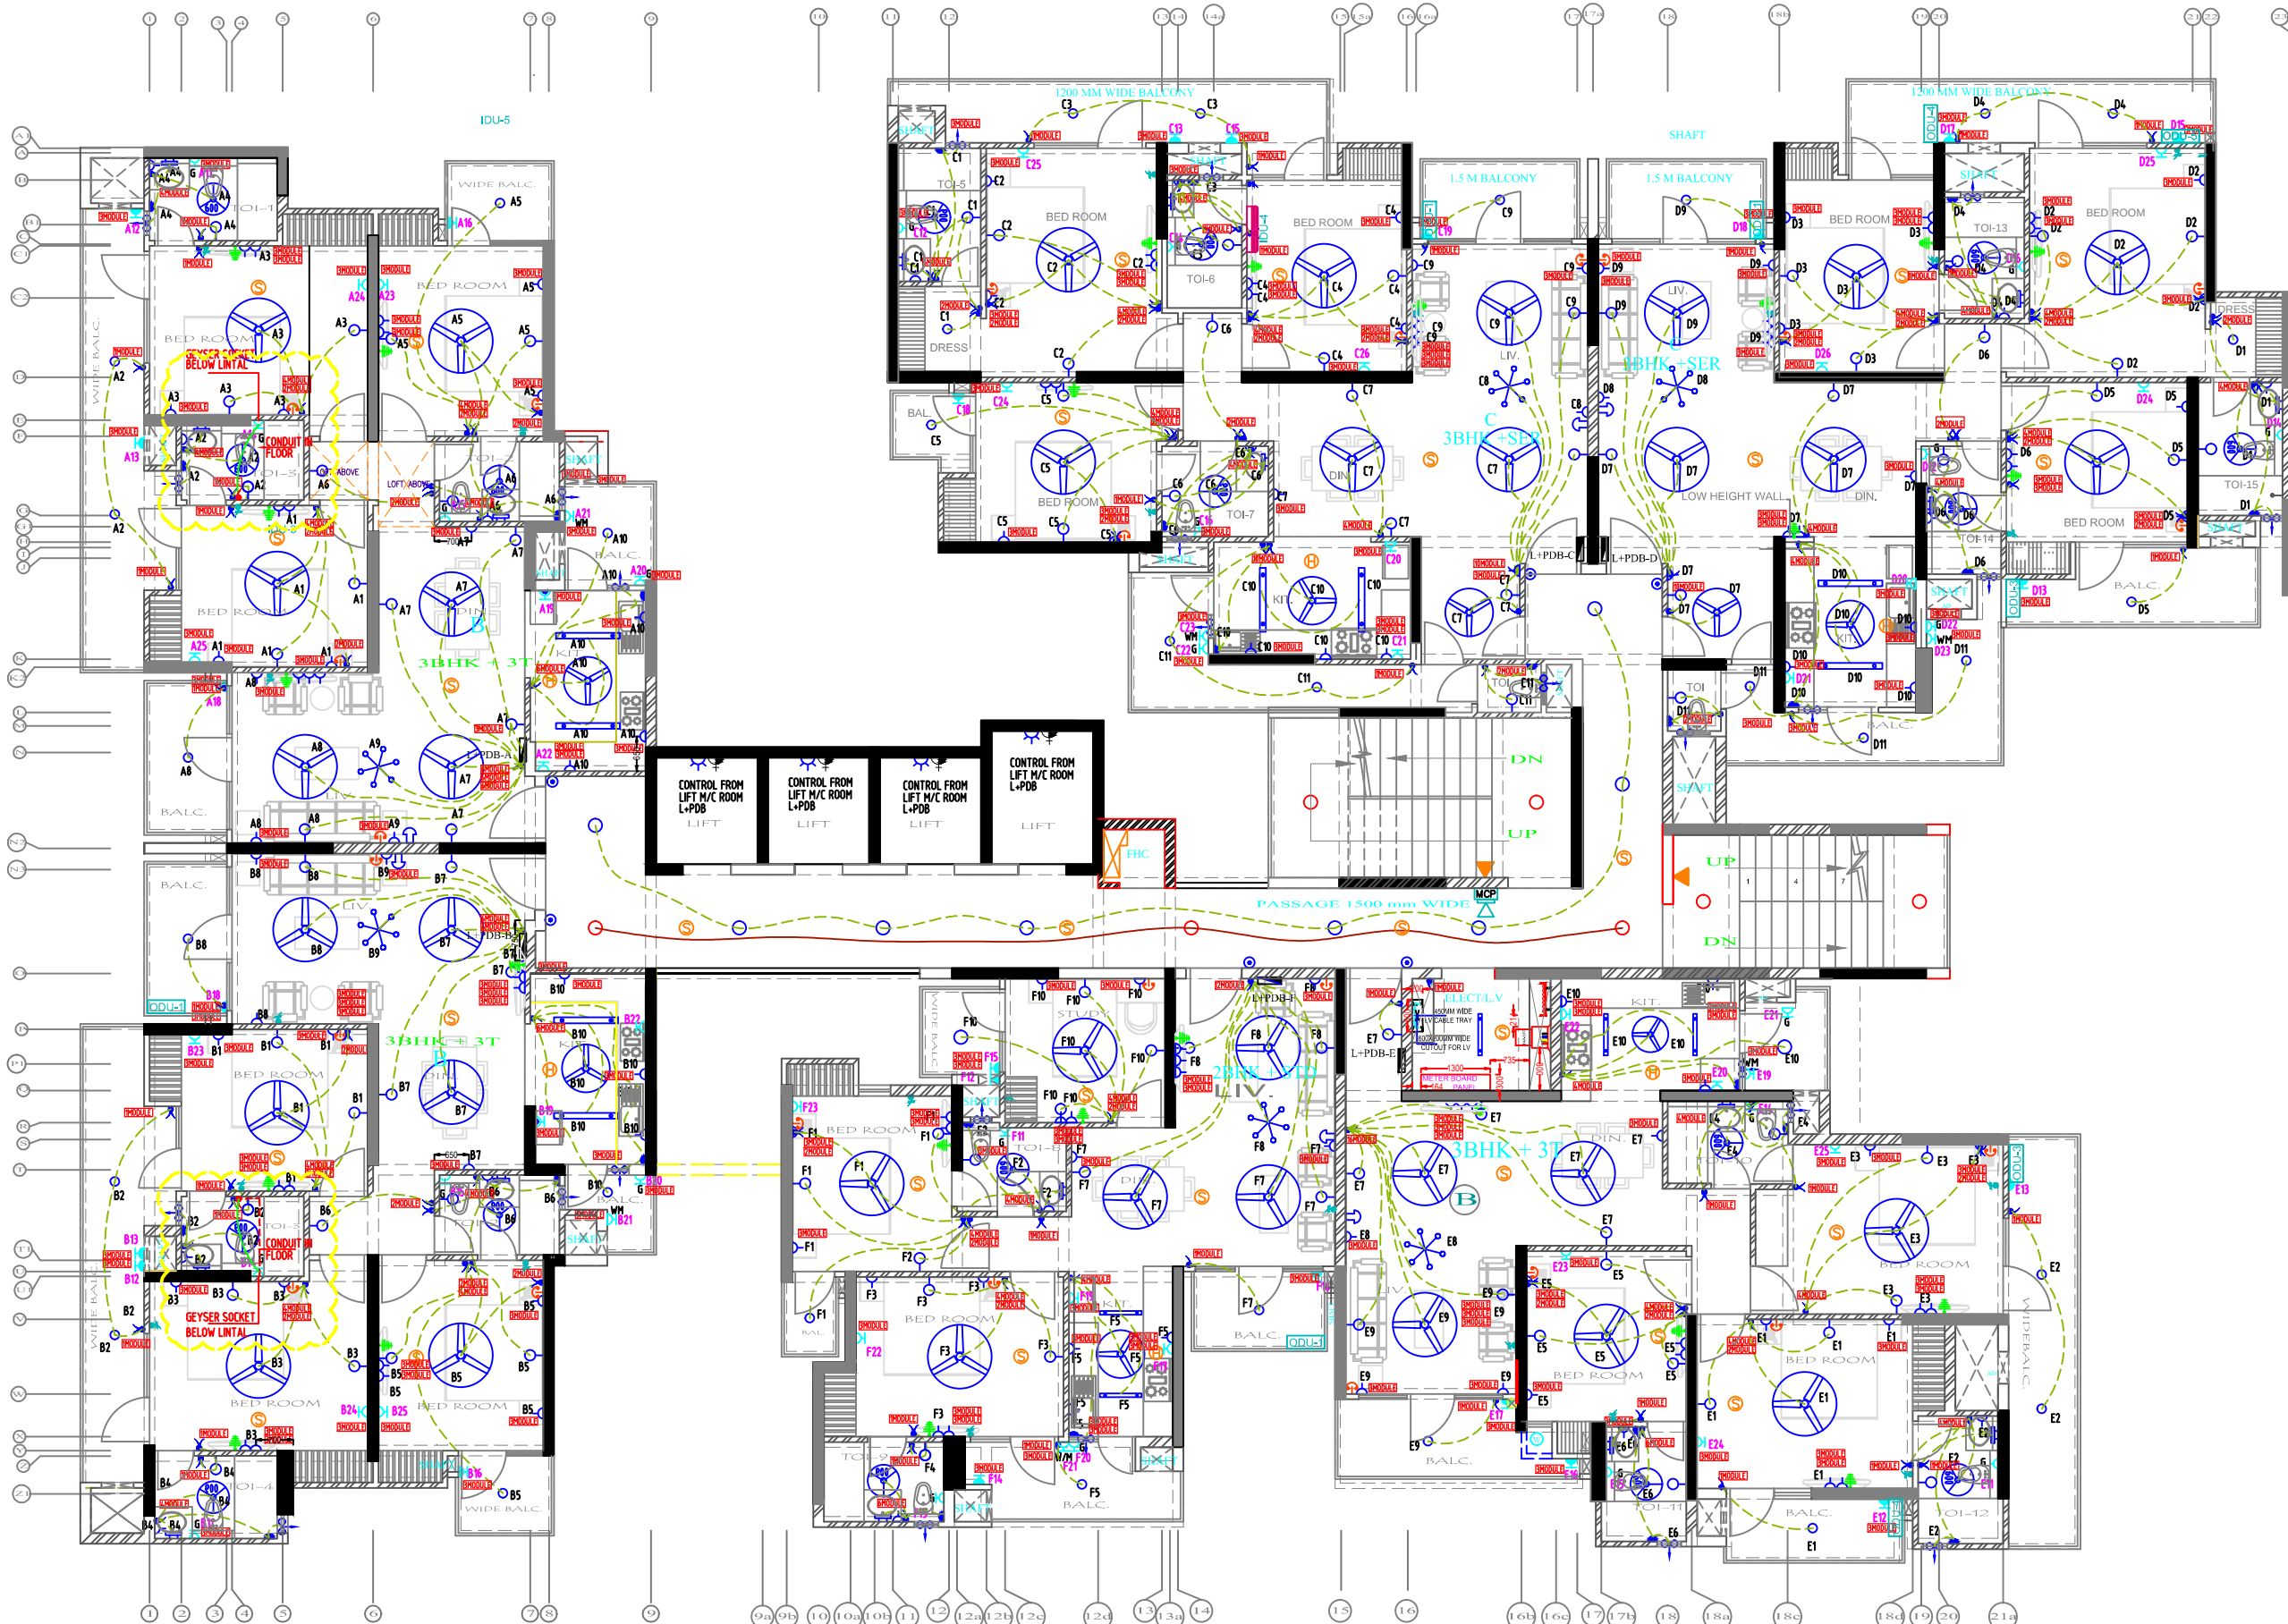

ALL BED SIDE 6PIN LIGHT PLUG ,SWITCH BOARD & TELEPHONE MOUNTING HEIGHT 600MM FFL LEVEL.

LEGEND:-		HEIGHT
	1200mm SWEEP CEILING FAN	CEILING
	900mm SWEEP CEILING FAN	CEILING
	600mm SWEEP CEILING FAN	CEILING
	1x40W WALL FTL FITTING	2100MM
	CEILING LIGHT	CEILING
	CEILING LIGHT EMERGENCY	CEILING
	JUNCTION BOX	CEILING
	1x40W CEILING LIGHT	CEILING
	BRACKET LIGHT	2100MM
	BULK HEAD LIGHT	2100MM
	MIRROR LIGHT	2100MM
	EXHAUST FAN	2400MM
	POWER POINT (FOR AC)	450MM
	16A 6 PIN POWER PLUG	450MM
	16A 6 PIN POWER PLUG (FOR KITCHEN)	1050MM
	20A 3 PIN POWER PLUG (FOR GEYSER)	1700MM
	POWER PLUG (FOR WASHING MACHINE)	1050MM
	POWER PLUG (FOR TOILET WASHING MACHINE POINT)	1700MM
	16AMP SWITCH SOCKET	-
	6A 5 PIN LIGHT PLUG	450MM
	6A 5 PIN LIGHT PLUG (FOR KITCHEN)	1050MM
	6A 5 PIN LIGHT PLUG (FOR BRACKET/EXHAUST FAN)	2400MM
	TELEVISION OUTLET	1050MM
	TELEPHONE OUTLET	600MM
	BELL PUSH	1050MM
	BELL BUZZER	2400MM
	AC STARTER SWITCH	1050MM
	CONTROL SWITCH	1050MM
	TWO WAY CONTROL SWITCH	1050MM
	DISTRIBUTION BOARD	1200MM
	INDOOR UNIT	2100MM
	OUTDOOR UNIT	
	16A SWITCH SOCKET FOR CHIMNEY	1050MM
	POWER PLUG	1700MM

4	08-04-16	JOSHI	AS PER CLIENT COMMENTS
3	19-11-14	JOSHI	SERVIENT ROOM REMOVED
2	29-09-14	JOSHI	AS PER ARCHITECTS COMMENT
1	21-11-13	JOSHI	KITCHEN POWER SOCKET SHIFT
REV.	DATE	NAME	DESCRIPTION

REVISION

MEP CONSULTANTS :-	
KKSC	
KISHOR KUMAR SERVICES CONSULTANTS	
007-PINNACLE TOWER, GH-7 AHINSA KHAND-2, INDRAPURAM GHAZIABAD, UP-201014	PHONE: +91 120 4132558 MOBILE: +91 9910487835 kksco101@gmail.com

CLIENT :
REAL ANCHOR PVT.LTD.

PROJECT :
PROPOSED APARTMENT FOR
M/S WORLD RESIDENCY
AT INDRAPURAM

DRAWING DATA		
SCALE	A1@50	REV.NO:
DATE	21-11-2013	4
CKD	PRASHANT	REV. DATE:08-04-16
DRN	JOSHI	

TITLE:-
TOWER-A
TYPICAL FLOOR PLAN

SUB TITLE:-
CONDUITING LAYOUT
FOR LIGHTING POINT

DRG. NO.
SNCP-LR-TY-EL/CONDUIT-02

ARCHITECTS: DIMENSIONS & DESIGNS architects,engineers,interior designer D-669, Chitranjan Park NEW DELHI-110019 (INDIA) PH: 011-26274473, 011-26274474		
---	--	--



LEGEND:-		HEIGHT
	1200mm SWEEP CEILING FAN	CEILING
	900mm SWEEP CEILING FAN	CEILING
	600mm SWEEP CEILING FAN	CEILING
	1x40W WALL FTL FITTING	2100MM
	1x9WATT CEILING LIGHT	CEILING
	1x9WATT CEILING LIGHT EMERGENCY	CEILING
	JUNCTION BOX	CEILING
	1x40W CEILING LIGHT	2100MM
	BRACKET LIGHT	2100MM
	BULK HEAD LIGHT	2100MM
	MIRROR LIGHT	2100MM
	EXHAUST FAN	2400MM
	POWER POINT (FOR AC)	450MM
	16A 6 PIN POWER PLUG	450MM
	16A 6 PIN POWER PLUG (FOR KITCHEN)	1050MM
	20A 3 PIN POWER PLUG (FOR GEYSER)	1700MM
	POWER PLUG (FOR WASHING MACHINE)	1050MM
	POWER PLUG (FOR TOILET WASHING MACHINE POINT)	1700MM
	6A 5 PIN LIGHT PLUG	450MM
	6A 5 PIN LIGHT PLUG (FOR KITCHEN)	1050MM
	16AMP SWITCH SOCKET	-
	6A 5 PIN LIGHT PLUG (FOR BRACKET/EXHAUST FAN)	2400MM
	TELEVISION OUTLET	1050MM
	TELEPHONE OUTLET	600MM
	BELL PUSH	1050MM
	BELL BUZZER	2400MM
	AC STARTER SWITCH	230MM
	1WAY SWITCH FOR FAN & LIGHT	1050MM
	TWO WAY SWITCH	1050MM
	DISTRIBUTION BOARD	1200MM
	INDOOR UNIT	2100MM
	OUTDOOR UNIT	
	16A SWITCH SOCKET FOR CHIMNEY	1050MM
	POWER PLUG	1700MM
	2x9WATT CEILING LIGHT	CEILING
	2x9WATT CEILING LIGHT EMERGENCY	CEILING

3	15-06-16	JOSHI	AS PER CLIENT COMMENTS
2	08-04-16	JOSHI	AS PER CLIENT COMMENTS
1	19-11-14	JOSHI	SERVIENT ROOM REMOVED
REV.	DATE	NAME	DESCRIPTION

REVISION

MEP CONSULTANTS :-
KKSC
KISHOR KUMAR SERVICES CONSULTANTS
007-PINNACLE TOWER, GH-7
AHINSA KHAND-2, INDRAPURAM
GHAZIABAD, UP-201014
PHONE: +91 120 4132568
MOBILE: +91 9910487835
kksco101@gmail.com

CLIENT :
REAL ANCHOR PVT.LTD.

PROJECT :
**PROPOSED APARTMENT FOR
M/S WORLD RESIDENCY
AT INDRAPURAM**

DRAWING DATA		
SCALE	A1@75	REV.NO:
DATE	02-12-2013	2
CKD	PRASHANT	REV. DATE-08-04-16
DRN	JOSHI	

TITLE:-
**TOWER-B
TYPICAL FLOOR PLAN**

SUB TITLE:-
CONDUITING LAYOUT
FOR LIGHTING POINT

DRG. NO.
SNCPL-WR-T-B/TYP-EL/CONDUIT-02

ARCHITECTS:
DIMENSIONS & DESIGNS
architects,engineers,interior designer
D-669, Chitranjan Park
NEW DELHI-110019 (INDIA)
PH: 011-26274473, 011-26274474

D&D