


PLOT NO : - GH-3B

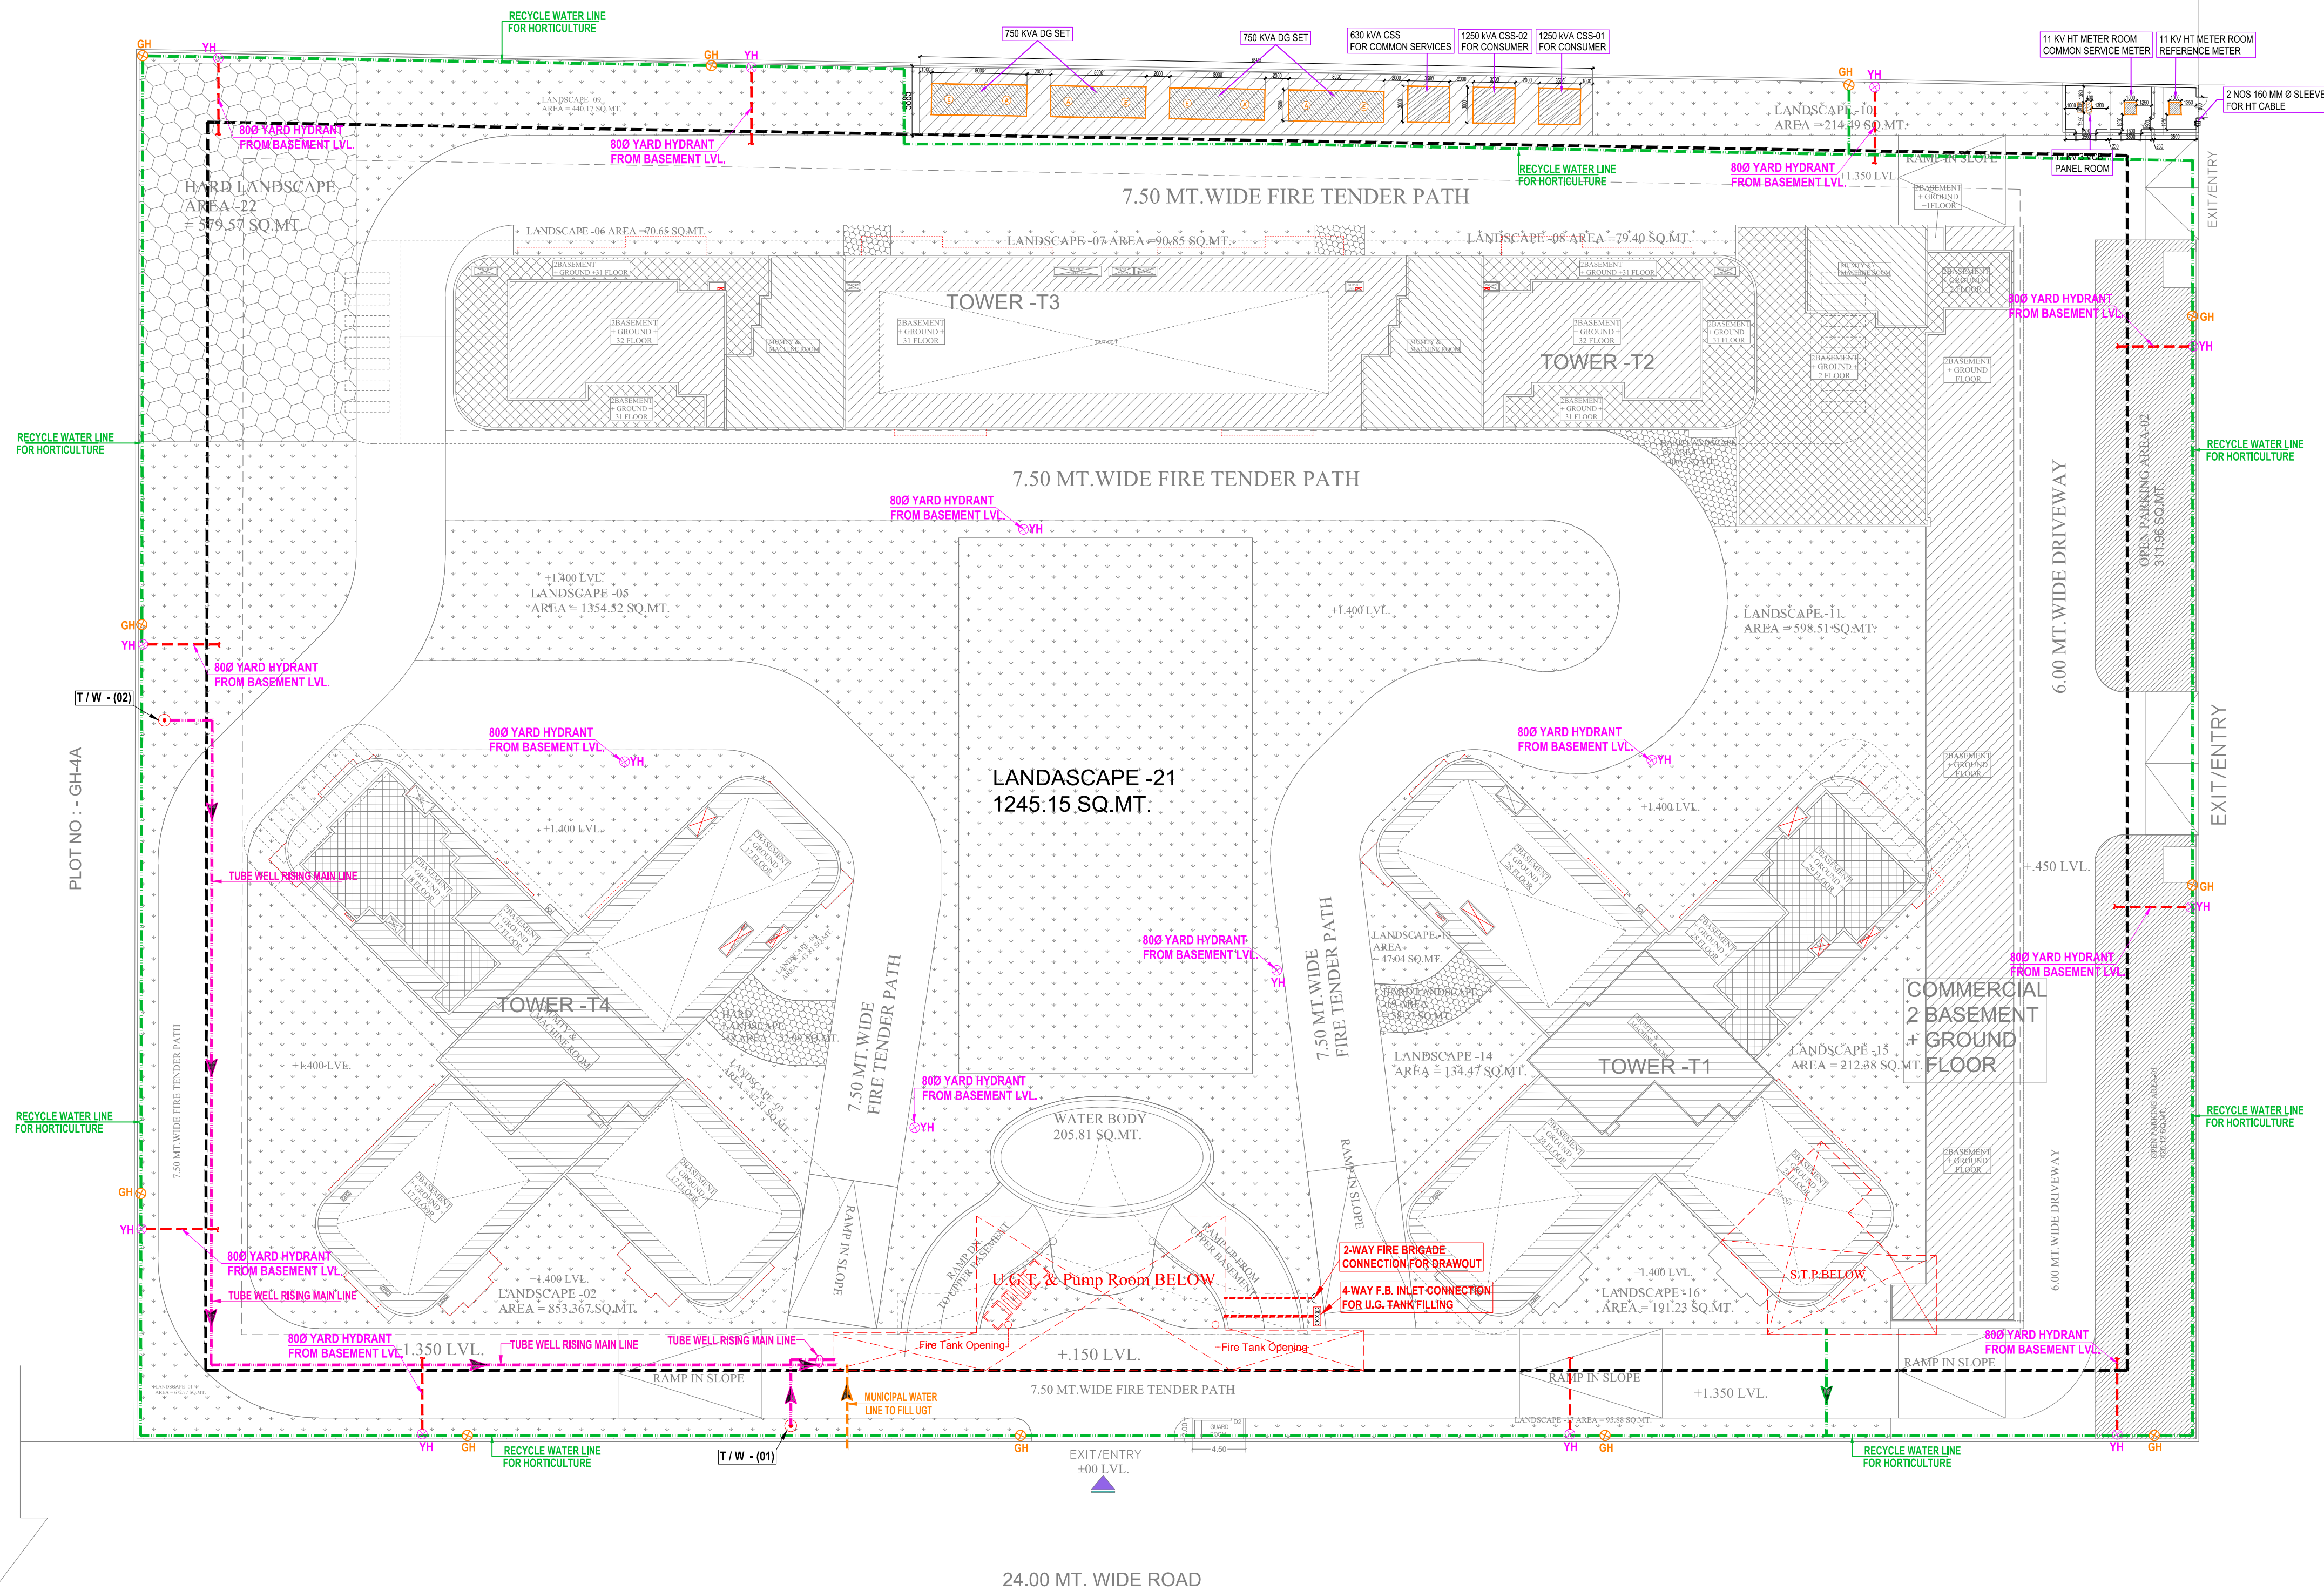


LEGEND :

S. No.	SYMBOL	DESCRIPTION
1.		RECYCLED WATER SUPPLY PIPE LINE.
2.		RISING MAIN WATER PIPE LINE.
3.		MUNICIPAL WATER SUPPLY PIPE LINE.
4.		ISOLATING VALVE
5.		MASONRY CHAMBER FOR ISOLATING VALVE
6.		PROPOSED TUBE WELL
7.		BASEMENT LINE
8.		GARDEN HYDRANT

LEGEND : FIRE SYSTEM

S. No.	SYMBOL	DESCRIPTION
1.		FIRE LINE
2.	 YH	YARD HYDRANT 63 M.M. DIA. SINGLE HEADED HYDRANT VALVE WITH 2 NOS. 15 M. LONG, 63 M.M. DIA. FIRE HOSE PIPE & 1 NO. BRANCH PIPE WITH NOZZLE
3.		FIRE BRIGADE CONNECTION
4.		BUTTERFLY VALVE
5.		NONRETURN VALVE (CHECK VALVE)
6.		ISOLATING VALVE WITH MASONRY CHAMBER

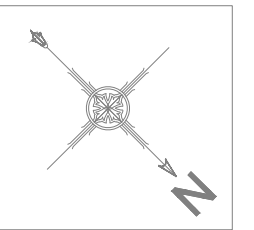

..	..	..
Rev. no.	Date	Revision

Project
PROPOSED GROUP HOUSING
AT PLOT No. GH-03A, SECTOR-12,
GREATER NOIDA

Title
SITE PLAN.

Subtitle
EXTERNAL WATER SUPPLY SERVICES

Drawing released for

☐ **APPROVAL** ☒ **SUBMISSION**

☐ **ADVANCE COPY** ☐ **CONSTRUCTION**

Drg. no. VVIP WHITE / EX / S-03

Drawn by Kulwant

Scale 1 : 350

Designed by R.K.

Date May 2024	Checked by Anand Havelia
------------------	-----------------------------

Architects

 ARCHITECTS :
Space Designers International
B - 34, SECTOR-67, NOIDA
PH : 0120-3100450, 451 452, 453
Mob: 9711633717, 18
e-mail : info@spacedi.com, www.spacedi.com

Services Consultant

Cespl Consultants Pvt. Ltd.

ce'spl
Enriching Together In Global Value

B - 67, Sector - 67, Noida - 201 301

Tel : (0120) 3225400 / 3225401

e mail : mail@cespl.in, website : www.cespl.in