



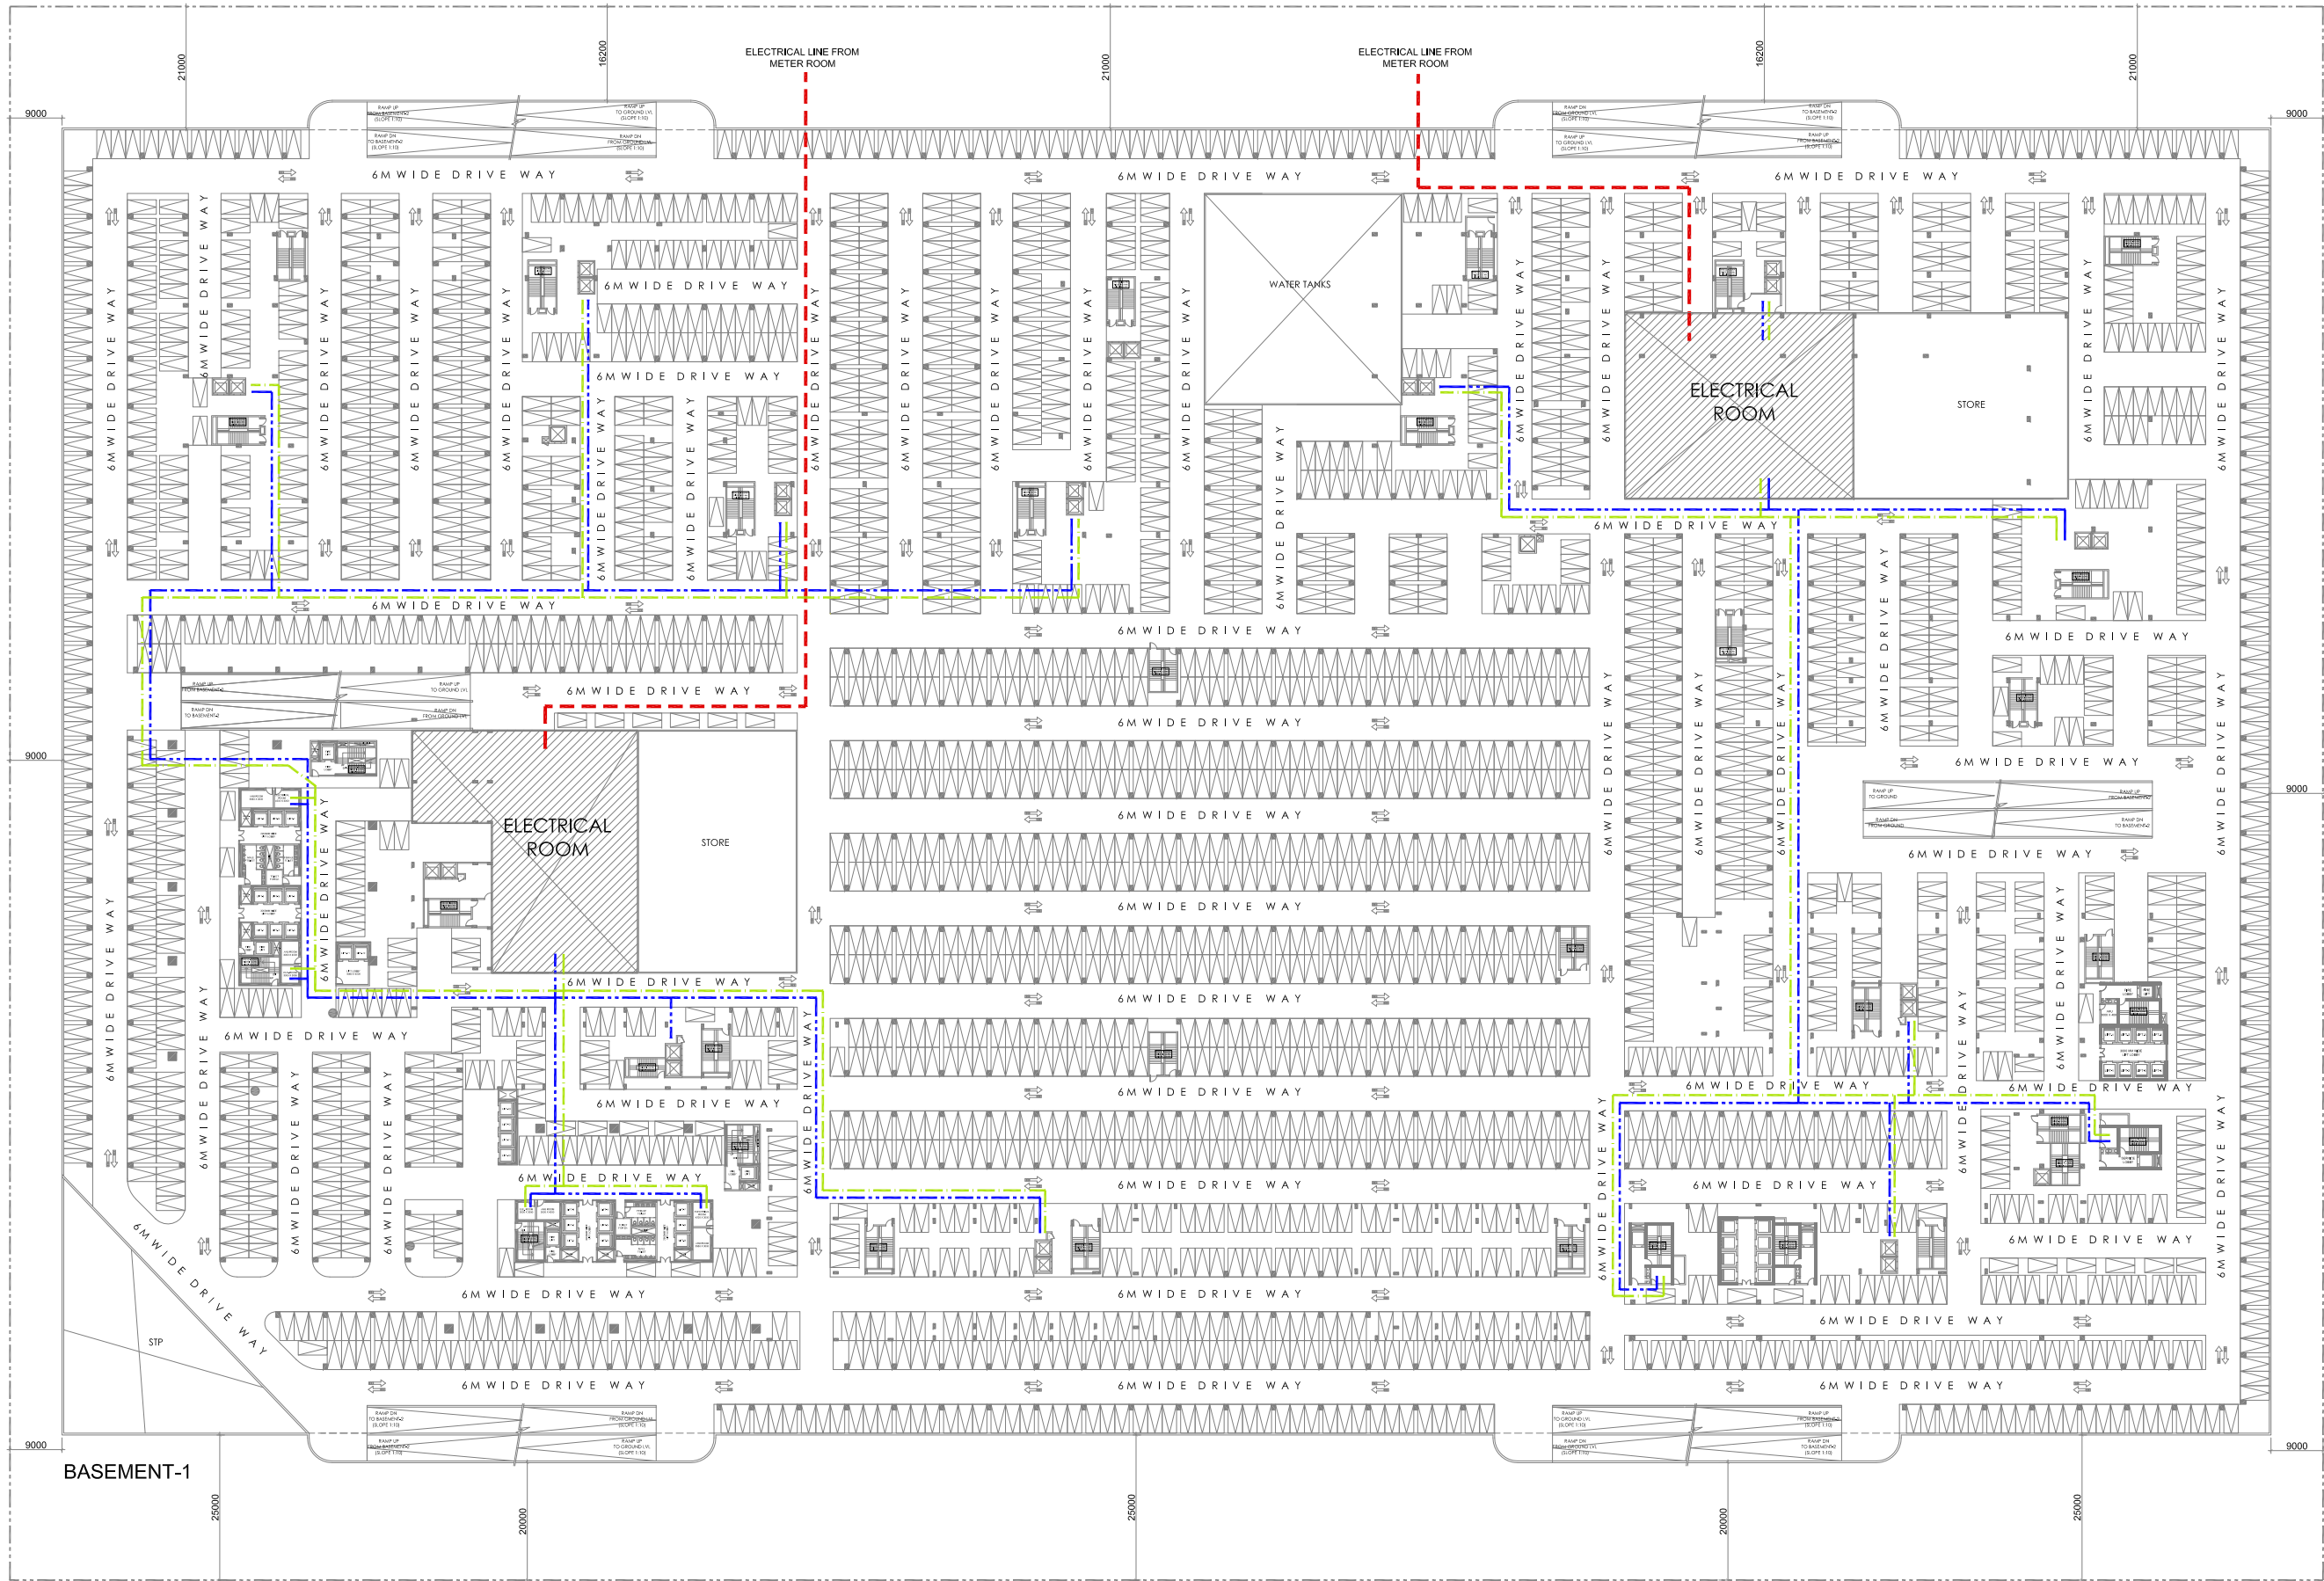

	ELECTRICAL MAIN LINE TO BASEMENT
	ELECTRICAL LINE TO BUILDING BLOCK
	DG CONNECTION TO BUILDING BLOCK

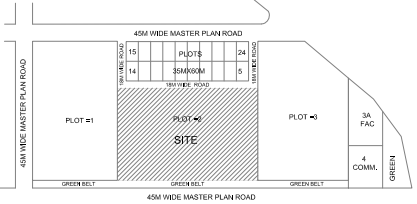

SUBMISSION

PROJECT:
IT/ITES (IT PARK) at PLOT NO.-2, SECTOR -140A, NOIDA, UP

FRONT OFFICE TITLE:
MAX DIGI INFOTECH PRIVATE LTD.
C-23,GREATER KAILASH ENCLAVE-1,
NEW DELHI-110048

DRAWING TITLE:
BASEMENT PLAN-1 (ELECTRICAL SCHEMATIC LAYOUT)


OWNER'S SIGN


ARCHITECT'S SIGN

ARCHITECT:
ACPL
ACPL Design Ltd

SCALE
1:500

DEALT BY
CHECKED BY

DATE - 28/08/2018

DRG. No.
SP/SITE-01

ACPL
ACPL Design Ltd


ARCHITECT'S SIGN

SCALE
1:500

DEALT BY
CHECKED BY

DATE - 28/08/2018

DRG. No.
SP/SITE-01

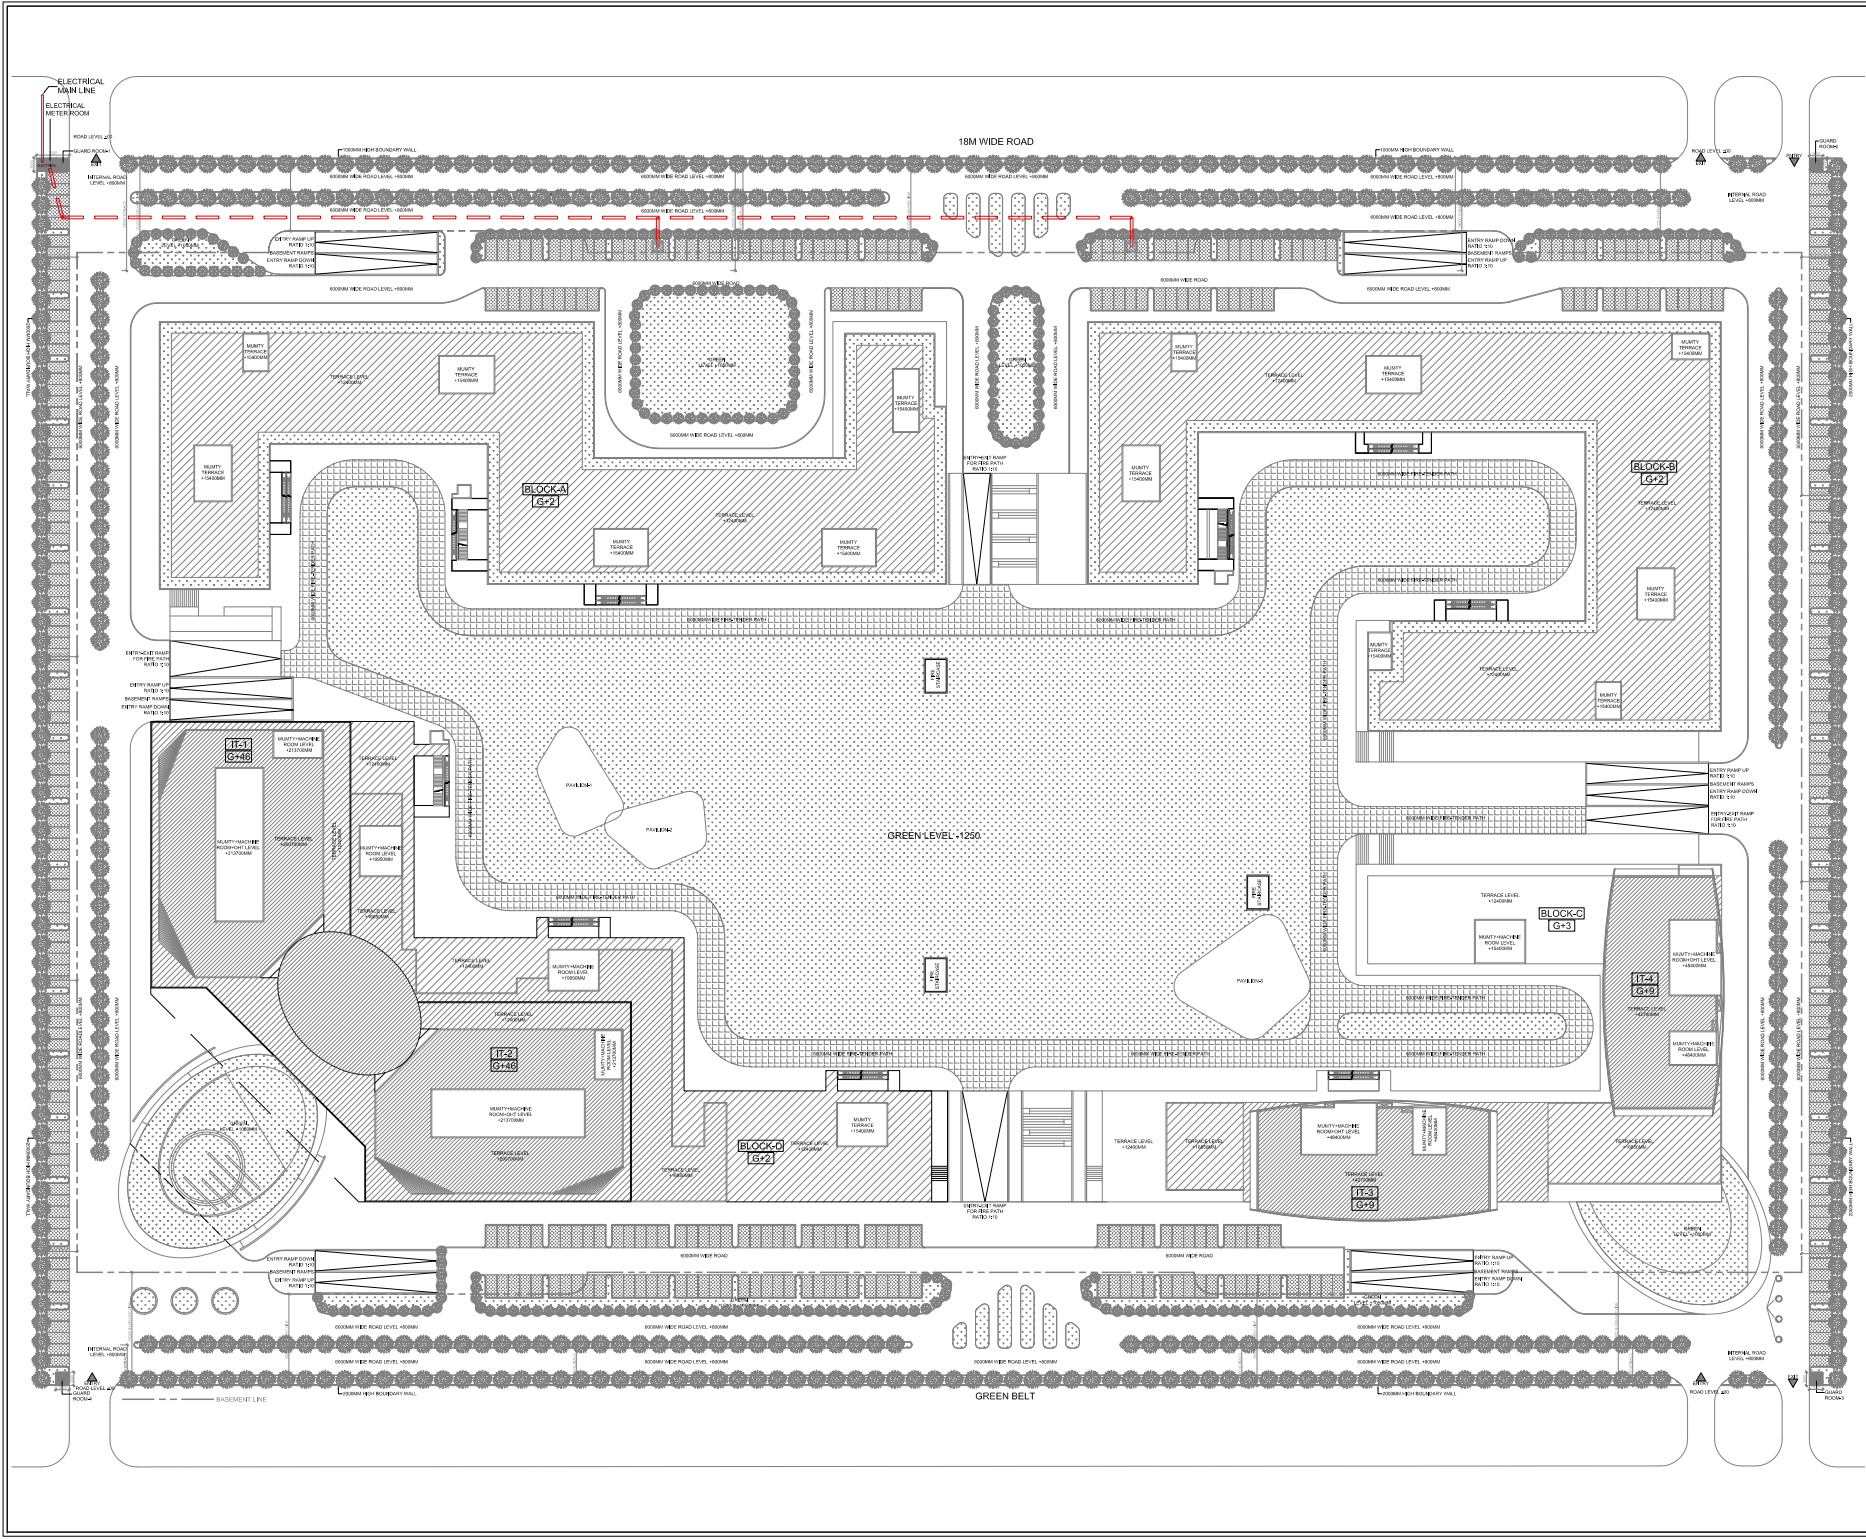

KEY PLAN

SUBMISSION

PROJECT:
IT/ITES (IT PARK) at PLOT NO.-2, SECTOR -140A, NOIDA, UP

FRONT OFFICE TITLE:
MAX DIGI INFOTECH PRIVATE LTD.
C-23, GREATER KAILASH ENCLAVE-1, NEW DELHI-110048

DRAWING TITLE:
SITE PLAN
ELECTRICAL SCHEMATIC LAYOUT

OWNER'S SIGN

ARCHITECT'S SIGN

ARCHITECT:
ACPL
ACPL Design Ltd

SCALE: 1:500

DESIGN BY:

DATE: 28/08/2018

CHECKED BY:

DRG. No.: SP/SITE-01