

45.0 Mts WIDE ROAD

45.0 Mts WIDE ROAD

PART -01


PART -02

- NOTES
1. ALL LIFTS SHALL HAVE 100% POWER BACK-UP.
 2. ALL ELECTRICAL INSTALLATIONS SHALL BE AS PER PROVISIONS OF NBC.
 3. VENTILATION IN BASEMENTS SHALL BE AS PER RELEVANT NBC PROVISIONS 12-15 AIR CHANGES PER HOUR FOR NORMAL OPERATION 30 AIR CHANGES PER HOUR FOR OPERATION IN CASE OF FIRE.
 4. FIRE-FIGHTING / SAFETY PROVISIONS WILL BE AS PER RELEVANT NBC PROVISIONS
 5. BUILDING STRUCTURE DESIGNED EARTH QUAKE RESISTANT
 6. ALL RAMP ARE IN 1:10 SLOP FOR CARS & 1:20 FOR HANDICAPS UNTIL UNLESS SPECIFIED
 7. 200 mm WIDE (AAC) BLOCKS SHALL BE USED FOR EXTERNAL WALLS & 100 MM WIDE (AAC) BLOCKS SHALL BE USED FOR INTERNAL WALLS
 8. KITCHEN & TOILETS EXHAUST FAN PROVIDED / MECHANICALLY LIT & VENTILATED
 9. ALL FIRE STAIR CASE ARE ON EXPOSED WALL WITH 1050 RAILING OTHERWISE MECHANICALLY LIT & PRESSURISED AS NBC.

PILOT BOUNDARY
SUBTRACK LINE
BASEMENT PROFILE LINE

PLUMBING SYMBOLS LEGEND	
	STORM WATER MANHOLE (800 x 600) MM
	STORM WATER MANHOLE (800 x 800) MM
	SEWER MANHOLE (800 x 800) MM
	EXTERNAL SEWER LINE
	EXTERNAL STORM WATER LINE
	DOMESTIC WATER SUPPLY LINE
	FLUSHING WATER SUPPLY LINE
	EXTERNAL FIRE HYDRANT LINE
	MUNICIPAL LINE WATER SUPPLY
	GARDEN IRRIGATION WATER SUPPLY LINE
	EXTERNAL FIRE HYDRANT (750x600x250) MM
	GARDEN HYDRANT
	RECHARGE PIT (3000 MM DIA)
	DIESEL TANK CHAMBER (1000 x 2000) MM
	VALVE WITH CHAMBER
	NON RETURN VALVE WITH CHAMBER (N.R.V.)

Key Plan

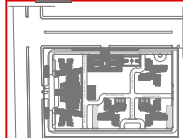

PERA SUBMISSION DRAWING

Architects Signature
ARCOP ASSOCIATES
A-15, PAMPOSH ENCLAVE
New Delhi-110 048

Owner's Signature

Clients
STARLANDCRAFT PVT. LTD.
B-47 Surpamart,
Ghaziabad -201010

Architects

Project title
Proposed Building Plan at Plot no SC-6109,
Sector 152, Noida being developed by M/S Star
Landcraft PVT. LTD.

MEP Consultants
PARADISE CONSULTANTS
PLOT NO. 103, POCKET-1 BASEMENT,
NEAR LIVING STYLE MALL,
JASOLA VIHAR NEW DELHI - 110025
PHONE NO. : 011-29943601, 26943216
E-MAIL : paradiseconsultants@gmail.com

Drawing Title



EXTERNAL SITE PLAN
FIRE & WATER SUPPLY LAYOUT

Job No.	Drawing No.
2016/03	PL-FIRE & WATER-003
Drawn	Checked
UNRAM	NAFEEZ
Date	Scale
09.04.21	1:300 (A2)
Revisions	

SYMBOL	DESCRIPTION
	BUTTER FLY VALVE
	NON RETURN VALVE (NRV)
	PRESSURE REDUCING VALVE
	DOMESTIC WATER SUPPLY LINE
	FLUSHING WATER SUPPLY LINE

- Notes
1. ALL LIFTS SHALL HAVE 100% POWER BACK-UP.
 2. ALL ELECTRICAL INSTALLATIONS SHALL BE AS PER PROVISIONS OF NBC.
 3. VENTILATION IN BASEMENTS SHALL BE AS PER RELEVANT NBC PROVISIONS 12-15 AIR CHANGES PER HOUR FOR NORMAL OPERATION 30 AIR CHANGES PER HOUR FOR OPERATION IN CASE OF FIRE.
 4. FIRE-FIGHTING / SAFETY PROVISIONS WILL BE AS PER RELEVANT NBC PROVISIONS.
 5. BUILDING STRUCTURE DESIGNED EARTH QUAKE RESISTANT.
 6. ALL RAMP ARE IN 1:10 SLOP FOR CARS & 1:20 FOR HANDICAPS UNTIL UNLESS SPECIFIED.
 7. 200 mm WIDE (AAC) BLOCKS SHALL BE USED FOR EXTERNAL WALLS & 100 MM WIDE (AAC) BLOCKS SHALL BE USED FOR INTERNAL WALLS.
 8. KITCHEN & TOILETS EXHAUST FAN PROVIDED / MECHANICALLY LIT & VENTILATED.
 9. ALL FIRE STAIR CASE ARE ON EXPOSED WALL WITH 1050 RAILING OTHERWISE MECHANICALLY LIT & PRESSURISED AS/NBC.

- PLOT BOUNDARY
— SETBACK LINE
— BASEMENT PROFILE LINE

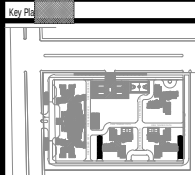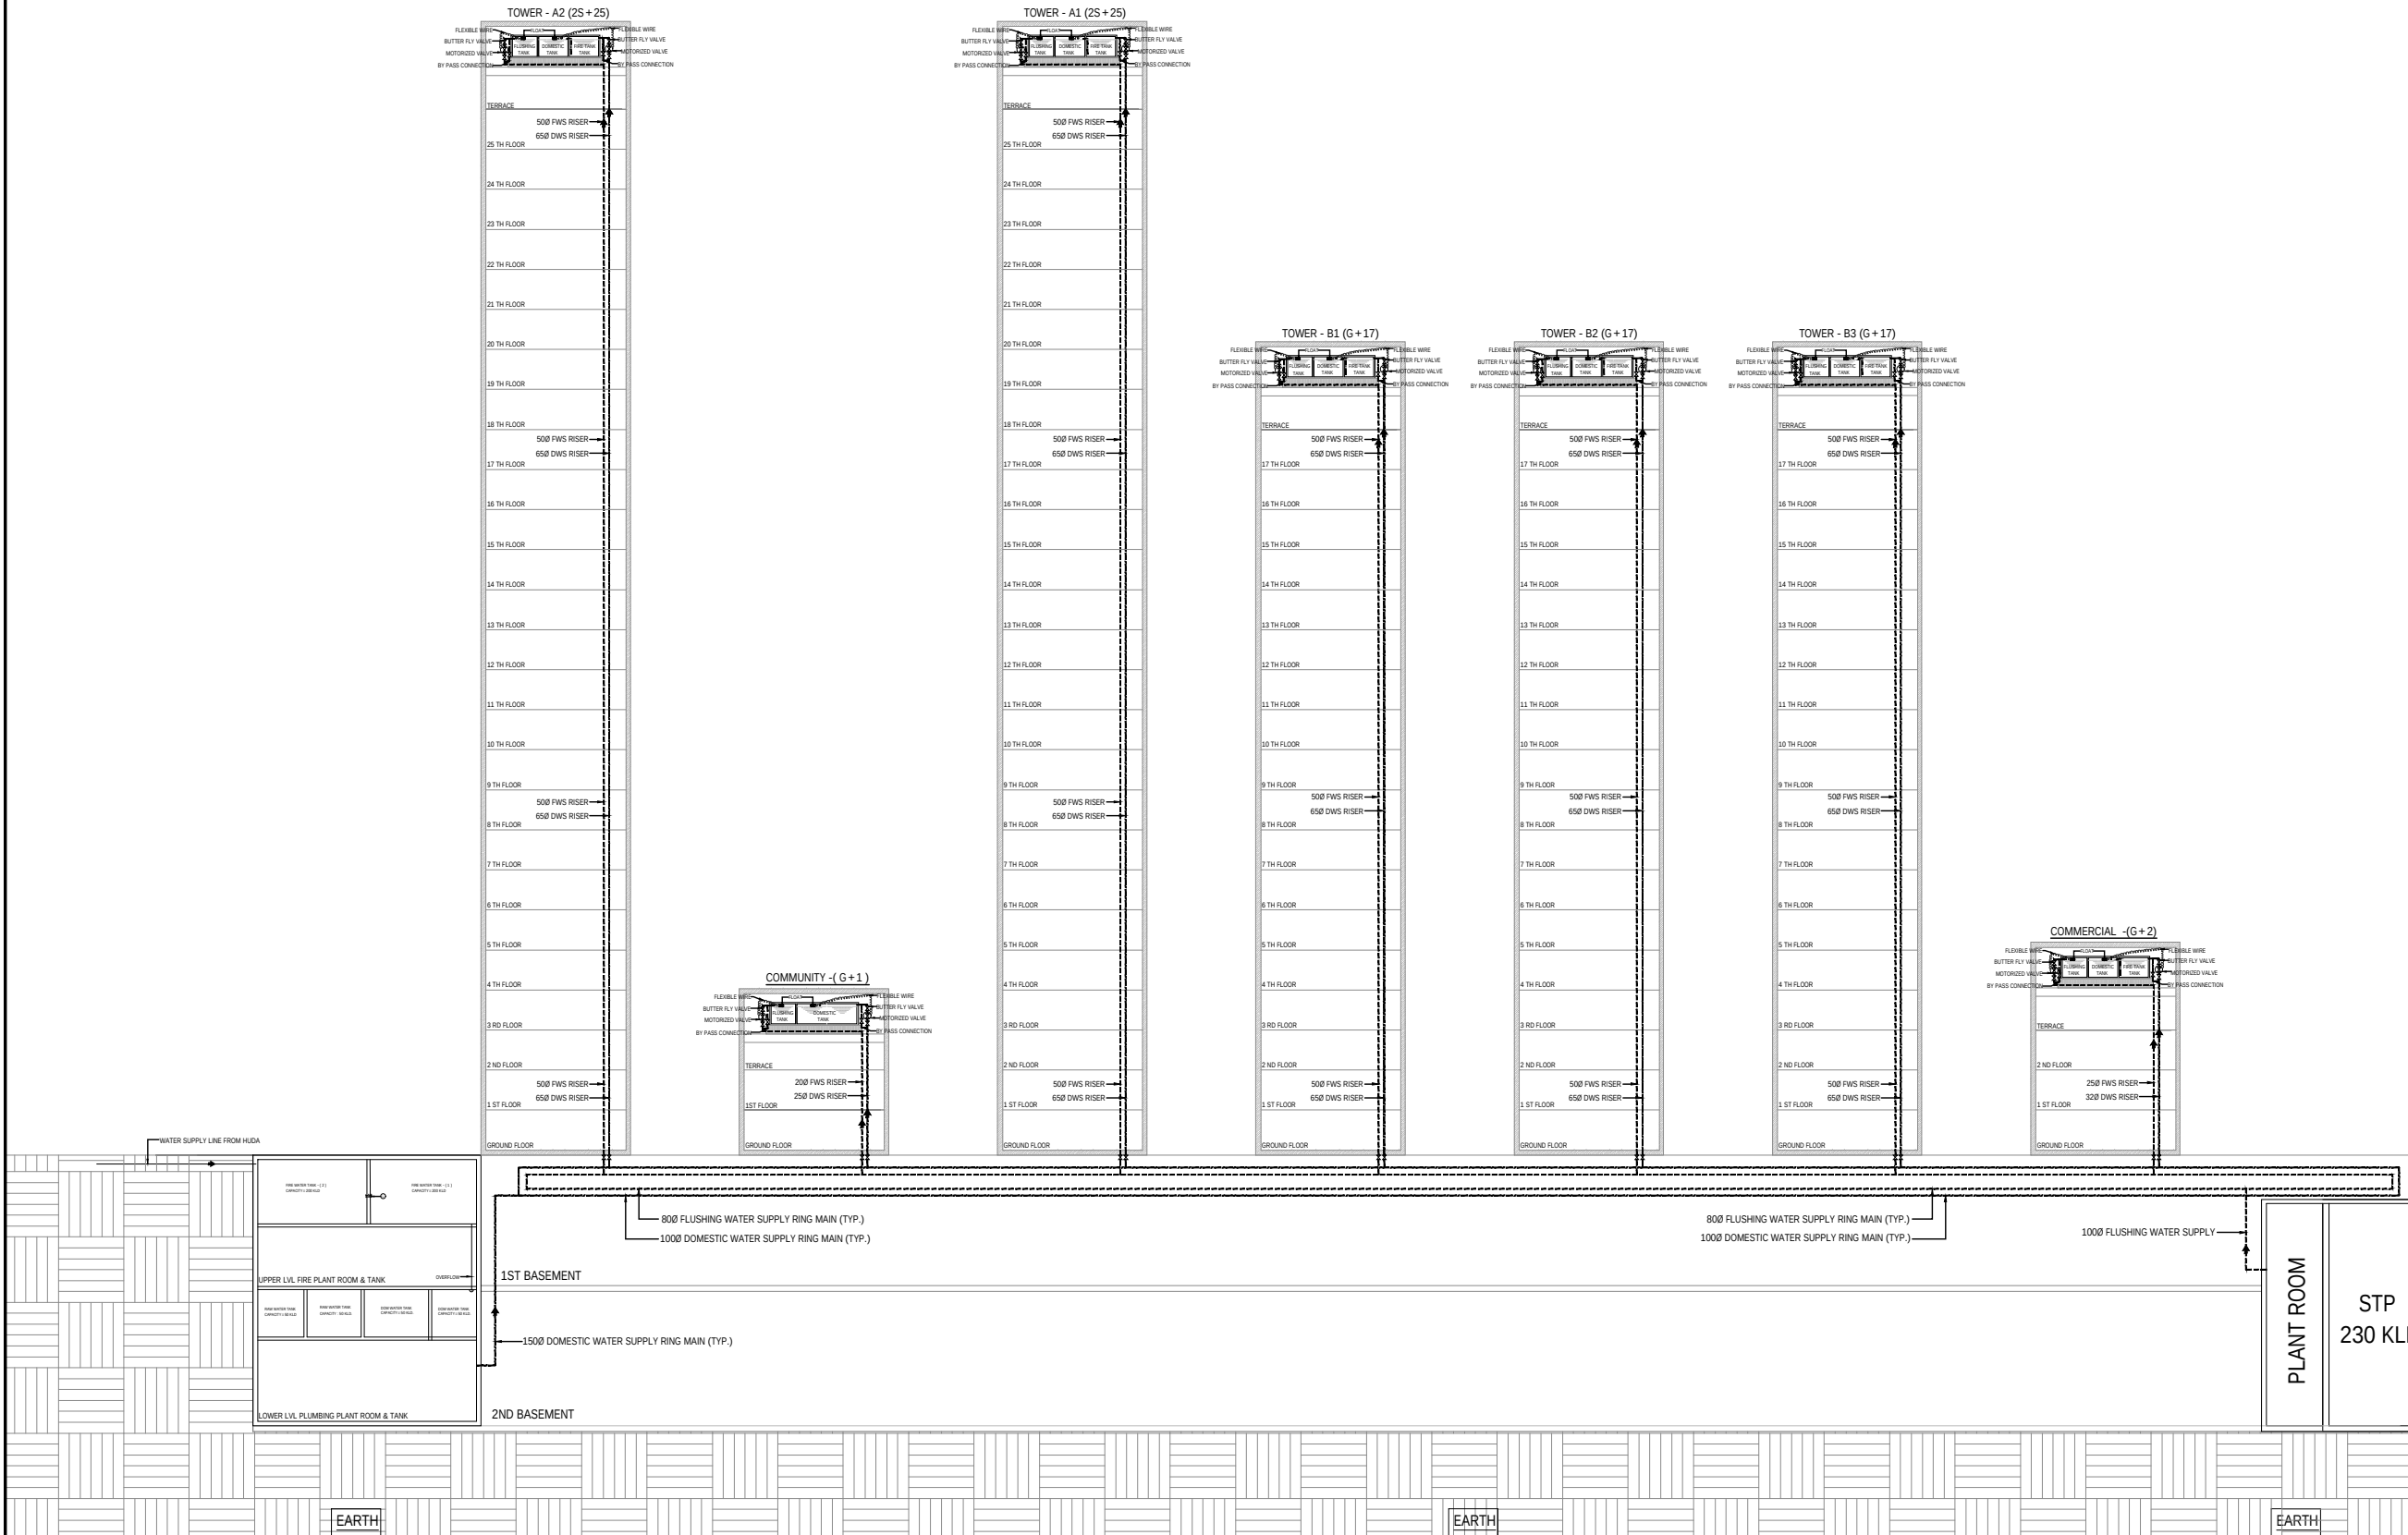

RERA SUBMISSION DRAWING

Architects Signature
ARCOP ASSOCIATES
A-15, PAMPOSH ENCLAVE
New Delhi-110 048

Owner's Signature

Clients
STARLANDRAFT PVT. LTD.
B-47 Surjanagar,
Gurgaon-201009

Architects


Project Title
Proposed Building Plan at Plot no SC-01/09, Sector 152,
Noida being developed by M/S Star Landcraft PVT. LTD.

MEP Consultants
PARADISE CONSULTANTS
PLOT NO. 103, POCKET-1 BASEMENT,
NEAR LIVING STYLE MALL,
JASOLA VIHAR NEW DELHI - 110025
PHONE NO. : 011-26943601, 26943216
E-MAIL : paradise consultants @ gmail.com


Drawing Title
**WATER SUPPLY NETWORKING
SCHEMATIC DIAGRAM**

Job No. 2024/043	Checked NAFEES	Revisions
Drawn VIKRAM	Scale 1:300 (A1)	
Date 09.04.21		

PL-PC-SLD-001

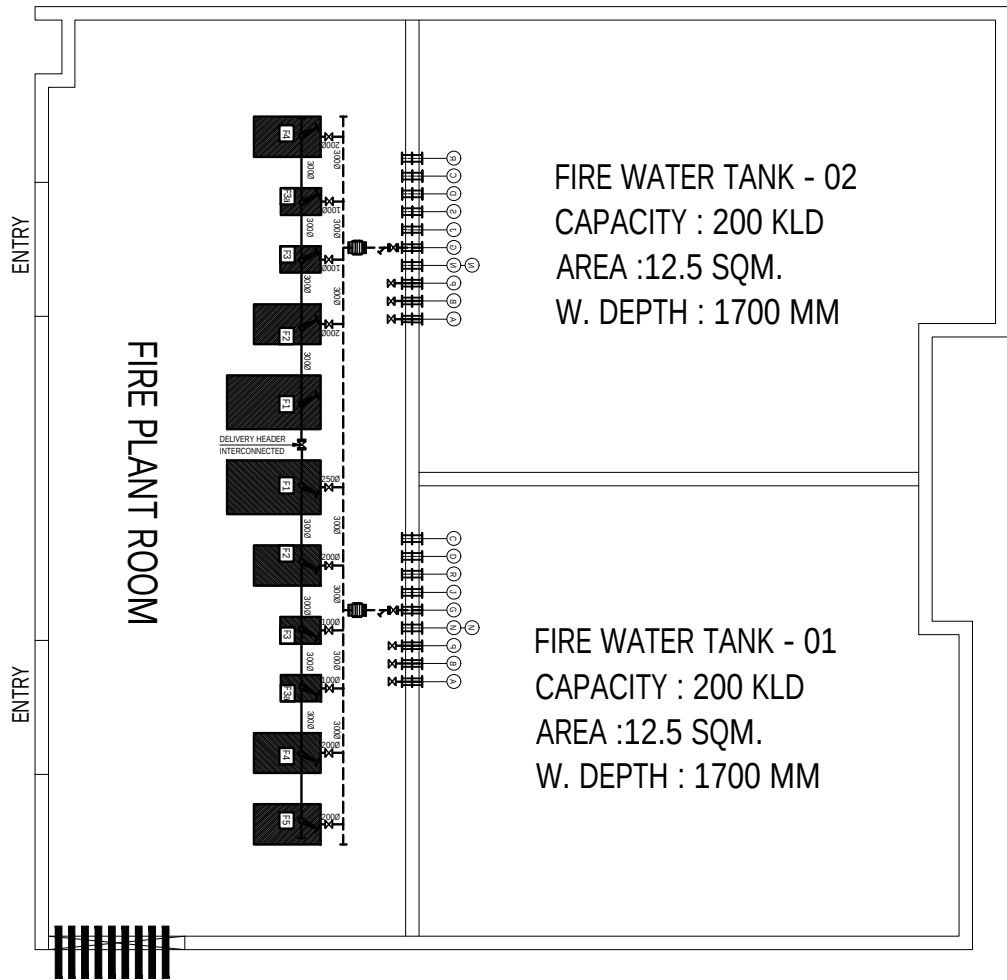


FIRE WATER TANK UPPER BASEMENT FLOOR LVL

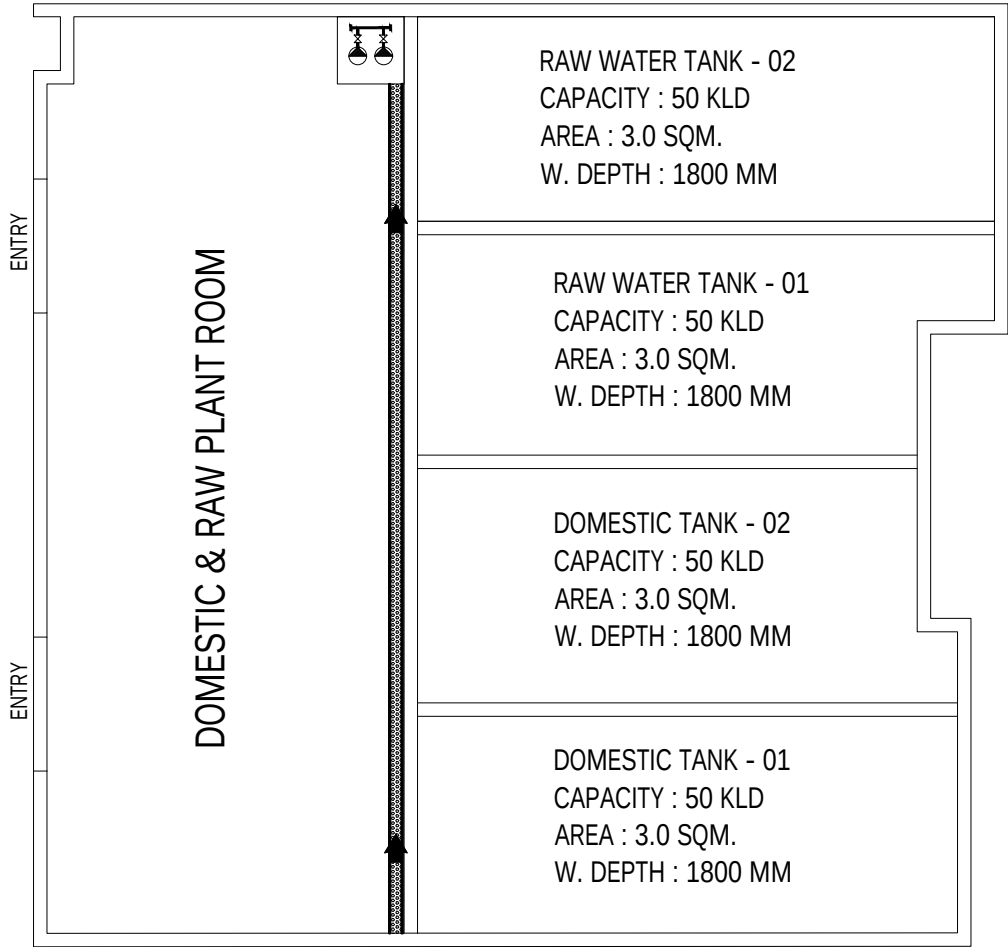

DOMESTIC WATER TANK & RAW WATER TANK LOWER BASEMENT FLOOR LVL

- Notes
1. ALL LIFTS SHALL HAVE 100% POWER BACK-UP.
 2. ALL ELECTRICAL INSTALLATIONS SHALL BE AS PER PROVISIONS OF NBC.
 3. VENTILATION IN BASEMENTS SHALL BE AS PER RELEVANT NBC PROVISIONS 12-15 AIR CHANGES PER HOUR FOR NORMAL OPERATION 30 AIR CHANGES PER HOUR FOR OPERATION IN CASE OF FIRE.
 4. FIRE-FIGHTING / SAFETY PROVISIONS WILL BE AS PER RELEVANT NBC PROVISIONS
 5. BUILDING STRUCTURE DESIGNED EARTH QUAKE RESISTANT
 6. ALL RAMP ARE IN 1:10 SLOP FOR CARS & 1:20 FOR HANDICAPS UNTIL UNLESS SPECIFIED
 7. 200 mm WIDE (AAC) BLOCKS SHALL BE USED FOR EXTERNAL WALLS & 100 MM WIDE (AAC) BLOCKS SHALL BE USED FOR INTERNAL WALLS
 8. KITCHEN & TOILETS EXHAUST FAN PROVIDED / MECHANICALLY LIT & VENTILATED.
 9. ALL FIRE STAIR CASE ARE ON EXPOSED WALL WITH 1050 RAILING OTHERWISE MECHANICALLY LIT & PRESSURISED AS/NBC.

Key Plan

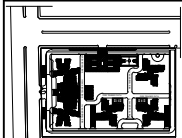

RERA SUBMISSION DRAWING

22-7-2024 Plot No. 103, Pocket-1, Sector 152, Noida being developed by M/S Star Landcraft PVT. LTD.

Architects Signature
ARCOP ASSOCIATES
A-15, PAMPOSH ENCLAVE
New Delhi-110 048

Owner's Signature

Clients
STAR LANDCRAFT PVT. LTD.
B-47 Sayamagar,
Ghaziabad-201010

Architects

Project title
Proposed Building Plan at Plot no SC-01/09,
Sector 152, Noida being developed by M/S Star
Landcraft PVT. LTD.

MEP Consultants
PARADISE CONSULTANTS
PLOT NO. 103, POCKET-1 BASEMENT,
NEAR LIVING STYLE MALL,
JASOLA VIHAR NEW DELHI - 110025
PHONE NO. : 011-29943601, 26943216
E-MAIL : paradise consultants @ gmail.com

Drawing Title
UNDER GROUND WATER TANK
PLUMBING LAYOUT

Job No. 2025043	Drawing No. PL-UGT-001
Drawn VIRAM	Checked NAFEES
Date 08.04.23	Revisions 1/75 (A2)