


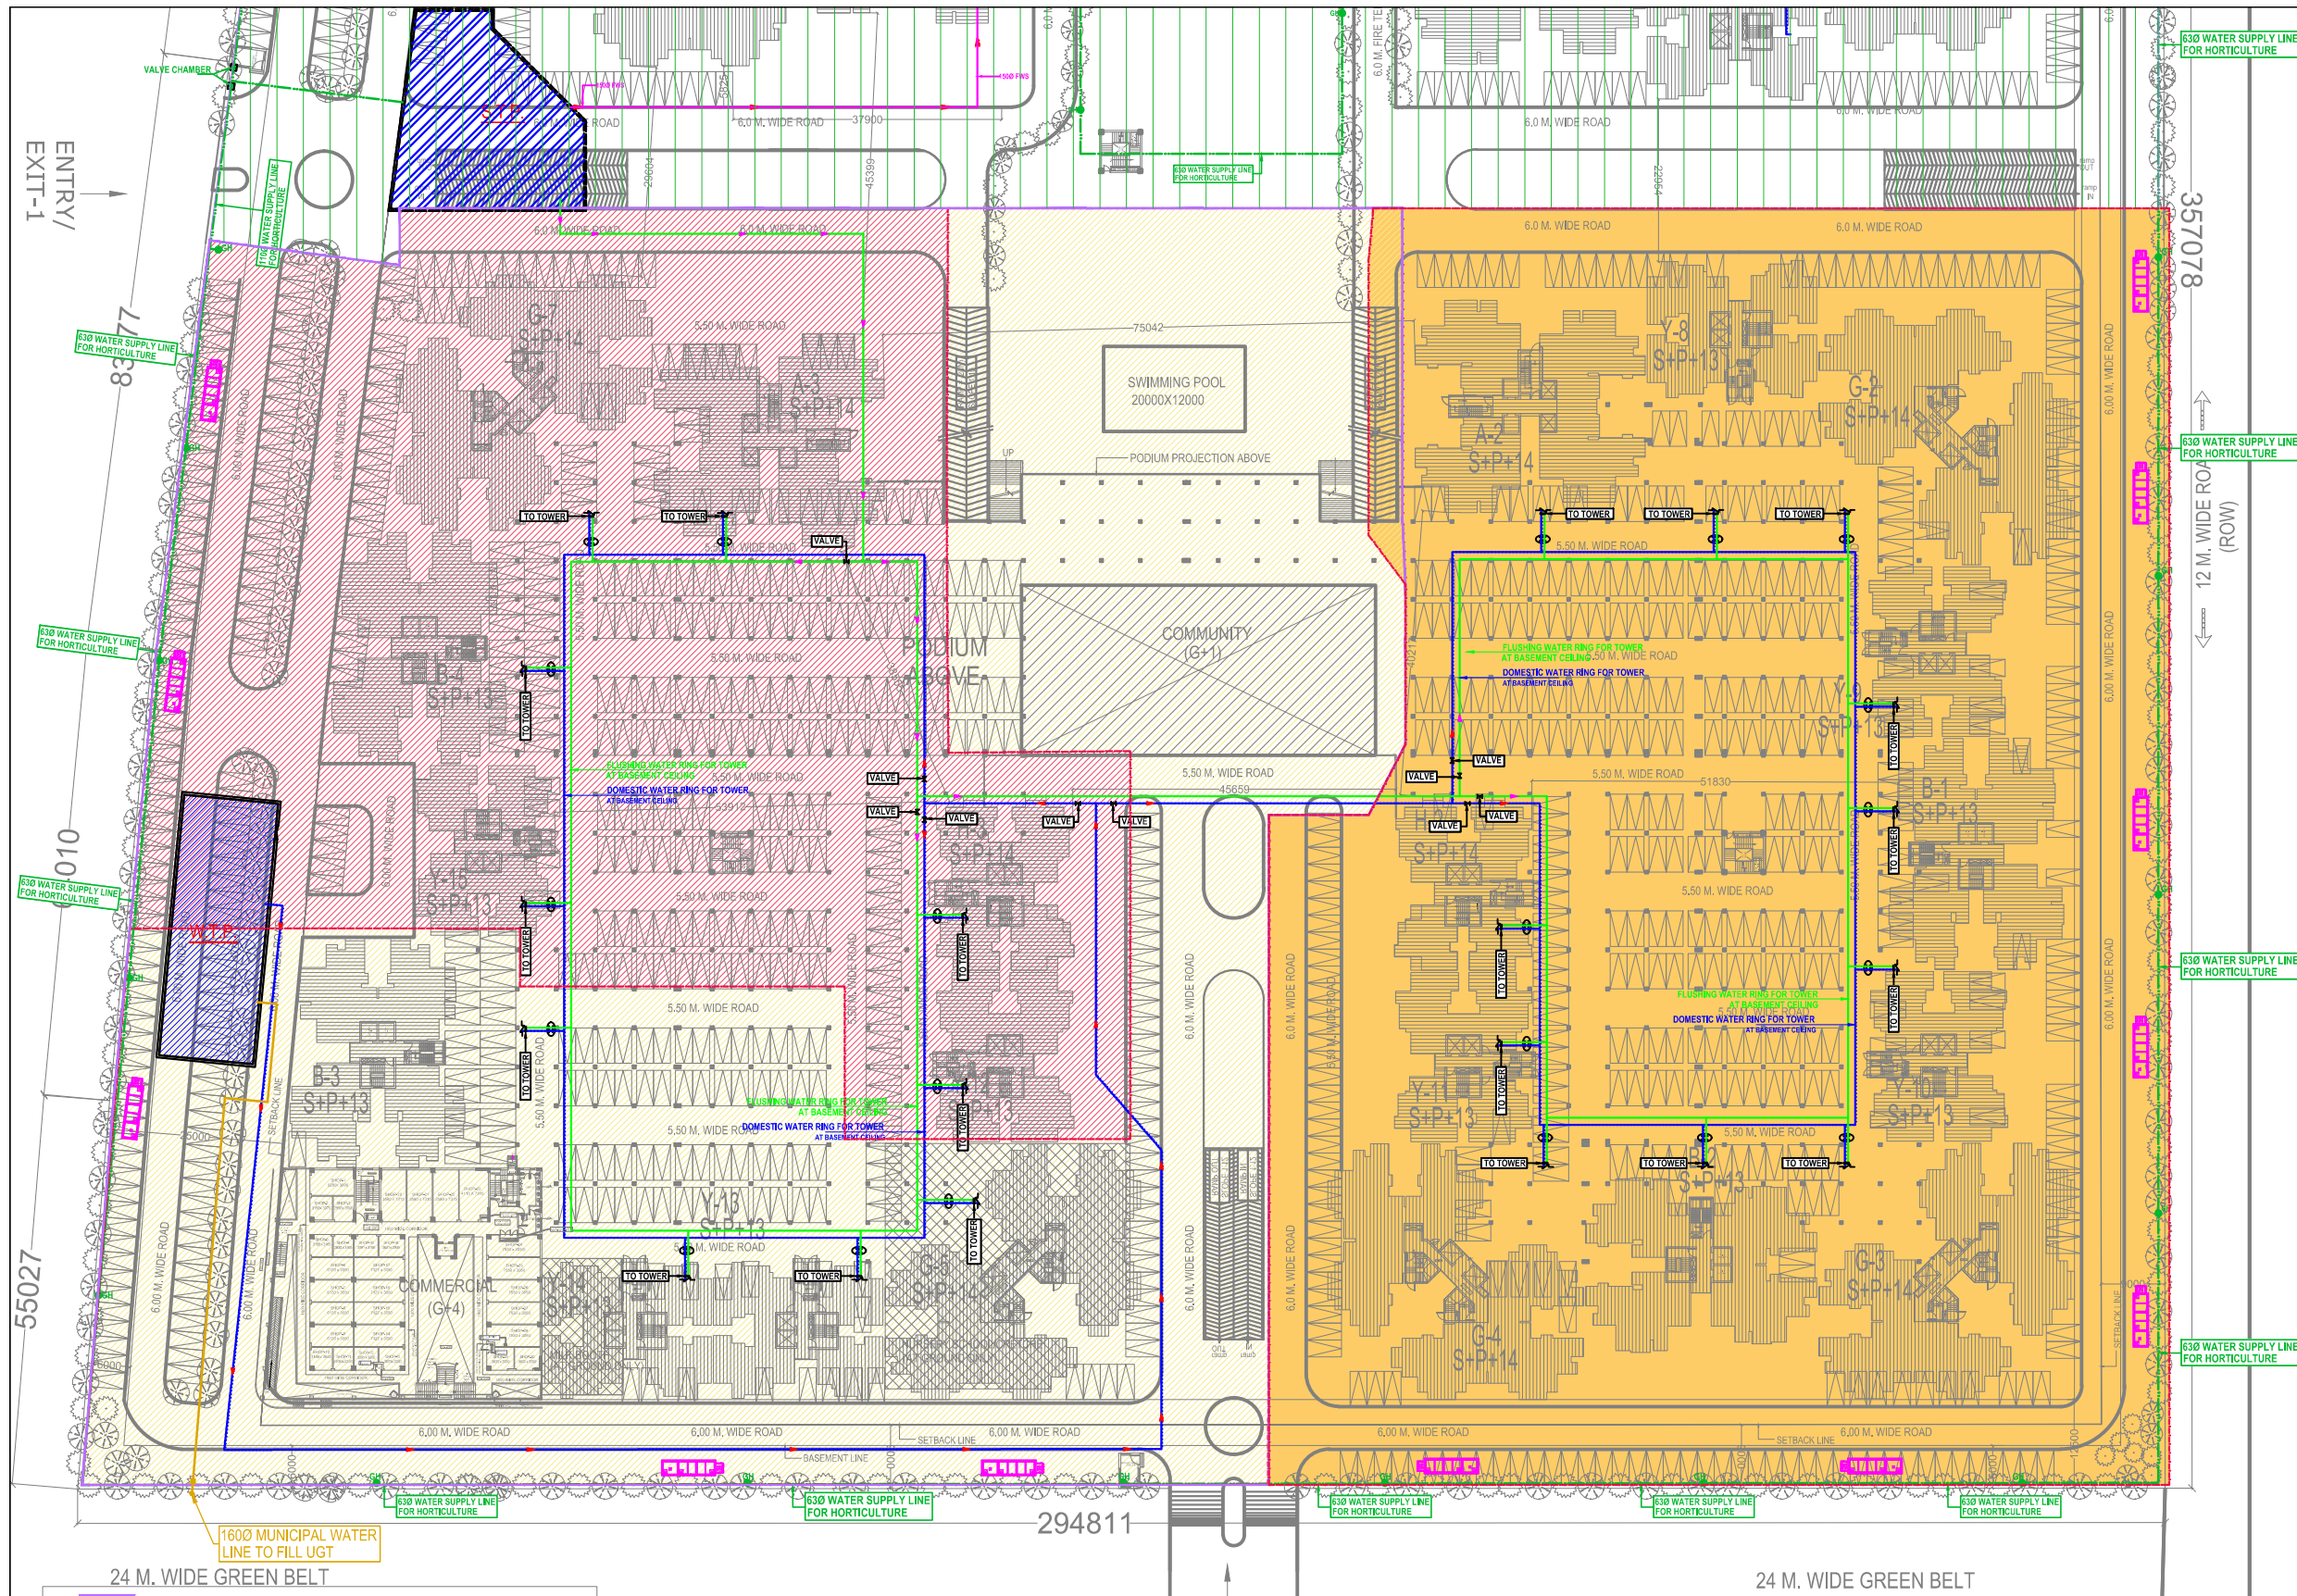

LEGEND :		
S. No.	SYMBOL	DESCRIPTION
1.		MUNICIPAL WATER SUPPLY PIPE LINE
2.		DOMESTIC WATER SUPPLY RING MAIN (DWS)
3.		RECYCLED WATER SUPPLY RING MAIN (FWS)
4.		RECYCLED WATER SUPPLY LINE FOR HORTICULTURE
5.		BASEMENT LINE
6.		GARDEN HYDRANT

	COMPLETED PHASE
	PHASE, EROS SAMPOORNAM 1 SHOWN THUS AREA 16,380.00 Sqm. (Approx.)
	PHASE, EROS SAMPOORNAM 2 SHOWN THUS AREA 13,534.00 Sqm. (Approx.)
	PHASE, EROS SAMPOORNAM 3 SHOWN THUS AREA 21,555.00 Sqm. (Approx.)

rev. no.	date	revision
project	EROS SAMPOORNAM GROUP HOUSING at GREATER NOIDA	
title	PHASE - III & IV SITE PLAN	
subtitle	EXTERNAL WATER SUPPLY SYSTEM	

drawing released for			
☐ APPROVAL	☐ SUBMISSION		
☐ ADVANCE COPY	☐ CONSTRUCTION		
drg. no.	CES / ES / SP / PL-05	drawn by	Arjun
scale	A1@ : 475	designed by	Shakir Sabbir
date	NOV2018	checked by	Anand Havella

architects	
VAIBHAVJAIN & ASSOCIATES	
195, RAM VIHAR, DELHI-110092	
PHONE/FAX : 42918322, 22377102	
E mail : avinash@nae.co.in, info@nae.co.in	
services consultant	
Consummate Engineering Services (P) Ltd.	
Noida Office : B - 67, Sector - 67, Noida - 201 301	
Tel : (0120) 2593500 (30 Lines)	
Lko Office : R 086, Rohas Plumeria, Gomti Nagar, Lucknow	
Tel : (0522) 8515455	
e mail : mail@cespln, website : www.cespln	