

Project Title :
ADD. / EXTENSION SUBMISSION
DRAWING FOR THE RESIDENTIAL
(BLOCK -1B, ARYAVARTA EMPIRE)
GROUP HOUSING -1
AT SECTOR-F, POCKET -1, SUSHANT
GOLF CITY, HI-TECH TOWNSHIP,
LUCKNOW [U.P.]

OWNER- M/S. AMRIT PLANNERS
PRIVATE LIMITED

LEGEND

RAIN WATER DRAIN LINE



R.W.H. PIT

DRG. TITLE

SITE PLAN FOR RAIN WATER DRAIN

SCALE - AS SHOWN

DATE - MARCH.24


OWNER'S SIGN

ARCHITECT

ARCHITECTURAL CONSULTANCY
VIJIT & ASSOCIATES
ARCHITECTS, ENGINEERS & PLANNERS
B-1/236, VIKRANT KHAND, GOMTI
NAGAR, LUCKNOW, PH. - 0522-4305138



SITE PLAN

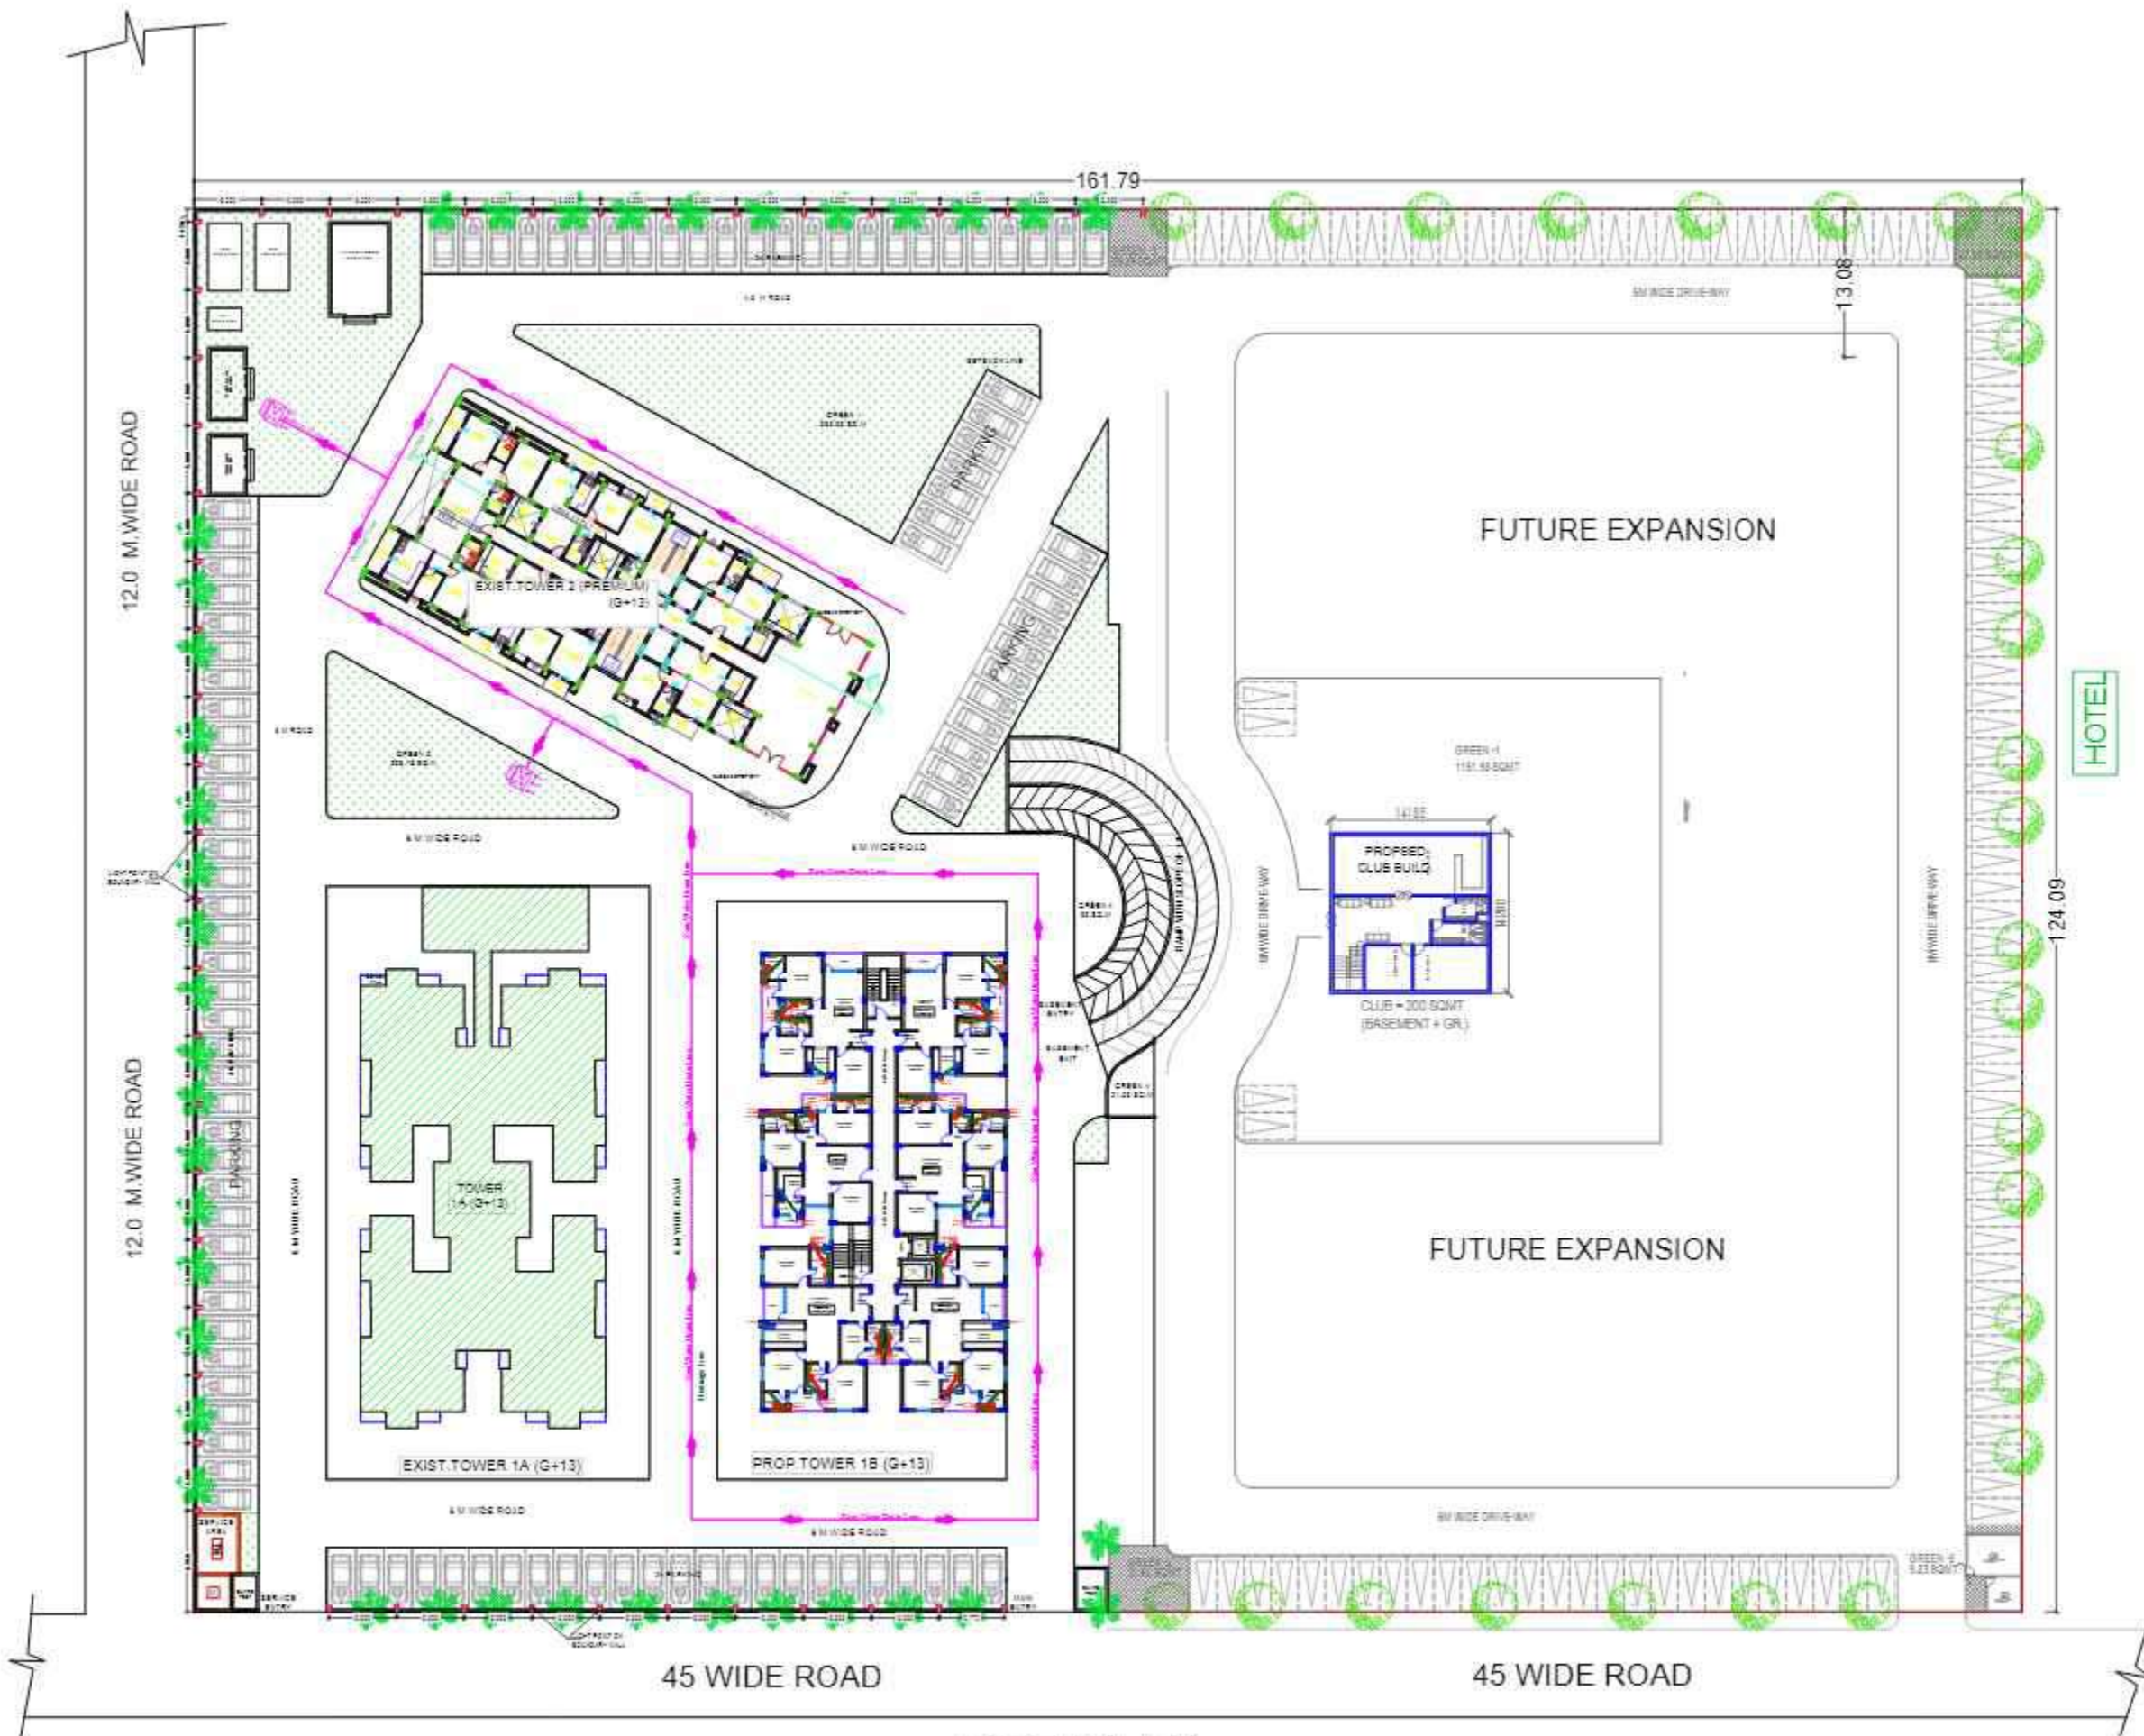

Project Title :
ADD. / EXTENSION SUBMISSION
DRAWING FOR THE RESIDENTIAL
(BLOCK -1B, ARYAVARTA EMPIRE)
GROUP HOUSING -1
AT SECTOR-F, POCKET -1, SUSHANT
GOLF CITY, HI-TECH TOWNSHIP,
LUCKNOW [U.P.]

OWNER- M/S. AMRIT PLANNERS
PRIVATE LIMITED

LEGEND

-  SEWER LINE
-  WATER SUPPLY LINE
-  ELECTRIC SUPPLY LINE
-  DRAIN LINE
-  MAIN HOLE
-  R.W.H. PIT
-  LIGHT POINT

DRG. TITLE

BASEMENT DRAINAGE PLAN


SCALE - AS SHOWN


DATE - MARCH.24

OWNER'S SIGN

ARCHITECT

ARCHITECTURAL CONSULTANCY
VIJIT & ASSOCIATES
ARCHITECTS, ENGINEERS & PLANNERS
B-1/238, VIKRANT KHAND, GOMTI
NAGAR, LUCKNOW, PH. - 0522-4305138

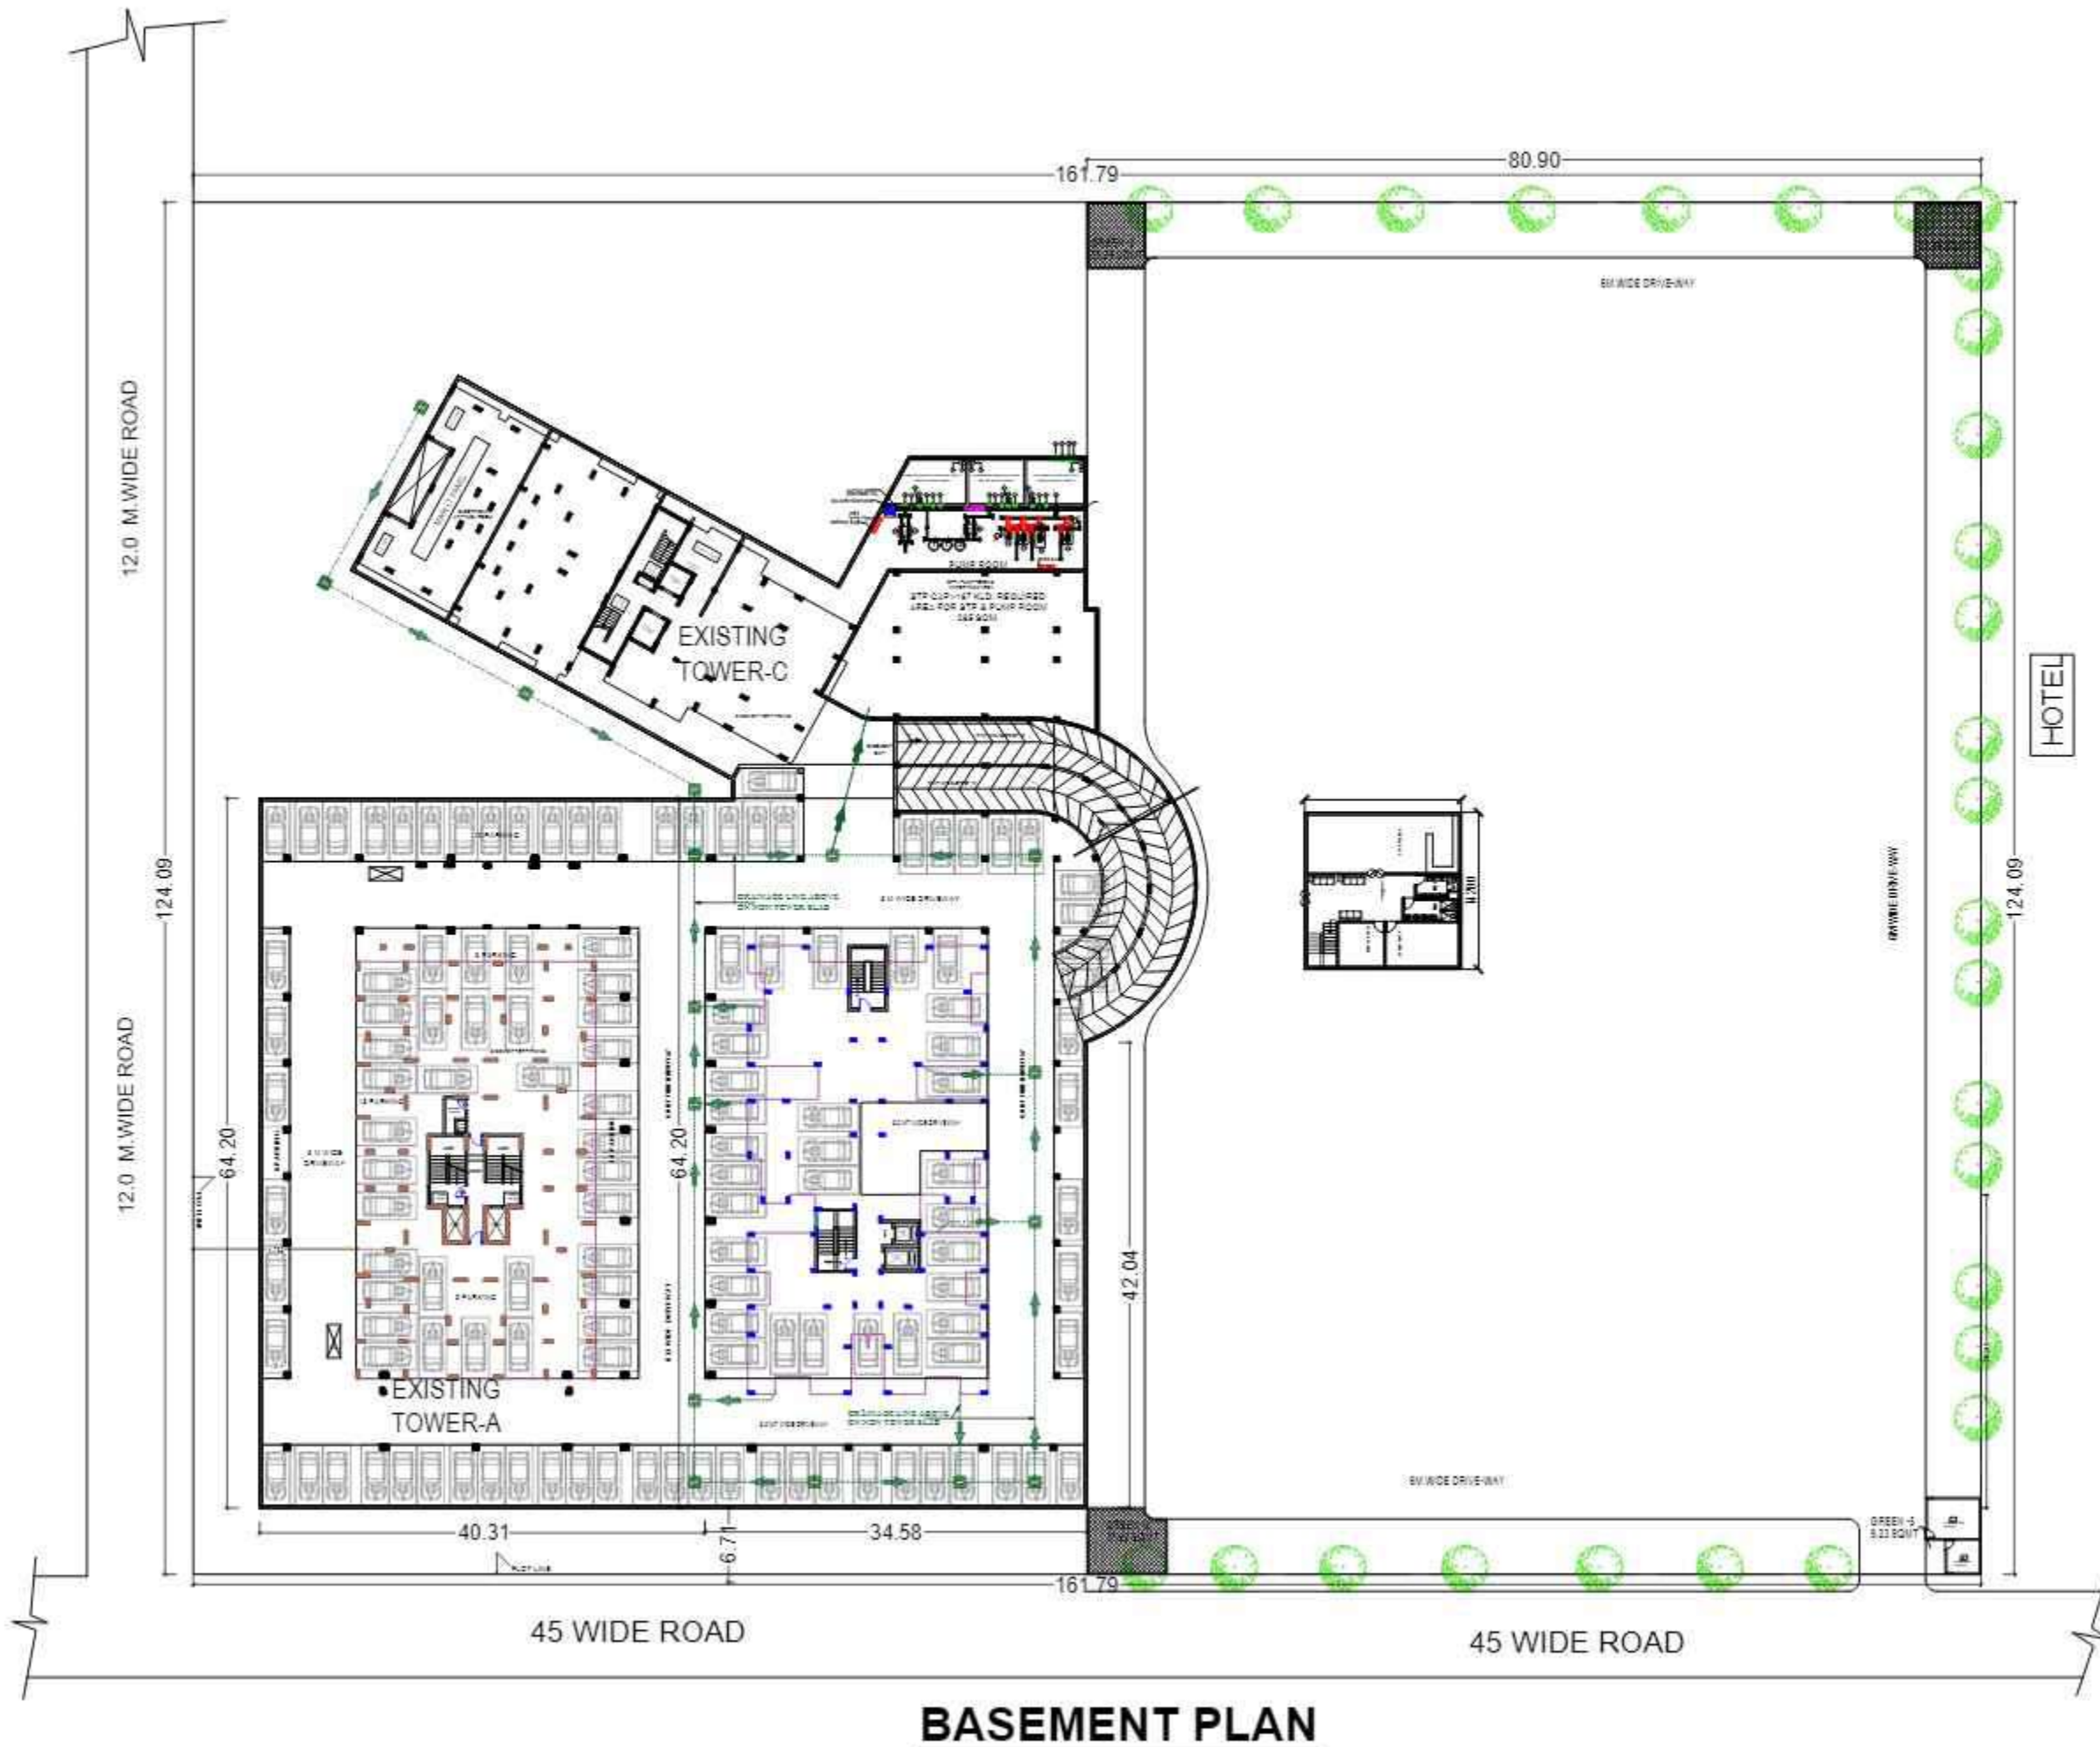

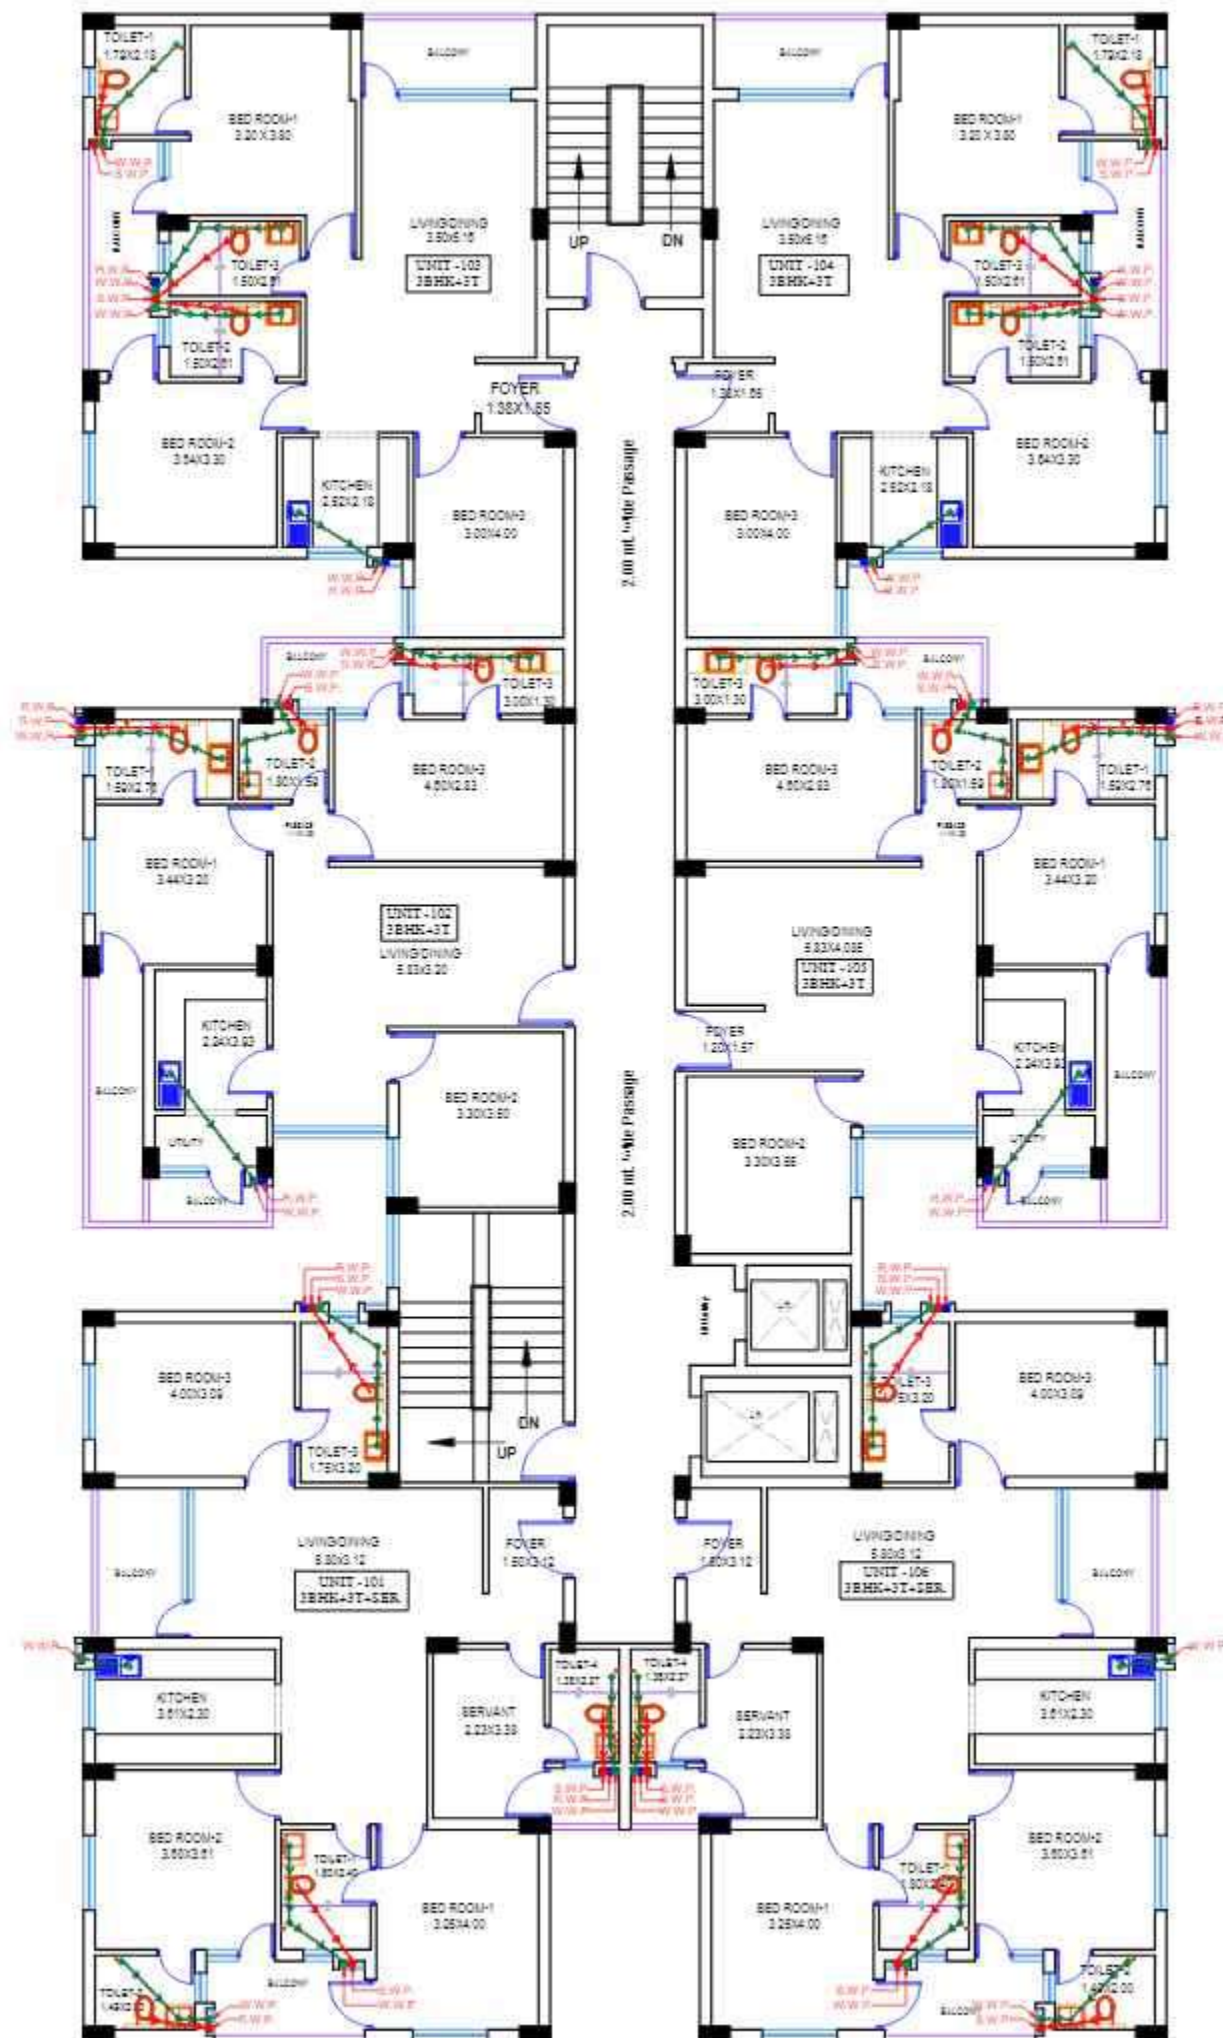

Project Title :
ADD. / EXTENSION SUBMISSION
DRAWING FOR THE RESIDENTIAL
(BLOCK -1B, ARYAVARTA EMPIRE)
GROUP HOUSING -1
AT SECTOR-F, POCKET -1, SUSHANT
GOLF CITY, HI-TECH TOWNSHIP,
LUCKNOW [U.P.]

OWNER- M/S. AMRIT PLANNERS
PRIVATE LIMITED

LEGEND

	W. W. P.
	S. W. P.
	W. W. P.
	R. W. P.
	S. W. P.

DRG. TITLE


TOWER 1B (SANITARY PLAN)

SCALE - AS SHOWN DATE - MARCH.24

OWNER'S SIGN ARCHITECT

ARCHITECTURAL CONSULTANCY
VIJIT & ASSOCIATES
ARCHITECTS, ENGINEERS & PLANNERS
B-1/238, VIKRANT KHAND, GOMTI
NAGAR, LUCKNOW, PH. - 0522-4305138



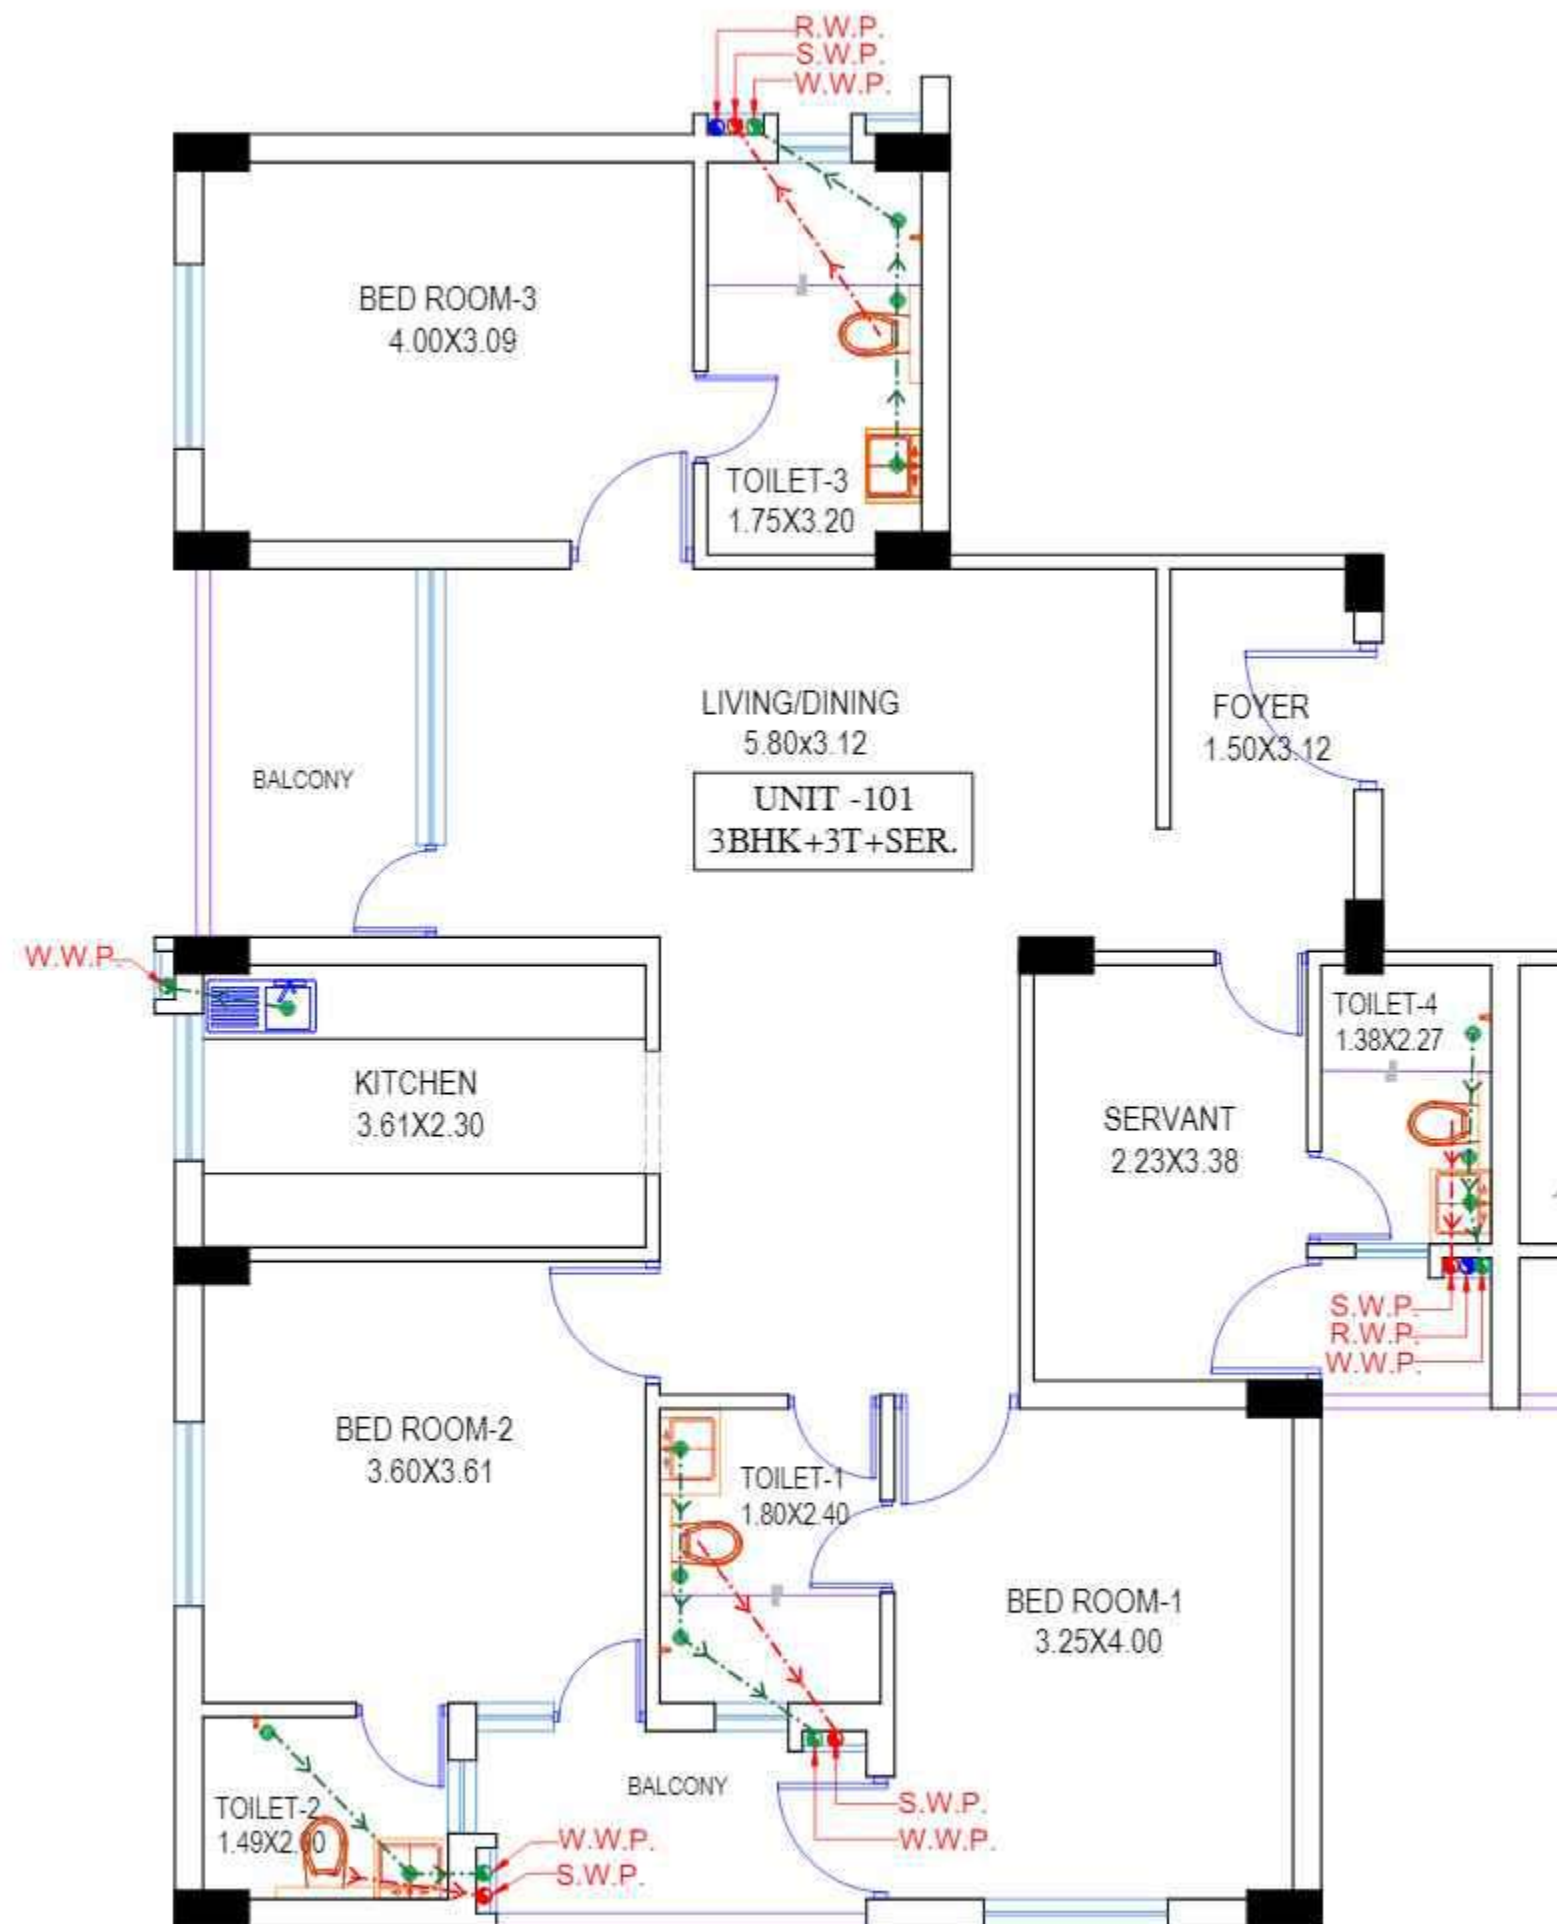

TOWER 1B
(UNIT -101, 3BHK+3T+SER.)

Project Title :
ADD. / EXTENSION SUBMISSION
DRAWING FOR THE RESIDENTIAL
(BLOCK -1B, ARYAVARTA EMPIRE)
GROUP HOUSING -1
AT SECTOR-F, POCKET -1, SUSHANT
GOLF CITY, HI-TECH TOWNSHIP,
LUCKNOW [U.P.]

OWNER- M/S. AMRIT PLANNERS
PRIVATE LIMITED

LEGEND

	W. W. P.
	S. W. P.
	W. W. P.
	R. W. P.
	S. W. P.

DRG. TITLE

TOWER 1B
(UNIT -101, 3BHK+3T+SER.)






SCALE - AS SHOWN DATE - MARCH.24

OWNER'S SIGN

ARCHITECT

ARCHITECTURAL CONSULTANCY
VIJIT & ASSOCIATES
ARCHITECTS, ENGINEERS & PLANNERS
B-1/238, VIKRANT KHAND, GOMTI
NAGAR, LUCKNOW, PH. - 0522-4305138



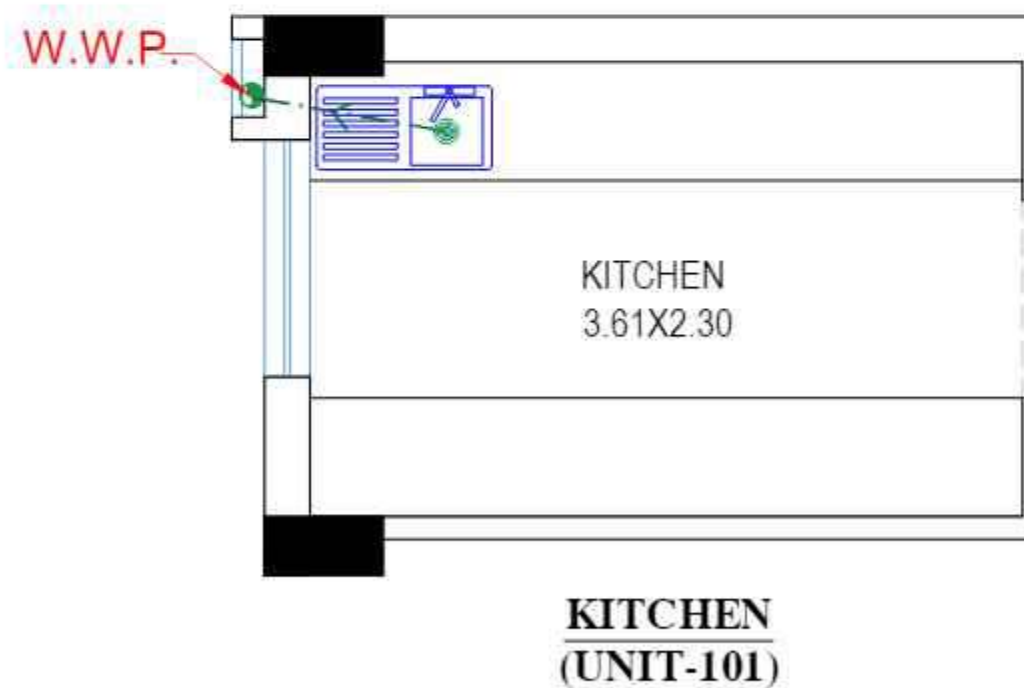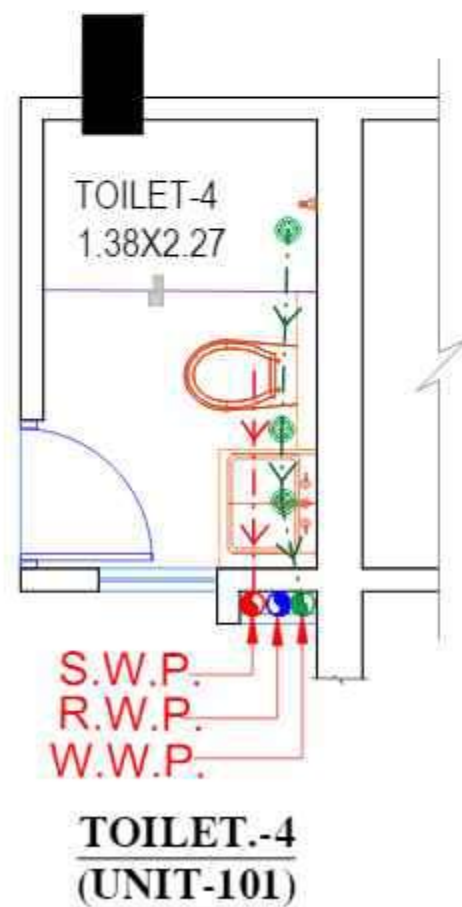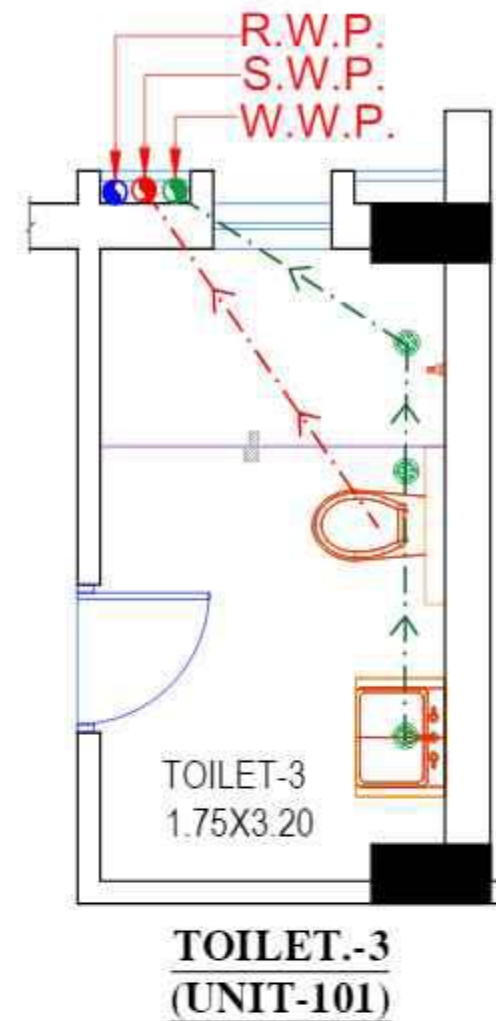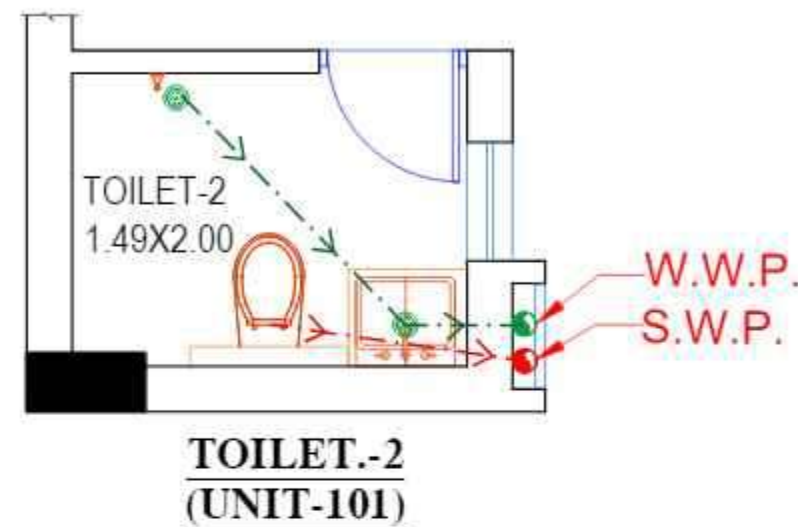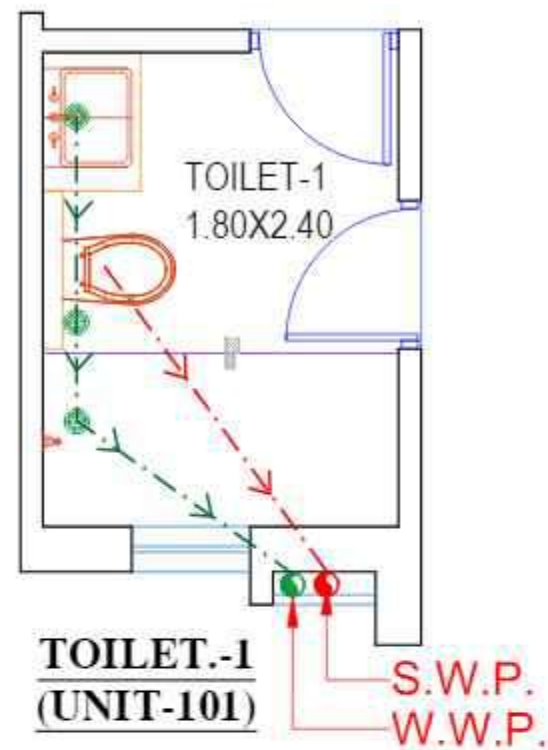

Project Title :
ADD. / EXTENSION SUBMISSION
DRAWING FOR THE RESIDENTIAL
(BLOCK -1B, ARYAVARTA EMPIRE)
GROUP HOUSING -1
AT SECTOR-F, POCKET -1, SUSHANT
GOLF CITY, HI-TECH TOWNSHIP,
LUCKNOW [U.P.]

OWNER- M/S. AMRIT PLANNERS
PRIVATE LIMITED

LEGEND

	W. W. P.
	S. W. P.
	W. W. P.
	R. W. P.
	S. W. P.

DRG. TITLE

**TOWER 1B
(UNIT -101, 3BHK+3T+SER.)**

SCALE - AS SHOWN


DATE - MARCH.24

OWNER'S SIGN

ARCHITECT

ARCHITECTURAL CONSULTANCY
VIJIT&ASSOCIATES
ARCHITECTS, ENGINEERS & PLANNERS
B-1/238, VIKRANT KHAND, GOMTI
NAGAR,LUCKNOW,PH.-0522-4305138



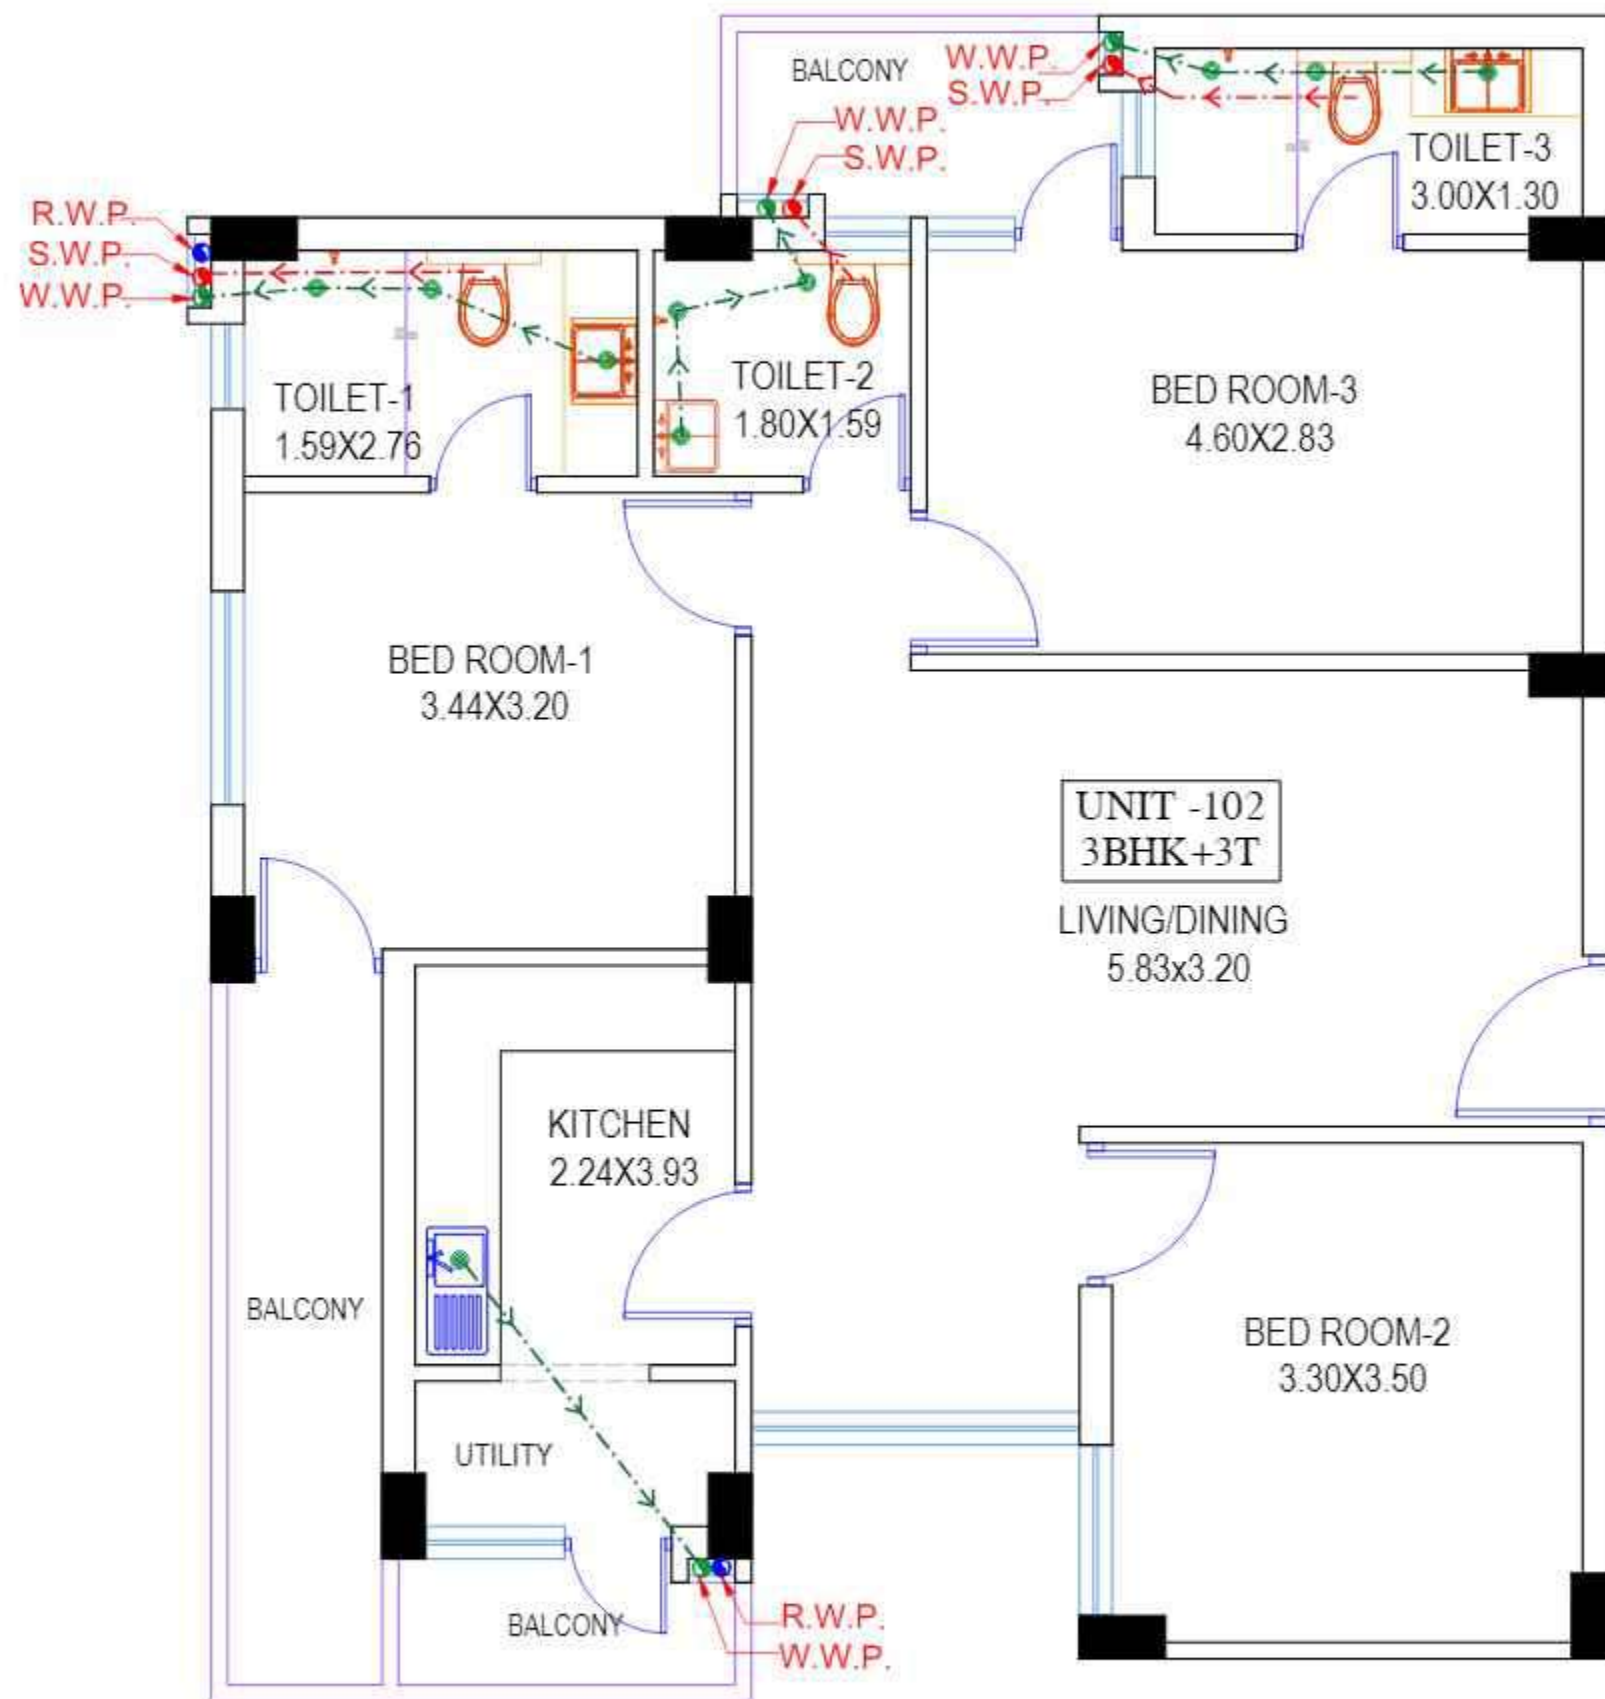

TOWER 1B
(UNIT -102, 3BHK+3T)

Project Title :
ADD. / EXTENSION SUBMISSION
DRAWING FOR THE RESIDENTIAL
(BLOCK -1B, ARYAVARTA EMPIRE)
GROUP HOUSING -1
AT SECTOR-F, POCKET -1, SUSHANT
GOLF CITY, HI-TECH TOWNSHIP,
LUCKNOW [U.P.]

OWNER- M/S. AMRIT PLANNERS
PRIVATE LIMITED

LEGEND

→→→→→	W. W. P.
→→→→→	S. W. P.
●	W. W. P.
●	R. W. P.
●	S. W. P.

DRG. TITLE


TOWER 1B
(UNIT -102, 3BHK+3T)

SCALE - AS SHOWN DATE - MARCH.24


OWNER'S SIGN ARCHITECT

ARCHITECTURAL CONSULTANCY
VIJIT & ASSOCIATES
ARCHITECTS, ENGINEERS & PLANNERS
B-1/238, VIKRANT KHAND, GOMTI
NAGAR, LUCKNOW, PH. -0522-4305138




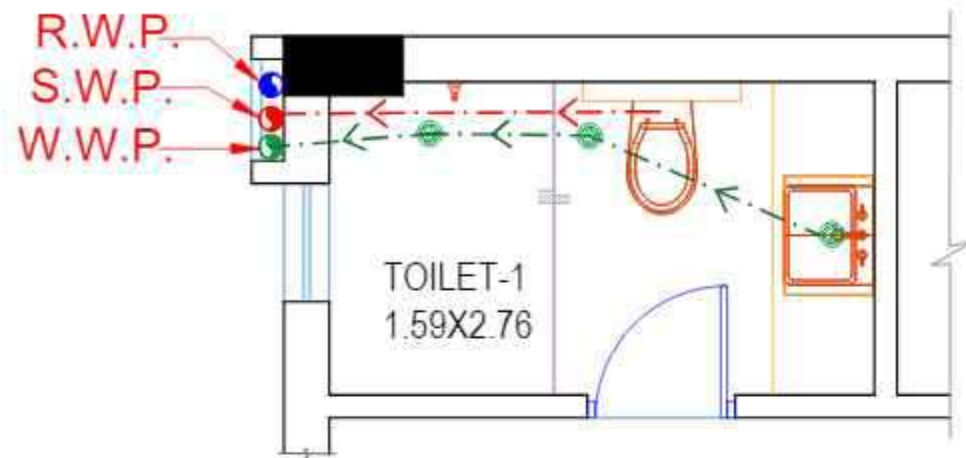


TOILET.-1
(UNIT-102)

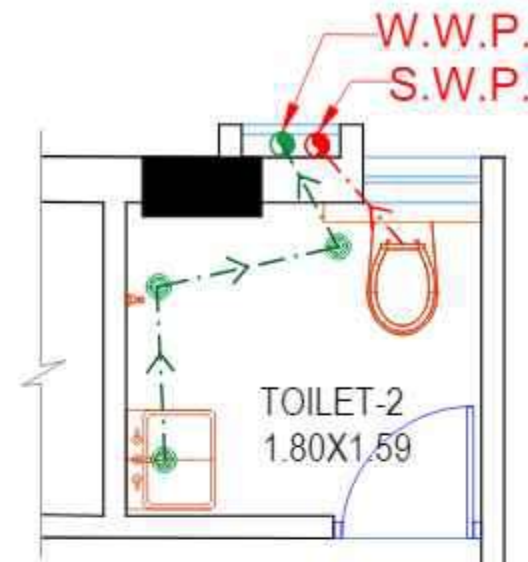

TOILET.-2
(UNIT-102)

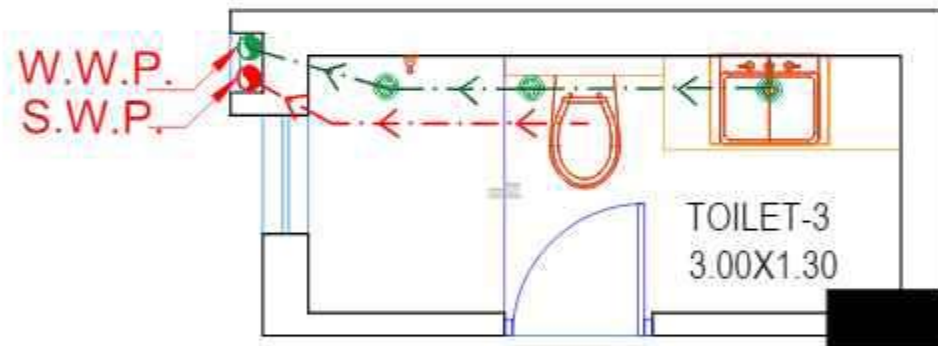

TOILET.-3
(UNIT-102)

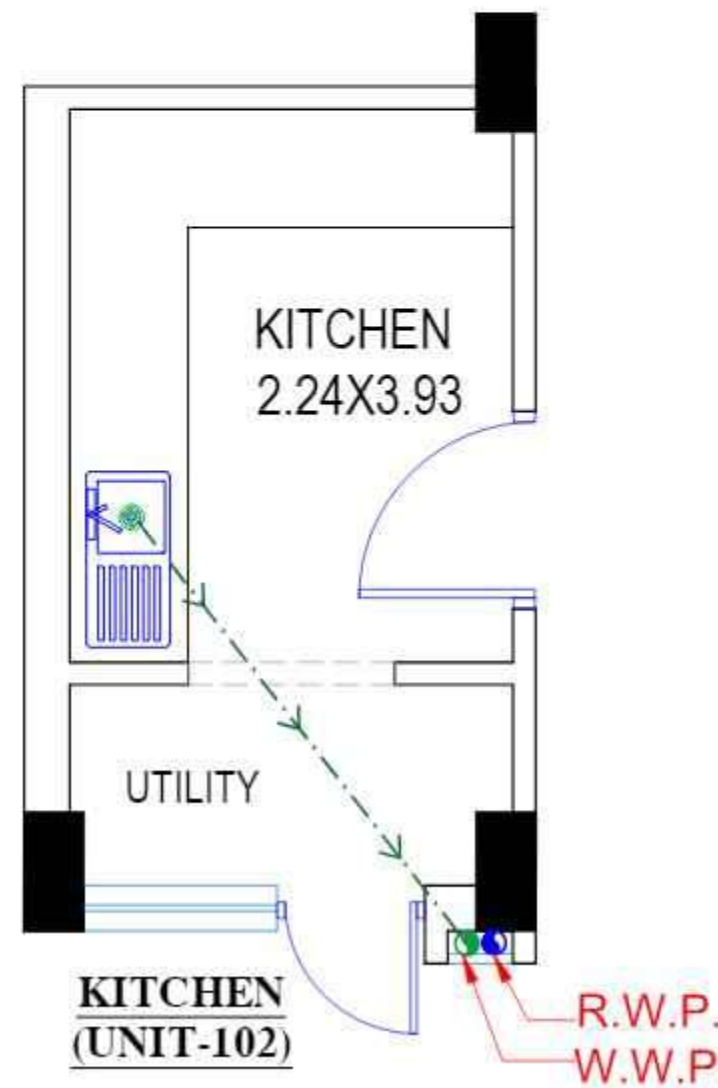

KITCHEN
(UNIT-102)

Project Title :
ADD. / EXTENSION SUBMISSION
DRAWING FOR THE RESIDENTIAL
(BLOCK -1B, ARYAVARTA EMPIRE)
GROUP HOUSING -1
AT SECTOR-F, POCKET -1, SUSHANT
GOLF CITY, HI-TECH TOWNSHIP,
LUCKNOW [U.P.]

OWNER- M/S. AMRIT PLANNERS
PRIVATE LIMITED

LEGEND

	W. W. P.
	S. W. P.
	W. W. P.
	R. W. P.
	S. W. P.

DRG. TITLE

TOWER 1B
(UNIT -102, 3BHK+3T)

SCALE - AS SHOWN


DATE - MARCH.24

OWNER'S SIGN

ARCHITECT

ARCHITECTURAL CONSULTANCY
VIJIT & ASSOCIATES
ARCHITECTS, ENGINEERS & PLANNERS
B-1/238, VIKRANT KHAND, GOMTI
NAGAR, LUCKNOW, PH. - 0522-4305138



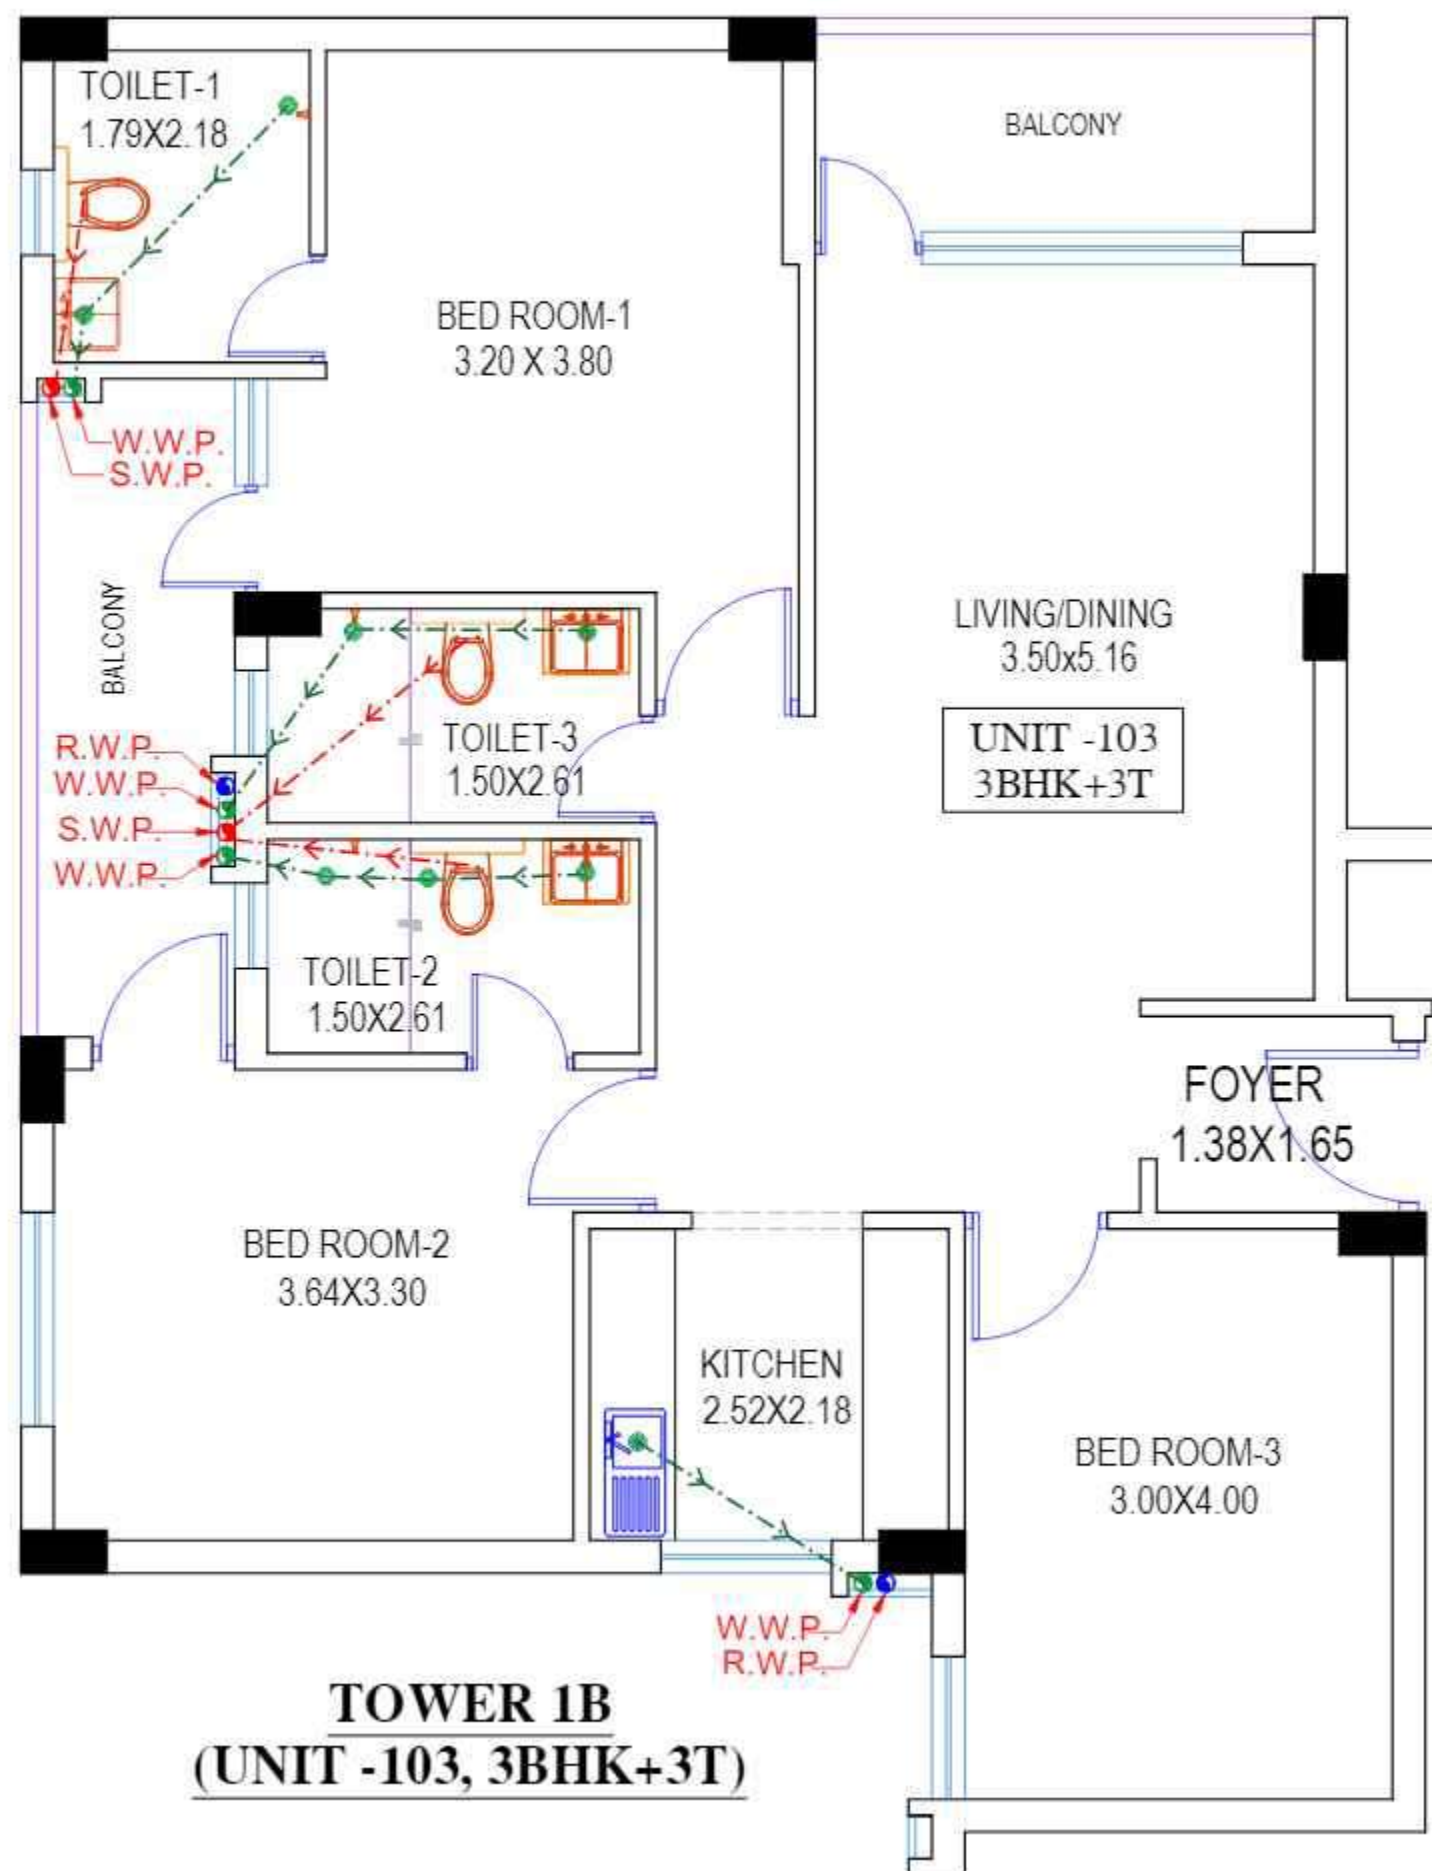

Project Title :
ADD. / EXTENSION SUBMISSION
DRAWING FOR THE RESIDENTIAL
(BLOCK -1B, ARYAVARTA EMPIRE)
GROUP HOUSING -1
AT SECTOR-F, POCKET -1, SUSHANT
GOLF CITY, HI-TECH TOWNSHIP,
LUCKNOW [U.P.]

OWNER- M/S. AMRIT PLANNERS
PRIVATE LIMITED

LEGEND

	W. W. P.
	S. W. P.
	W. W. P.
	R. W. P.
	S. W. P.

DRG. TITLE

TOWER 1B
(UNIT -103, 3BHK+3T)

SCALE - AS SHOWN DATE - MARCH.24

OWNER'S SIGN ARCHITECT

ARCHITECTURAL CONSULTANCY
VIJIT & ASSOCIATES
ARCHITECTS, ENGINEERS & PLANNERS
B-1/238, VIKRANT KHAND, GOMTI
NAGAR, LUCKNOW, PH. - 0522-4305138




Project Title :
ADD. / EXTENSION SUBMISSION
DRAWING FOR THE RESIDENTIAL
(BLOCK -1B, ARYAVARTA EMPIRE)
GROUP HOUSING -1
AT SECTOR-F, POCKET -1, SUSHANT
GOLF CITY, HI-TECH TOWNSHIP,
LUCKNOW [U.P.]


OWNER- M/S. AMRIT PLANNERS
PRIVATE LIMITED

LEGEND


	W. W. P.
	S. W. P.
	W. W. P.
	R. W. P.
	S. W. P.

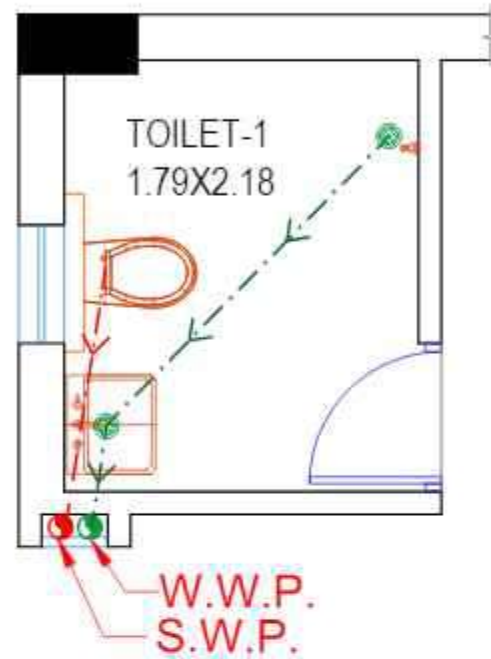


TOILET.-1
(UNIT-103)

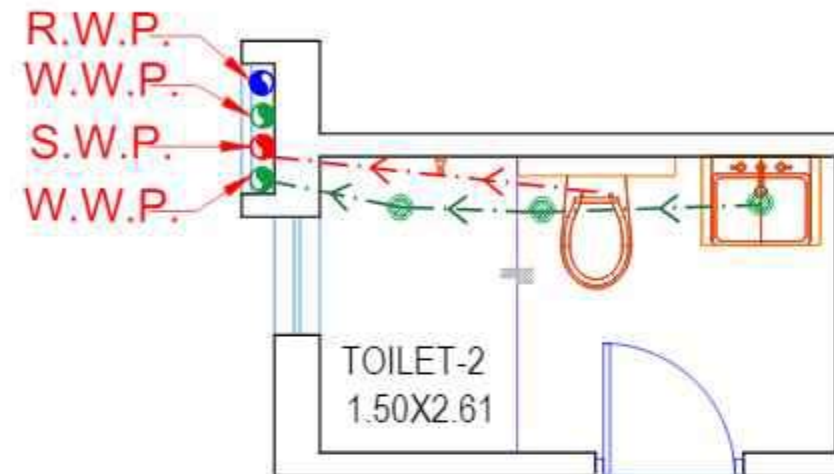

TOILET.-2
(UNIT-103)

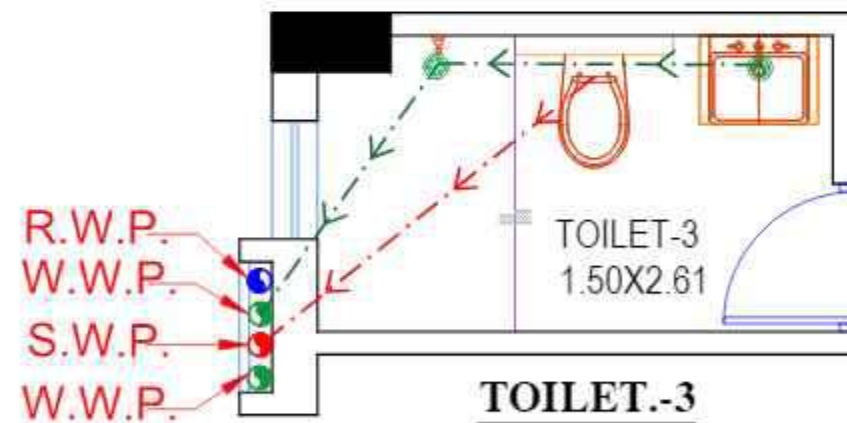

TOILET.-3
(UNIT-103)

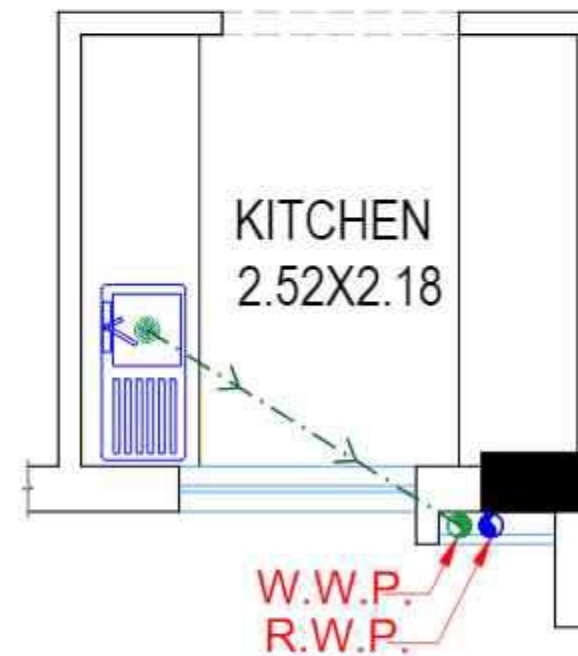

KITCHEN
(UNIT-103)

DRG. TITLE

TOWER 1B
(UNIT -103, 3BHK+3T)

SCALE - AS SHOWN


DATE - MARCH.24

OWNER'S SIGN

ARCHITECT

ARCHITECTURAL CONSULTANCY
VIJIT & ASSOCIATES
ARCHITECTS, ENGINEERS & PLANNERS
B-1/238, VIKRANT KHAND, GOMTI
NAGAR, LUCKNOW, PH. - 0522-4305138



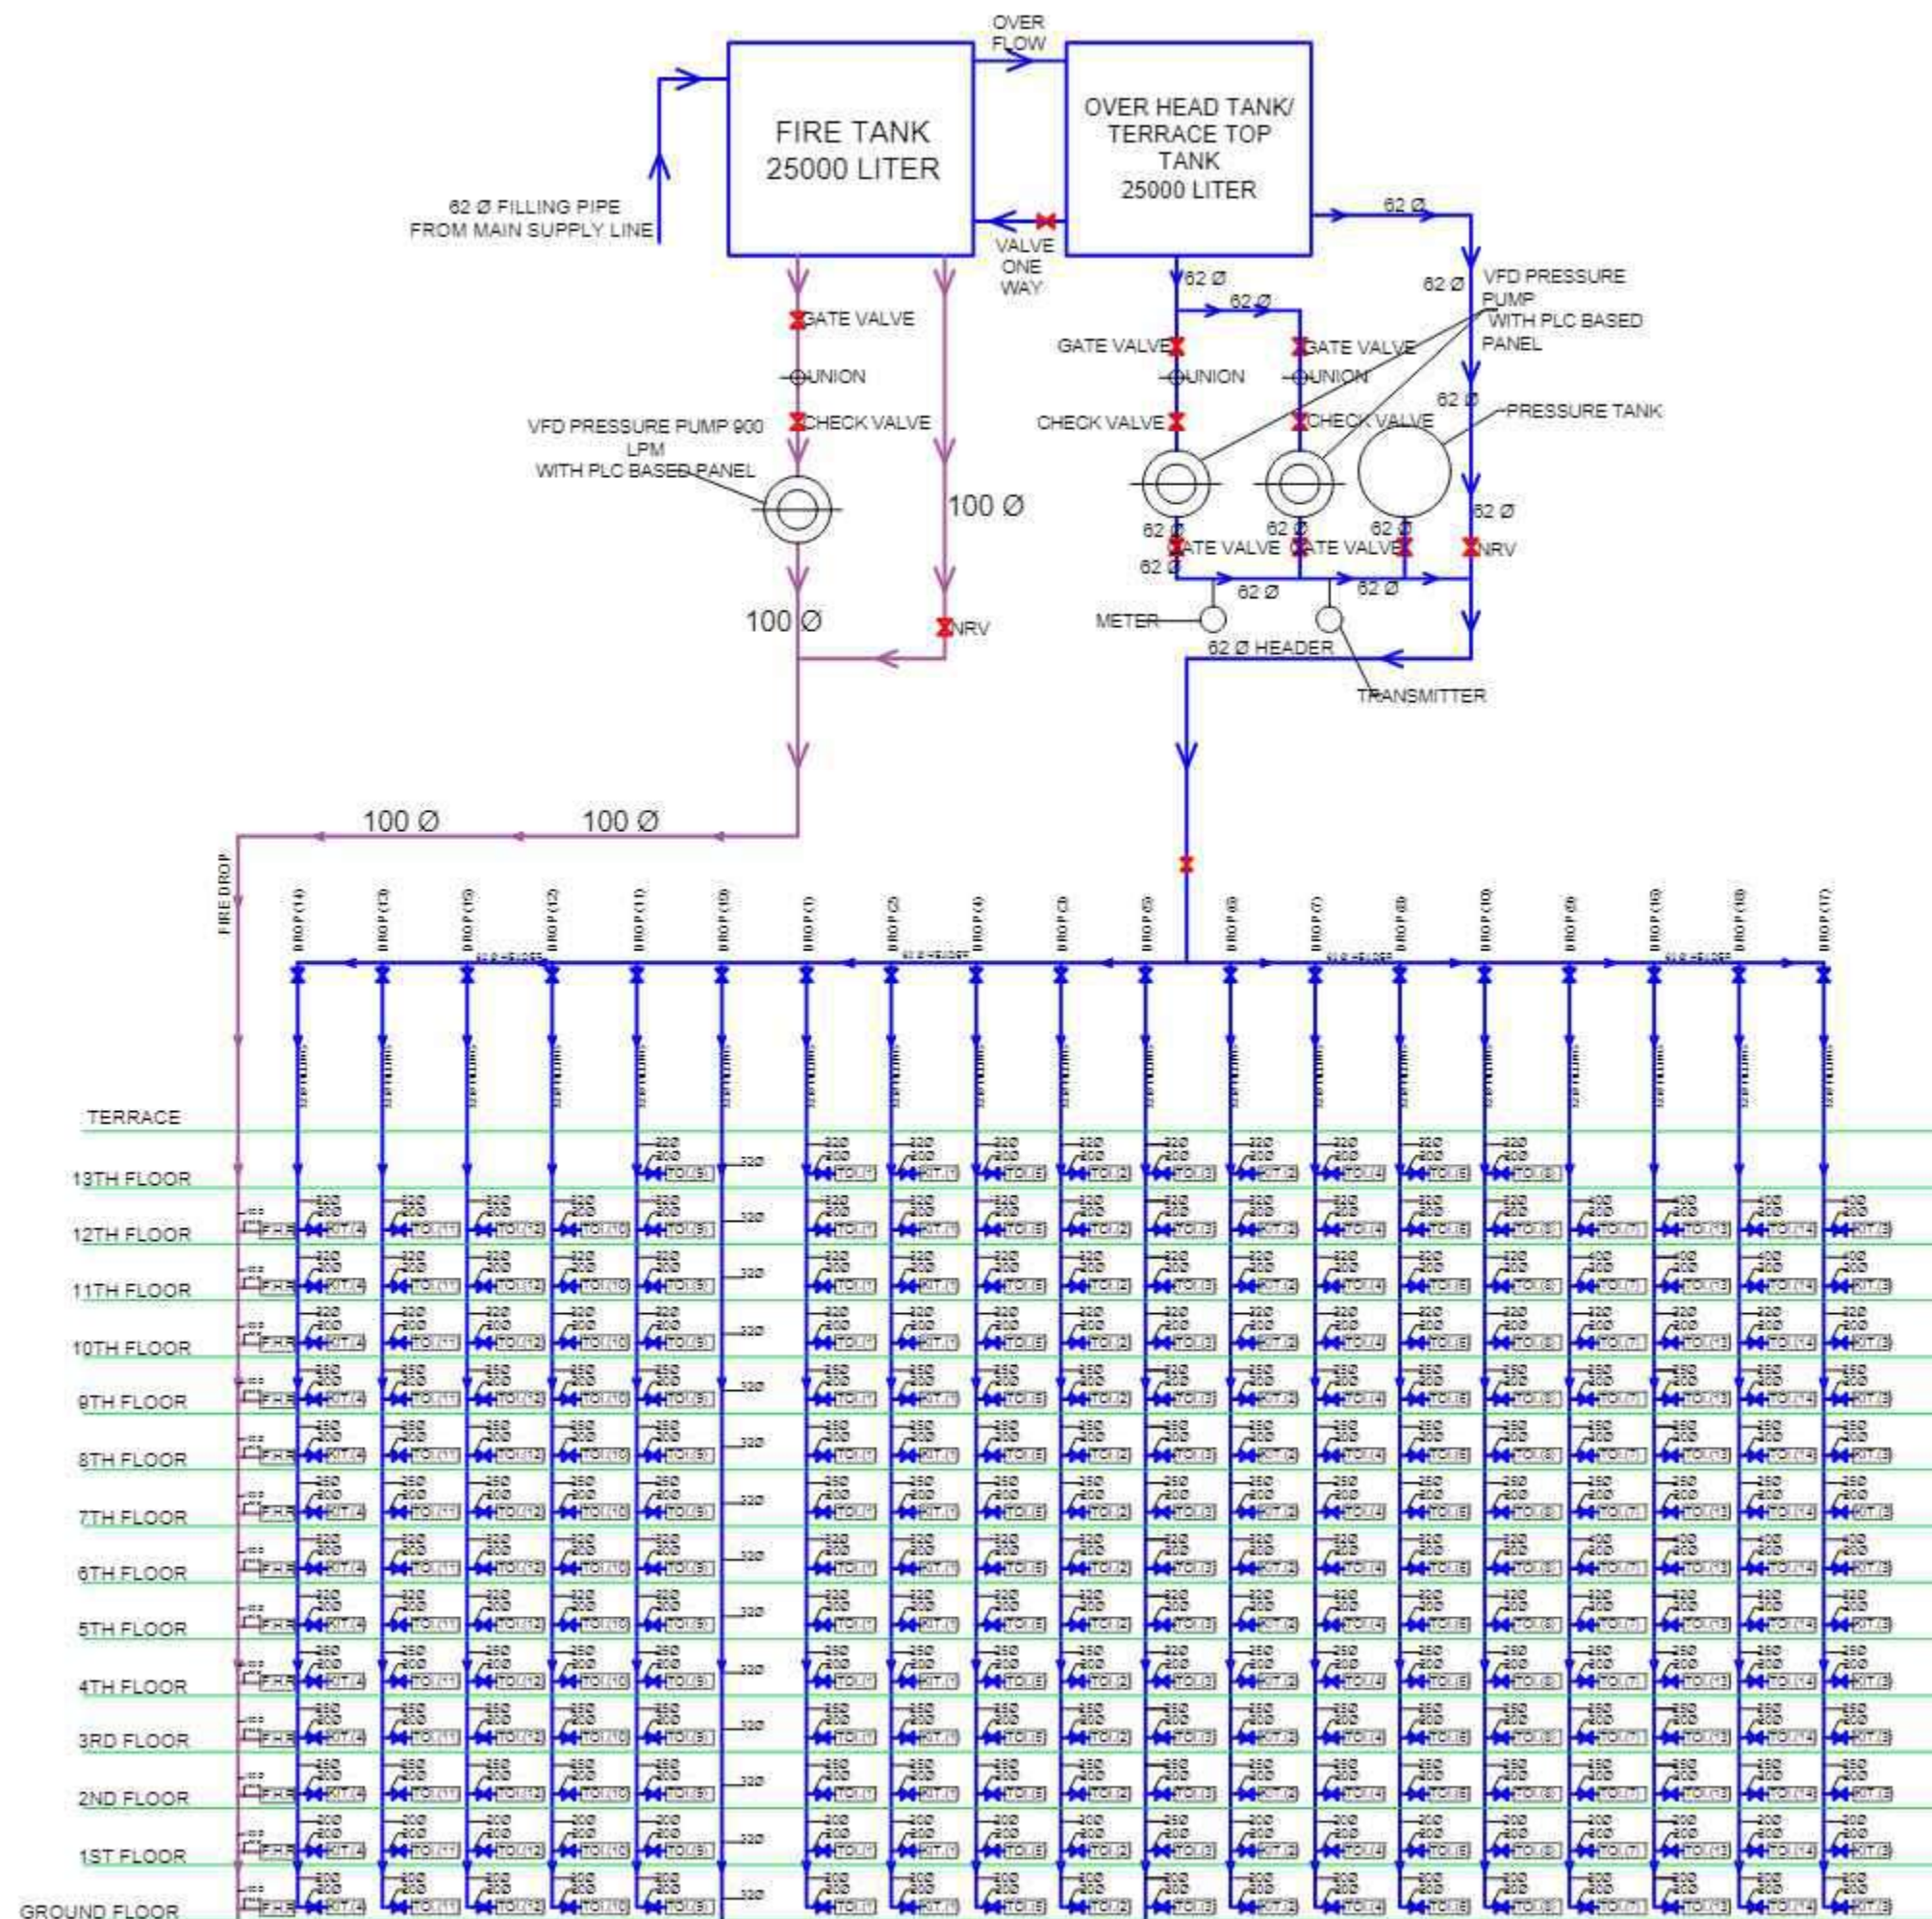

Project Title :
ADD. / EXTENSION SUBMISSION
DRAWING FOR THE RESIDENTIAL
(BLOCK -1B, ARYAVARTA EMPIRE)
GROUP HOUSING -1
AT SECTOR-F, POCKET -1, SUSHANT
GOLF CITY, HI-TECH TOWNSHIP,
LUCKNOW [U.P.]

OWNER- M/S. AMRIT PLANNERS
PRIVATE LIMITED

DRG. TITLE

**SCHEMATIC DIAGRAM FOR
WATER SUPPLY**

SCALE - AS SHOWN


DATE - MARCH 24

OWNER'S SIGN

ARCHITECT

ARCHITECTURAL CONSULTANCY
VIJIT & ASSOCIATES
ARCHITECTS, ENGINEERS & PLANNERS
B-1/238, VIKRANT KHAND, GOMTI
NAGAR, LUCKNOW, PH. - 0522-4305138



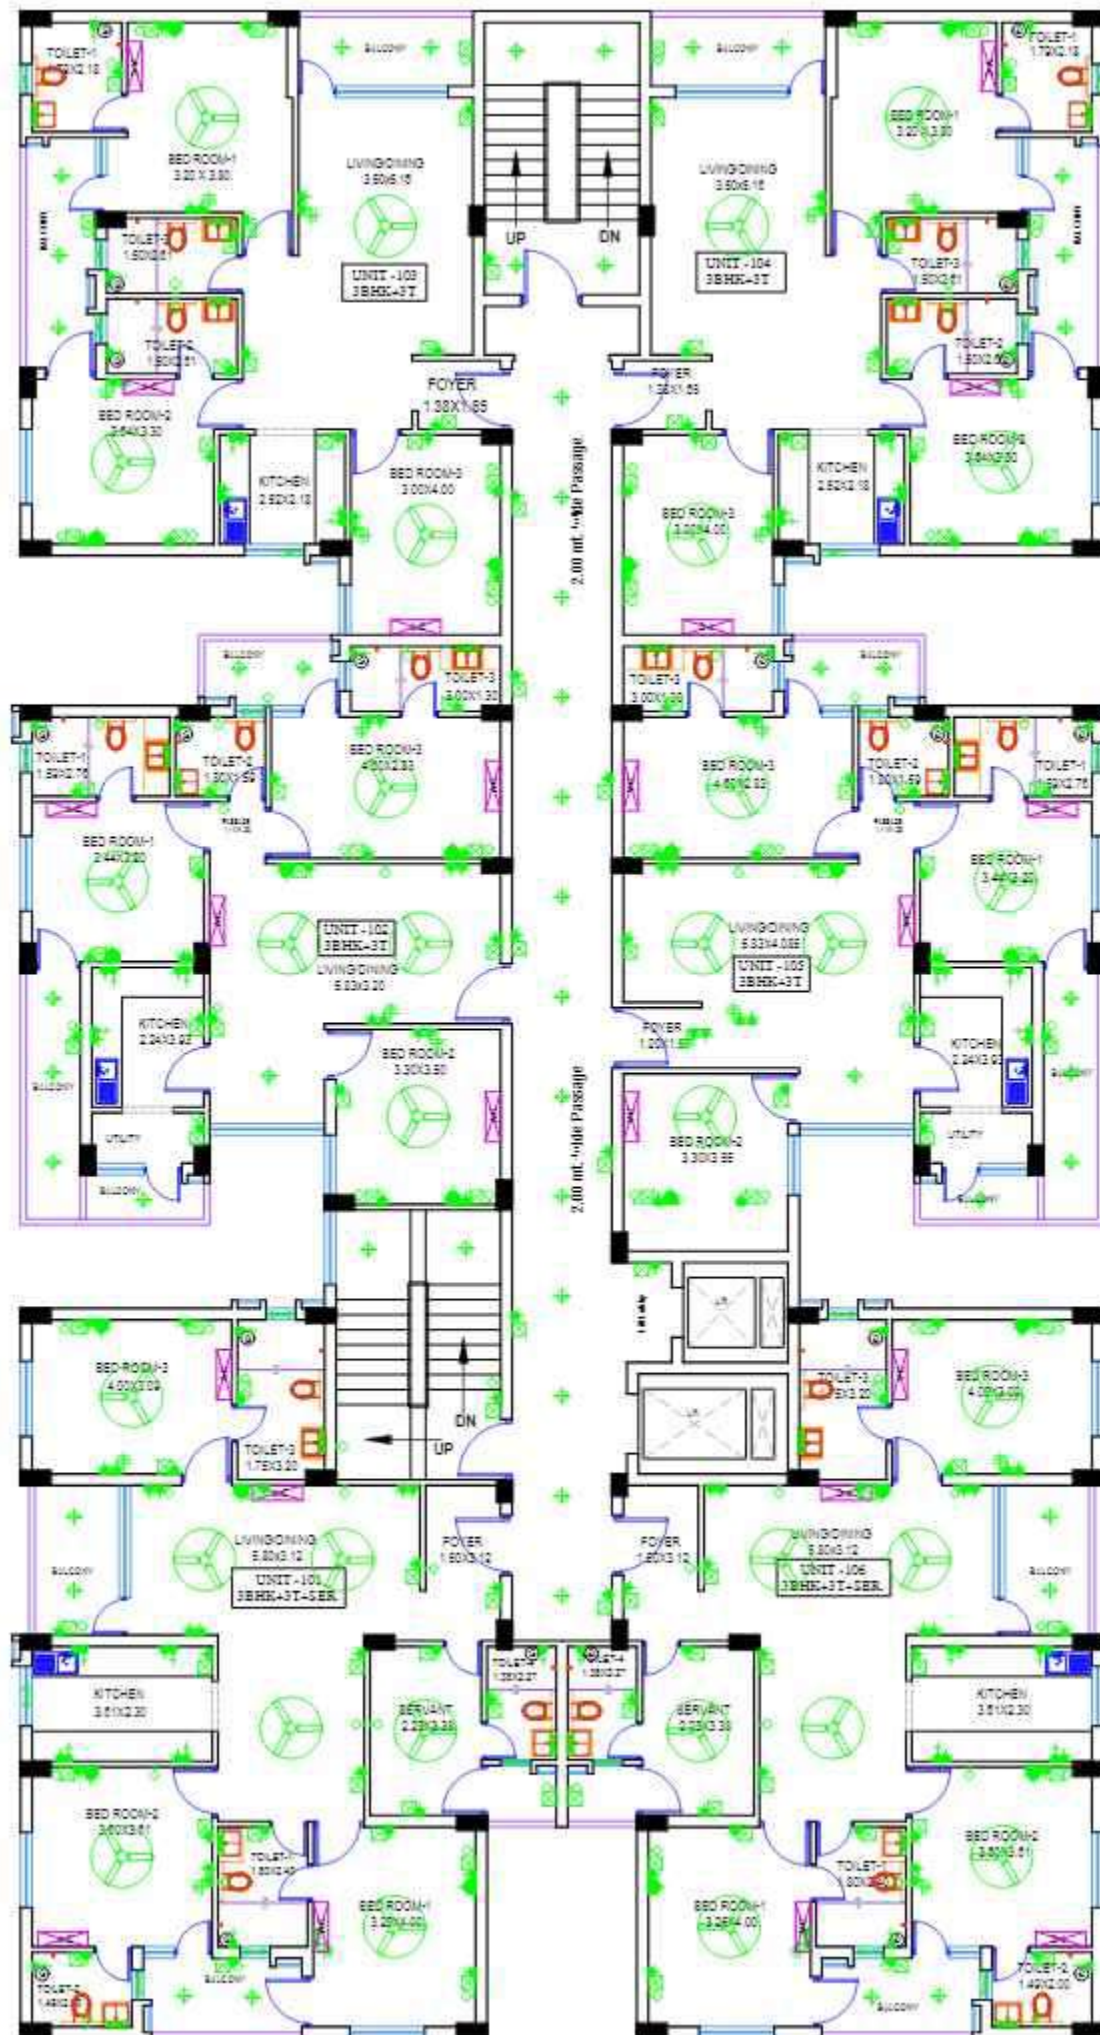

Project Title :
ADD. / EXTENSION SUBMISSION
DRAWING FOR THE RESIDENTIAL
(BLOCK -1B, ARYAVARTA EMPIRE)
GROUP HOUSING -1
AT SECTOR-F, POCKET -1, SUSHANT
GOLF CITY, HI-TECH TOWNSHIP,
LUCKNOW [U.P.]

OWNER- M/S. AMRIT PLANNERS
PRIVATE LIMITED

LEGEND : (Electrical)

S. No.	SYMBOL	DESCRIPTION	POSITION
1.		LIGHT POINT/WALL BRACKET	
2.		EXHAUST FAN	
3.		POWER POINT (6 AMP)	
4.		POWER POINT (6/16 AMP)	
5.		A/C POINT	
6.		T.V. POINT	
7.		SWITCH BOARD WITH SOCKET	
8.		M.C.B.	
9.		CALL BELL	
10.		PUSH BUTTON	
11.		MIRROR LIGHTS	
12.		CEILING LIGHT (SURFACE)	
13.		CEILING FAN	
14.		CEILING EXHAUST FAN	

DRG. TITLE



**TOWER 1B
(ELECTRICAL PLAN)**

SCALE - AS SHOWN DATE - MARCH.24

OWNER'S SIGN ARCHITECT

ARCHITECTURAL CONSULTANCY
VIJIT & ASSOCIATES
ARCHITECTS, ENGINEERS & PLANNERS
B-1/238, VIKRANT KHAND, GOMTI
NAGAR, LUCKNOW. PH. - 0522-4305138



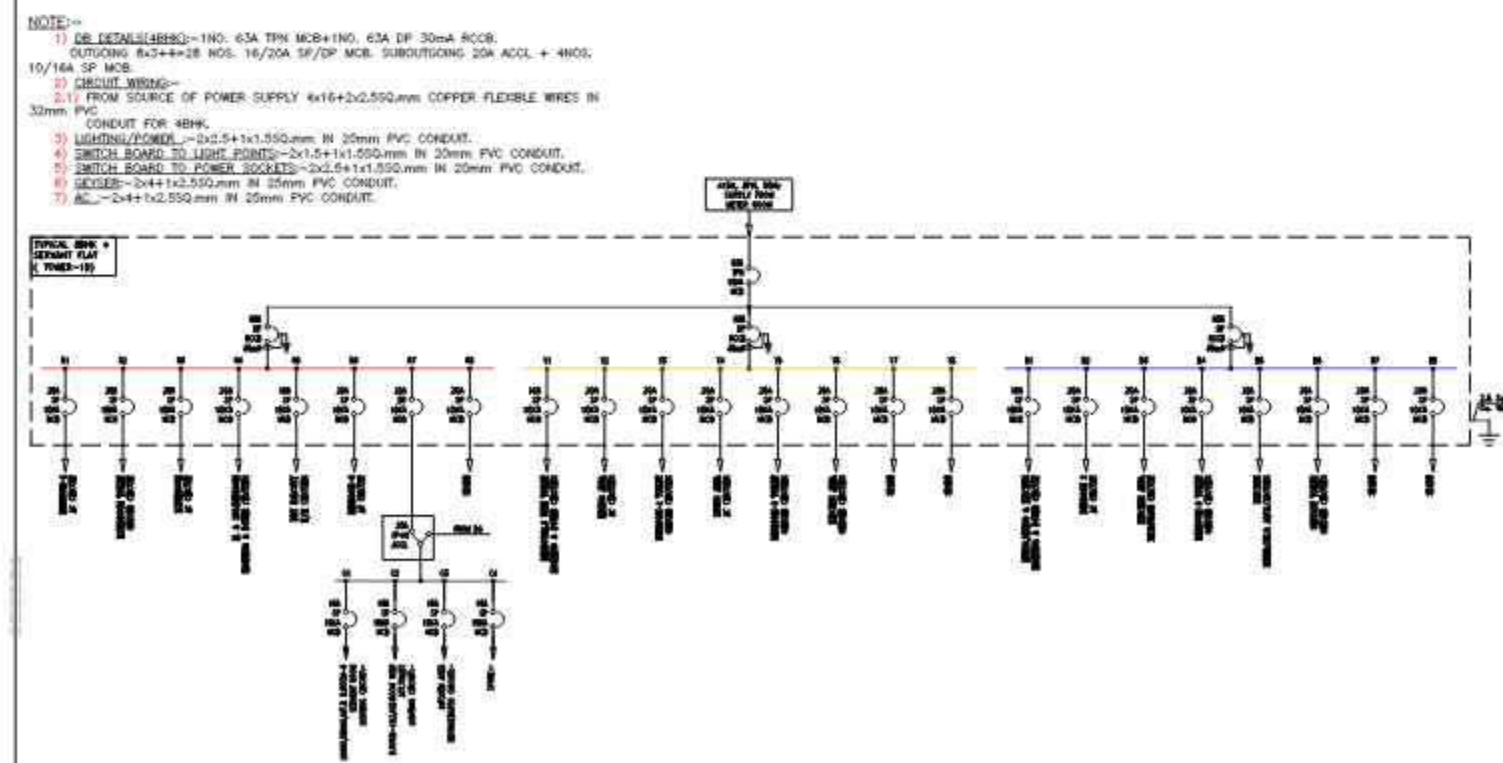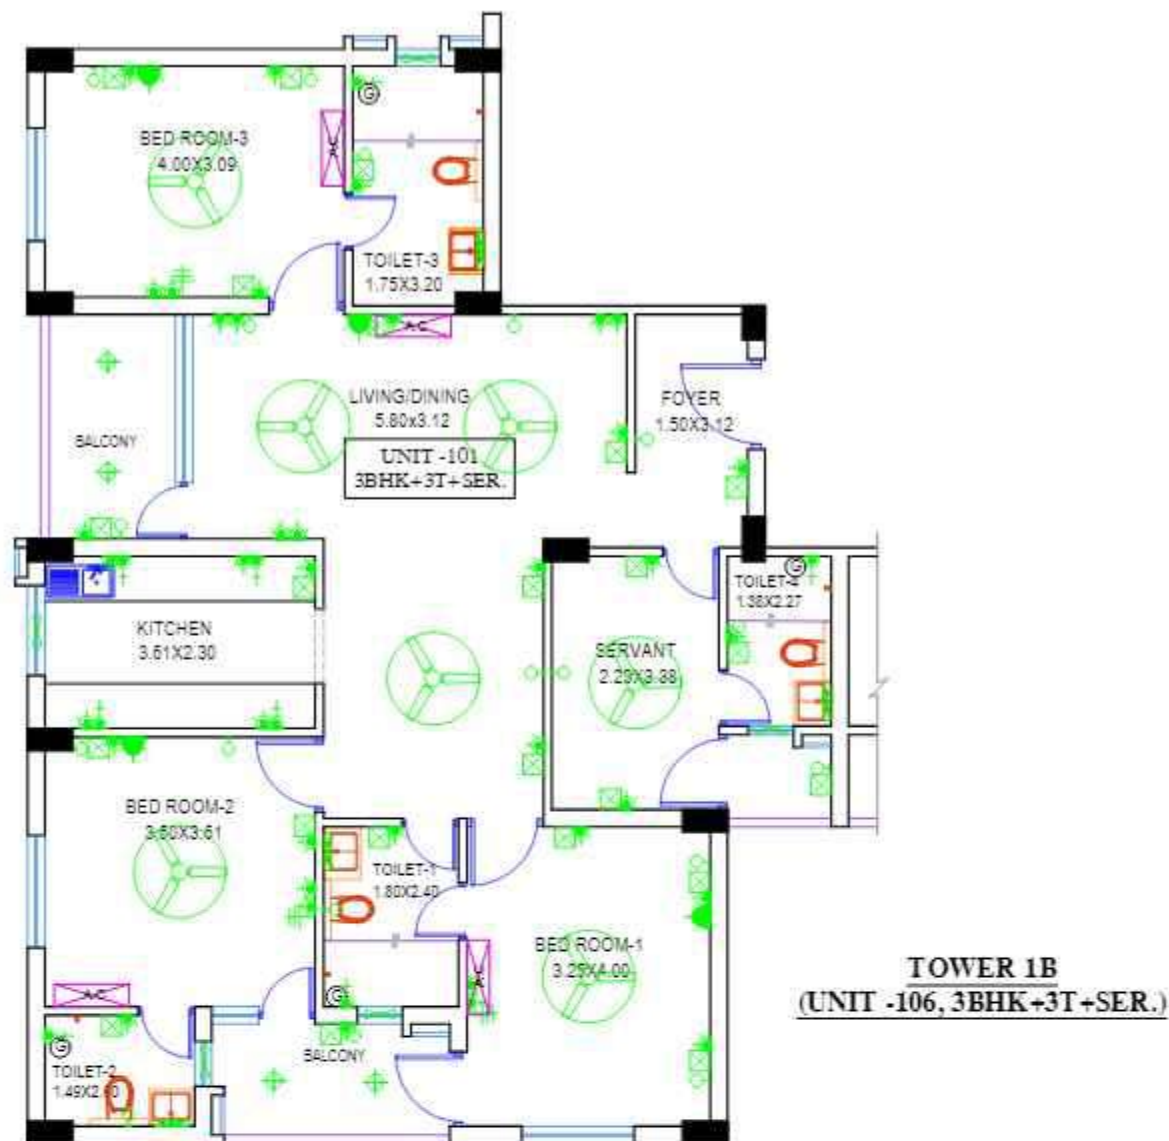

Project Title :
ADD. / EXTENSION SUBMISSION
DRAWING FOR THE RESIDENTIAL
(BLOCK -1B, ARYAVARTA EMPIRE)
GROUP HOUSING -1
AT SECTOR-F, POCKET -1, SUSHANT
GOLF CITY, HI-TECH TOWNSHIP,
LUCKNOW [U.P.]

OWNER- M/S. AMRIT PLANNERS
PRIVATE LIMITED

DRG. TITLE


TOWER 1B
(UNIT -101, 3BHK+3T+SER.)
ELECTRICAL PLAN

SCALE - AS SHOWN DATE - MARCH.24

OWNER'S SIGN ARCHITECT


ARCHITECTURAL CONSULTANCY
VIJIT & ASSOCIATES
ARCHITECTS, ENGINEERS & PLANNERS
B-1/236, VIKRANT KHAND, GOMTI
NAGAR, LUCKNOW, PH. - 0522-4305138



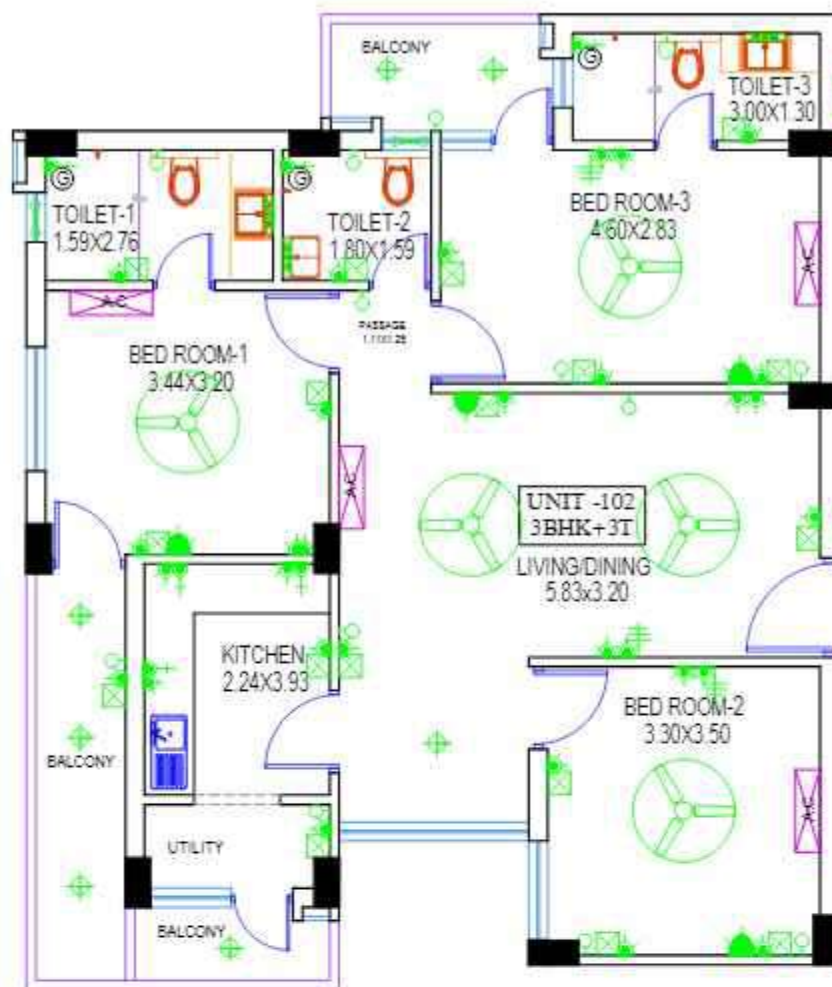

**TOWER 1B
(UNIT -102, 3BHK+3T)**

- NOTE:-**
- 1) DB DETAILS (4BHK):- 1NO. 63A TPN MCB+1NO. 63A DP 30mA RCCB. OUTGOING 8x3+4=28 NOS. 16/20A SP/DP MCB. SUBOUTGOING 20A ACCL + 4NOS. 10/16A SP MCB.
 - 2) CIRCUIT WIRING:-
 - 3) FROM SOURCE OF POWER SUPPLY 4x10+2x2.5sq.mm COPPER FLEXIBLE WIRES IN 32mm PVC CONDUIT FOR 48HK.
 - 4) LIGHTING/POWER:- 2x2.5+1x1.5sq.mm IN 20mm PVC CONDUIT.
 - 5) SWITCH BOARD TO LIGHT POINTS:- 2x1.5+1x1.5sq.mm IN 20mm PVC CONDUIT.
 - 6) SWITCH BOARD TO POWER SOCKETS:- 2x2.5+1x1.5sq.mm IN 20mm PVC CONDUIT.
 - 7) CECES:- 2x4+1x2.5sq.mm IN 25mm PVC CONDUIT.
 - 8) E.L.U:- 2x4+1x2.5sq.mm IN 25mm PVC CONDUIT.

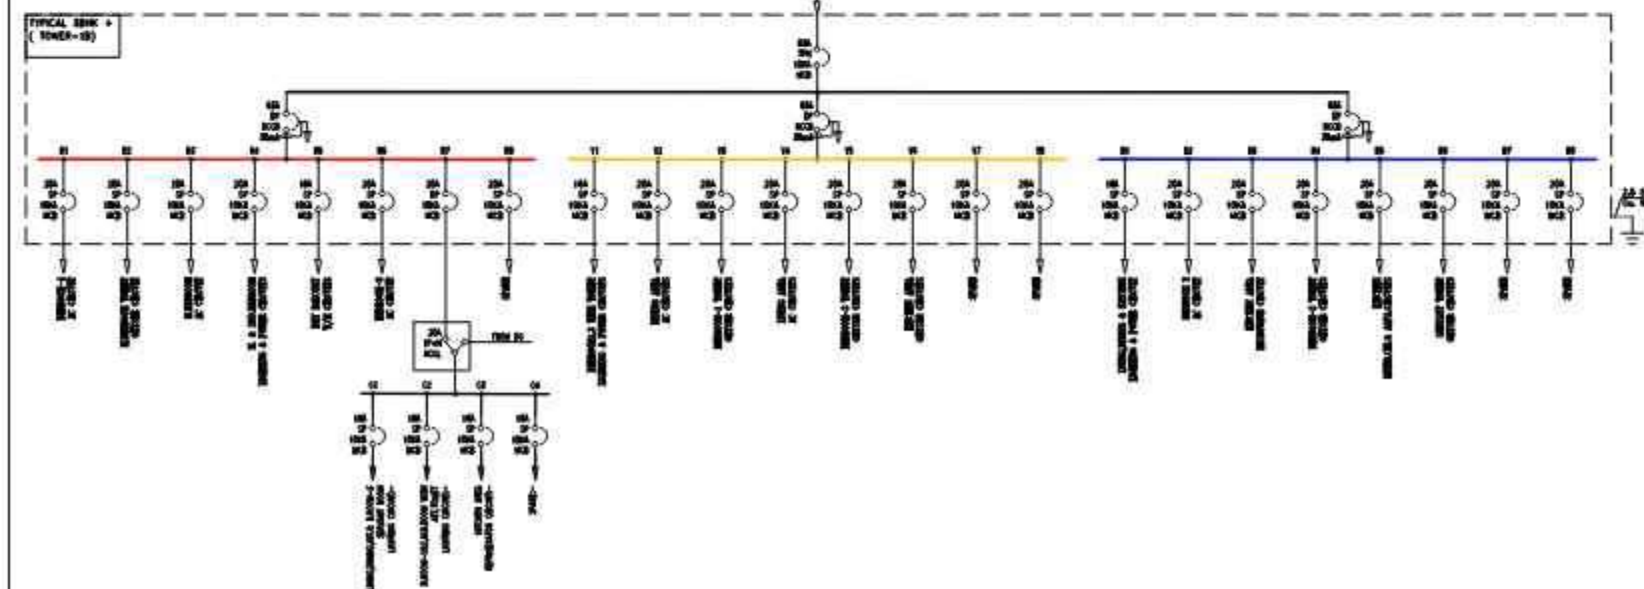

Project Title :
ADD. / EXTENSION SUBMISSION
DRAWING FOR THE RESIDENTIAL
(BLOCK -1B, ARYAVARTA EMPIRE)
GROUP HOUSING -1
AT SECTOR-F, POCKET -1, SUSHANT
GOLF CITY, HI-TECH TOWNSHIP,
LUCKNOW [U.P.]

OWNER- M/S. AMRIT PLANNERS
PRIVATE LIMITED

LEGEND : (Electrical)			
S. No.	SYMBOL	DESCRIPTION	POSITION
1.		LIGHT POINT/WALL BRACKET	
2.		EXHAUST FAN	
3.		POWER POINT (6 AMP)	
4.		POWER POINT (6 /16 AMP)	
5.		A/C POINT	
6.		T.V. POINT	
7.		SWITCH BOARD WITH SOCKET	
8.		M.C.B.	
9.		CALL BELL	
10.		PUSH BUTTON	
11.		MIRROR LIGHT	
12.		CEILING LIGHT (SURFACE)	
13.		CEILING FAN	
14.		CEILING EXHAUST FAN	

DRG. TITLE

**TOWER 1B
(UNIT -102, 3BHK+3T)
ELECTRICAL PLAN**

SCALE - AS SHOWN DATE - MARCH.24

OWNER'S SIGN ARCHITECT

ARCHITECTURAL CONSULTANCY
VIJIT & ASSOCIATES
ARCHITECTS, ENGINEERS & PLANNERS
B-1/236, VIKRANT KHAND, GOMTI
NAGAR, LUCKNOW, PH. - 0522-4305138

