



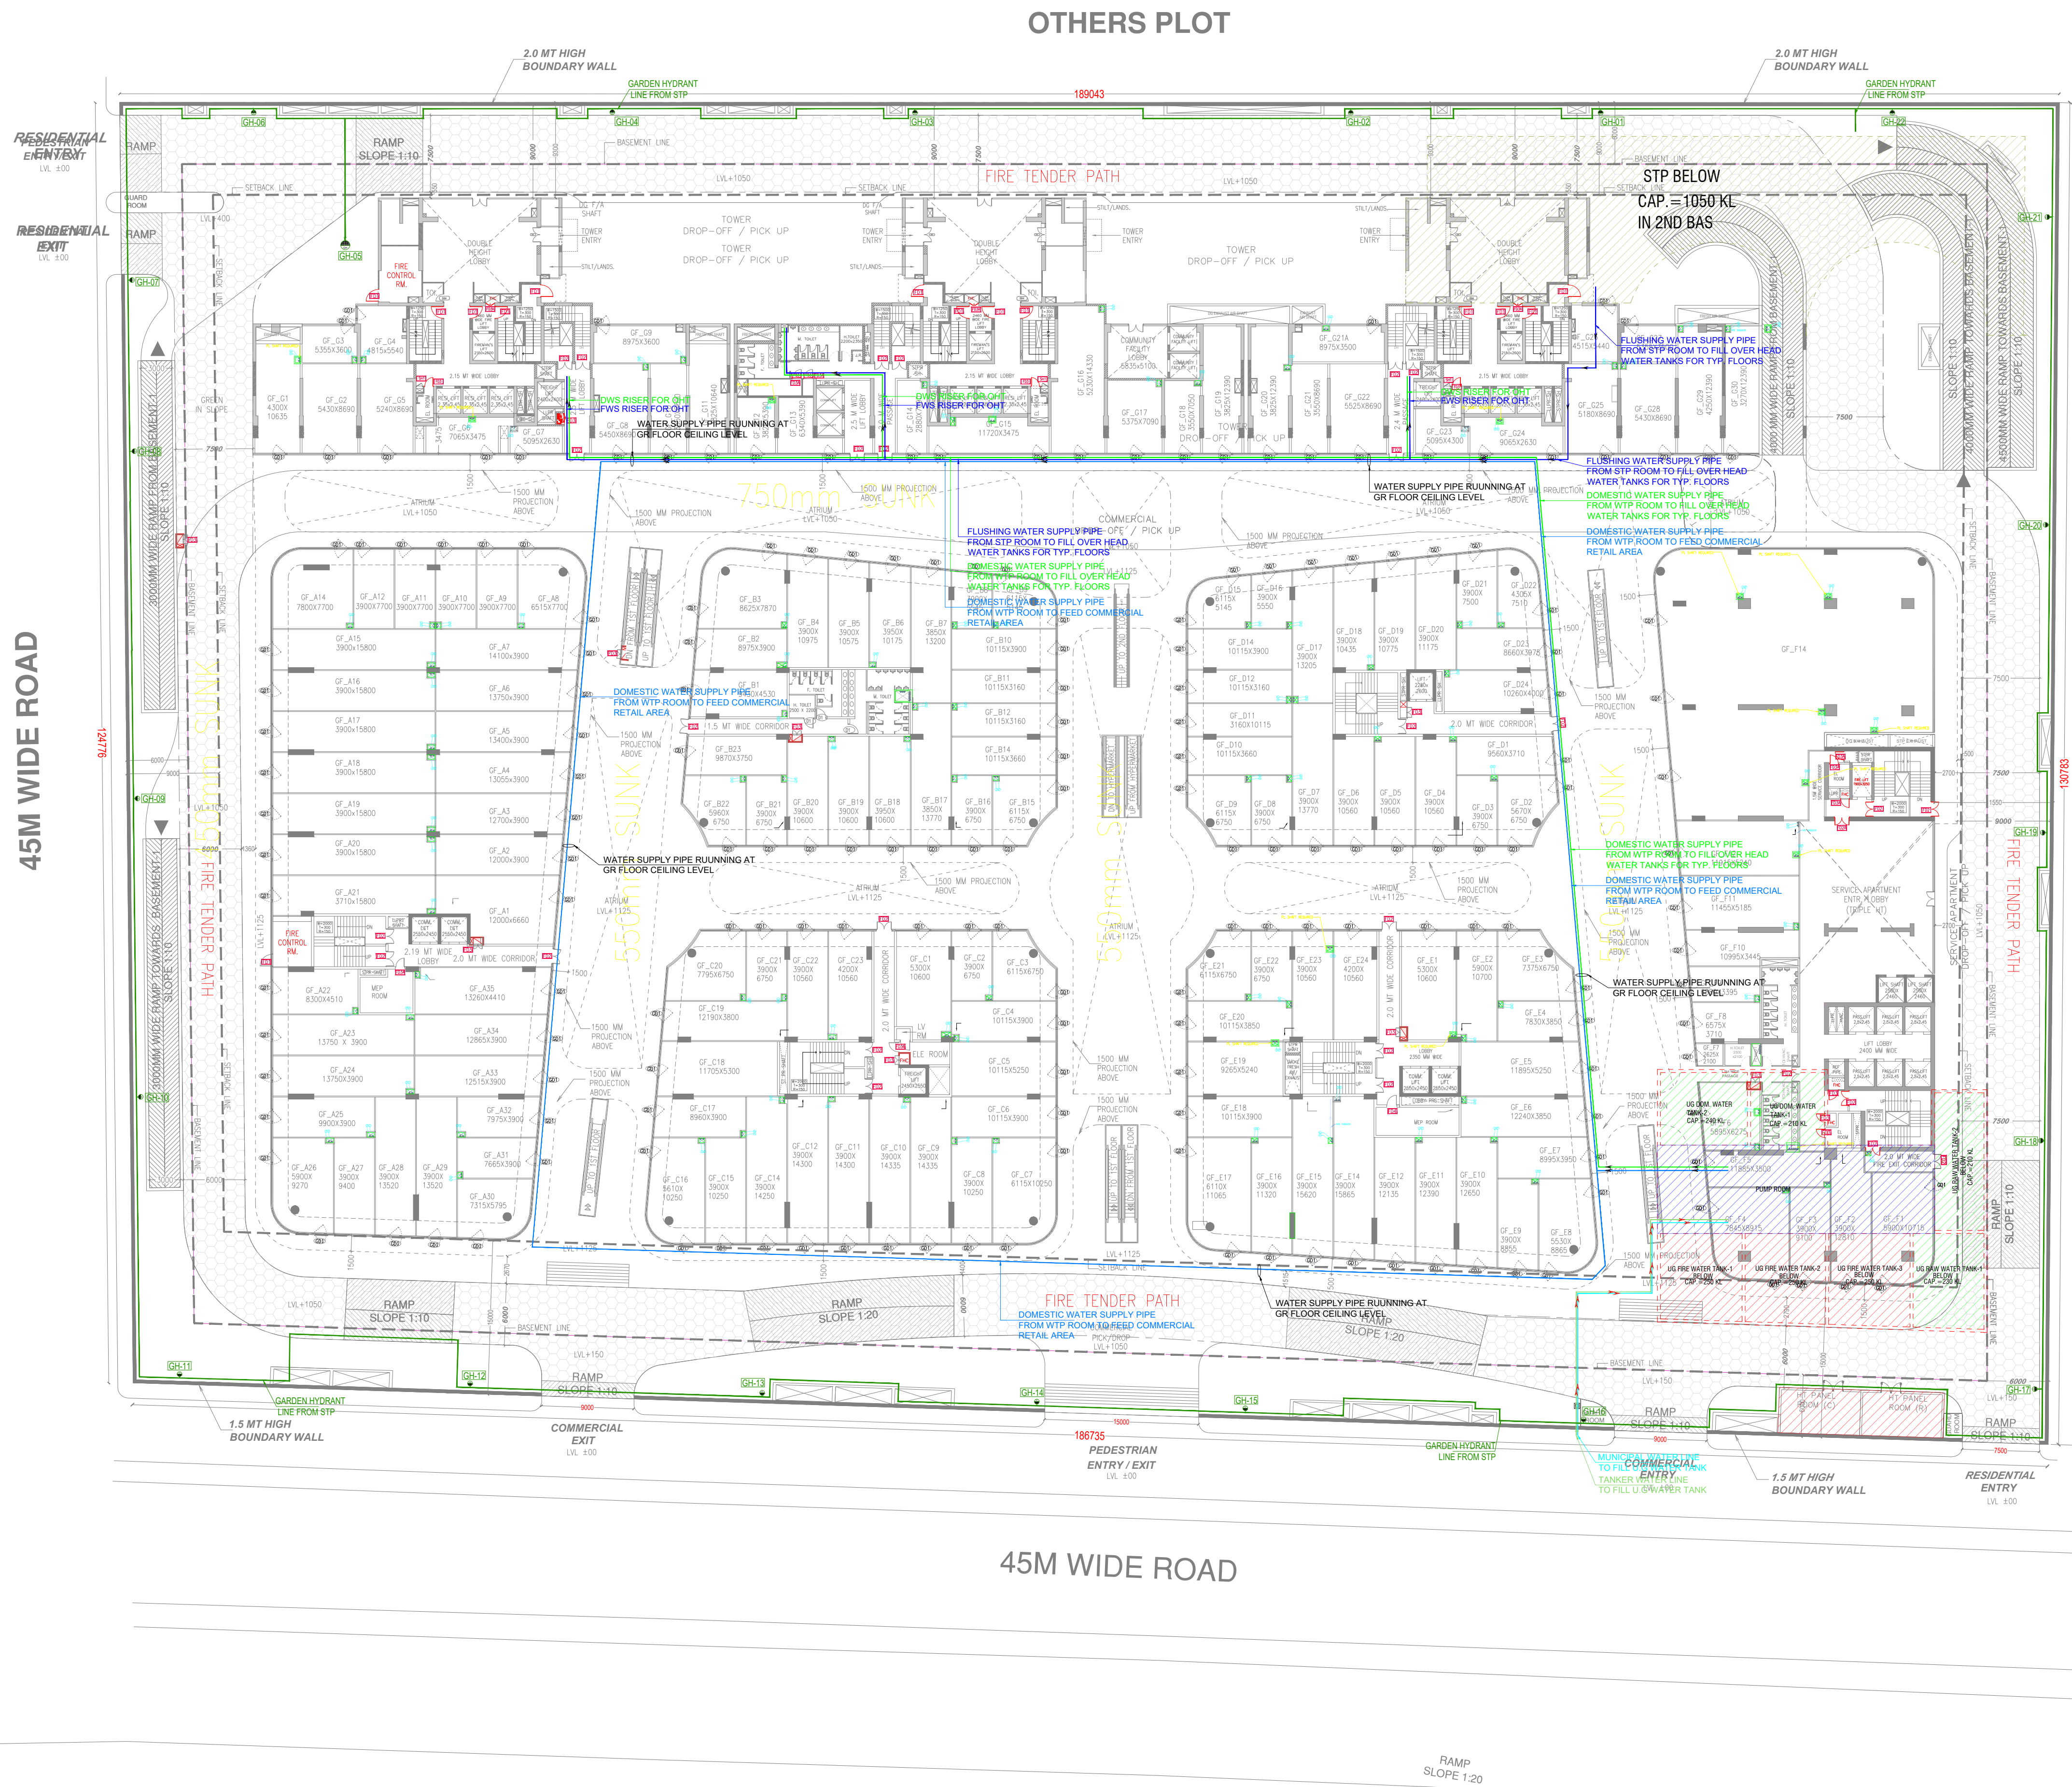

H-8

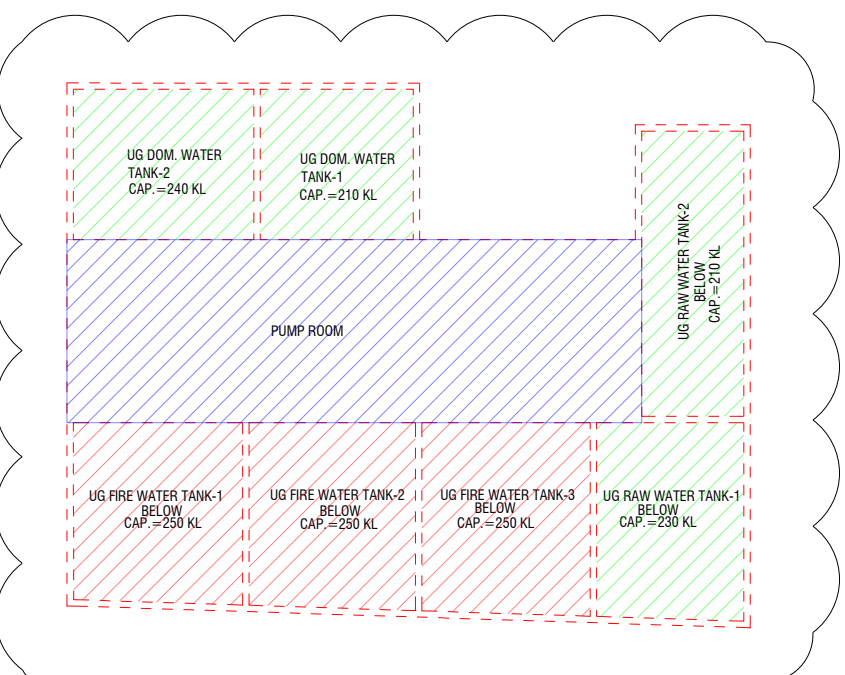

IN 1ST BASEMENT
FIRE WATER TANK
CAP. 250+250+250=750 KL
RAW WATER TANK
CAP. 230+210=440 KL
DOMESTIC WATER TANK
CAP.= 240+210= 250KL

OTHERS PLOT

NOTE :-

1. BUILDING HAS AUTOMATIC SPRINKLER SYSTEM WHEREVER REQUIRED BY NBC

2. BUILDING WILL BE DESIGNED (STRUCTURES) AS PER RELEVANT IS CODES FOR EARTH QUAKE RESISTANCE

3. 100% POWER BACKUP/ MECHANICAL VENTILATED SHAFTS

KEY PLAN

LEGEND

—	PLOT BOUNDARY
—	BASEMENT LINE
—	SETBACK LINE

PROJECT

FIRE APPROVAL OF BUILDING PLAN OF KLU PROJECT SMARTWORLD ELITE SAAB AT PLOT NO H-7, SECTOR-98, NOIDA

FOR M/S BLITZBAY DEVELOPERS PRIVATE LIMITED

ARCHITECTS

STUDIO SYMBIOSIS

India | Germany | UK

INDIA
1301, Tower-E, Skymark One
Sector 98, Noida, U.P. 201301, Noida
TEL: +91 0120 4226979
E-MAIL: info@studio-symbiosis.com
www.studio-symbiosis.com

ARCHITECT'S SEAL & SIGNATURE

OWNER'S SEAL & SIGNATURE

ARCHITECT'S SEAL & SIGNATURE

SEP 2025	Scale :-	Drawing No.-
Drawing Title:-		
PL GROUND FLOOR PLAN(WATER SUPPLY)		