


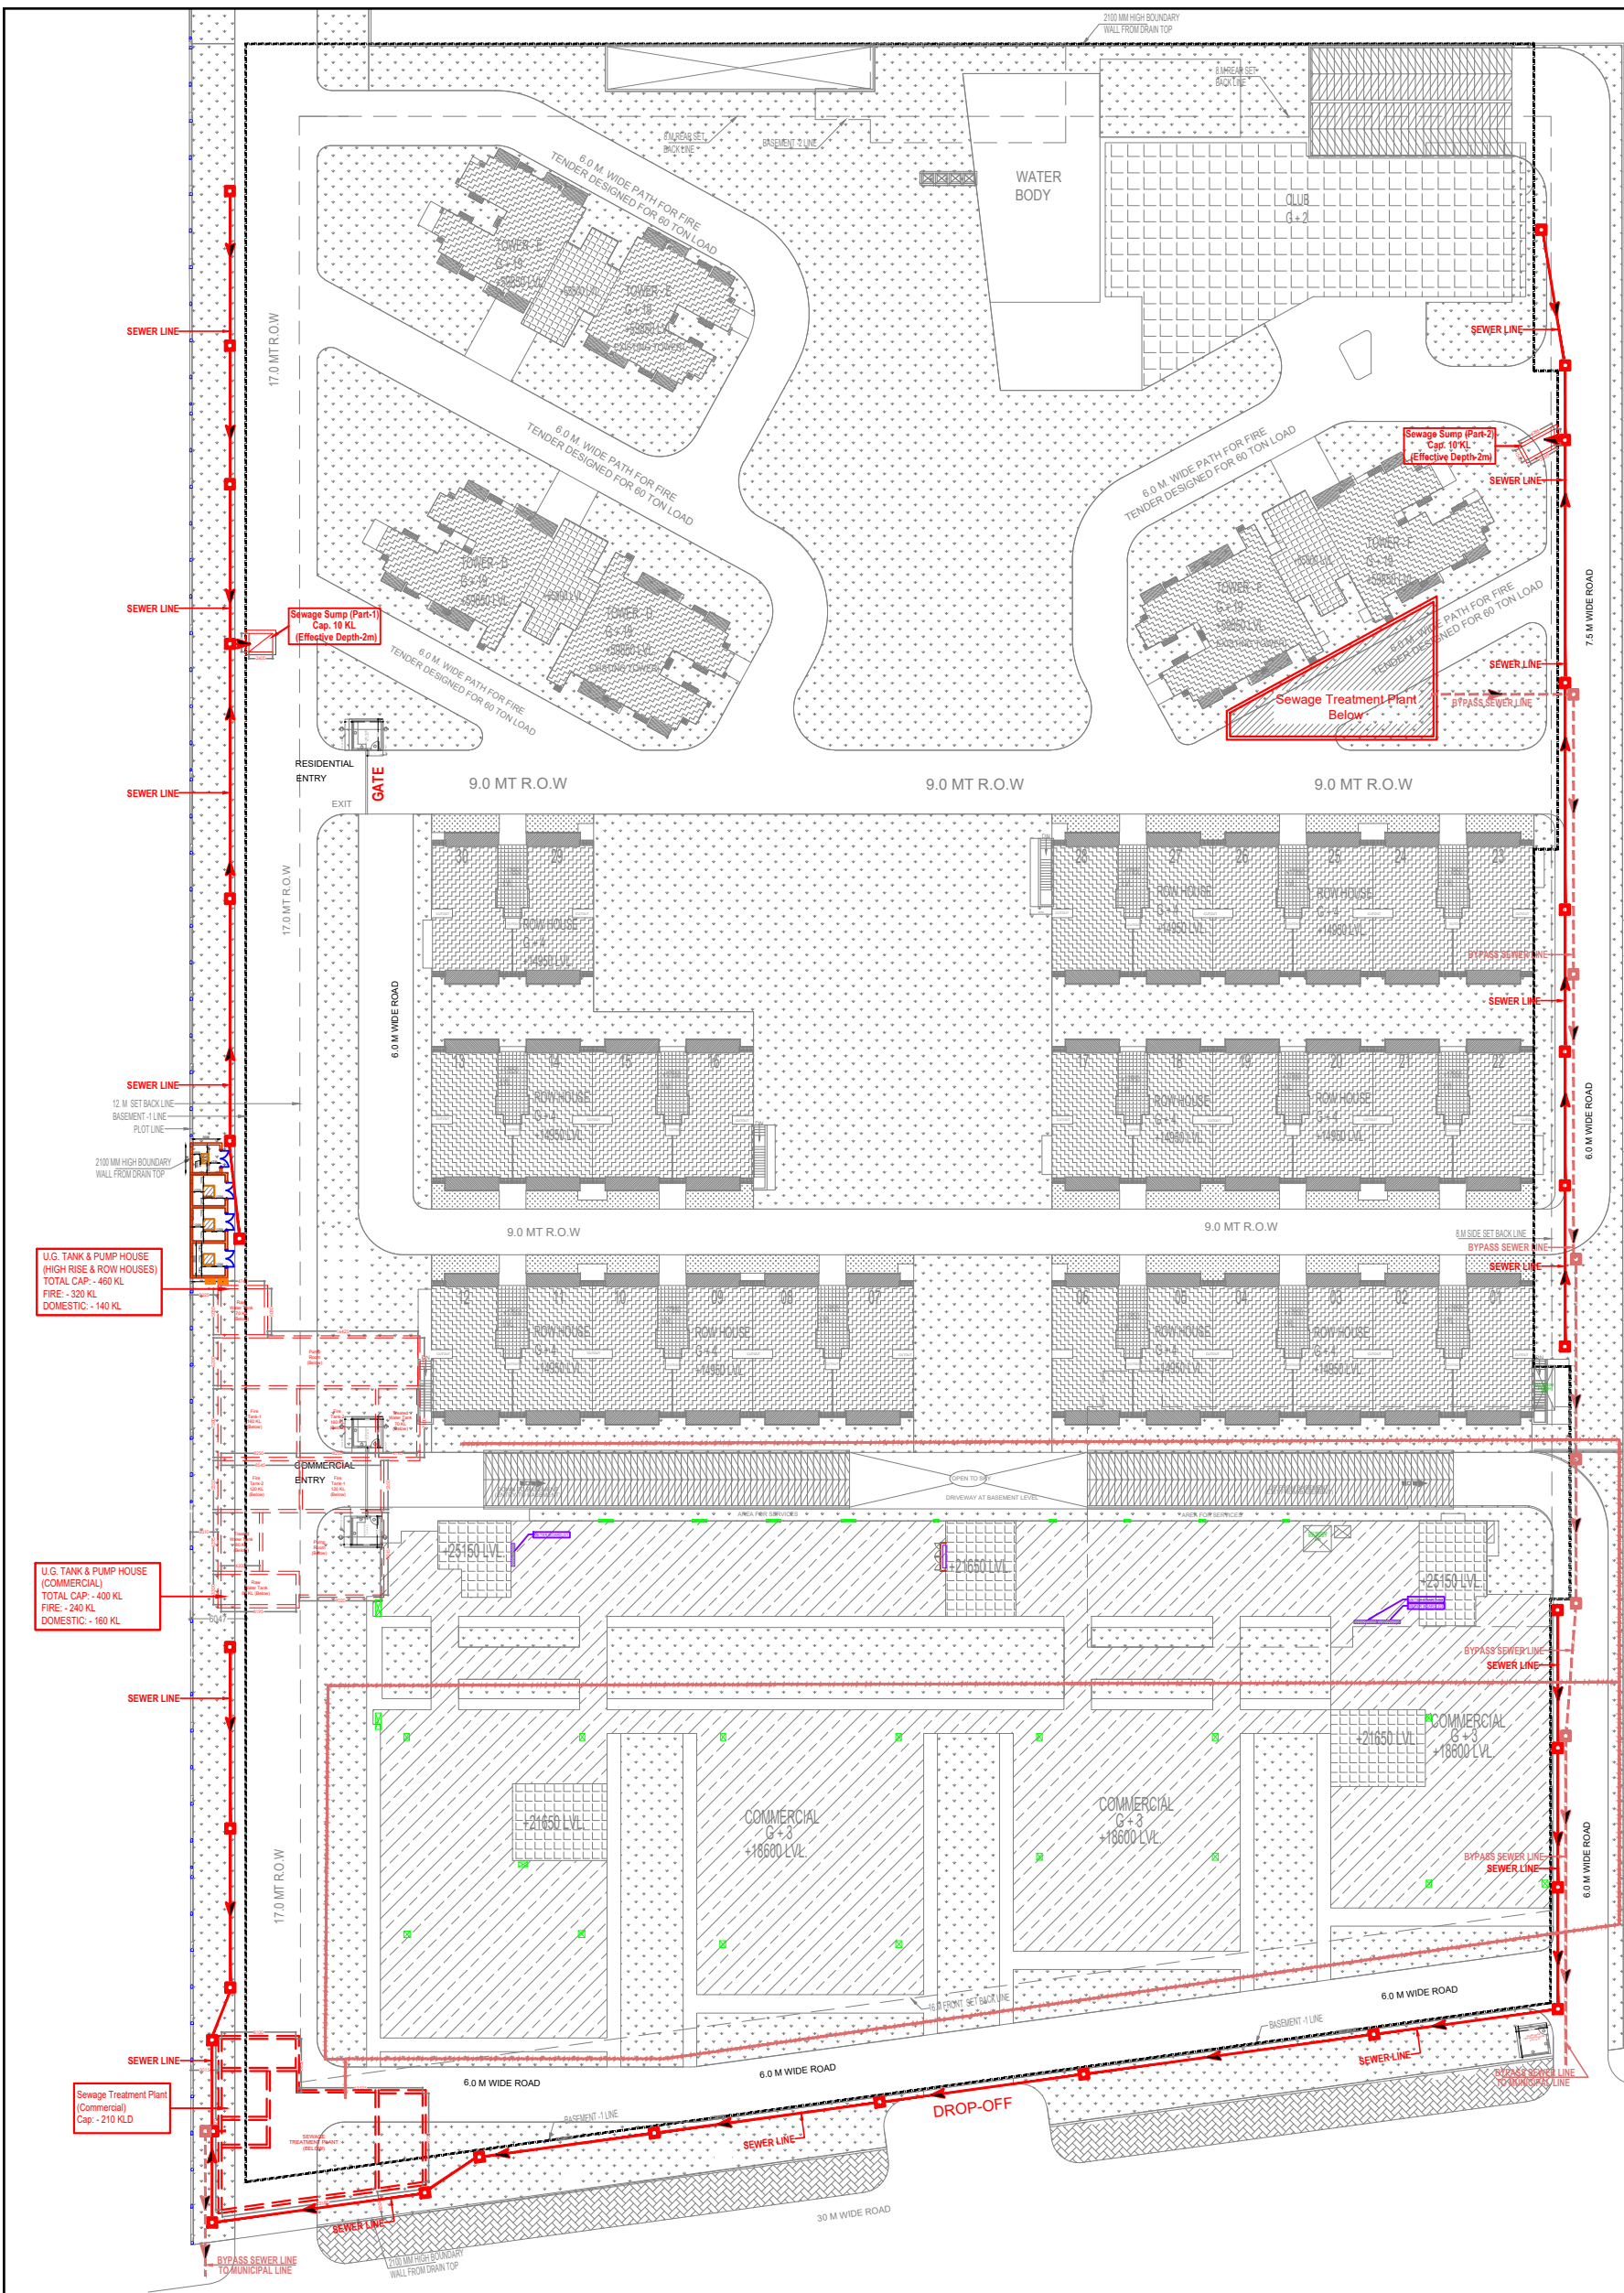

LEGEND :		
S. No.	SYMBOL	DESCRIPTION
1.	M.H.	MANHOLE
2.	S.E.W.E.R. LINE	SEWER LINE
3.	BYPASS SEWER LINE	BYPASS SEWER LINE
4.	BASEMENT LINE	BASEMENT LINE

Project

PROPOSED SPORTS CITY NEOWORLD FOR
M/S LOGIX INFRADEVELOPERS PVT.LTD.
AT PLOT NO: SC - 01/B, SECTOR -150, NOIDA, UP.

Title

SITE PLAN

Subtitle

EXTERNAL SEWERAGE SYSTEM
RESIDENTIAL & COMMERCIAL

Drawing released for

☐ APPROVAL
☐ ADVANCE COPY
☒ SUBMISSION
☐ CONSTRUCTION

Drig. no.

LOGIX / EX / S-01

Scale

1 : 400 @ A1

Date

Dec. 2019

Drawn by

Kulwant

Designed by

R.K.

Checked by

Anand Havelia

Architects

Confluence
B-421, NEW FRIENDS COLONY, N.D-85 INDIA
Ph: +91-11-46130600
www.confluence.com
urban design hospitality

Services Consultant

Consummate Engineering Services (P) Ltd.
Noida Office : B - 67, Sector - 67, Noida - 201 301
Tel : (0120) 6943500 (23 Lines)
Lko. Office : R 006, Rohtas Plumeria, Gomti Nagar, Lucknow
Tel : (0522) 4025902
e mail : mail@cespl.in, website : www.cespl.in