


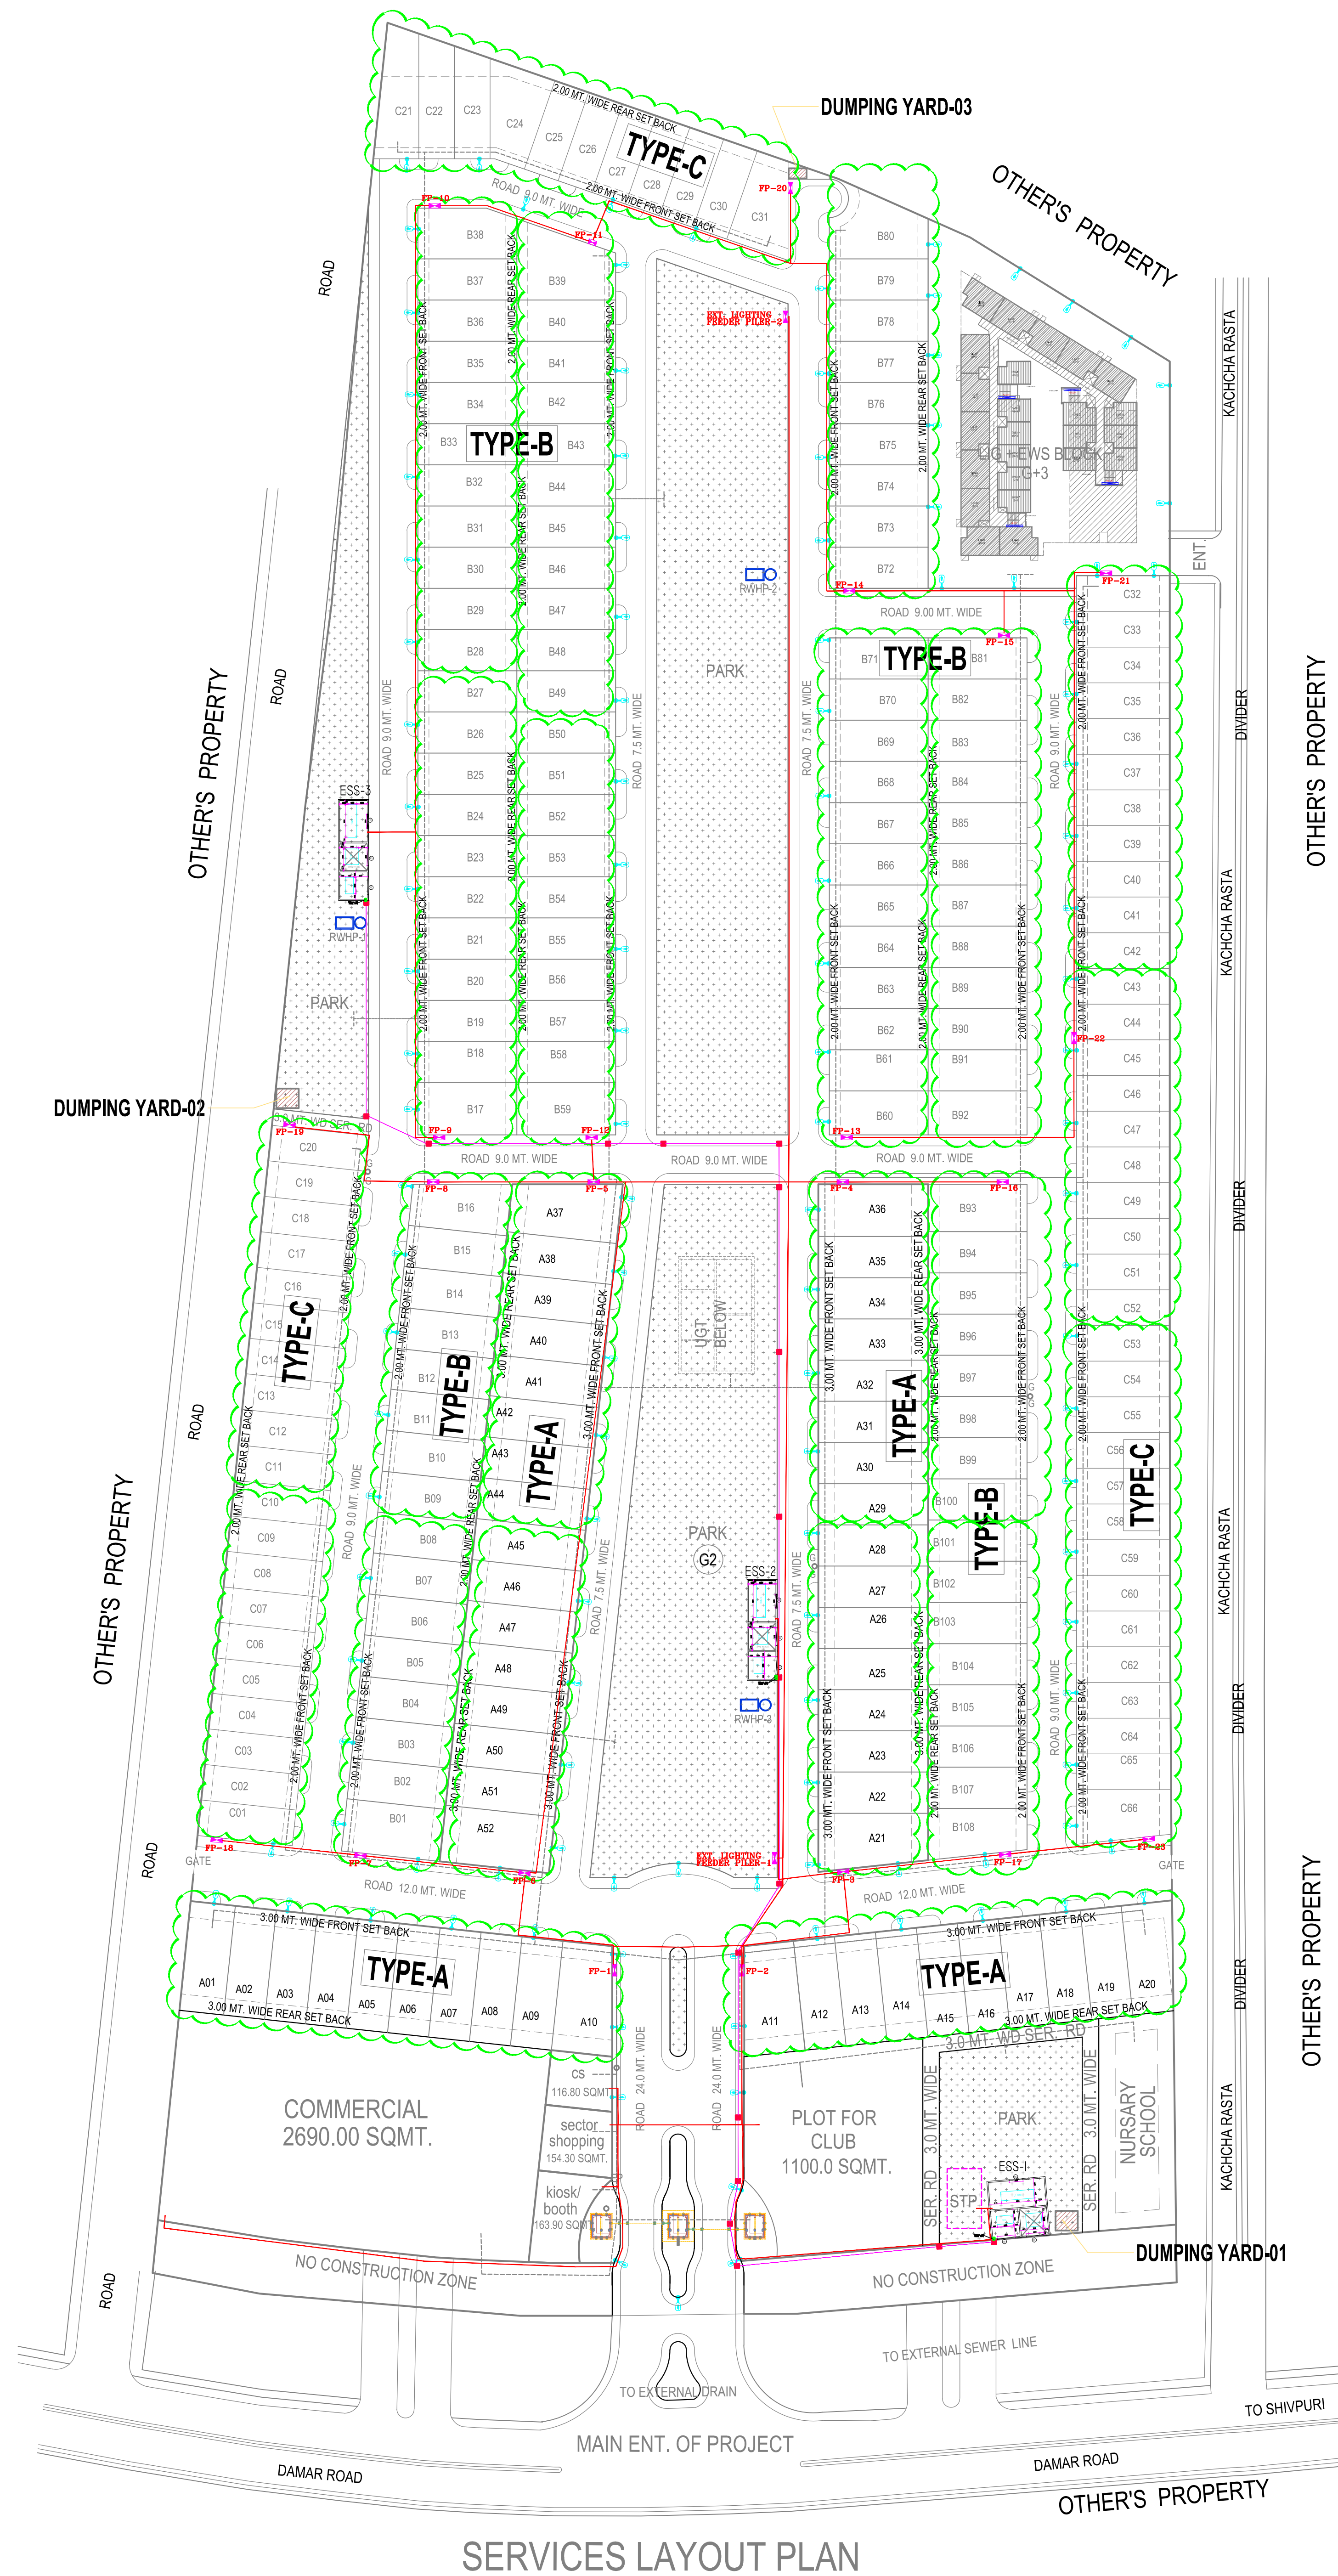

SERVICES LAYOUT PLAN

LEGENDS:

| SYMBOL | DESCRIPTION                                                |
|--------|------------------------------------------------------------|
|        | 100W LED STREET LIGHT FIXTURE<br>7MTS. LONG OCTAGONEL POLE |
|        | L.T. CABLES ROUTE                                          |
|        | H.T. CABLES ROUTE                                          |
|        | FEEDER PILLAR                                              |
|        | 800 X 800 X 1200 MM MAIN HOLE                              |

ELECTRICAL CONSULTANT :-

D.P. ARORA & ASSOCIATES

GH-2/98-B, ANKUR APARTMENT  
 PASCHIM VIHAR-NEW DELHI-63  
 Ph.011-45677687.Mob.No.9312221486  
 E-mail: dpa.elc@gmail.com

PROJECT  
**PROP. RESIDENTIAL LAYOUT PLAN ON BETWA VIHAR AWASIYA YOJNA ON KHASRA NO.182,183,187,243,244,245**  
**246,247,248,313,328,329,330,331,332,333,334,335,336,337,338,400**  
**401,445,446,447,448**  
**AT GRAM - BOODHA , TEHSIL AND DISTT.- JHANSI (U.P.)**

OWNERS:  
**M/S MAHAGUN (INDIA) PVT.LTD.**

ARCHITECTS:-  
**SPACE COMBINE**  
*Architects,Engineers,Planners*  
*project management consult.*  
 A12 SAFDARJUNG ENCLAVE  
 New Delhi -110029

SITE PLAN ELECTRICAL & SUBSTATION LAYOUT

|            |          |          |              |
|------------|----------|----------|--------------|
| SCALE      | - N.T.S. | DRG. NO. | -            |
| DRAWN BY   | - RANU   | DATE     | - 13-12-2021 |
| CHECKED BY | - D.P.A. | JOB NO.  | -            |

SIG. OF OWNERS

*Signature*  
**AYOTI SINGHAJ**  
 ARCHITECT  
 CA / 98 / 18250

SIG. OF ARCHITECT