



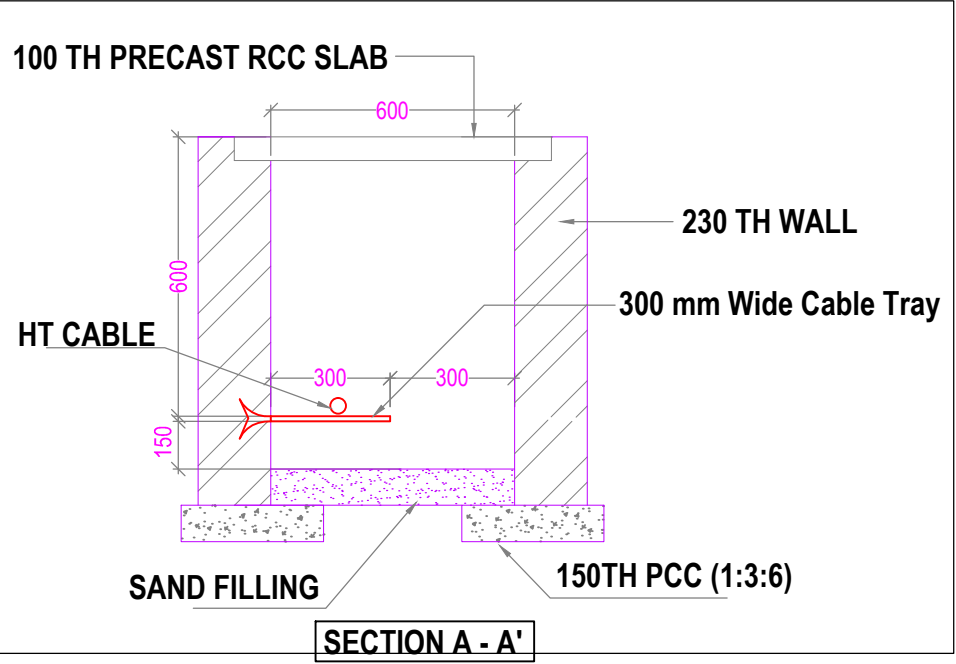

School

9000mm Wide Road

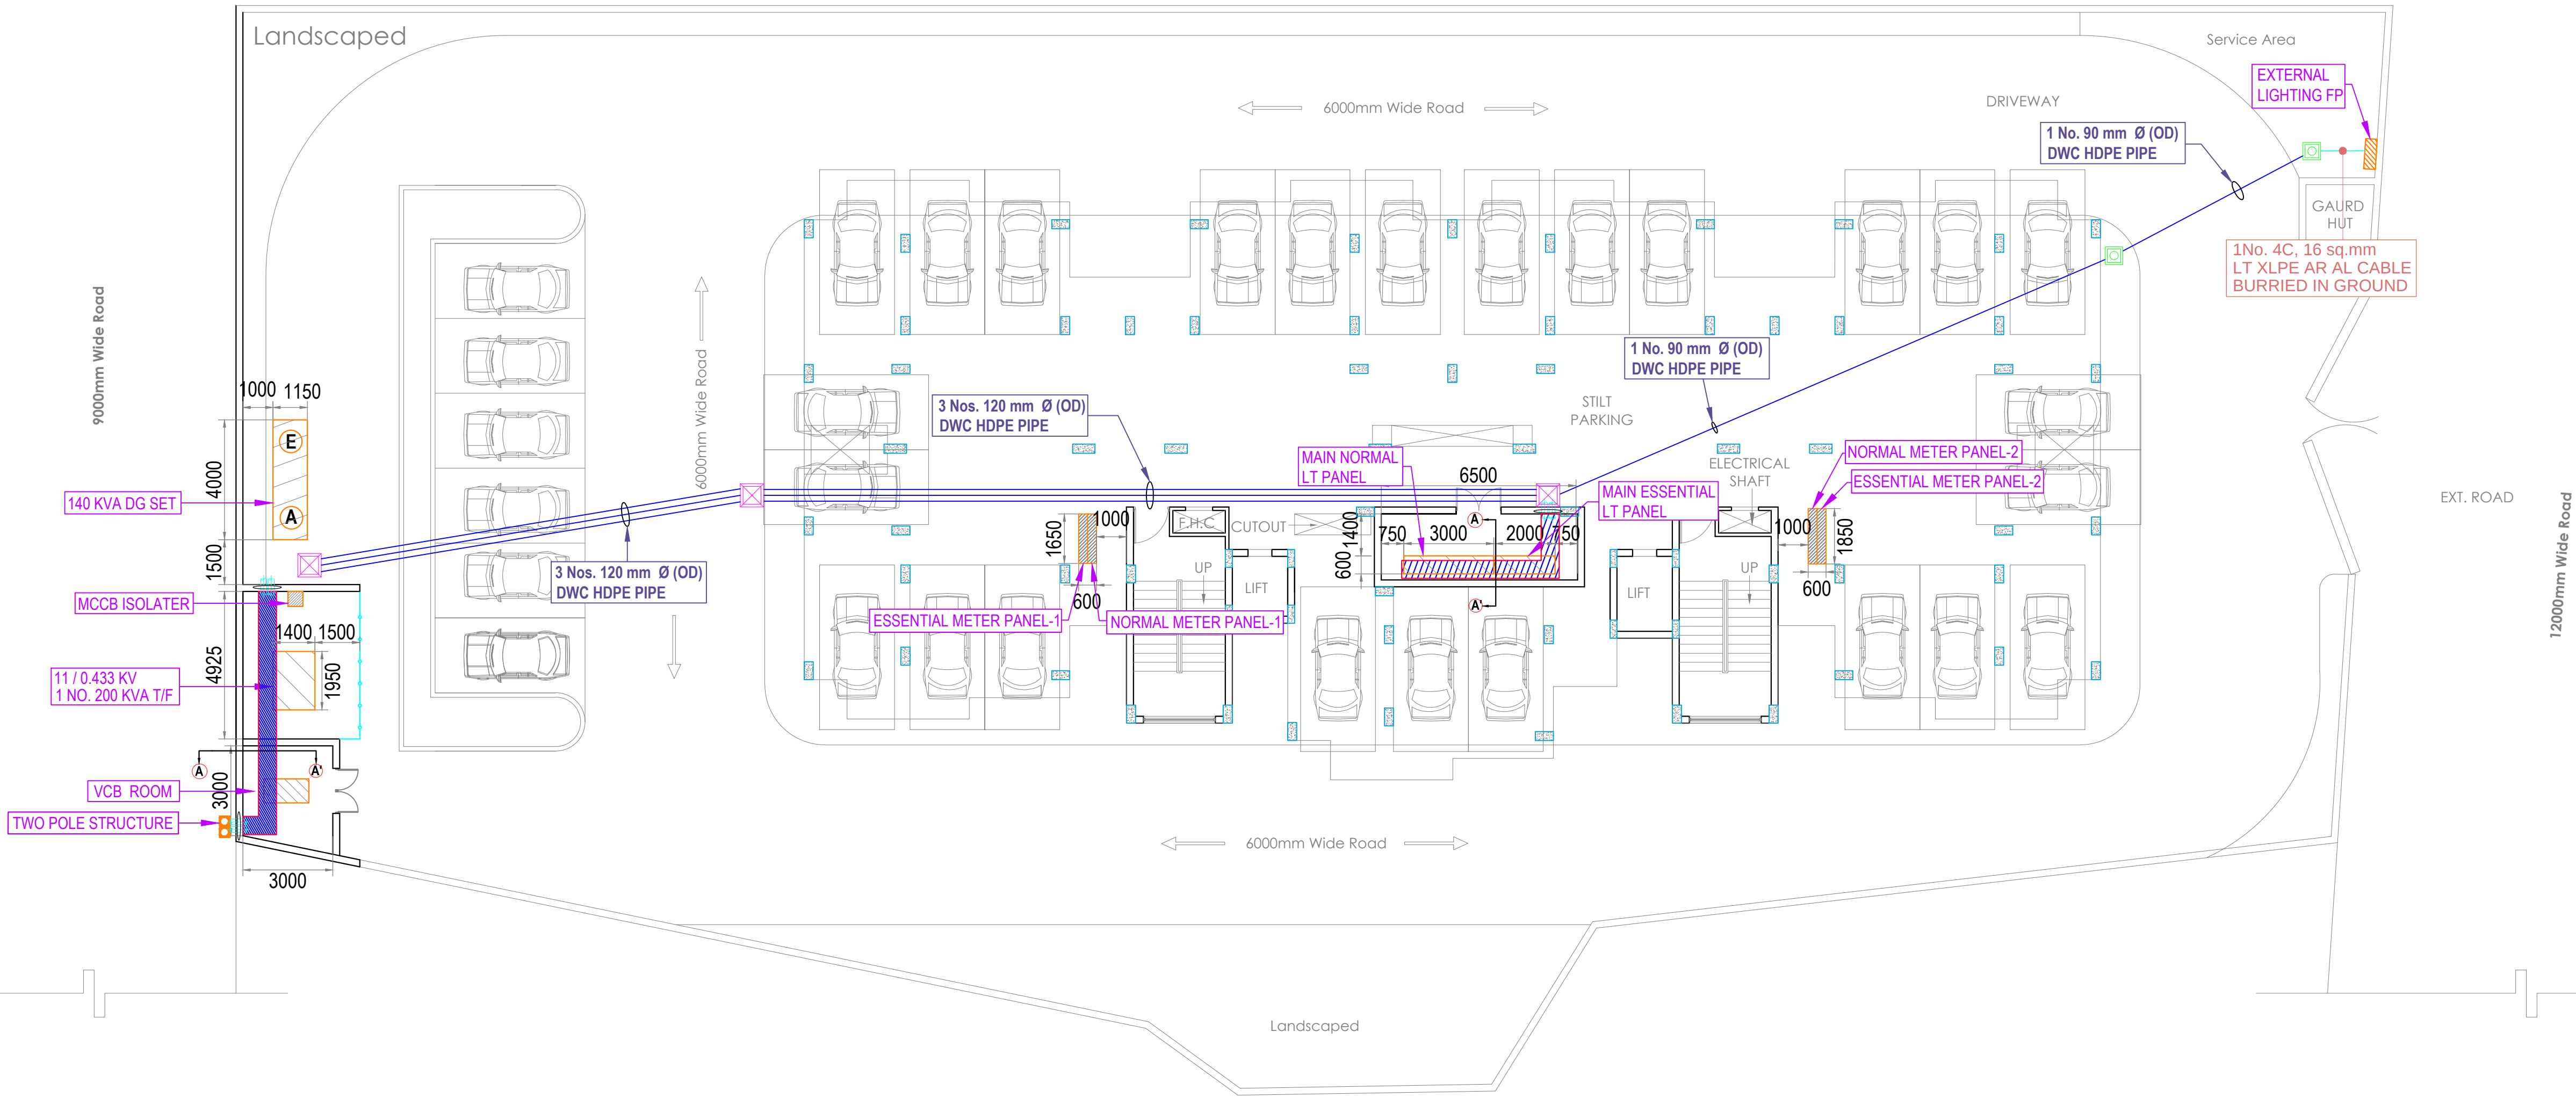

- NOTES :**
- 1) Clear height of 11 KV VCB room shall be minimum 3.6 mtr. below clear beam.
 - 2) Plinth Level of VCB room shall be 600 mm above final finished ground level.
 - 3) Trench detail shall be finalized after receiving foundation detail of Transformer, 11 KV VCB room.

R0	01.07.2015	ISSUED AS ADVANCE COPY
rev. no.	date	revision

project
PROPOSED GROUP HOUSING
AT SECTOR-P, KANPUR ROAD SCHEME, LUCKNOW

title
ELECTRICAL SETTING OUT

subtitle
STILT FLOOR PLAN (Sector-P)

drawing released for
☐ APPROVAL ☐ SUBMISSION
☒ ADVANCE COPY ☐ CONSTRUCTION

drg. no. KR / SEC-P / EXT. / ELEC.- 01 drawn by Nitesh Sharma

scale 1:200 @ A2 designed by Gaurav Tyagi

date Aug. 2014 checked by ANAND HAVELIA

architects **rajesh & associates**
architects, engineers, planners & interior designers
magna house, first floor, D-2, infocity II, gurgaon- 122 001, india
tel : +91-124-4626666 fax: +91-124-4626688
3, b.n. road, kaiserbagh, lucknow- 226 001, india
Tel : +91-522-2626838 +91-522-2628360
email: rajeshassoc@rediffmail.com

services consultant
Consummate Engineering Services (P) Ltd.
Noida Office : B - 67, Sector - 67, Noida - 201 301
Tel : (0120) 2593500 (30 Lines)
Lko. Office : R 006, Rohtas Plumeria, Gomti Nagar, Lucknow
Tel : (0522) 6515455
e mail : mail@cespl.in, website : www.cespl.in