



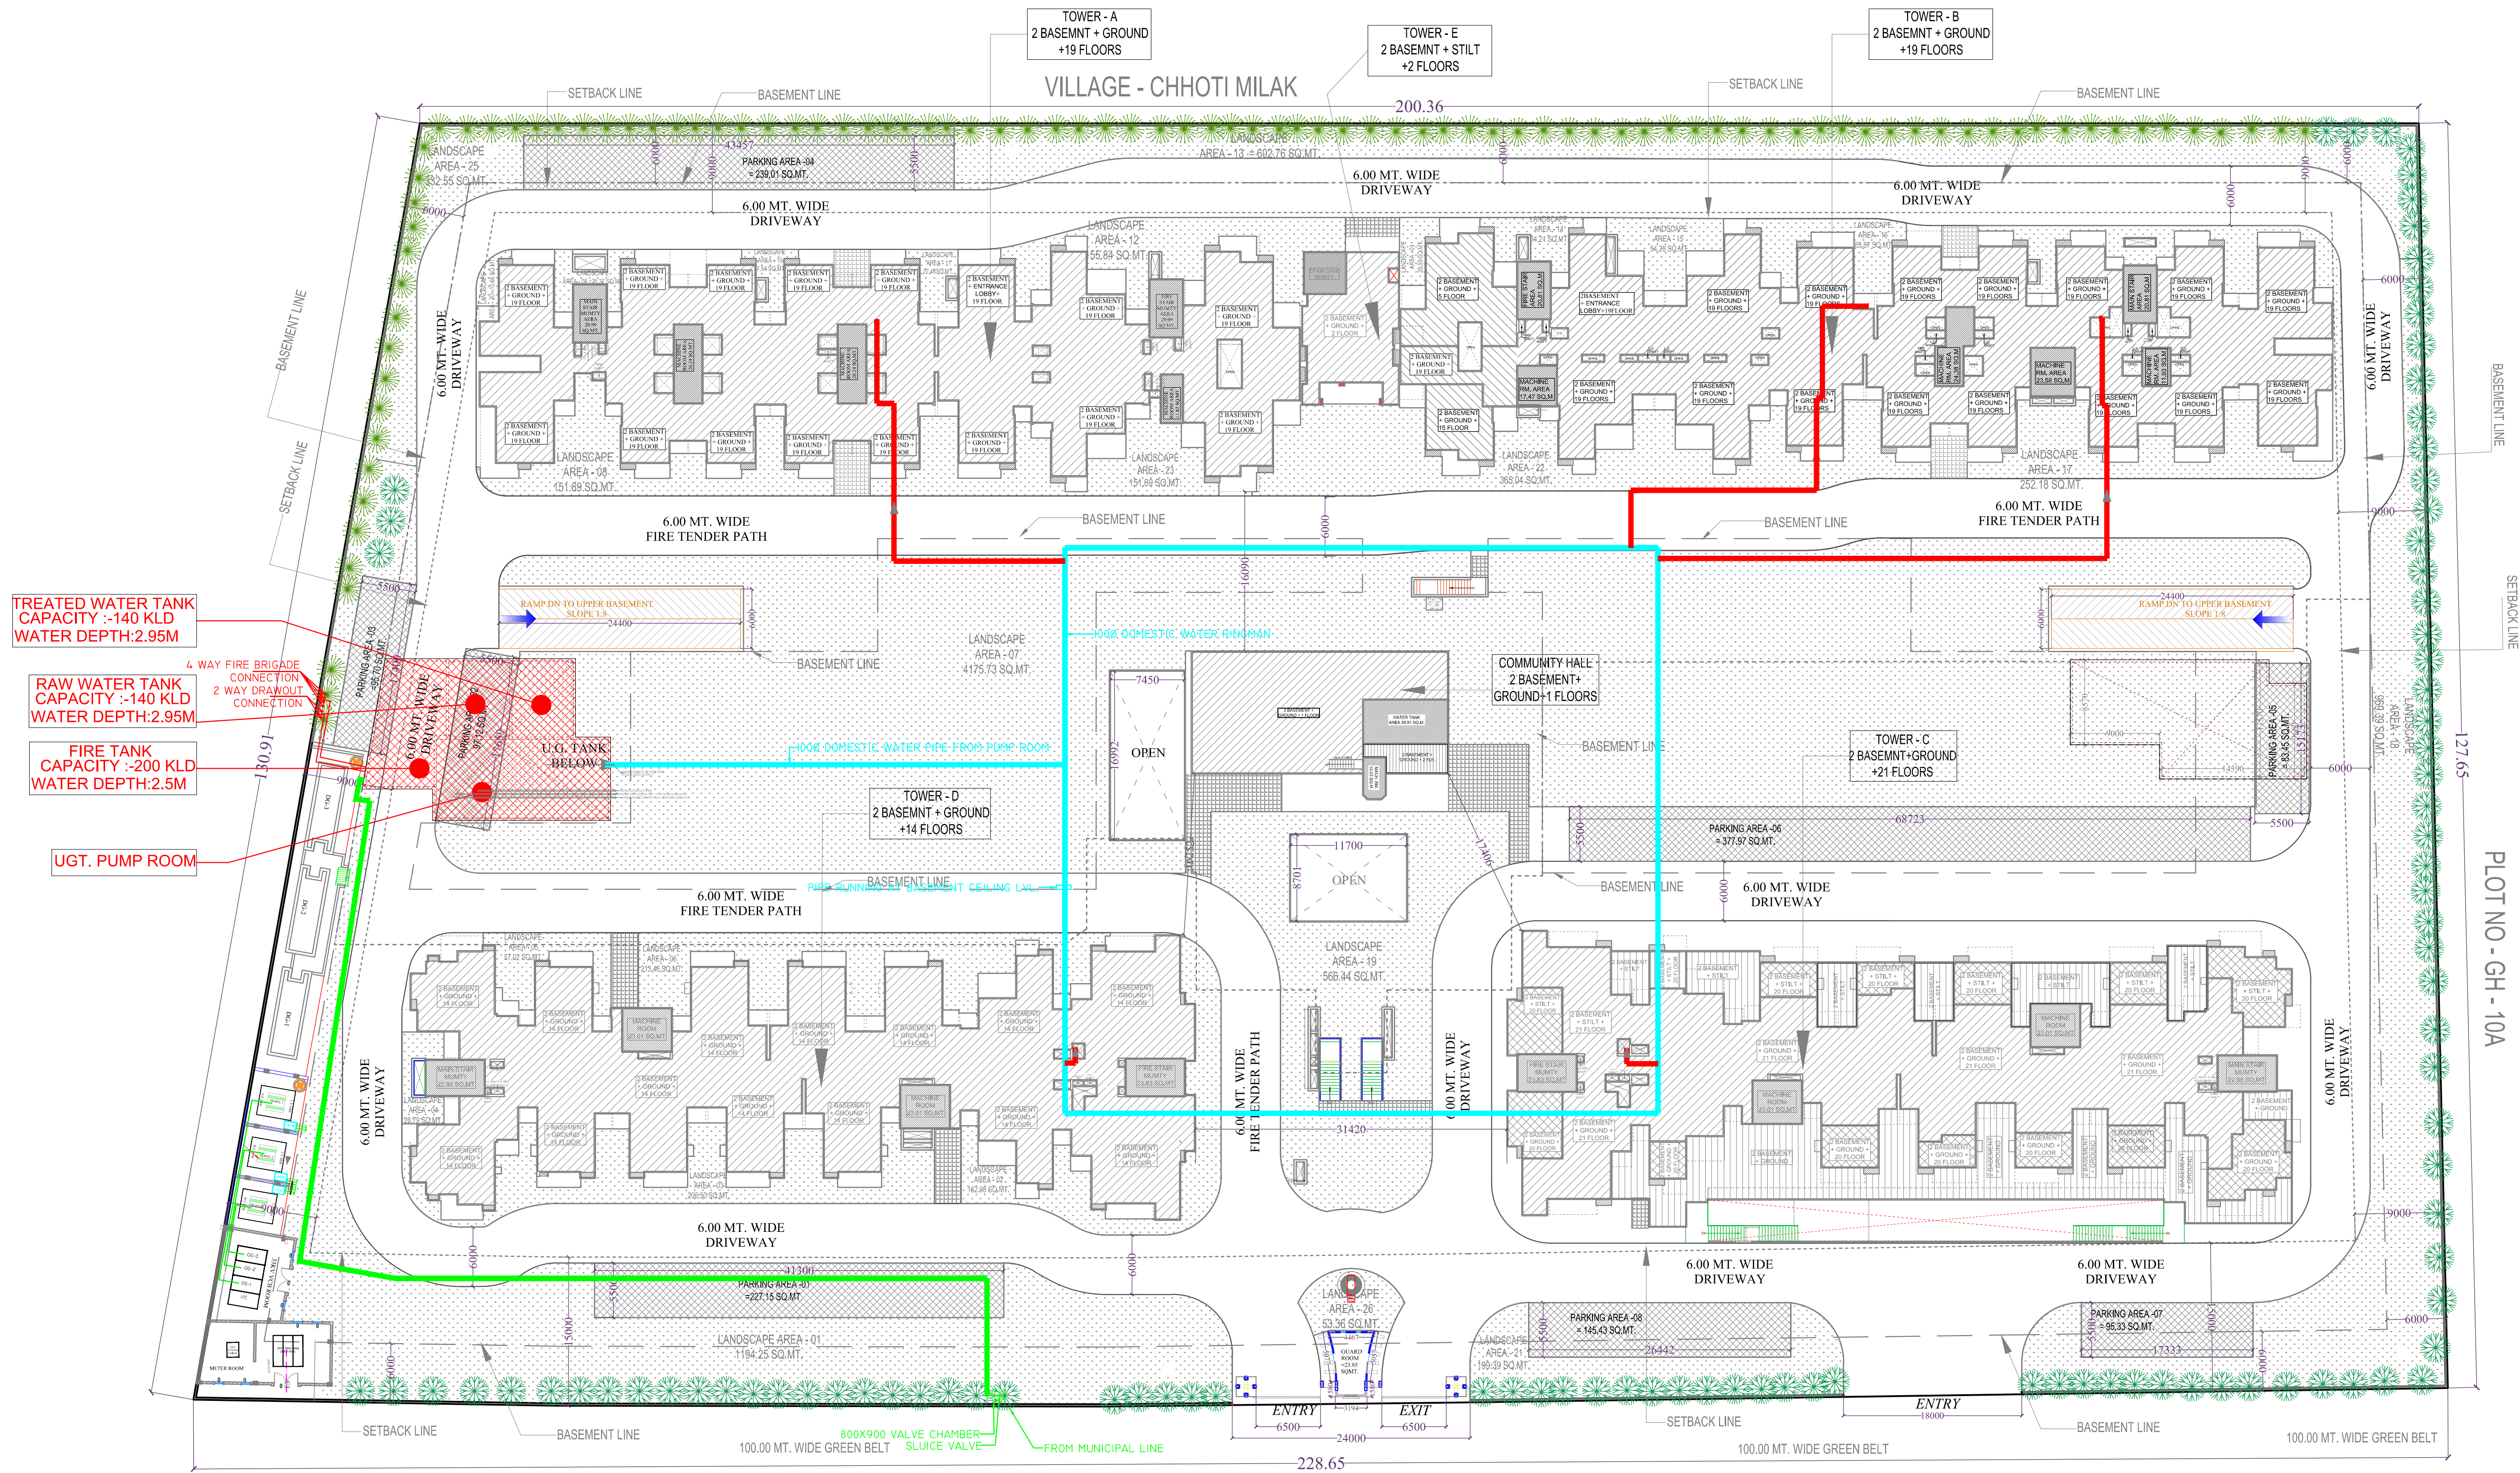

PLOT NO - GH - 10A

SITE PLAN

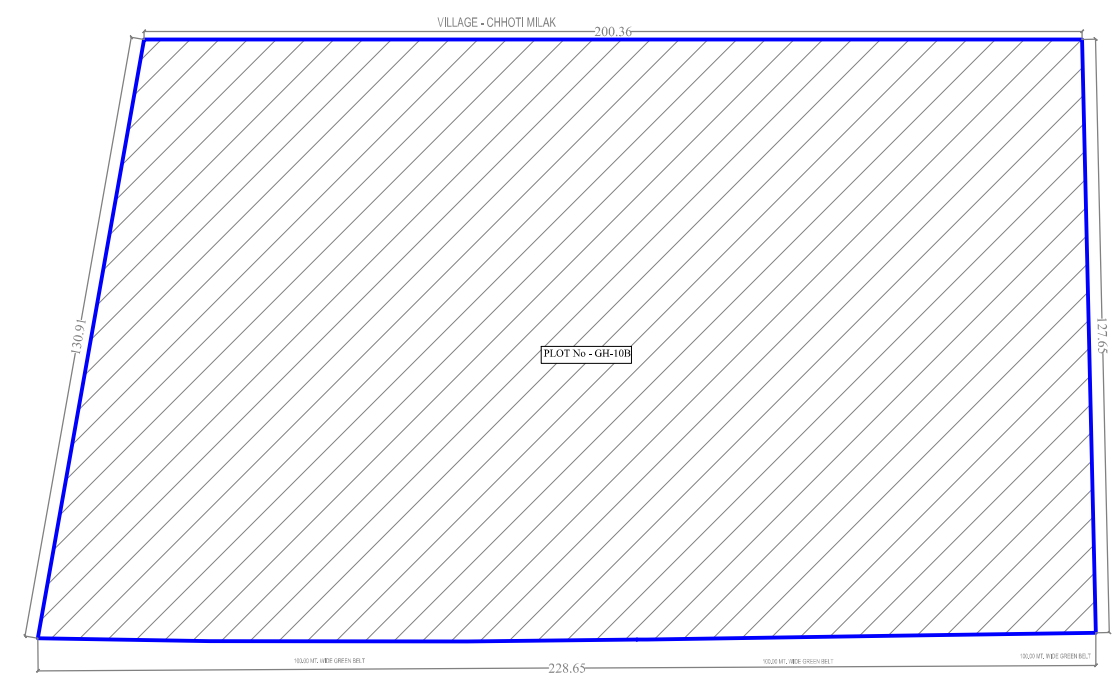

KEY PLAN

LEGEND :-	
1	SETBACK LINE
2	BASEMENT LINE
3	TOWER ENTRANCE
4	PARKING AREA

NO/REV.	DATE	REVISION/ISSUED TO
BUILDERS & PROMOTER :-		
M/s HIMALAYA REAL STATE PVT.LTD. REGD. OFFICE : 7365, PREM NAGAR(SHAKTI NAGAR), NEW DELHI - 1100		
PROJECT TITLE:		
RESIDENTIAL COMPLEX "HIMALYA PRIDE" AT PLOT No - GH-10B , TECH ZONE-IV GREATER NOIDA (U.P)		
ARCHITECTS :-		
 ARCHITECTS : Space Designers International B-34, Sector-67, Noida-201301 (U.P.) PH : 097165317, 87, 9720 e-mail : spacesdi@gmail.com, www.spacesdi.com		
LANDSCAPE ARCHITECT:		
 AYAM ARCHITECTURE AND LANDSCAPE CONSULTANTS LGF-254, GYAN KHAND-1, INDIRAPURAM GHAZIABAD-201010 Ph: 9818500389 • MASTER PLANNING • LANDSCAPE ARCHITECTURE • ARCHITECTURE		
DRAWING TITLE:		
WATER SUPPLY PLAN		
SCALE	NTS	DATE: 19.06.18
DRAWN BY: ASHISH	CHECKED BY: DINESH	
DWG NO:	STATUS	
PL-02	R0	
PLUMBING & FIRE FIGHTING CONSULTANTS :-		
PEE CONSULTANTS 815-C, EAST OF LONI ROAD SHAHADRA, DELHI-110093 PH: 011-22816297, 22815897 EMAIL: pds_in@yahoo.com, nrcons@gmail.com		