


EXTERNAL ELECTRICAL SITE LAYOUT

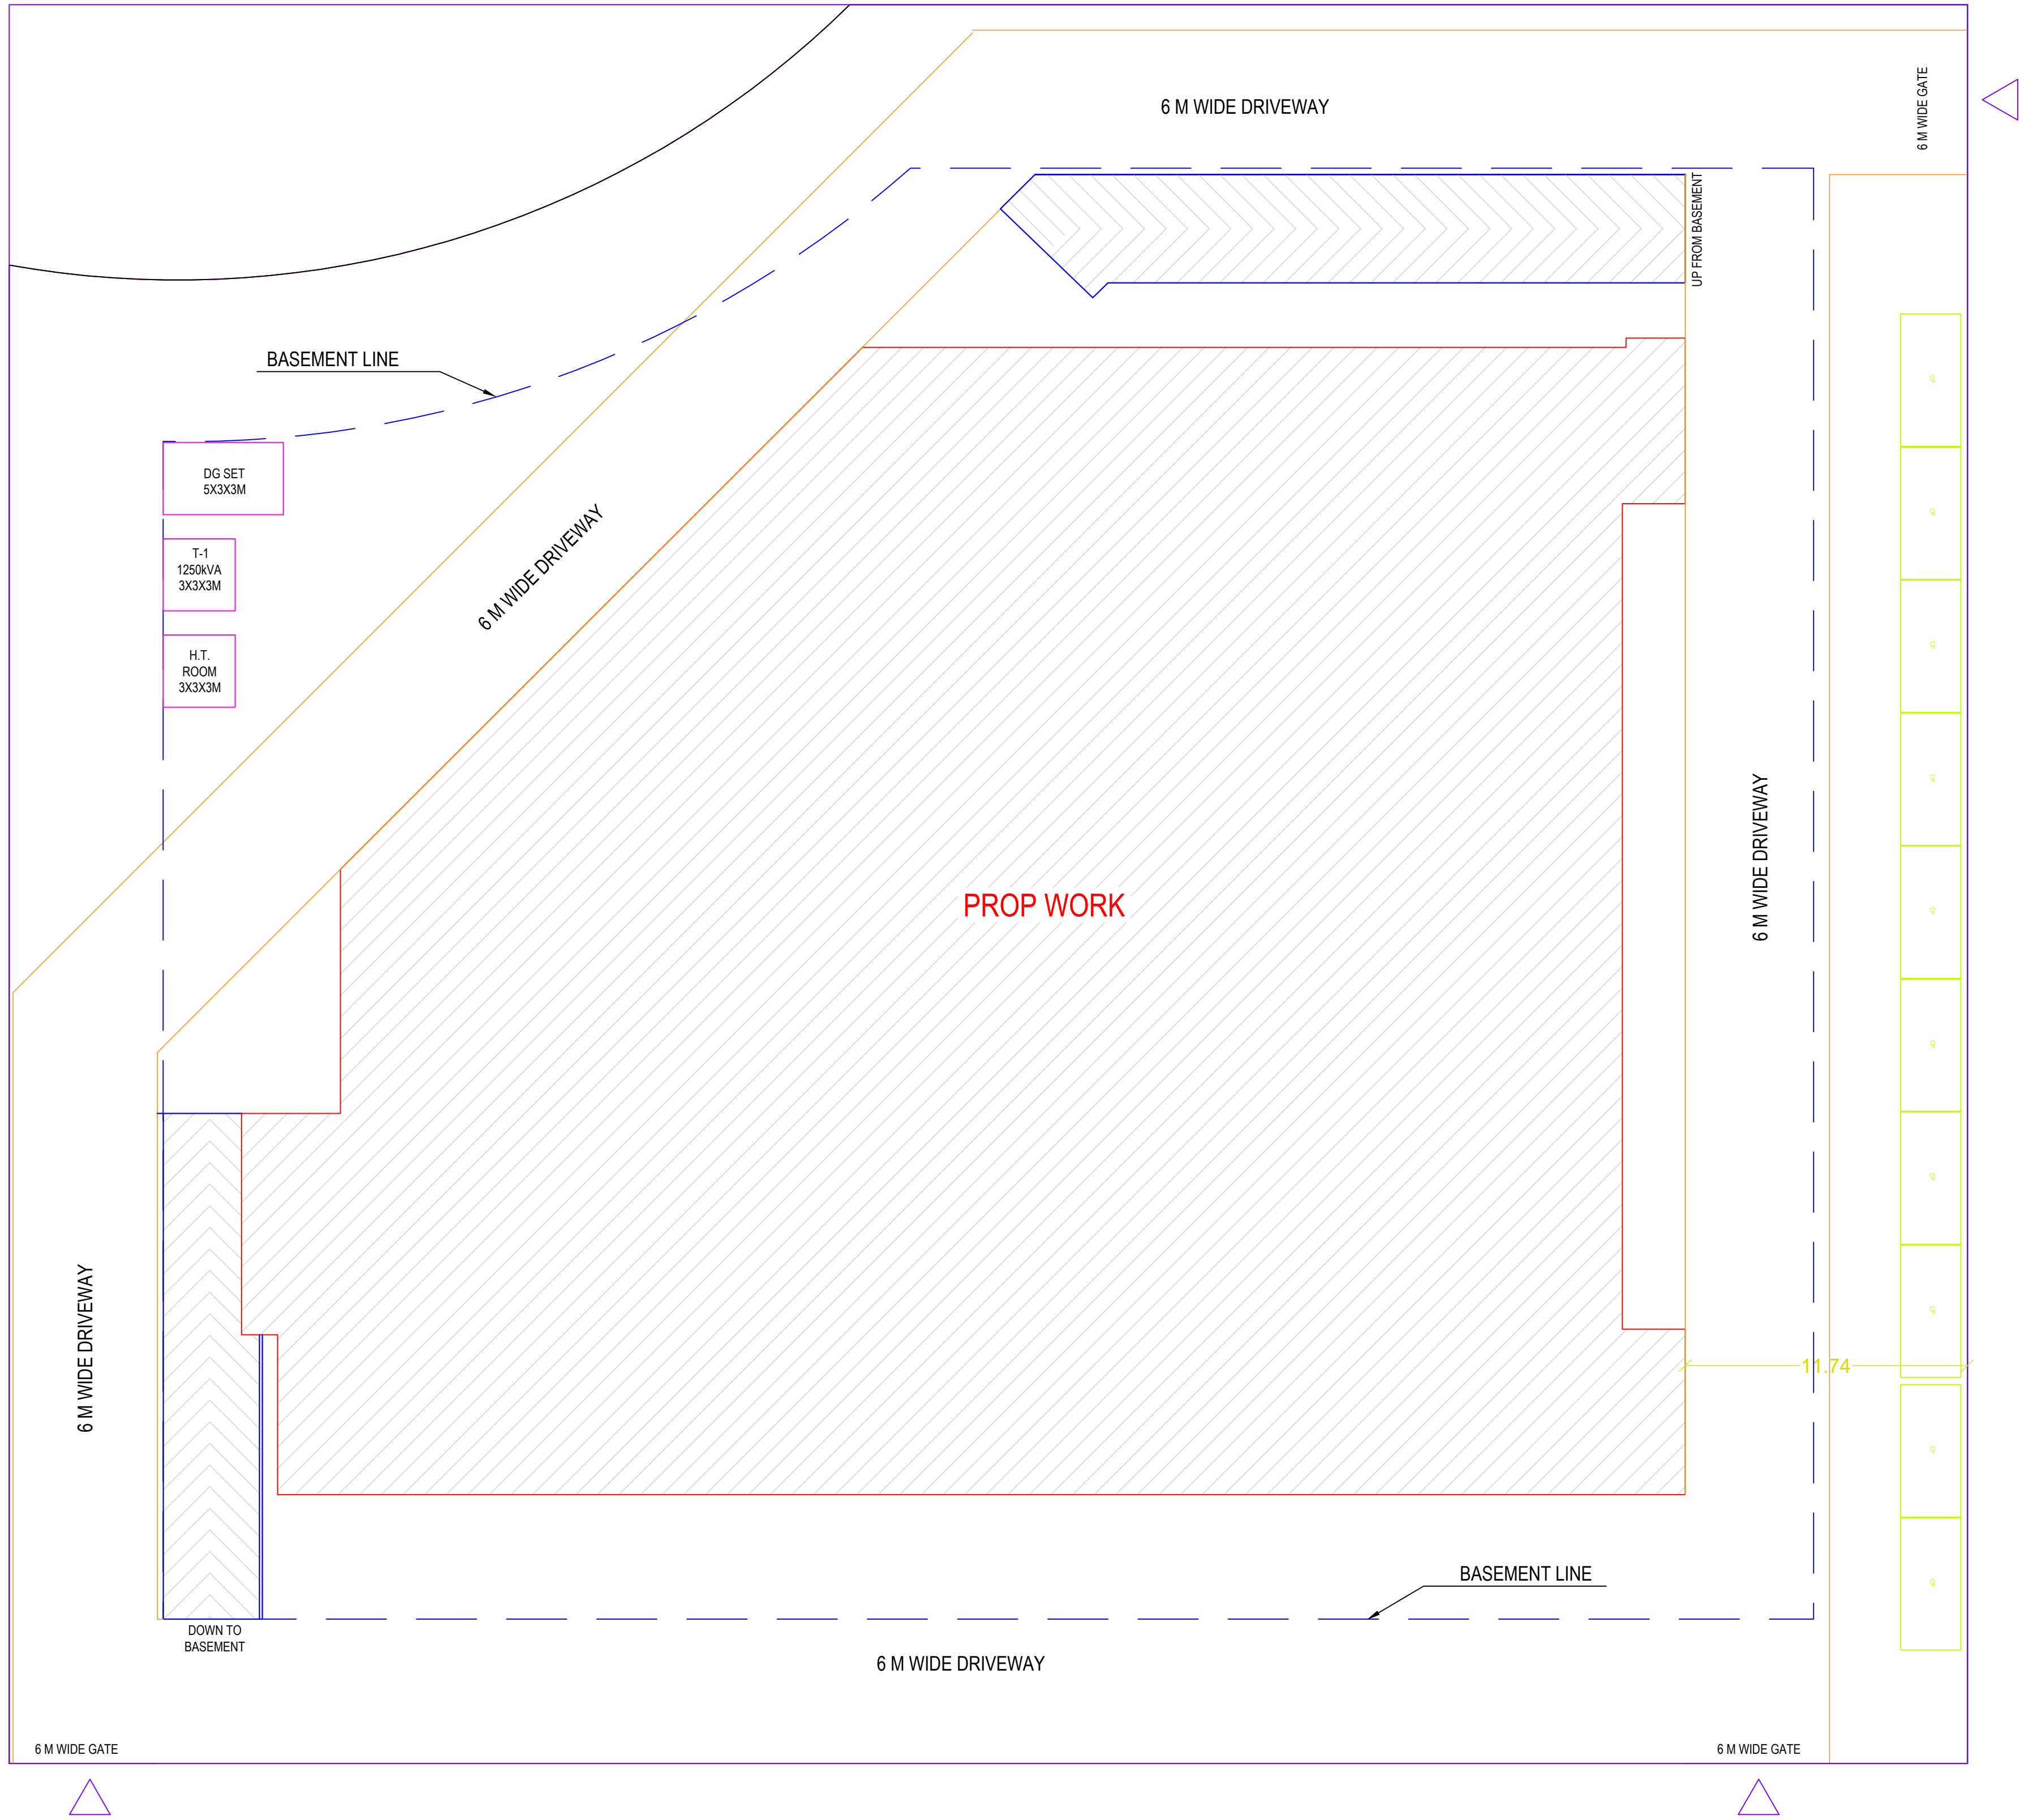

24.0 MT. WIDE MAINROAD Approved Internal Road

DRG. NO. -

PROJECT

PROPOSED COMMERCIAL / OFFICE / HOTEL COMPLEX

FOR

M/s GPCL BUILDERS AND DEVELOPERS PVT. LTD.

DIRECTOR

MR. KISHAN BABU GUPTA

AT

PLOT NO.- UNDIVIDED SHARE OF LAND OF TOWER - T3B IN I. B. B.-1 SUSHANT GOLF CITY, SULTANPUR ROAD, LUCKNOW

REMARK

1. Dimensions are to be read not to be measured.
2. Any discrepancy in the drawing, if any, should be brought to the notice of the architect immediately.
3. All dimensions are in meter.
4. All dimension & levels are from unfinished architectural surface.
5. All the rights of the drawing are reserved with the architect. Reproducing the drawings in any form without the prior permission of architect is not permitted.
6. If no remarks / suggestions are given within fifteen days from the release date of the drawing the drawing shall be deemed as final draft.
7. All the information regarding the land / building & its surrounding is provided by the owner.
8. Architect shall not be responsible for any kind of discrepancy regarding land information.

SCALE

DATE

DRG. NO.

SEPTEMBER - 2021


DRAWING TITLE

EXTERNAL ELECTRICAL LAYOUT

DRAWN BY

AJAI KISHORE


NORTH

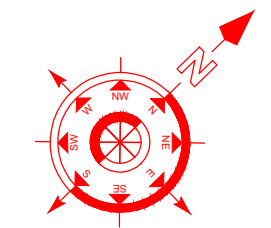

AUTHORIZED SIGNATORY

ARCHITECT SIGN.

ARCHITECT

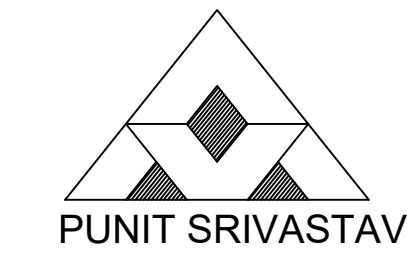

VASTULIPI

ARCHITECTS, DESIGNERS & PLANNERS

vastulipi@gmail.com, 9935590999

www.vastulipi.com