


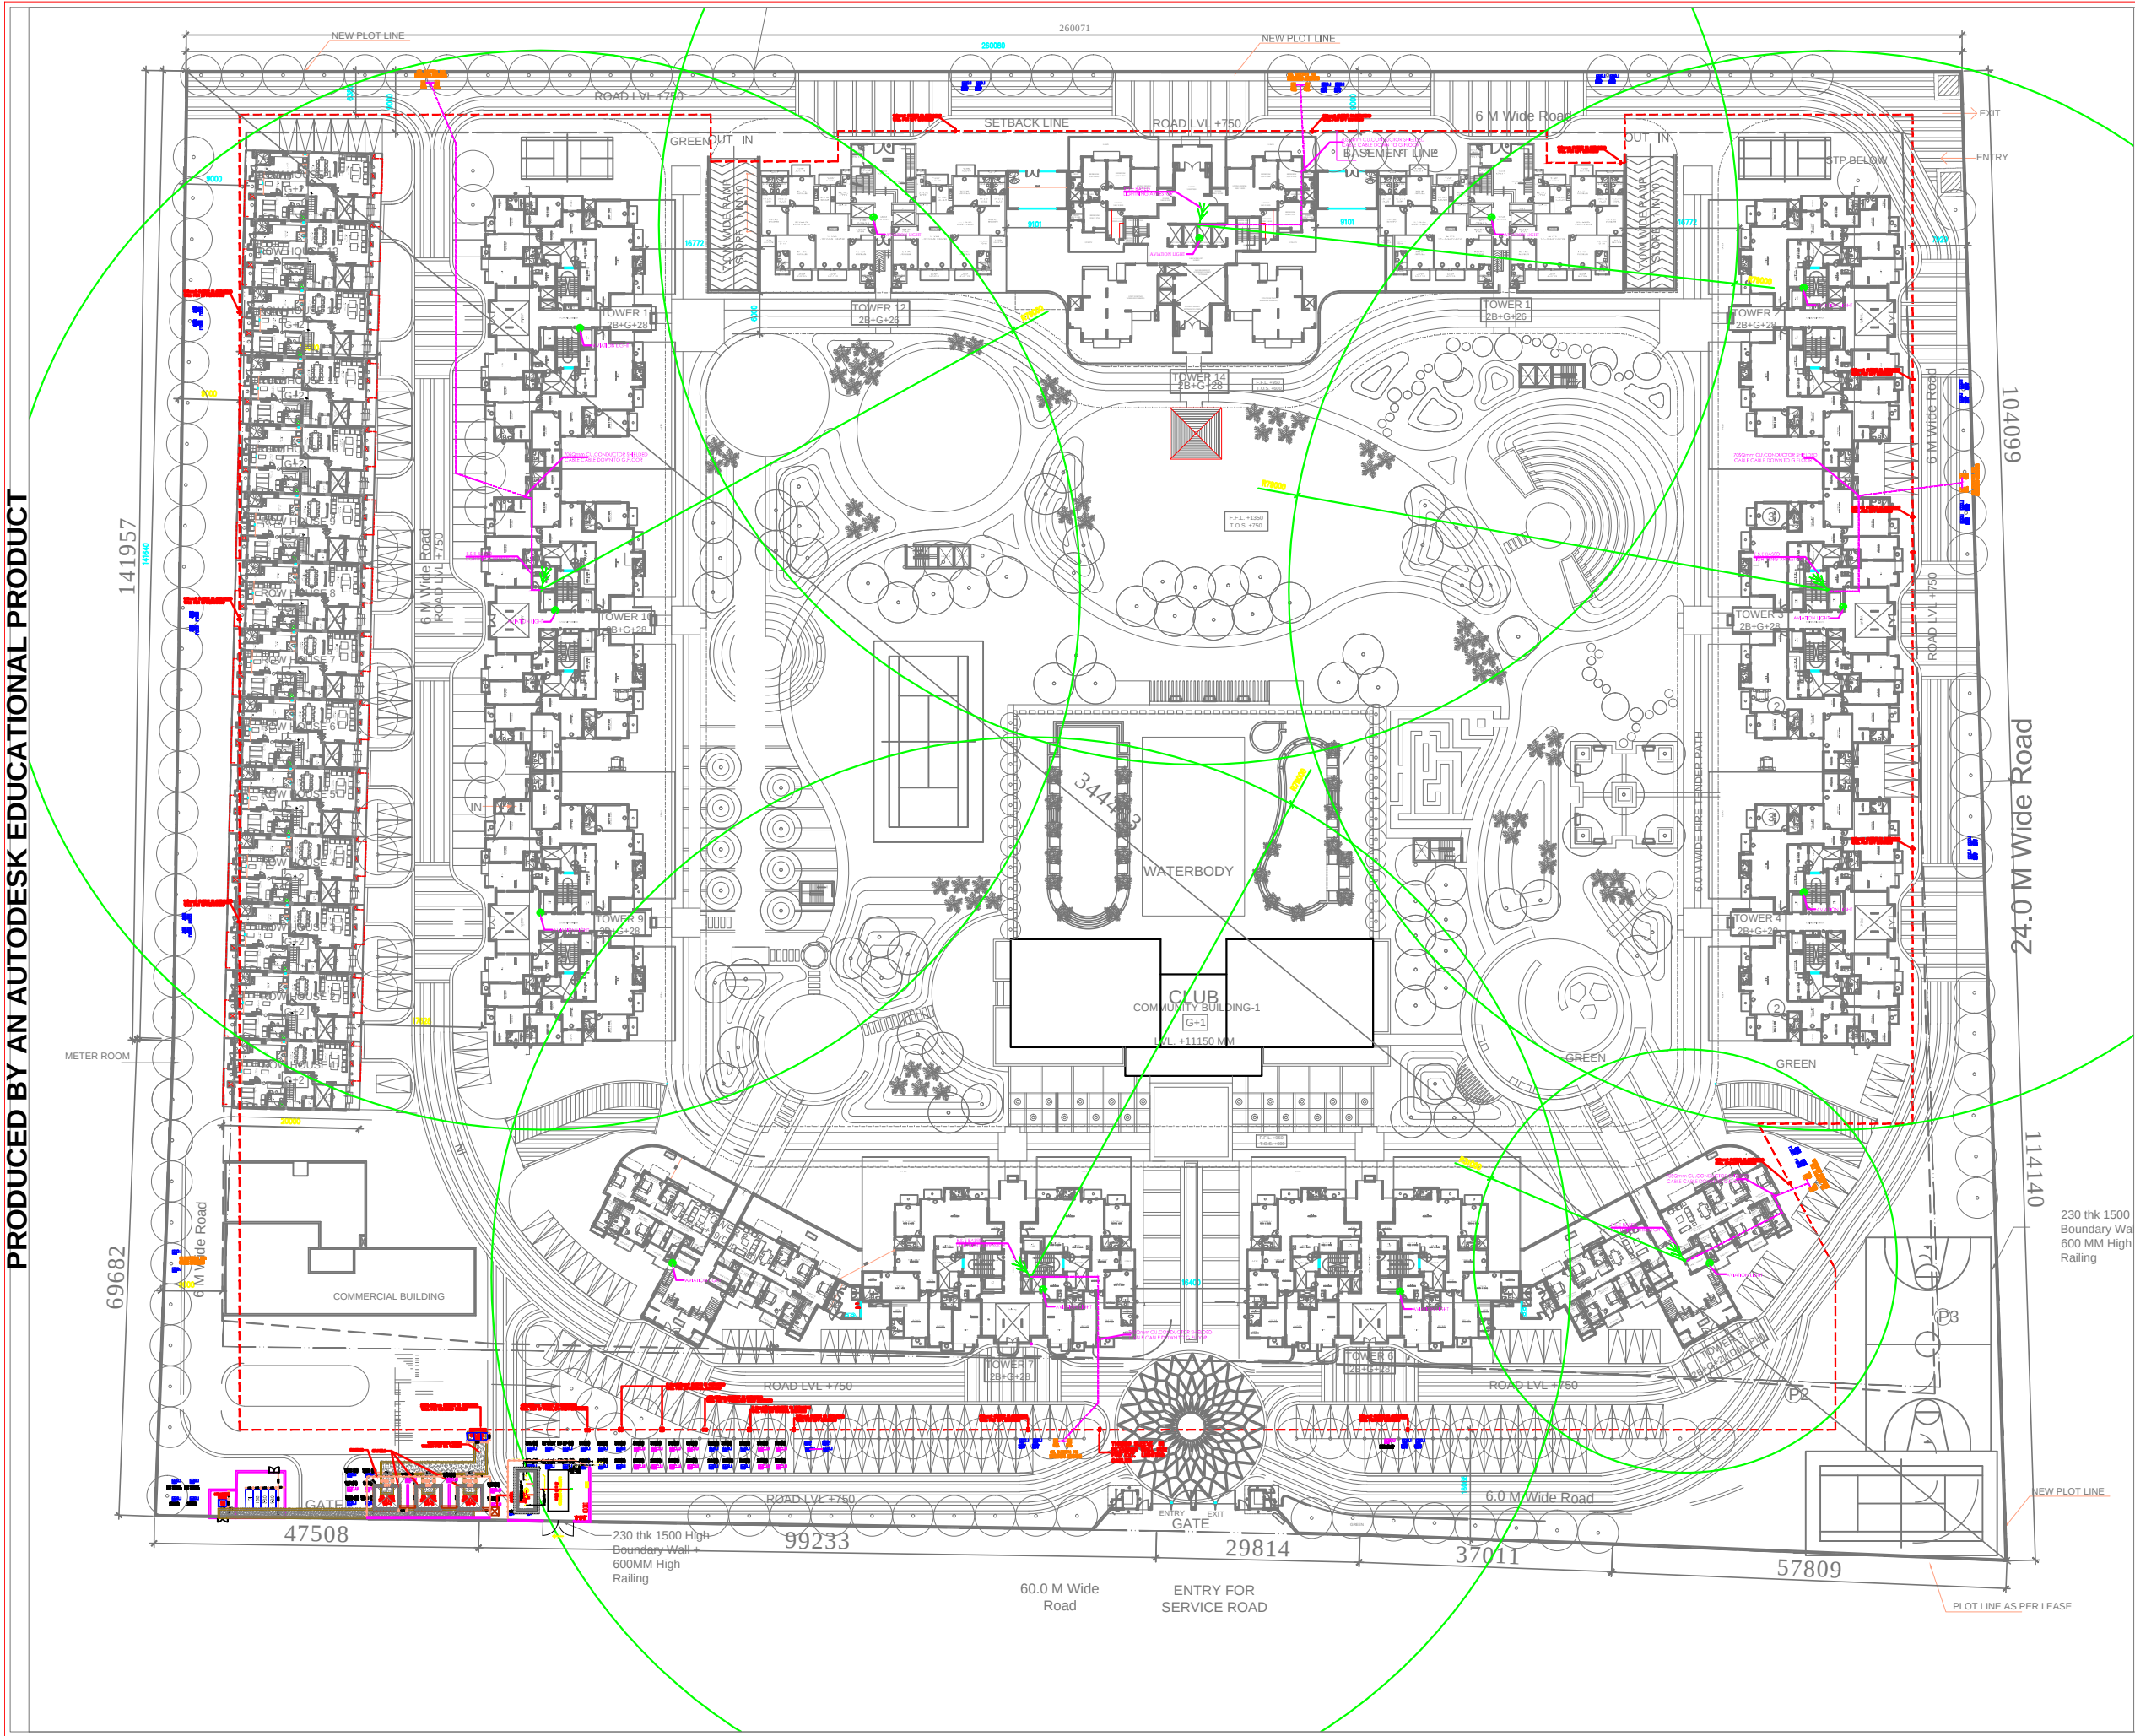

PROJECT :-	
ATS-DOLCE	
AT PLOT NO-12A ZETA-1	
MEP CONSULTANTS:	
PARADISE CONSULTANTS	
G-76C, SHAHEEN BAGH, NOIDA ROAD	
NEAR KALINDIKUNI, NEW DELHI-110025	
PH : 011- 29943601, 24528427	
E-mail: paradiseconsultants@gmail.com	
DRAWING TITLE :	
ELECTRICAL SITE PLAN	
scale :	drawn by :
date :	checked by :
project no :	approved by :
drawing no :	EL-PC-ATS-SITE-101
REVISION	