

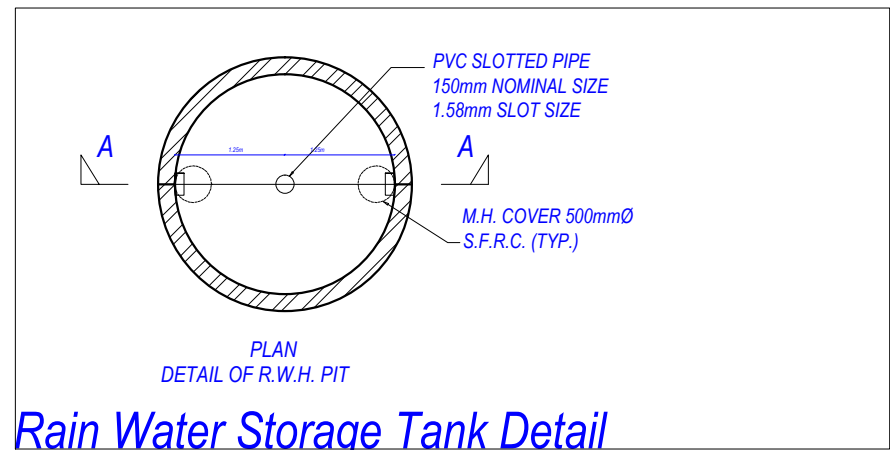
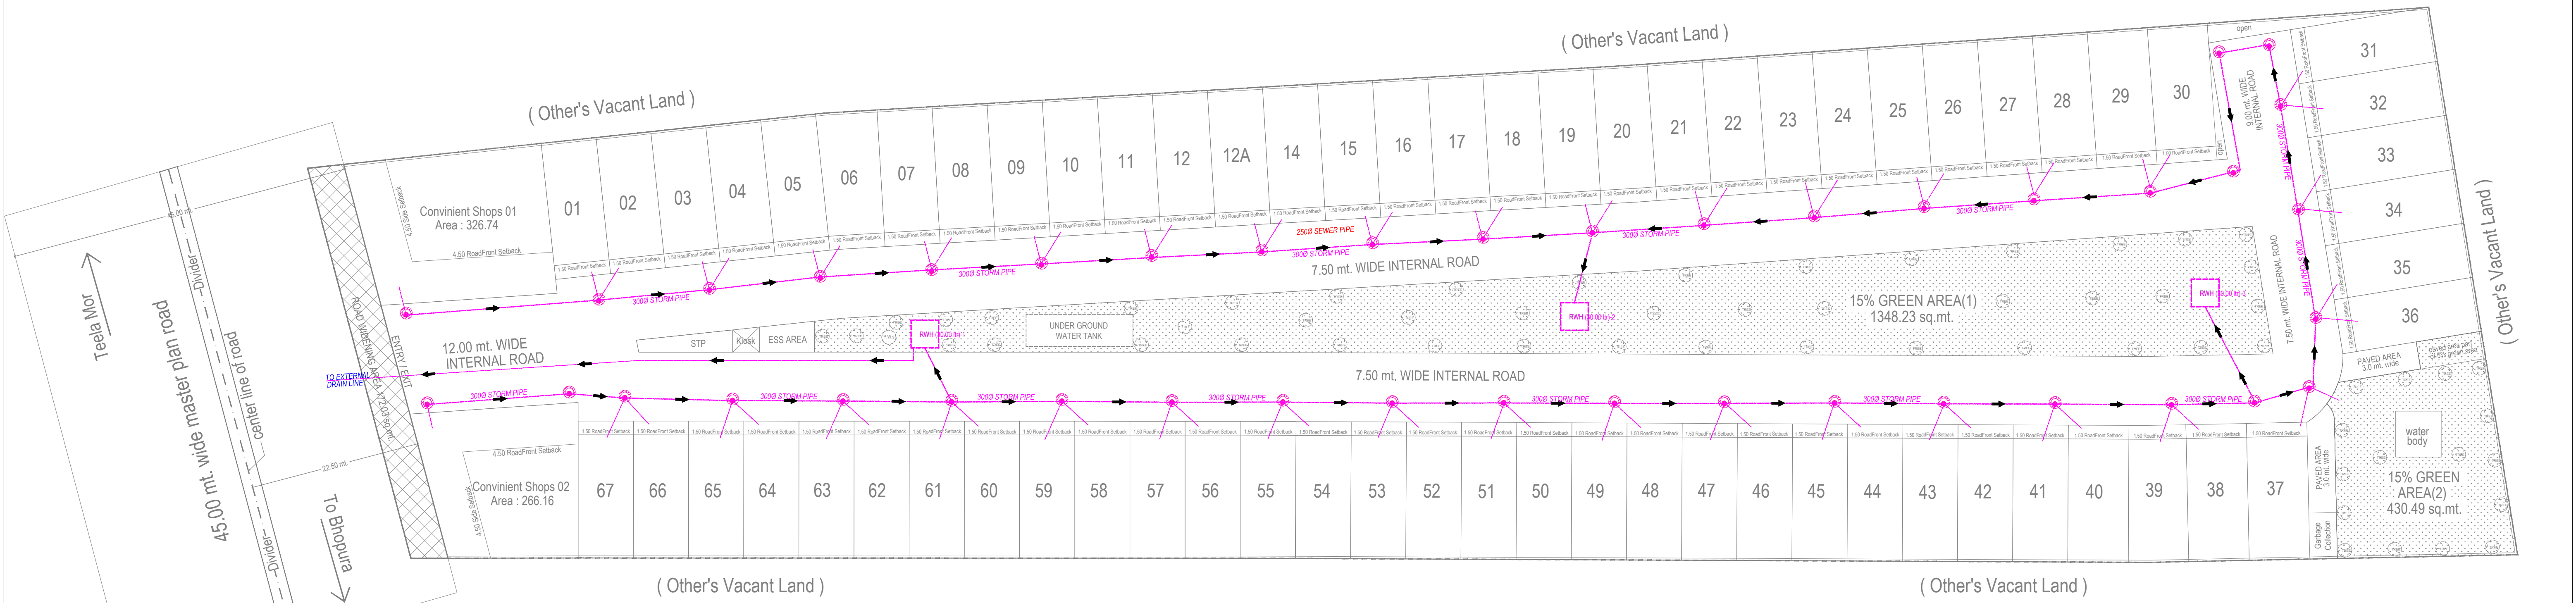


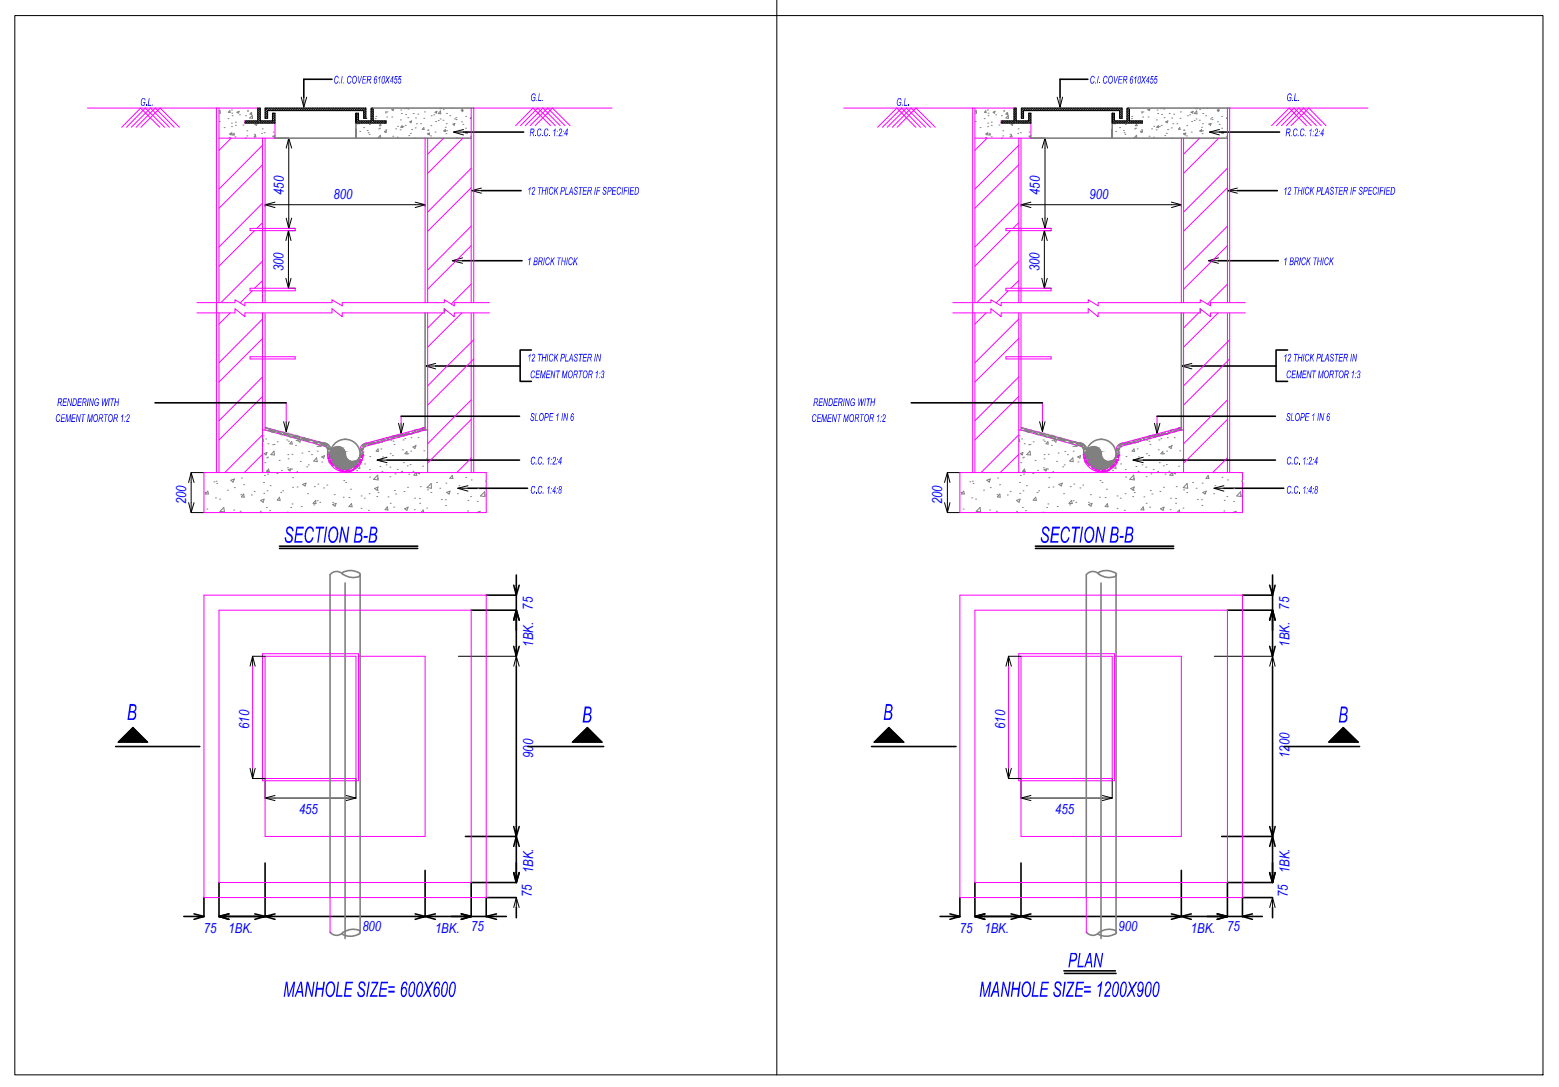

Rain Water Storage Tank Detail

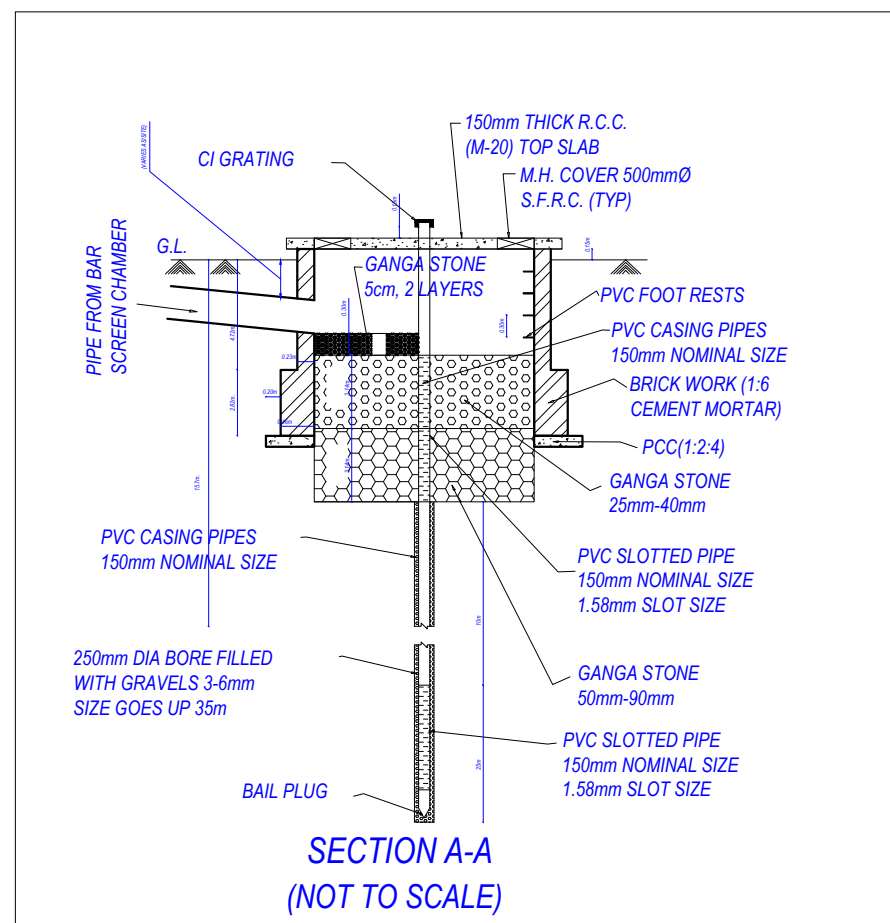

Rain Water Harvesting Details

LEGEND:-	
	STORM WATER LINE
	STORM WATER MAN HOLE
	STORM WATER CATCH BASIN
	RAIN WATER HARVESTING PIT
G.L.	GROUND LEVEL
I.L.	INVERT LEVEL
C.L.	CONNECTION LEVEL
L.	LENGTH OF PIPE

DRAINAGE LAYOUT

PROJECT
PROPOSED AFFORDABLE HOUSING LAYOUT PLAN
KHASRA NO :- 606m VILLAGE TILA SAHBAJPUR ,
PARGANA LONI, GHAZIABAD (U.P.)

OWNER
M/s. - PRITHVILINK DEVELOPER'S PRIVATE LIMITED
Through :- Mr. - AMARDEEP DALAL

DRAWING TITLE
DRAINAGE LAYOUT PLAN

ARCHITECT
ANUJ AGARWAL ARCHITECTS
OFFICE:- A-244 KAUSHAMBI GHAZIABAD (U.P.)
Ph:-0120 - 4165716 , 4563716 , 6454182
e-mail : anujagarwal@gmail.com

DEALT BY:- Ar.Talib
CHECKED BY:- Ar.Anuj Agarwal
DATE: 30-08-2023
DRG. No.: DW-02