


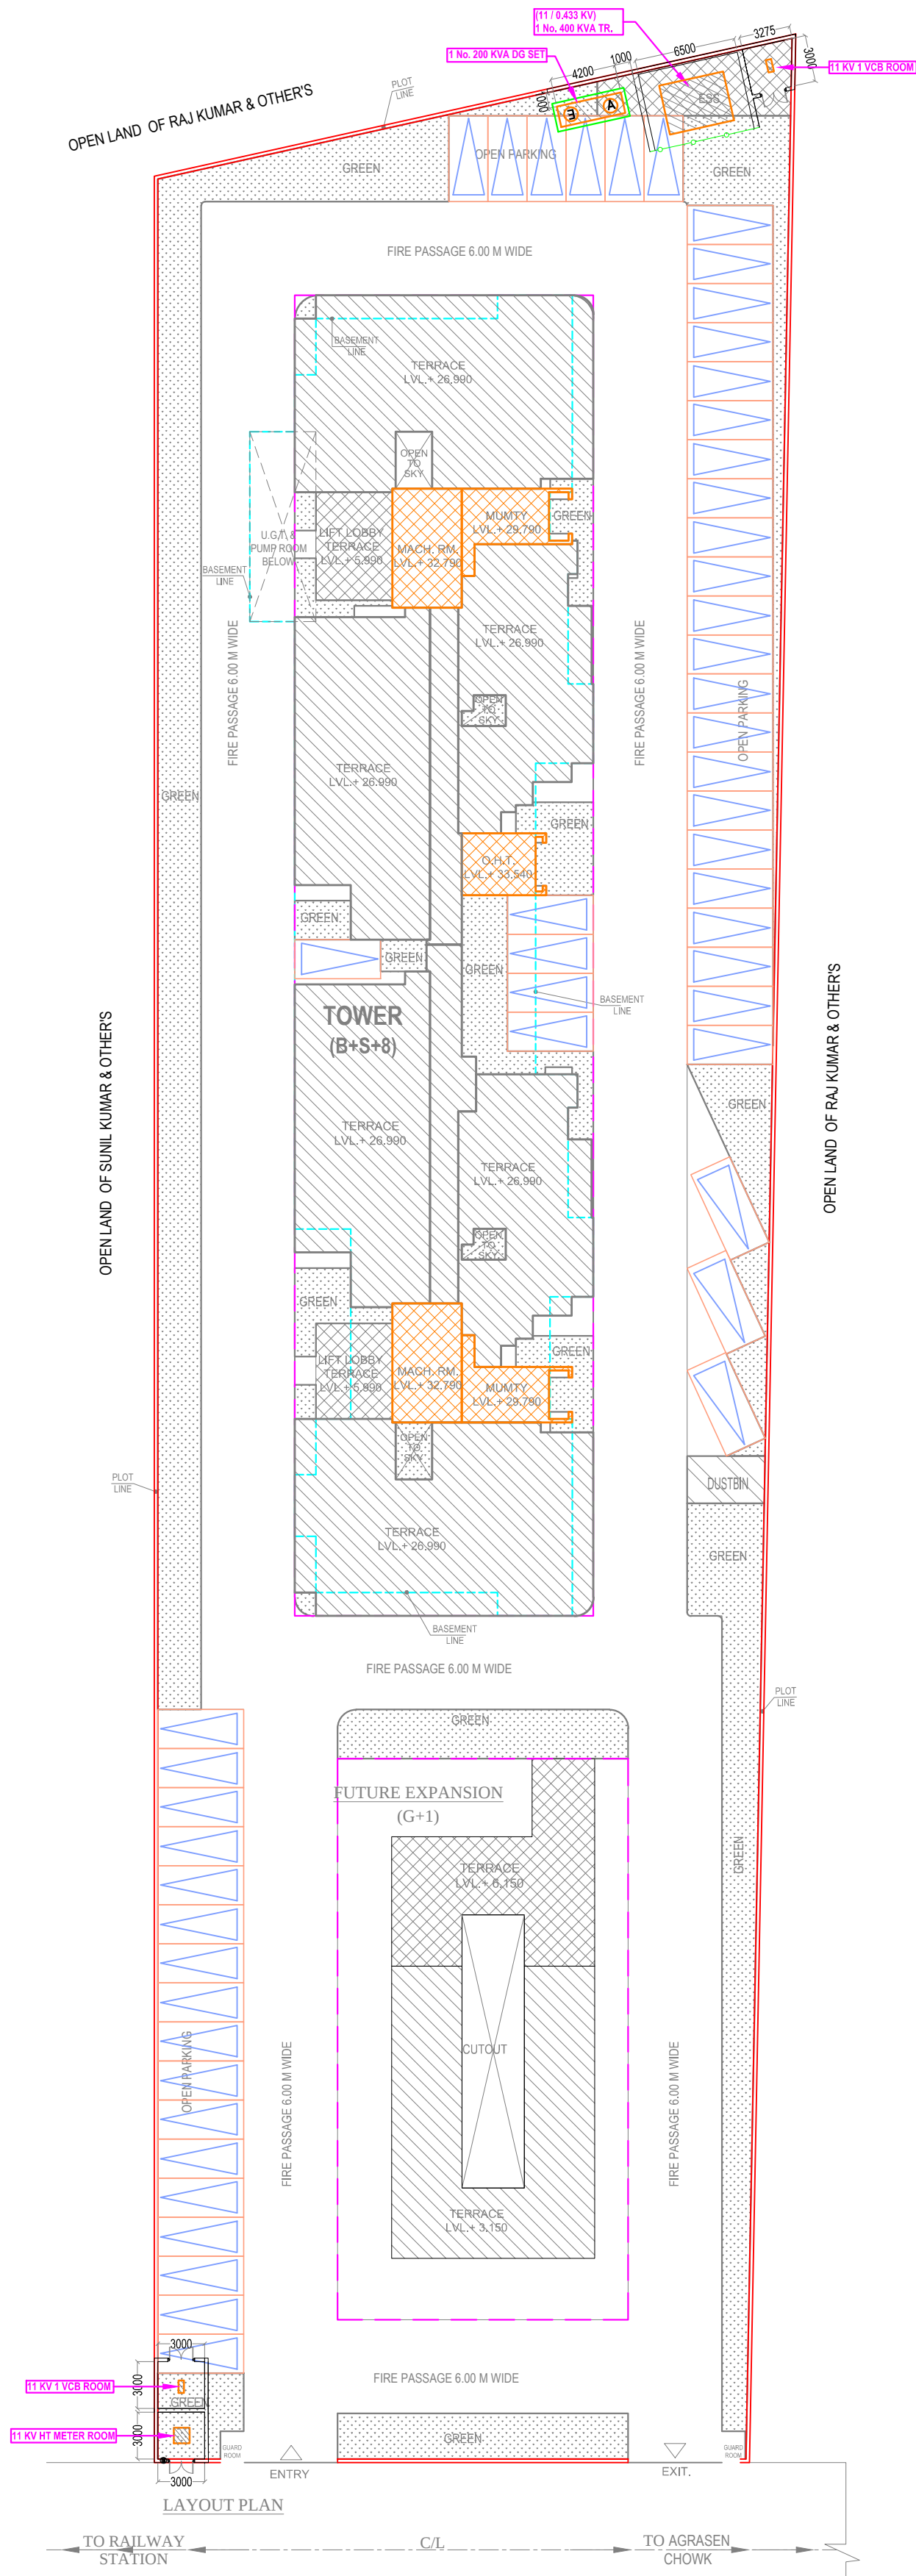

- NOTES : FOR HT, LT & VCB ROOM**
- 1) Clear height of 11 KV Meter room shall be minimum 3.6 mtr. below clear beam.
 - 2) Plinth Level of Meter room & VCB room shall be 450 mm above final finished ground level.

project
GROUP HOUSING FOR BAHRAICH
AT MAUJA-BAHRAICH KHAS,
MOHALLA-DIGIHA DISST. BAHRAICH (U.P.)

title
ELECTRICAL DRAWING
subtitle
MEP SETTING-OUT LAYOUT
AT SITE PLAN.

drawing released for
☐ APPROVAL
☐ ADVANCE COPY
☒ SUBMISSION
☐ CONSTRUCTION

drg. no.
BH / ELEC / EXT - 01
scale
1 : 250 @ A1
date
February, 2021

drawn by
Surjeet
designed by
Ateeq Ur Rehman
checked by
Anand Havella

architects
DEEPAK MEHTA & ASSOCIATES
ARCHITECTS, PLANNERS, VALUERS, LANDSCAPE & INTERIORS
PLOT NO. 16 ABHISHEK PLAZA L.S.C. MAYUR VIHAR PH II DELHI 91
PH: 65272180 TELEFAX: 22770180

services consultant
Consummate Engineering Services (P) Ltd.
Noida Office : B - 67, Sector - 67, Noida - 201 301
Tel : (0120) 2303500 (24 Lines)
Lko. Office : R 006, Rohtas Plumeria, Gomti Nagar, Lucknow
e mail : mail@cespl.in, website : www.cespl.in