


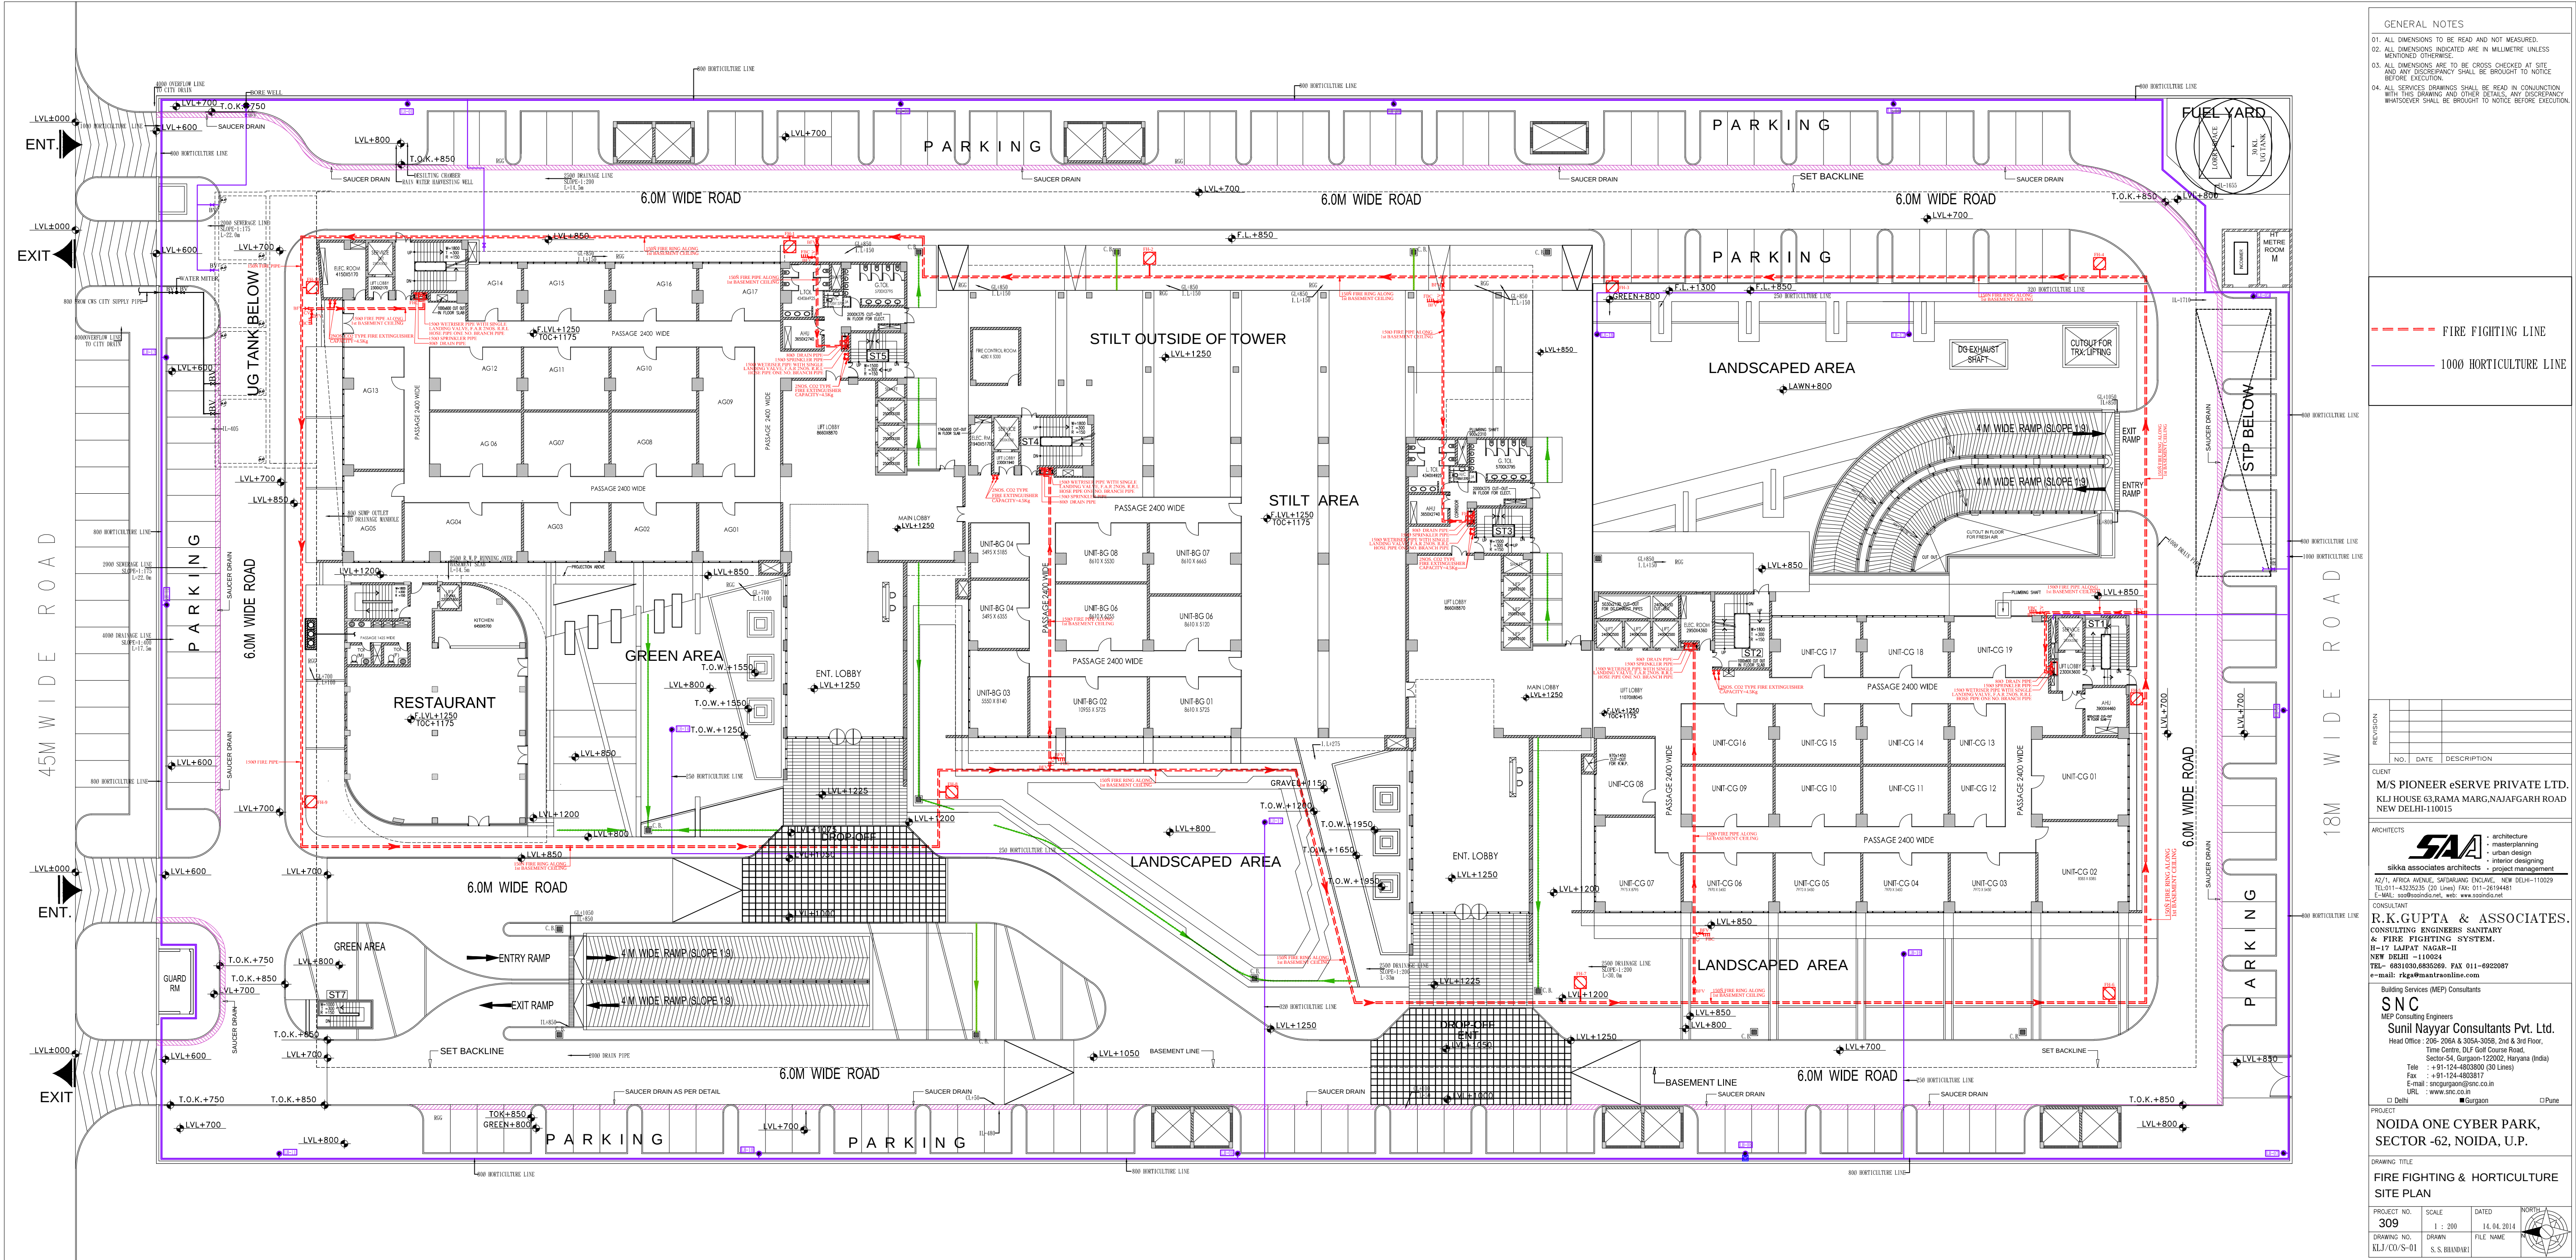

GENERAL NOTES

01. ALL DIMENSIONS TO BE READ AND NOT MEASURED.
02. ALL DIMENSIONS INDICATED ARE IN MILLIMETRE UNLESS MENTIONED OTHERWISE.
03. ALL DIMENSIONS ARE TO BE CHECKED AT SITE AND ANY DISCREPANCY SHALL BE BROUGHT TO NOTICE BEFORE EXECUTION.
04. ALL SERVICES DRAWINGS SHALL BE READ IN CONJUNCTION WITH THIS DRAWING AND OTHER DETAILS. ANY DISCREPANCY WHATSOEVER SHALL BE BROUGHT TO NOTICE BEFORE EXECUTION.

--- FIRE FIGHTING LINE
--- 1000 HORTICULTURE LINE

NO.	DATE	DESCRIPTION

CLIENT
M/S PIONEER eSERVE PRIVATE LTD.
KJ HOUSE 63, RAMA MARG, NAJAFGARH ROAD
NEW DELHI - 110015

ARCHITECTS
SAA
sikka associates architects
• architecture
• master planning
• urban design
• interior designing
• project management
A2/71, AFRA AVENUE, SARANSWARI ENCLAVE, NEW DELHI - 110029
TEL: 011-43202325 (20 Lines) FAX: 011-26194481
E-MAIL: saasikkasaa@gmail.com, web: www.sikkasaa.com

CONSULTANT
R.K.GUPTA & ASSOCIATES.
CONSULTING ENGINEERS SANITARY
& FIRE FIGHTING SYSTEM.
H-17 LAJPAT NAGAR-II
NEW DELHI - 110024
TEL: 08103068850, FAX: 011-6922087
E-MAIL: rkgs@mantraonline.com

Building Services (MEP) Consultants
SNC
MEP Consulting Engineers
Sunil Nayyar Consultants Pvt. Ltd.
Head Office: 205, 205A & 205B-205D, 3rd & 4th Floor,
Time Centre, DLF Golf Course Road,
Sector-54, Gurgaon-122002, Haryana (India)
Tel: +91-124-4803800 (20 Lines)
Fax: +91-124-4803817
E-mail: sncgurgaon@snc.co.in
URL: www.snc.co.in

PROJECT
Noida One Cyber Park,
SECTOR - 62, NOIDA, U.P.

DRAWING TITLE
**FIRE FIGHTING & HORTICULTURE
SITE PLAN**

PROJECT NO. 309
SCALE 1 : 200
DATED 14.04.2014
DRAWN S.S. BHADURI
FILE NAME

