
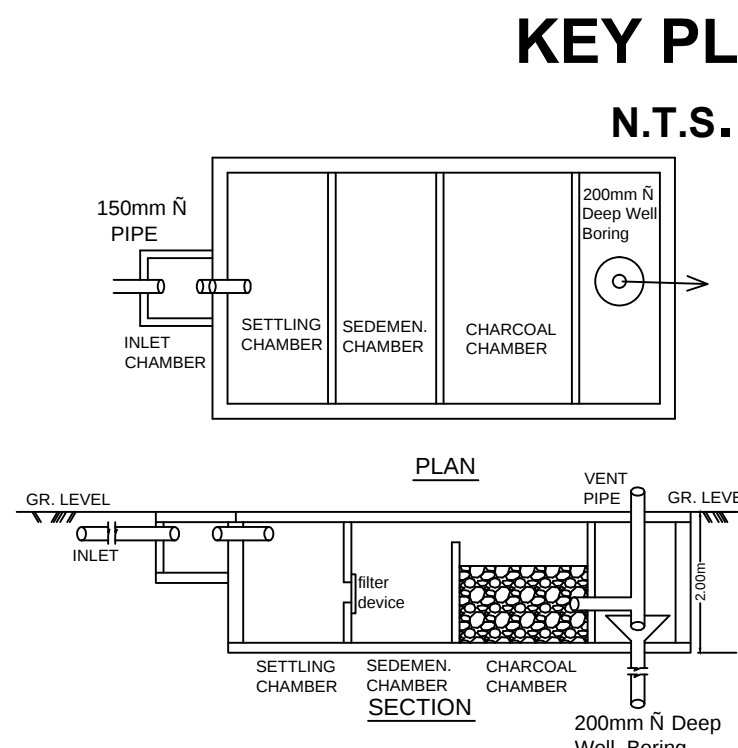
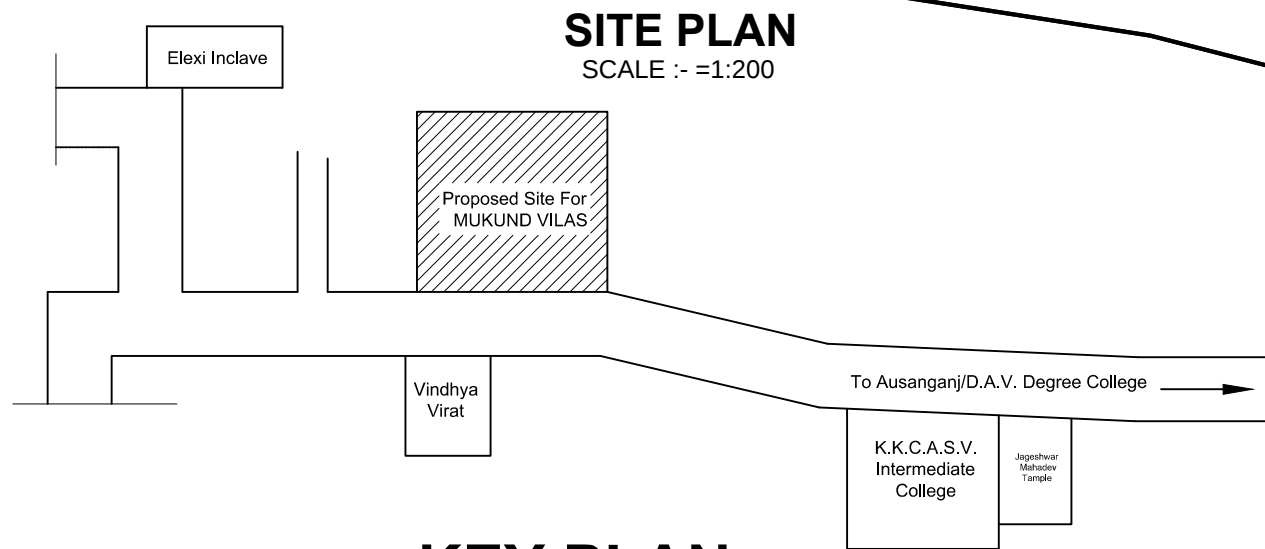
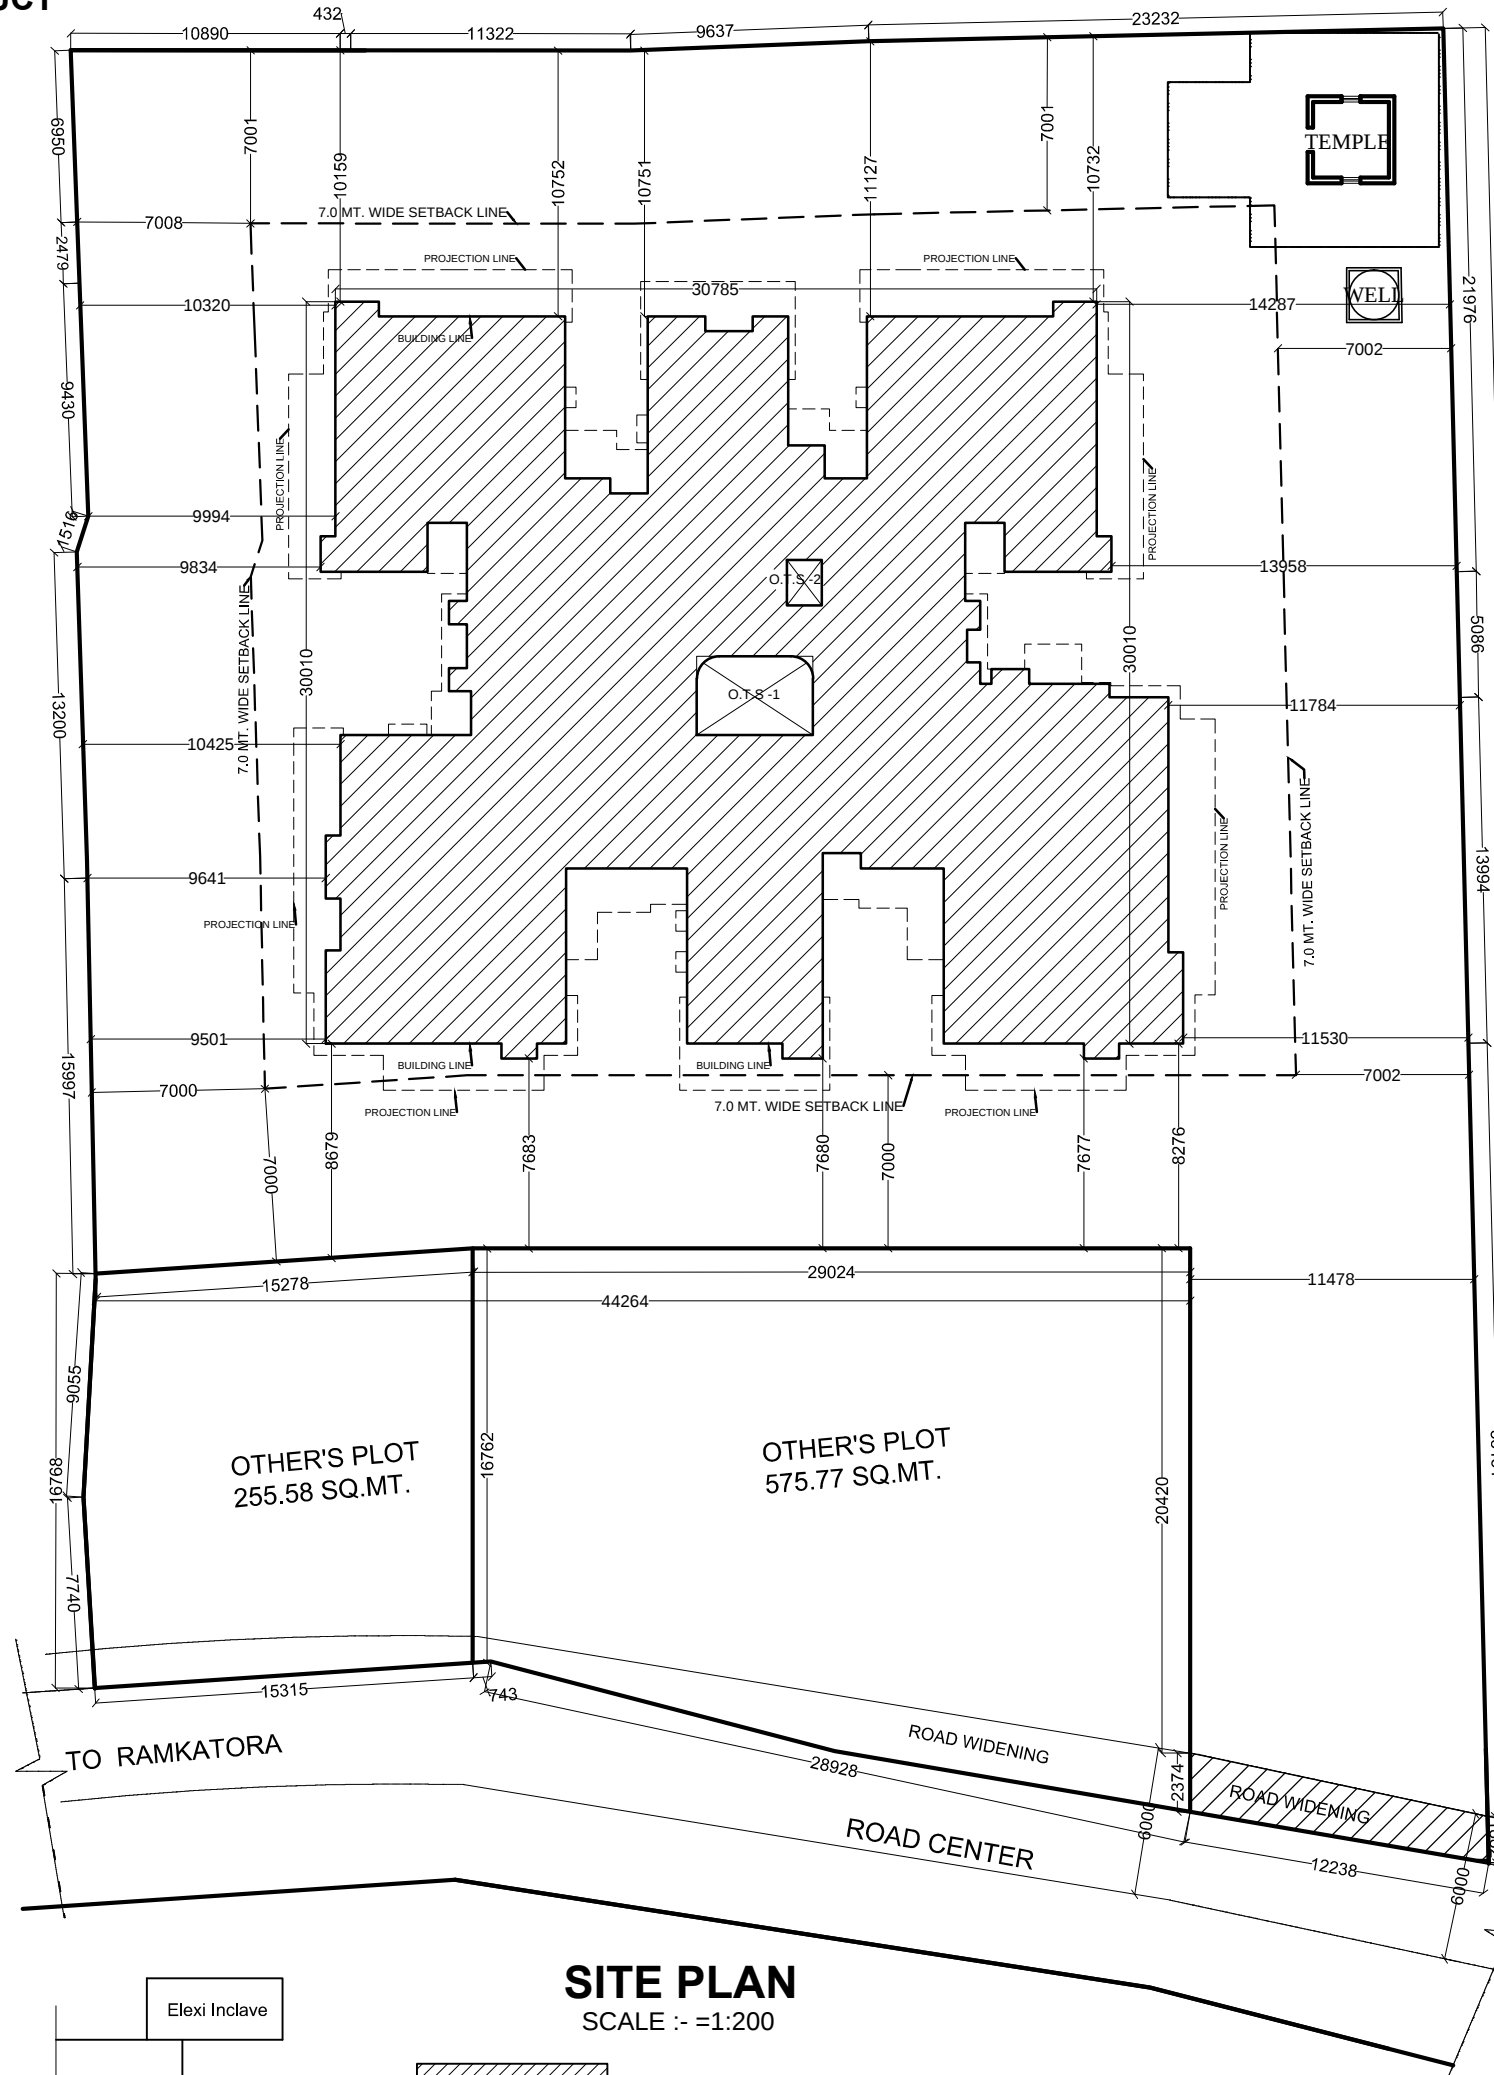


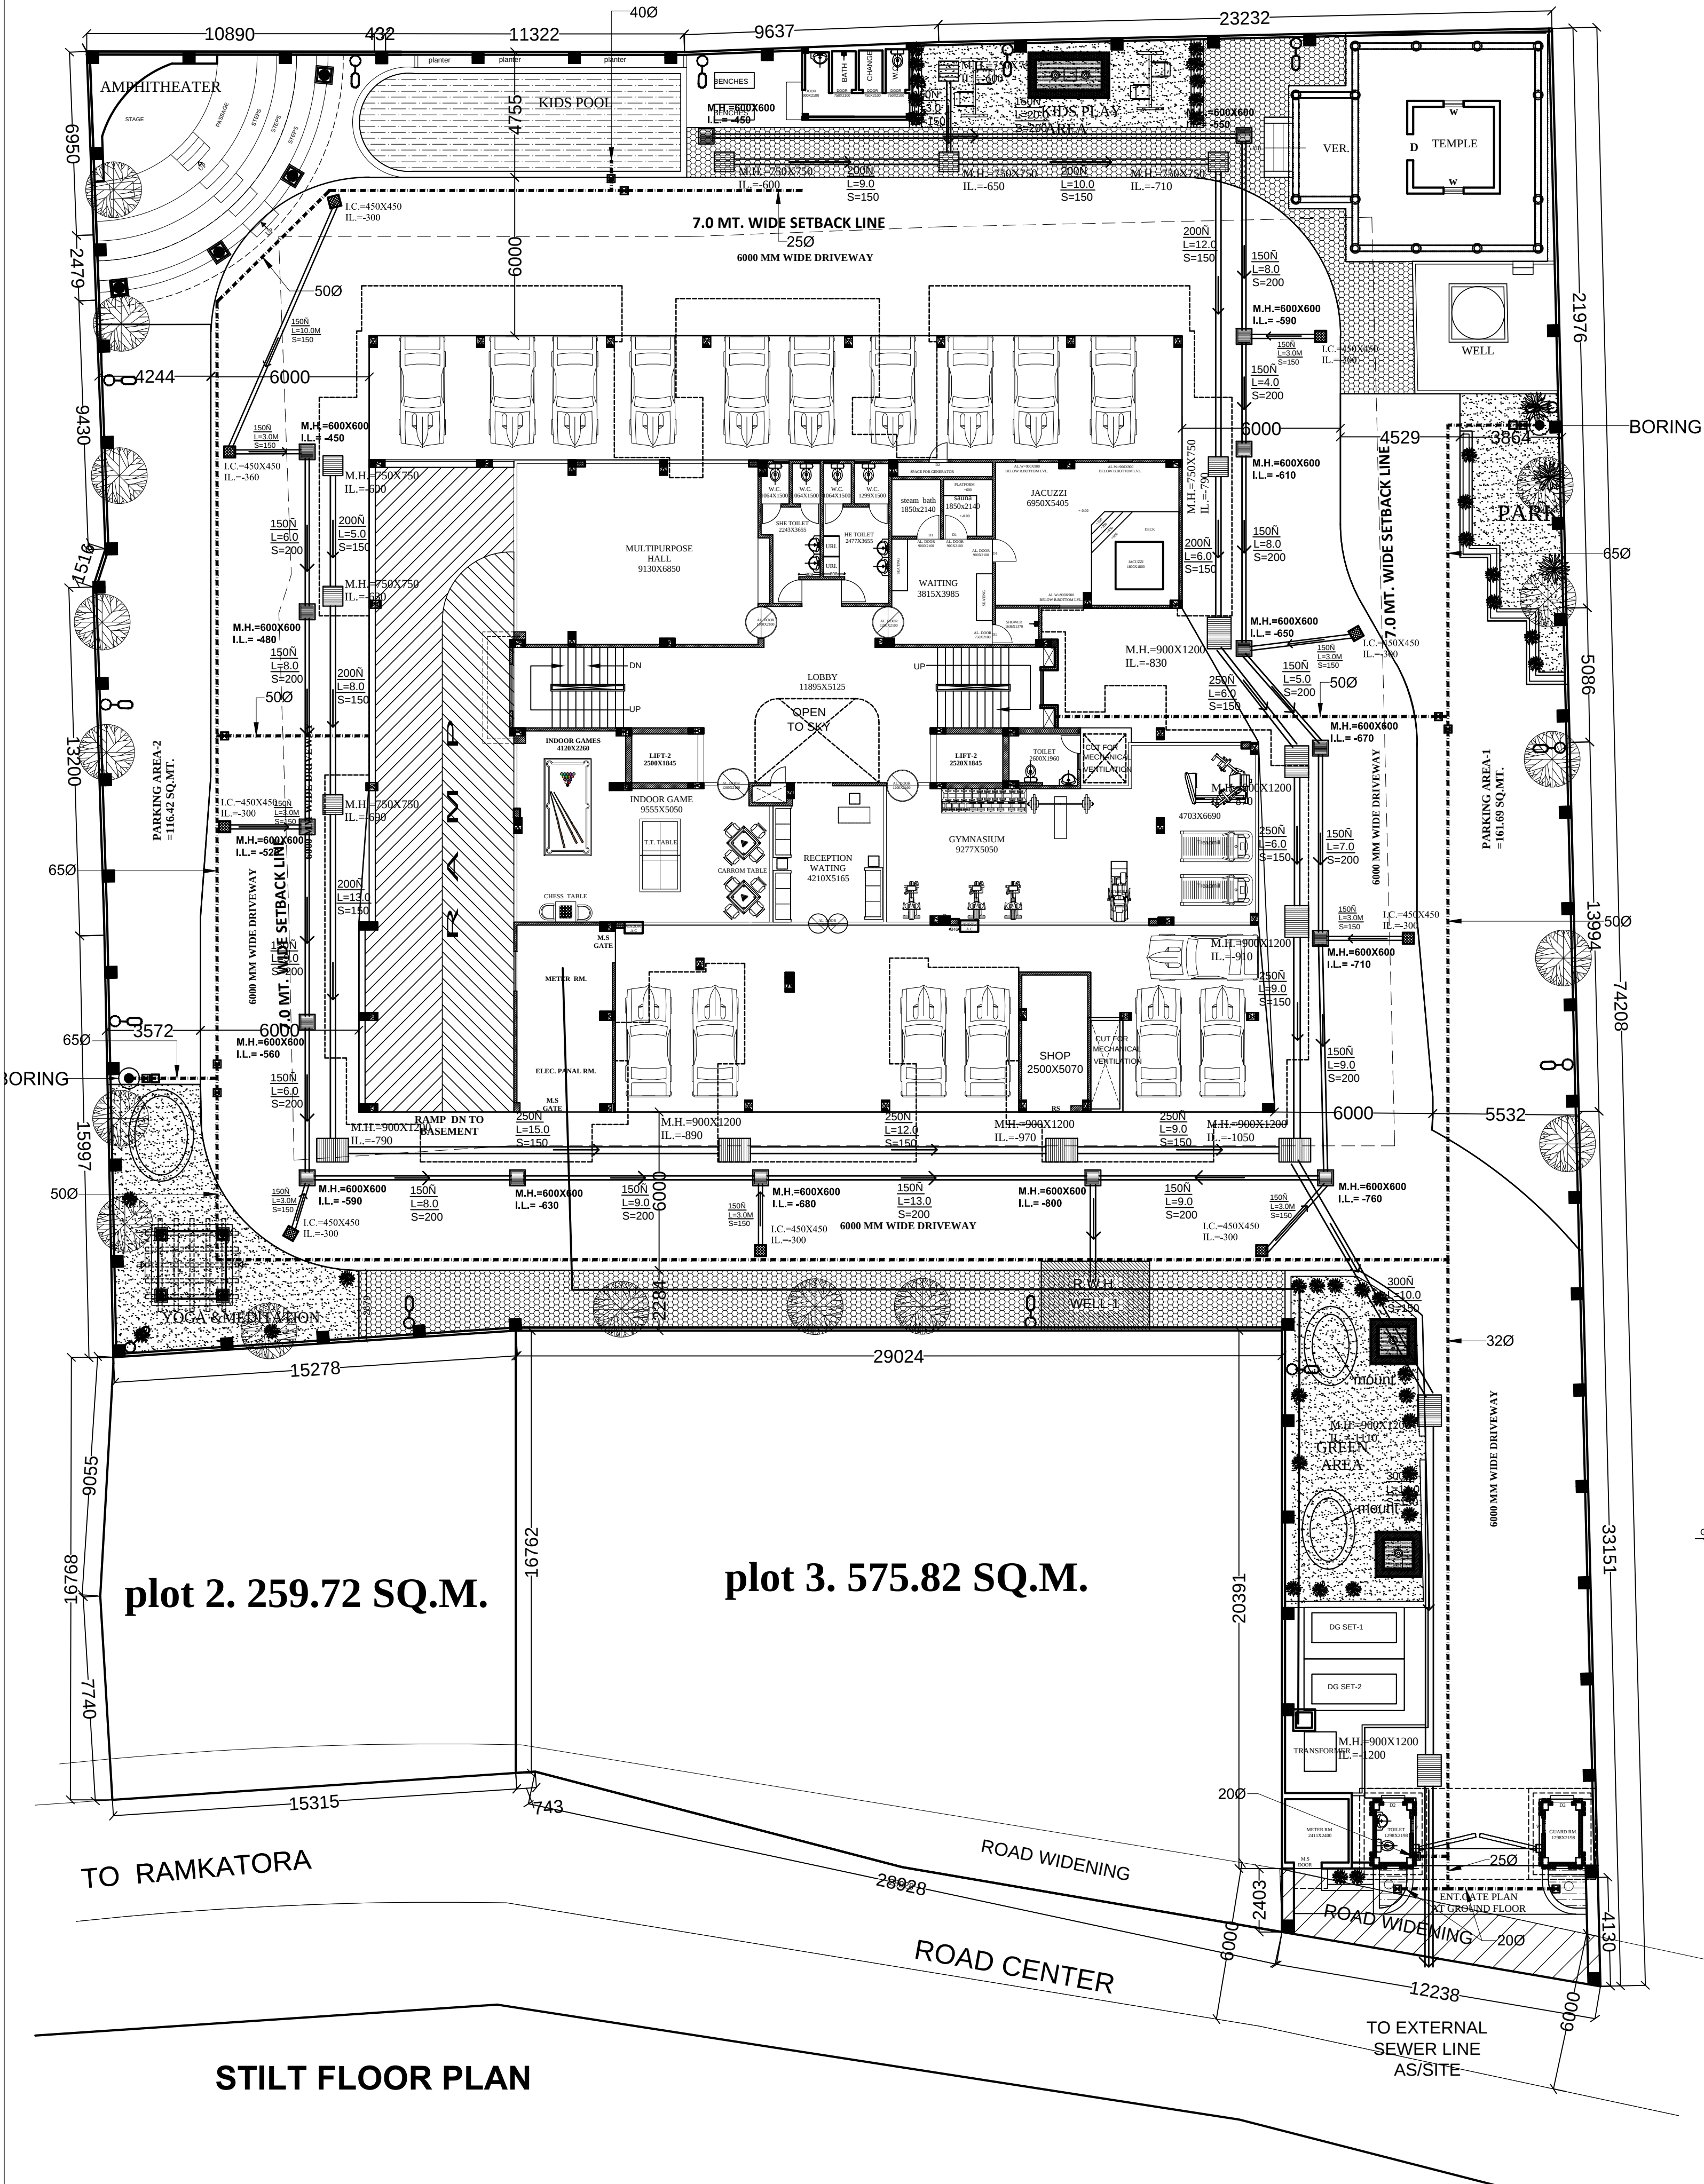

DETAIL OF RAIN WATER HARVESTING SYSTEM (NOT TO SCALE)

LEGEND:- ELECTRICAL

- | | |
|----|---|
| 1. | CABLE TRAY |
| 2. | PVC PIPE SLEEVE FOR CABLE |
| 3. | GATE LIGHT WITH PLC (2 X 18 WATT) |
| 4. | DOWN LIGHT RECESSS UITLEABLE FOR PLC(1 X 18 WATT) |
| 5. | POLE (12 FT. LONG) WITH 1X18/26 WATT. |
| 6. | BOLLARD LIGHT WITH (1 X 15 TO 26 WATT) |
| 7. | UNDER GROUND CABLE (PVC. INSULATED ARMOURD ALUMINIUM) |
| 8. | E.M.H. |
| 9. | E.S.S/GEN SET AS PER SITE LOCATION |

KEY PLAN

N.T.S.

SANITARY DRAWING

LEGEND:- (SANITARY)

- | SL. | SYMBOL | DESCRIPTION |
|-----|------------------------|-------------------------------|
| 1. | IL. | INVERT LEVEL |
| 2. | 150N
L=7.0
S=150 | DIA/LENGTH/SLOPE |
| 3. | | SEWER MANHOLE |
| 4. | | SEWER PIPE NETWORK |
| 5. | | RAIN WATER HARVESTING MANHOLE |
| 6. | | RAIN WATER HARVESTING PIT |
| 7. | | WATER SUPPLY PIPE |
| 8. | | GATE VALVE |
| 9. | | CHECK VALVE |
| 10. | | FIRE BRIGADE INLET |
| 11. | | M.S.PIPE |

FIRE FIGHTING DIAGRAM

CERTIFICATE

1-CERTIFIED THAT THERE IS NO PROP. OR ROAD MAINTAINED BY ANY GOVT. DEPTT. OR BELONGING TO RLY ADMINT. WITH IN 30.48 MT FROM THE SITE IN QUESTION
2-PLAN HAS BEEN PREPARED AS PER BUILDING BYE LAWS 2008 & MASTER PLAN 2011.

SPECIFICATION

1. BRICK WORK IN CEMENT MORTAR 1:6
2. LEAN CONC. 1:4:8
3. PLASTER ON R. C. C. SURFACE 1:4
4. PLASTER ON BRICK WORK 1:6
5. DOOR'S & WINDOW FRAME ARE IN SAL WOOD
6. R.C.C. FRAME STRUCTUREAS PER DESIGN

PROJECT:

COMPOUNDING&COMPLETION RESIDENTIAL GROUP HOUSING OF ARAZI BANDOBASTI NO-2917 SITUATED AT NAGAR NIGAM NO.- K 67/80 MOUZA JAIPUR MOHALLA ISHWERHANGI (NARHARPURA) WARD-KOTWALI CITY- VARANASI.

OWNED BY:

M/S. RUDRA REALTECH PVT.LTD. RAMSHWER MALIYA, FIRST VAILANE HAWDA 711101 WEST BANGAL . through its authorized signatory--- MR.ANAND KUMAR AGARWAL S/O. LATE ASHOK KUMAR AGARWAL C.K.65/159A, PIYARI KALA , HOWK, VARANASI.

DRG. TITLE

STILT FLOOR, SITE PLAN, & KEY PLAN

SCALE: 1:100

DATED: 20.05.2014

DRN.BY: Er.SACHCHIDANAND

OWNER'S SIGN

ARCHITECT:

ASEEM SANRACHANA DESIGN LTD. 5 UGF , Himalaya House , 23 Kasturba Gandhi Marg, Connaught Place, New Delhi - 110001

ARCHITECT'S SIGN