


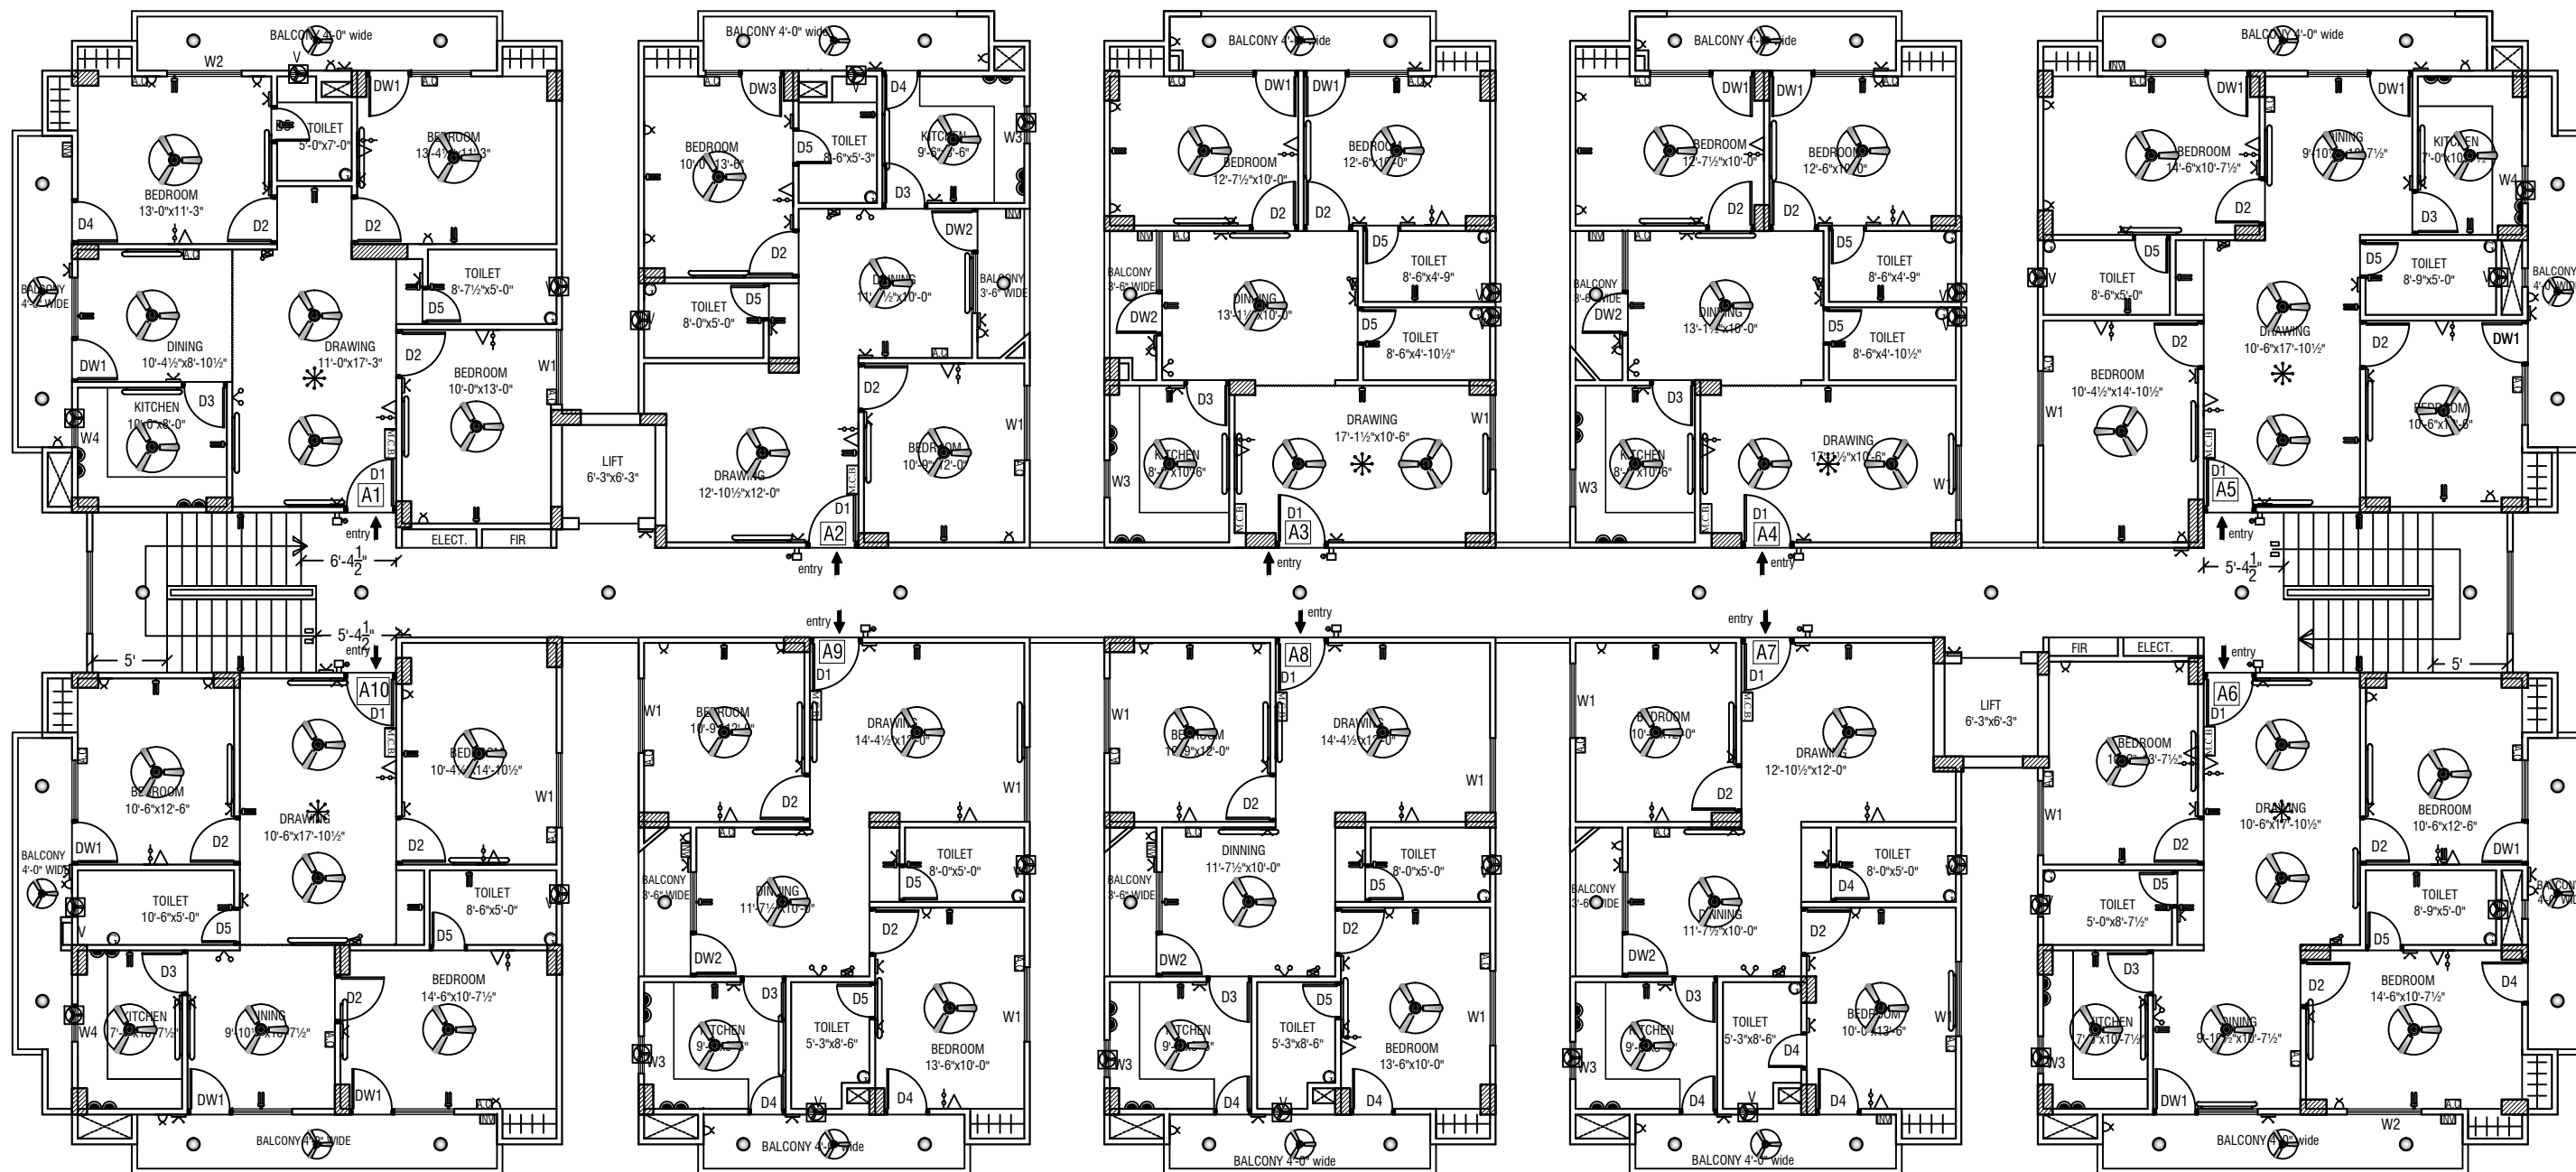

CELLING LIGHT	15 AMP. PLUG SOCKET
WALL BRACKET	T.V. ANTENNA SOCKET(P)
TUBE LIGHT	A.C./COOLAR
EXHAUST	FANCY LIGHT
FAN	CABLE POINT
SWITCH BOARD	DOOR BELL POSITION
MAIN CUT BOARD	DOORBELL SWITCH
INTER COM	GYZER
POWER POINT	INVERTER

CLIENT NAME:----

Mr. SANJEEV KAPOOR AT KATESAR

DRG.TITLE:---

TYPICAL FLOOR ELECTRICAL PLAN

DRAWN BY:---

PURNIMA

DATE:---

27-08-2016

CHECKED BY:---

REVISION NO.:---

SCALE:---

1"=1'



Er. S.K. GUPTA

(B.TECH. HONS.)

(CHARTERED ENGINEER)

A-1,VIRAT VILLA, MAHAMOORGANJ - VARANASI.

MOB.NO. - 9559830008 , 9453760086

EMAIL ID:-- officeskgupta@gmail.com