


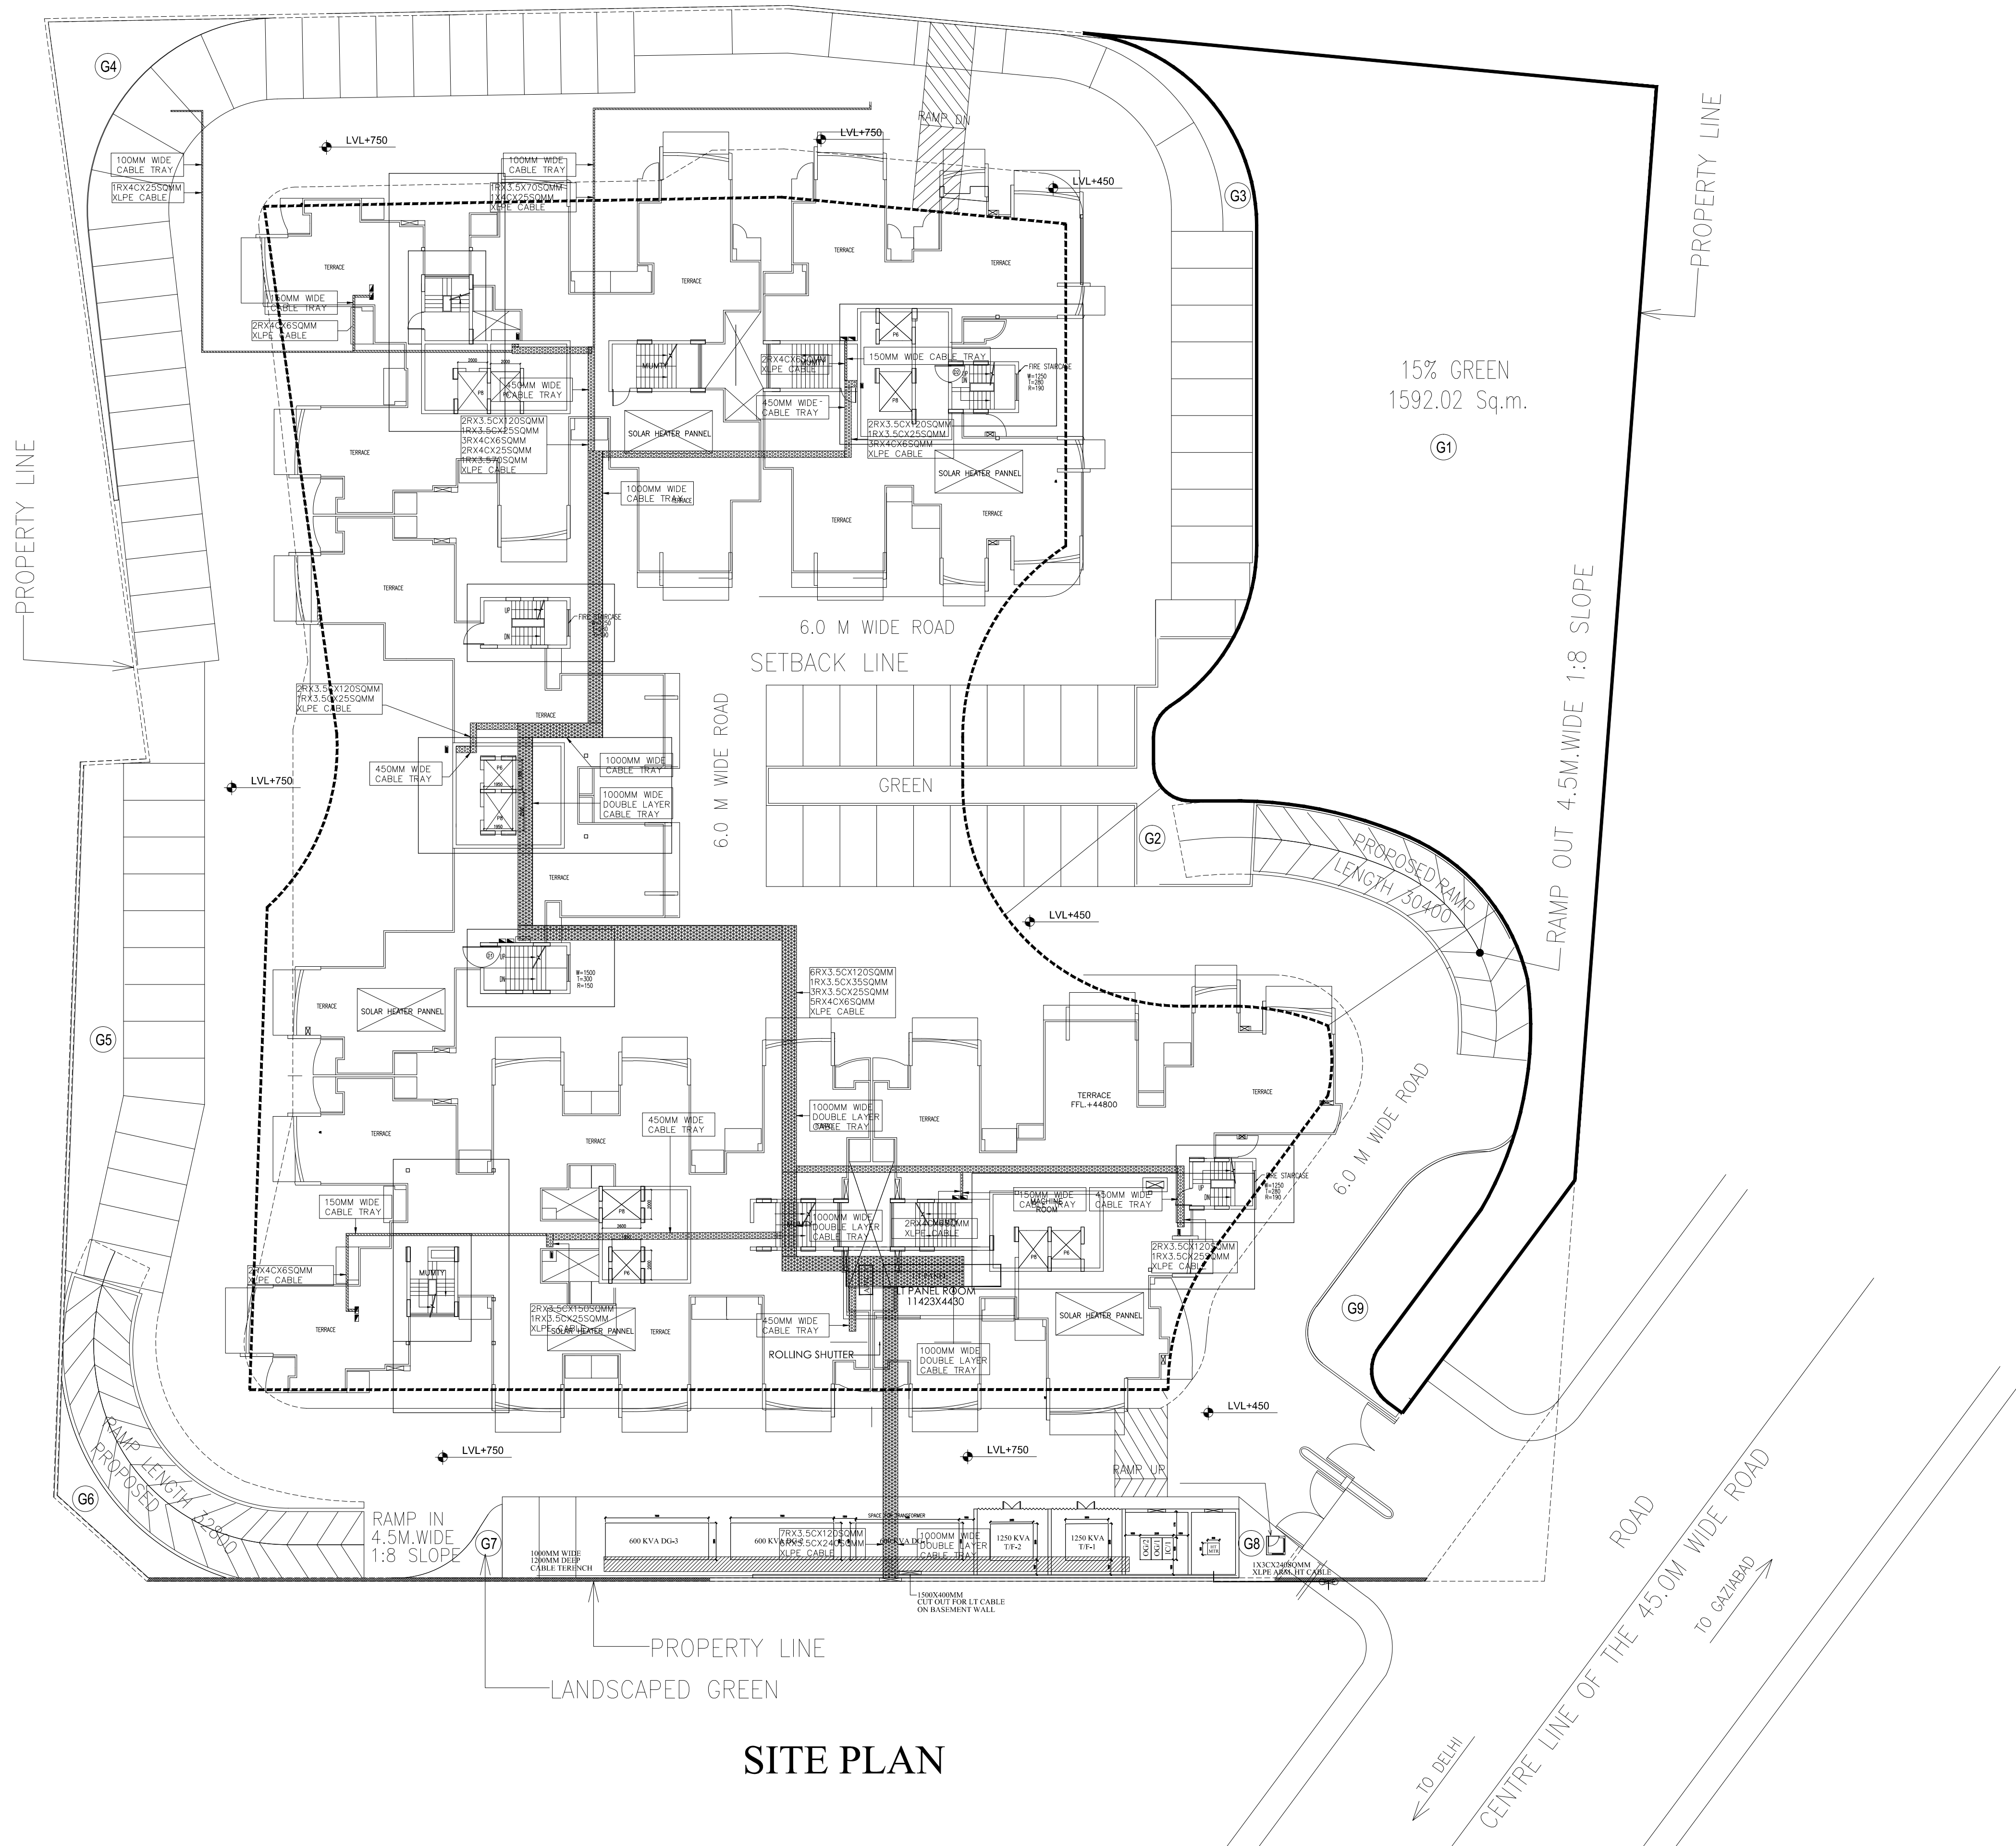

SITE PLAN

- NOTES:-
1. ALL DIMENSIONS ARE IN MILLIMETER.
 2. ALL LEVELS ARE IN MILLIMETER.
 3. ALL THE AREAS INDICATED ARE IN SQ.M
 4. COLUMNS ARE ONLY INDICATIVE AND WILL BE AS PER RELEVANT STRUCTURAL DRAWINGS.
 5. ALL EXTERNAL WALLS ARE 230TH.
 6. ALL INTERNAL WALLS ARE 115TH. UNLESS OTHERWISE MENTIONED

LEGEND:-		
S.NO.	SYMBOL	DESCRIPTION
1.		750mm WIDE HT CABLE TRENCH
2.		600mm WIDE CABLE TRENCH
3.		1050mm WIDE CABLE TRENCH
4.		150mm WIDE CABLE TRENCH
5.		150mm WIDE CABLE TRAY
6.		750mm WIDE CABLE TRAY
7.		1000mm WIDE CABLE TRAY
8.		MAN HOLE (1500X1500X1000 MM)
9.		HUME PIPE
10.		LT CABLE
11.		HT CABLE

SUBMISSION DRAWING
INCLUDING PURCHASABLE F.A.R.
COMPOUNDED DRAWING

OWNERS SIGNATURE Mr.HARENDRA SINGH KHOKHAR
Director

ARCHITECT'S SIGNATURE Architect ANURAG GUPTA
Registration No.CA/85/9138

PROJECT K.M.RESIDENCY

PROJECT PROPOSED GROUP HOUSING FOR
M/S. S.R.B. PROMOTERS (P) LTD.
KHASRA NO. 308.309,310,311 & 312
AT NOOR NAGAR, GHAZIABAD.

Architect
ANURAG GUPTA

VASTU SRJAN
ARCHITECTS, ENGINEERS & PLANNERS
82, DEFENCE ENCLAVE, VIKAS MARG, DELHI 110092 (INDIA)
PHONE: 011-22507733, email address:- vastu@vsgd.com, vsgd.co.in

DRAWN BY	Harbans	SCALE	1=250	PLOT No.	--
CHECKED BY	AG	DATE	JUN, 18	JOB No.	1006

DRG.TITLE	DWG. No.
ELECTRICAL LAYOUT	1006/EL-01