


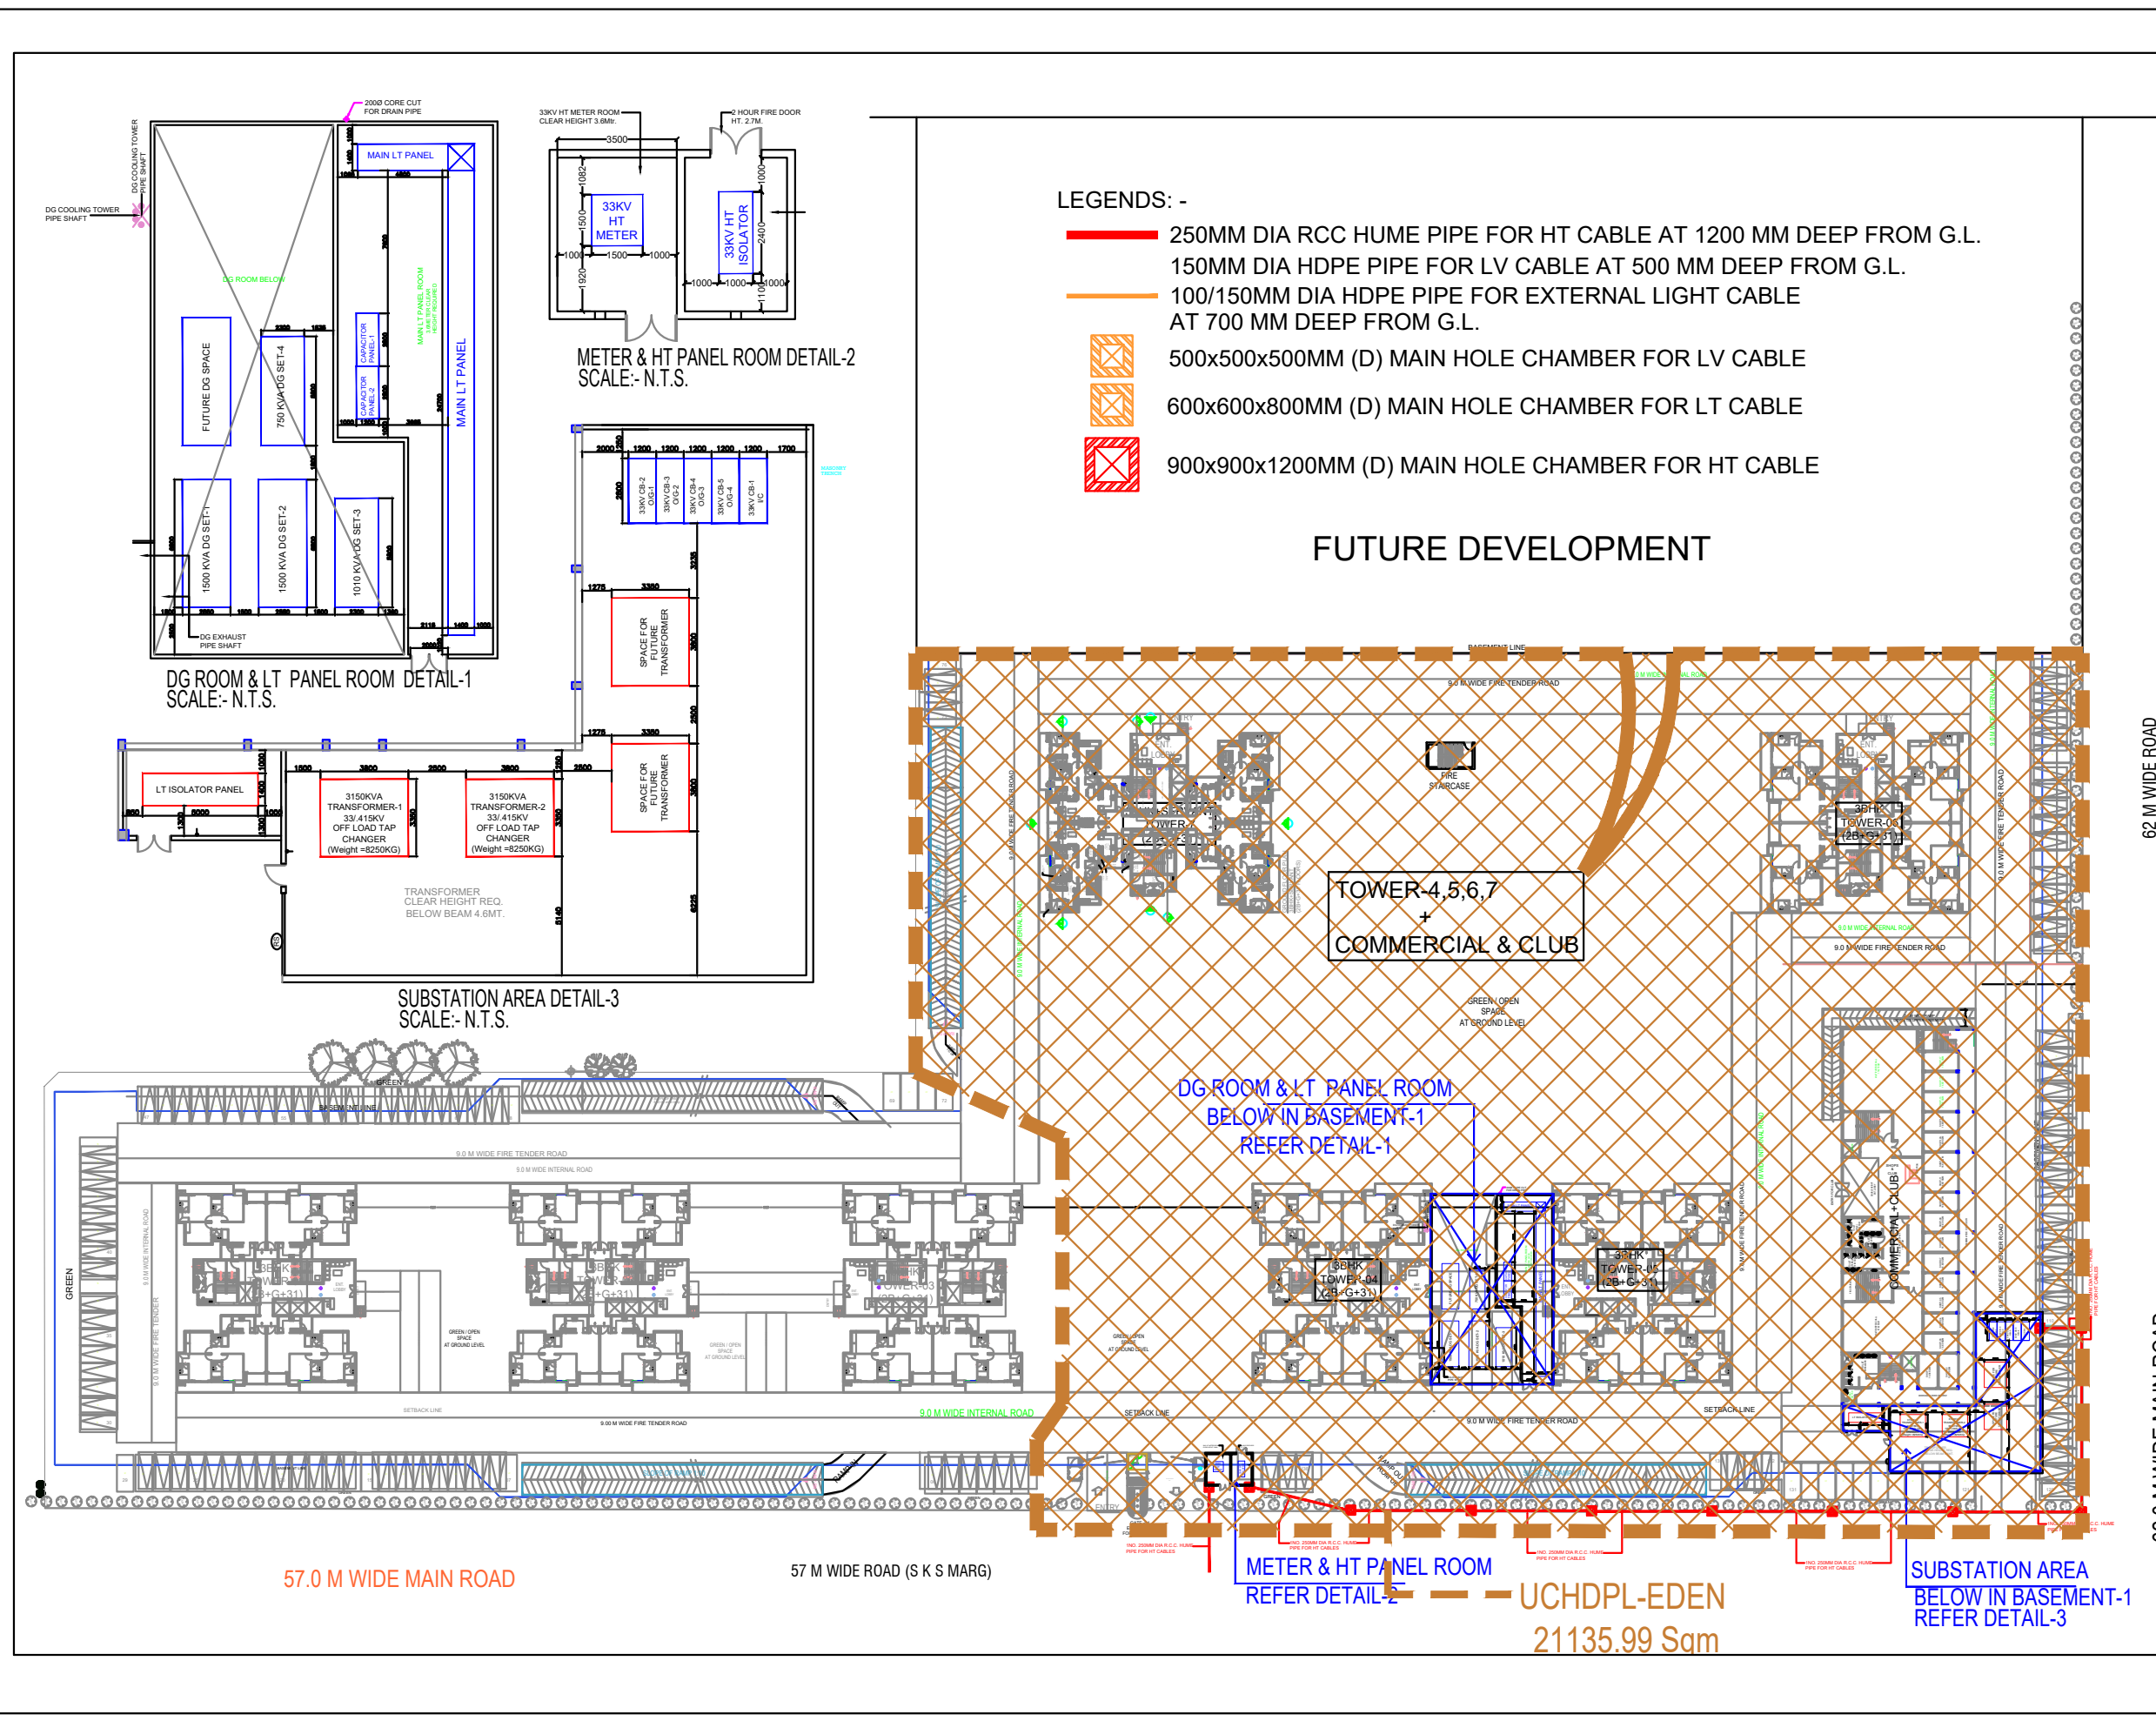

LEGENDS: -

- 250MM DIA RCC HUME PIPE FOR HT CABLE AT 1200 MM DEEP FROM G.L.
- 150MM DIA HDPE PIPE FOR LV CABLE AT 500 MM DEEP FROM G.L.
- 100/150MM DIA HDPE PIPE FOR EXTERNAL LIGHT CABLE AT 700 MM DEEP FROM G.L.
- 500x500x500MM (D) MAIN HOLE CHAMBER FOR LV CABLE
- 600x600x800MM (D) MAIN HOLE CHAMBER FOR LT CABLE
- 900x900x1200MM (D) MAIN HOLE CHAMBER FOR HT CABLE

FUTURE DEVELOPMENT

Architect :
Wave Infratech Pvt. Ltd.
C-1, Sector-3
Noida, U.P. 201301
TEL: +91 120 4180500

Structure Consultant
OPTIMIZATION CONSULTANTS
202 & 203, HIMALAND HOUSE,
KARAMPURA COMMERCIAL COMPLEX,
NEW DELHI - 110015
E-mail: optpro34@yahoo.com

MEP Consultant
ELECTRO CONSULTANTS
A-222, Shivallik, Malviya Nagar,
New Delhi- 110017
PH: (011)26684140, 26688712
email: electroconsultants@gmail.com

Landscape Consultant
AECOM

KEY PLAN

OWNER
UPPAL CHADHA HITECH DEVELOPERS
PVT. LTD.

PROJECT
EDEN (GH08-PH03, WAVE CITY)

REV.NO	DESCRIPTION	DATE

TITLE
SITE PLAN
ELECTRICAL ESS AND SUB STATION LAYOUT

DRAWN	CHECKED	DWG. NO.	REV. NO.
DUSHYANT	ANIL	EDEN/PH03/ST/EL-01	R0

SCALE
1:500

DATE
29.06.2024

PURPOSE
SUBMISSION DRAWINGS