



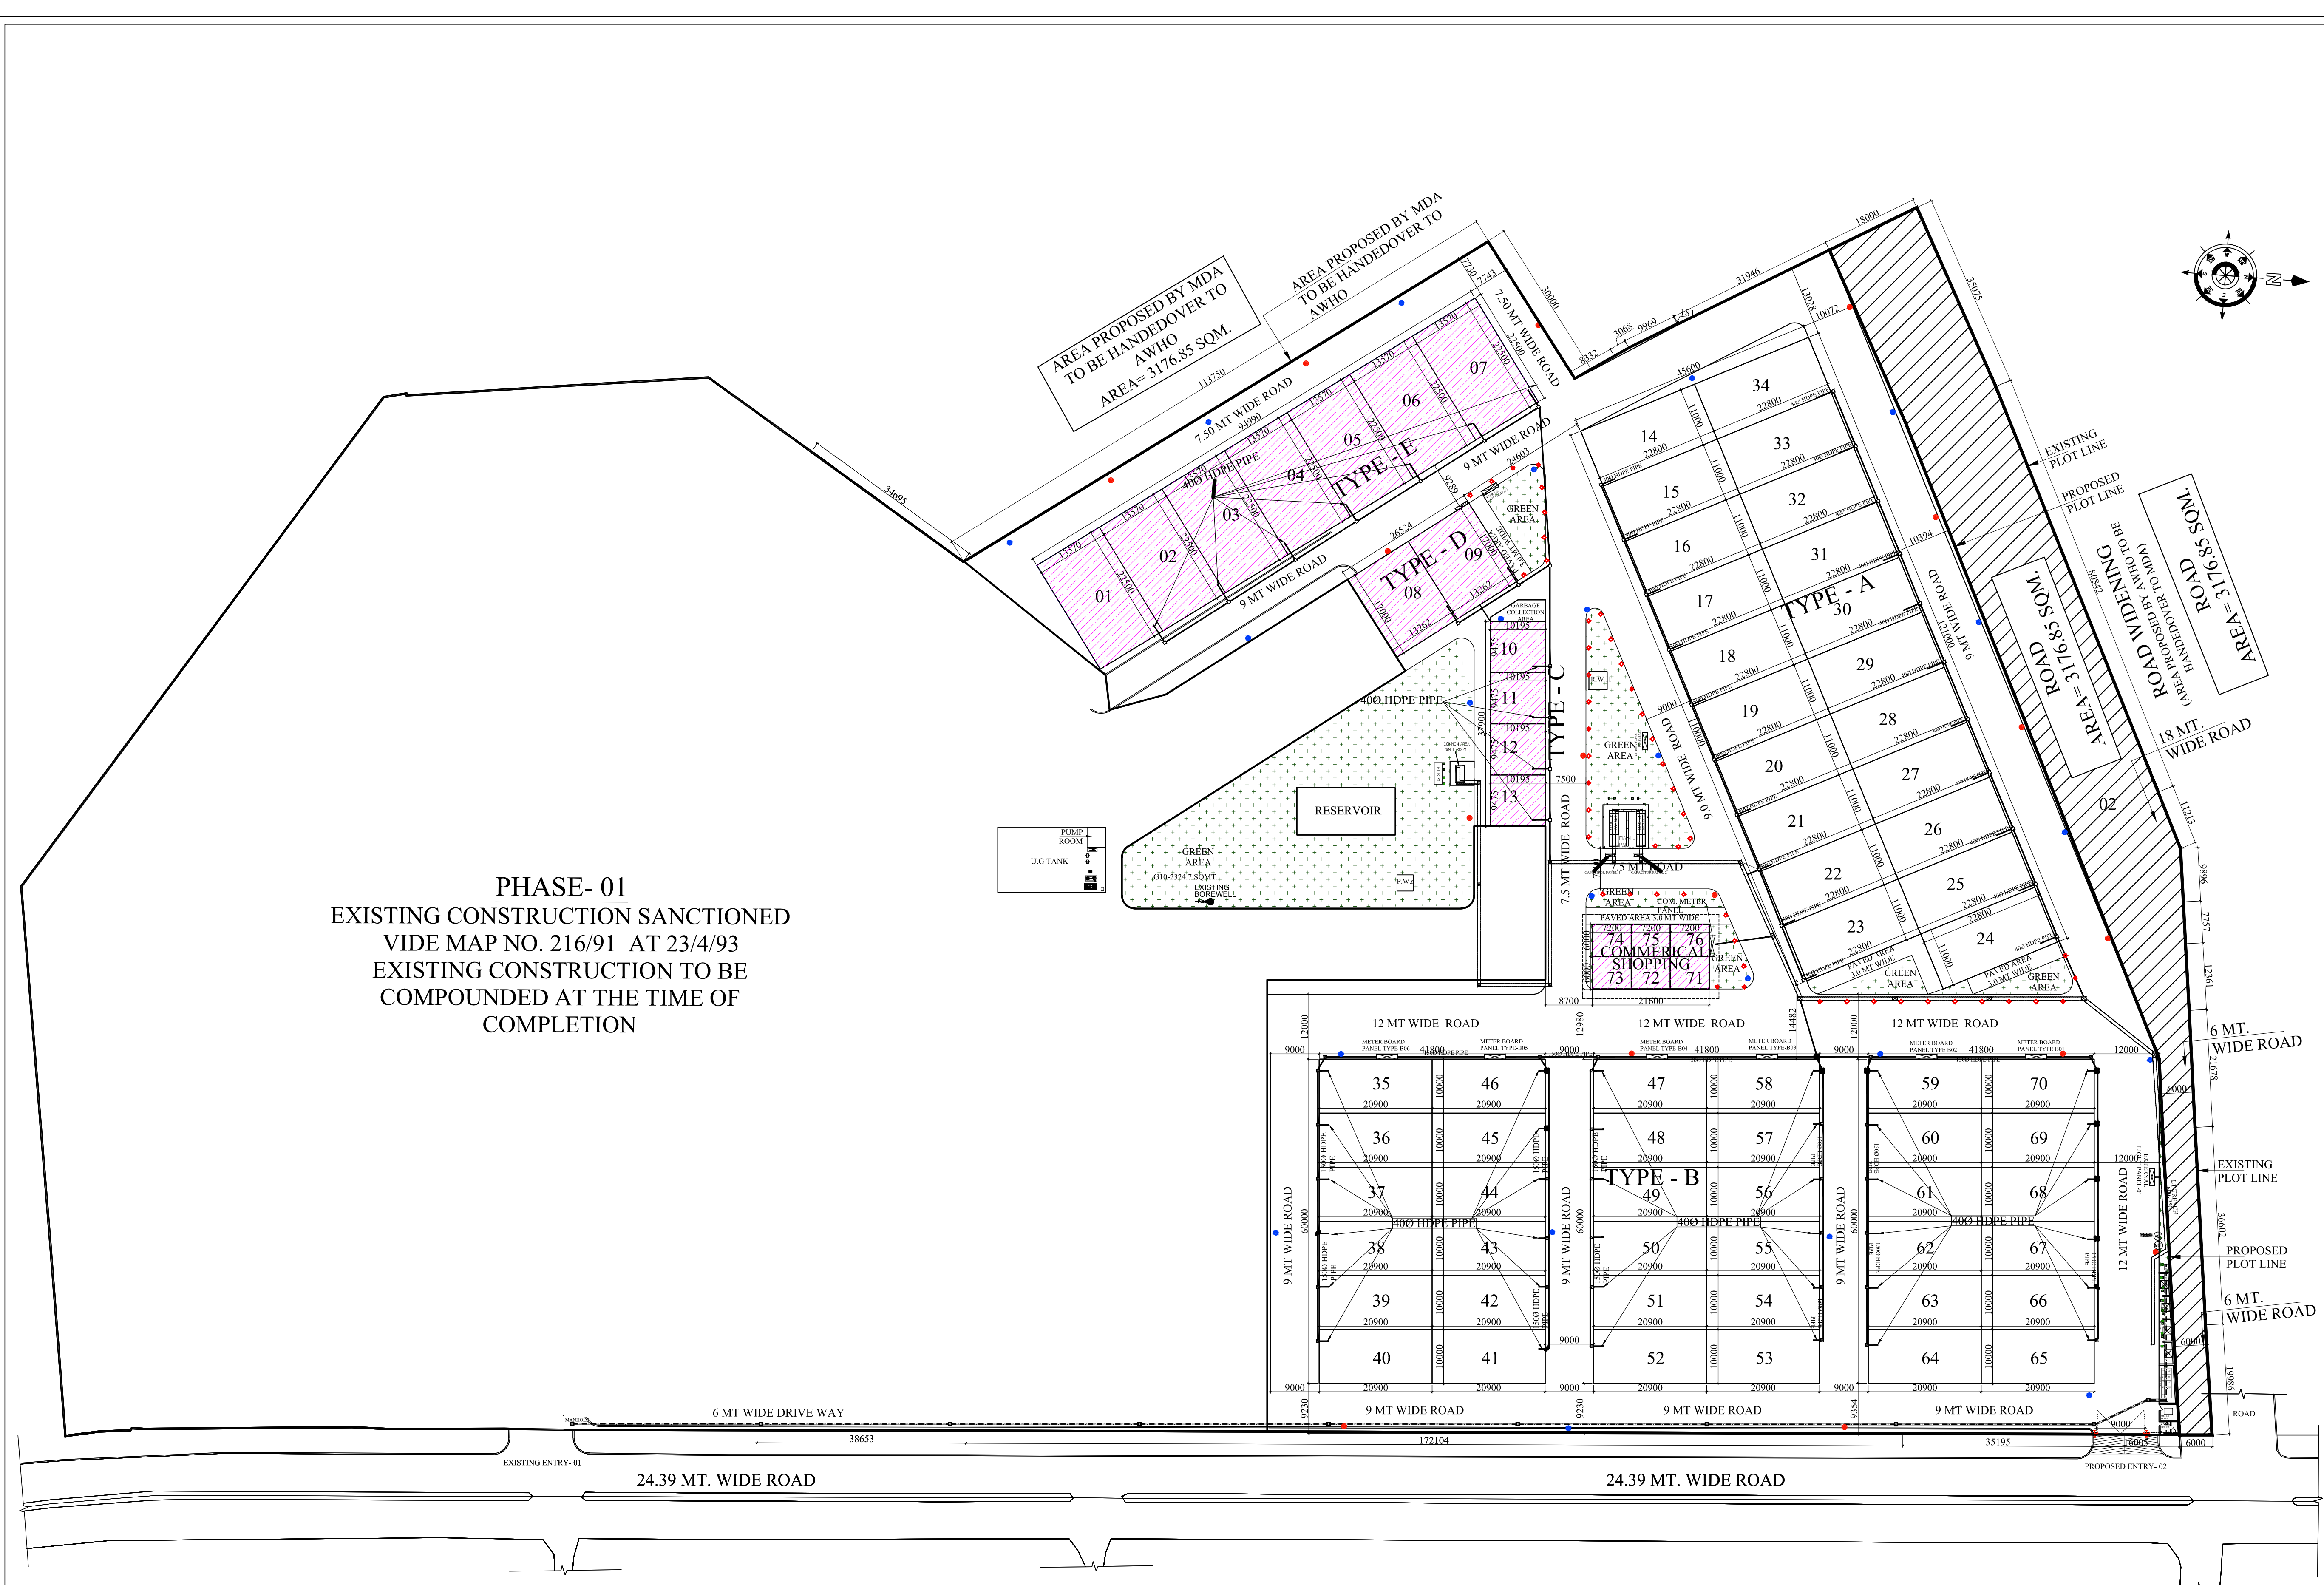

PHASE- 01
EXISTING CONSTRUCTION SANCTIONED
VIDE MAP NO. 216/91 AT 23/4/93
EXISTING CONSTRUCTION TO BE
COMPOUNDED AT THE TIME OF
COMPLETION

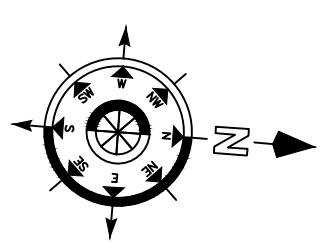

GENERAL NOTES:			
1. THIS DRAWING IS THE PROPERTY OF M/S. R T & ASSOCIATES. PVT. LTD. & SHALL NOT BE USED OR REPRODUCED IN ANY WAY WITHOUT PERMISSION IN WRITTEN.			
2. ALL DIMENSIONS ARE IN MILLIMETERS AND LEVELS ARE IN METERS UNLESS MENTIONED OTHERWISE.			
3. ALL DIMENSIONS ARE TO BE CHECKED AND CO-RELATED WITH THE RELEVANT ARCHITECTURAL, STRUCTURAL AND SERVICES DRAWINGS AND ANY AMBIGUITY, DISCREPANCY OR OMISSION SHALL BE BROUGHT IN TO NOTICE OF ARCHITECT.			
4. DRAWINGS AND DIMENSIONS SHOWN IN THIS SHEET ARE SUPERCEDED BY DETAIL DRAWING OF THE CORRESPONDENCE.			
5. ALL WALLS ARE OF BRICK OF 115 MM AND 230 MM THICK.			
S.NO	SYMBOL	DESCRIPTION	QTY.
01		POLE LIGHT (NORMAL)	
02		EMERGENCY STREET LIGHT	
03		TRANSFORMER	
04		VCB	
05		METER BOARD PANEL	
06		DIESEL GENERATOR SET	
07		BOLARD LIGHT	
08		HT CABLE TRENCH	
09		LT CABLE TRENCH	

REVISIONS	
R	DATE
PROJECT NAME	
AWHO RAKSHAPURAM P.H-II	
ADDRESS	
PROPOSED LAYOUT PLAN FOR M.D.A VOJNA RAKSHAPURAM, MAWANA ROAD, MEERUT U.P.	
CLIENT NAME	
ARMY WELFARE HOUSING ORGANISATION, KASHMIR HOUSE, RAJAJI MARG, NEW DELHI- 110011	

SIGNATURE:-

ARCHITECT & PMC
R T & Associates Pvt. Ltd.
ARCHITECTS, DESIGNERS & PROJECT MANAGEMENT
A-47 & 48, SECTOR - 67
NOIDA - 201301, UTTAR PRADESH
TEL: 0120 - 6495313, 2484020 / 21
FAX: 0120 - 6495313 E-MAIL: rtdesigns@gmail.com

SIGNATURE:-

SUBMISSION DRAWING
DRAWING TITLE :

EXTERNAL ELECTRICAL LAYOUT PLAN			
DRAWING NO. : AWHO/MEERUT/S.D./LAY/09			
DATE :	31-10-2025	DRAWN :	N.K.
SCALE :	N.T.S	CHECKED :	R T
RELEASED FOR :	PRELIMINARY	ISSUED FOR :	CONSTRUCTION