


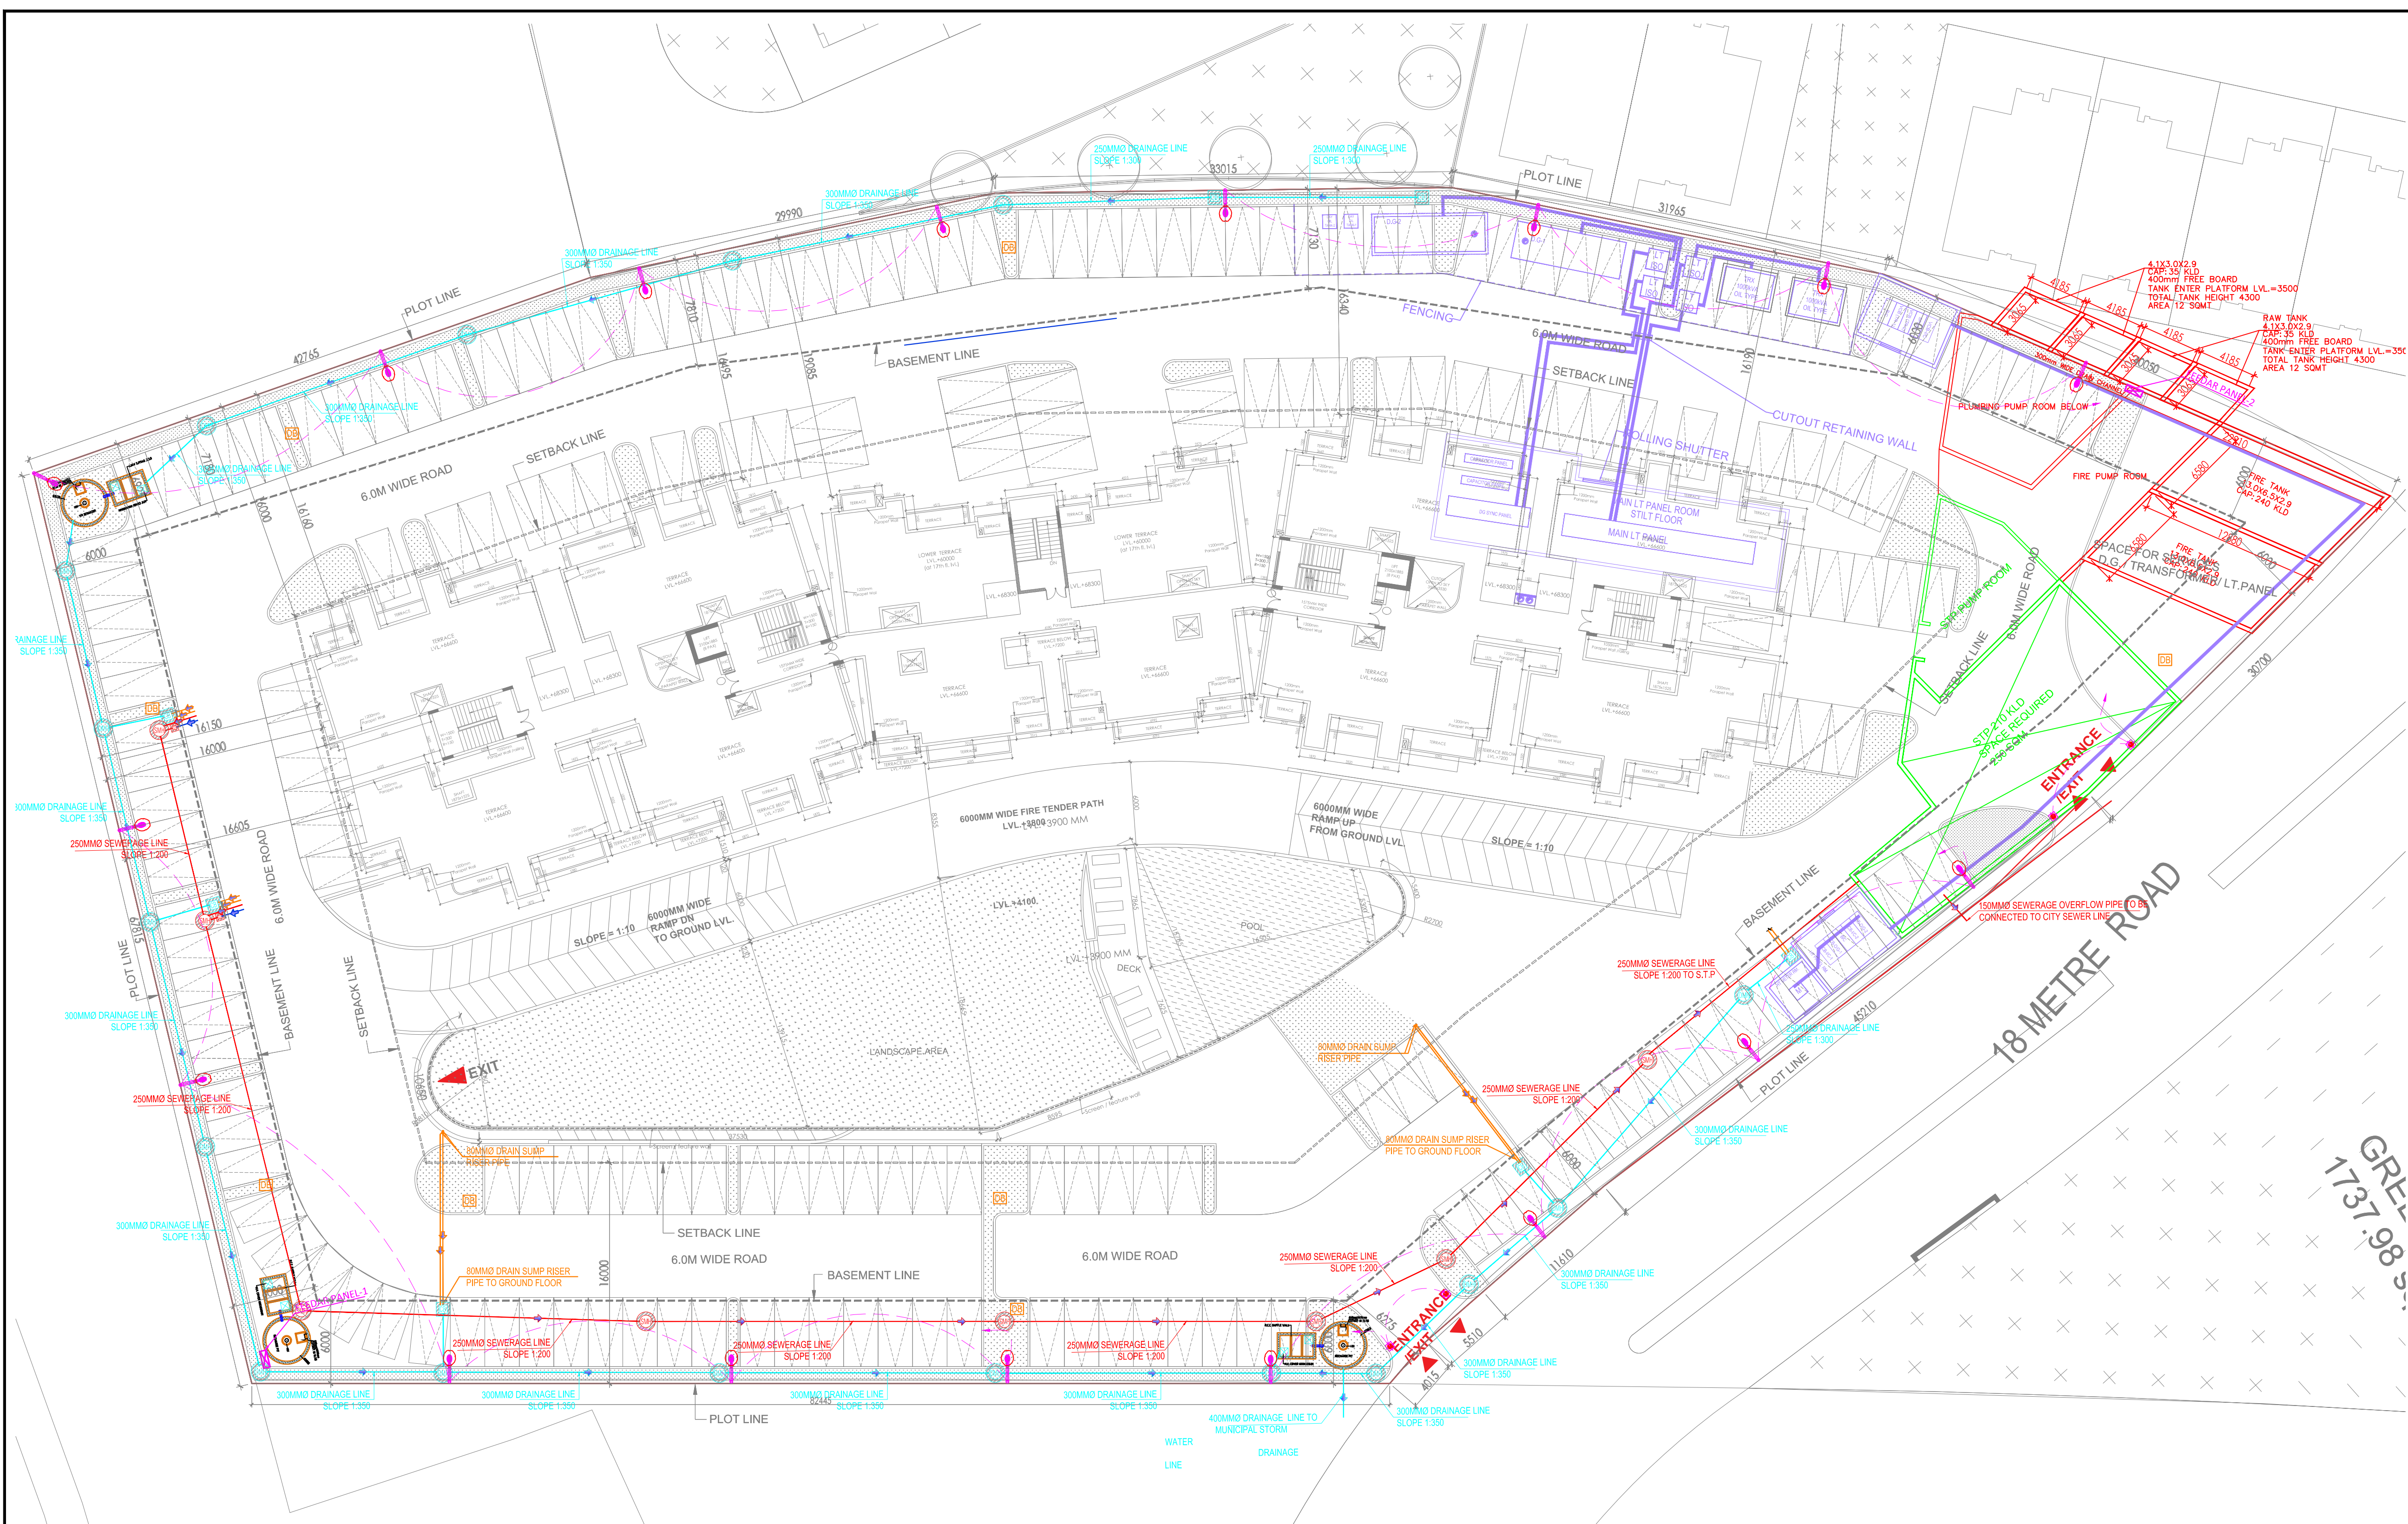

PLUMBING LEGEND	
SYMBOL	DESCRIPTION
	DRAINAGE PIPE LINE
	DRAINAGE MANHOLE
	DRAINAGE CATCH BASIN
	RAIN WATER PIPE
	RAIN WATER HARVESTING PIT

PLUMBING LEGEND	
SYMBOL	DESCRIPTION
	SEWEGAGE PIPE LINE
	SEWERAGE MANHOLE
	GULLY TRAP
	SOIL WATER PIPE
	WASTE WATER PIPE
S.T.P.	SEWERAGE TREATMENT PLANT

ELECTRICAL LEGEND :-		
S. No.	SYMBOL	DESCRIPTION
1.		1X36W GATE LIGHT
2.		90 W LED POLE LIGHT
3.		FEEDER PILLER
4.		LOOPING

PROJECT TITLE:
**PROPOSED GROUP HOUSING
GARDEN BAY-CROWN
LUCKNOW**

KEYPLAN:

KHASRA NO:-
234, 235 & 236

SUBMISSION DRAWING

NORTH:

NOTE:

CLIENT & DEVELOPER:

**SHALIMAR KSMB
PROJECTS**

DESIGN ARCHITECT:

SA
SIKKA ASSOCIATES ARCHITECTS

PLUMBING & FIRE:

PLUMBING & FIRE:

PDA **PDA Consultants**
MEP & Green Building Consultants
REGD OFFICE:
PLOT NO-190, SECOND FLOOR
PATPARGANJ INDUSTRIAL AREA,
DELHI-110092, INDIA
TEL. : +91-11-42408301/42408302
E-MAIL : delhi@pdaconsultants.in

DRAWING TITLE:

**SITE PLAN LAYOUT
MEP**

SCALE (B&D)	1:150	DATE	15-02-2023
DRAWN	S.D.S	CHECKED	P.J
PAPER		ISSUED	

D NO.	GB/AR/SUB-MEP-001
-------	-------------------

FOR RERA SUBMISSION