


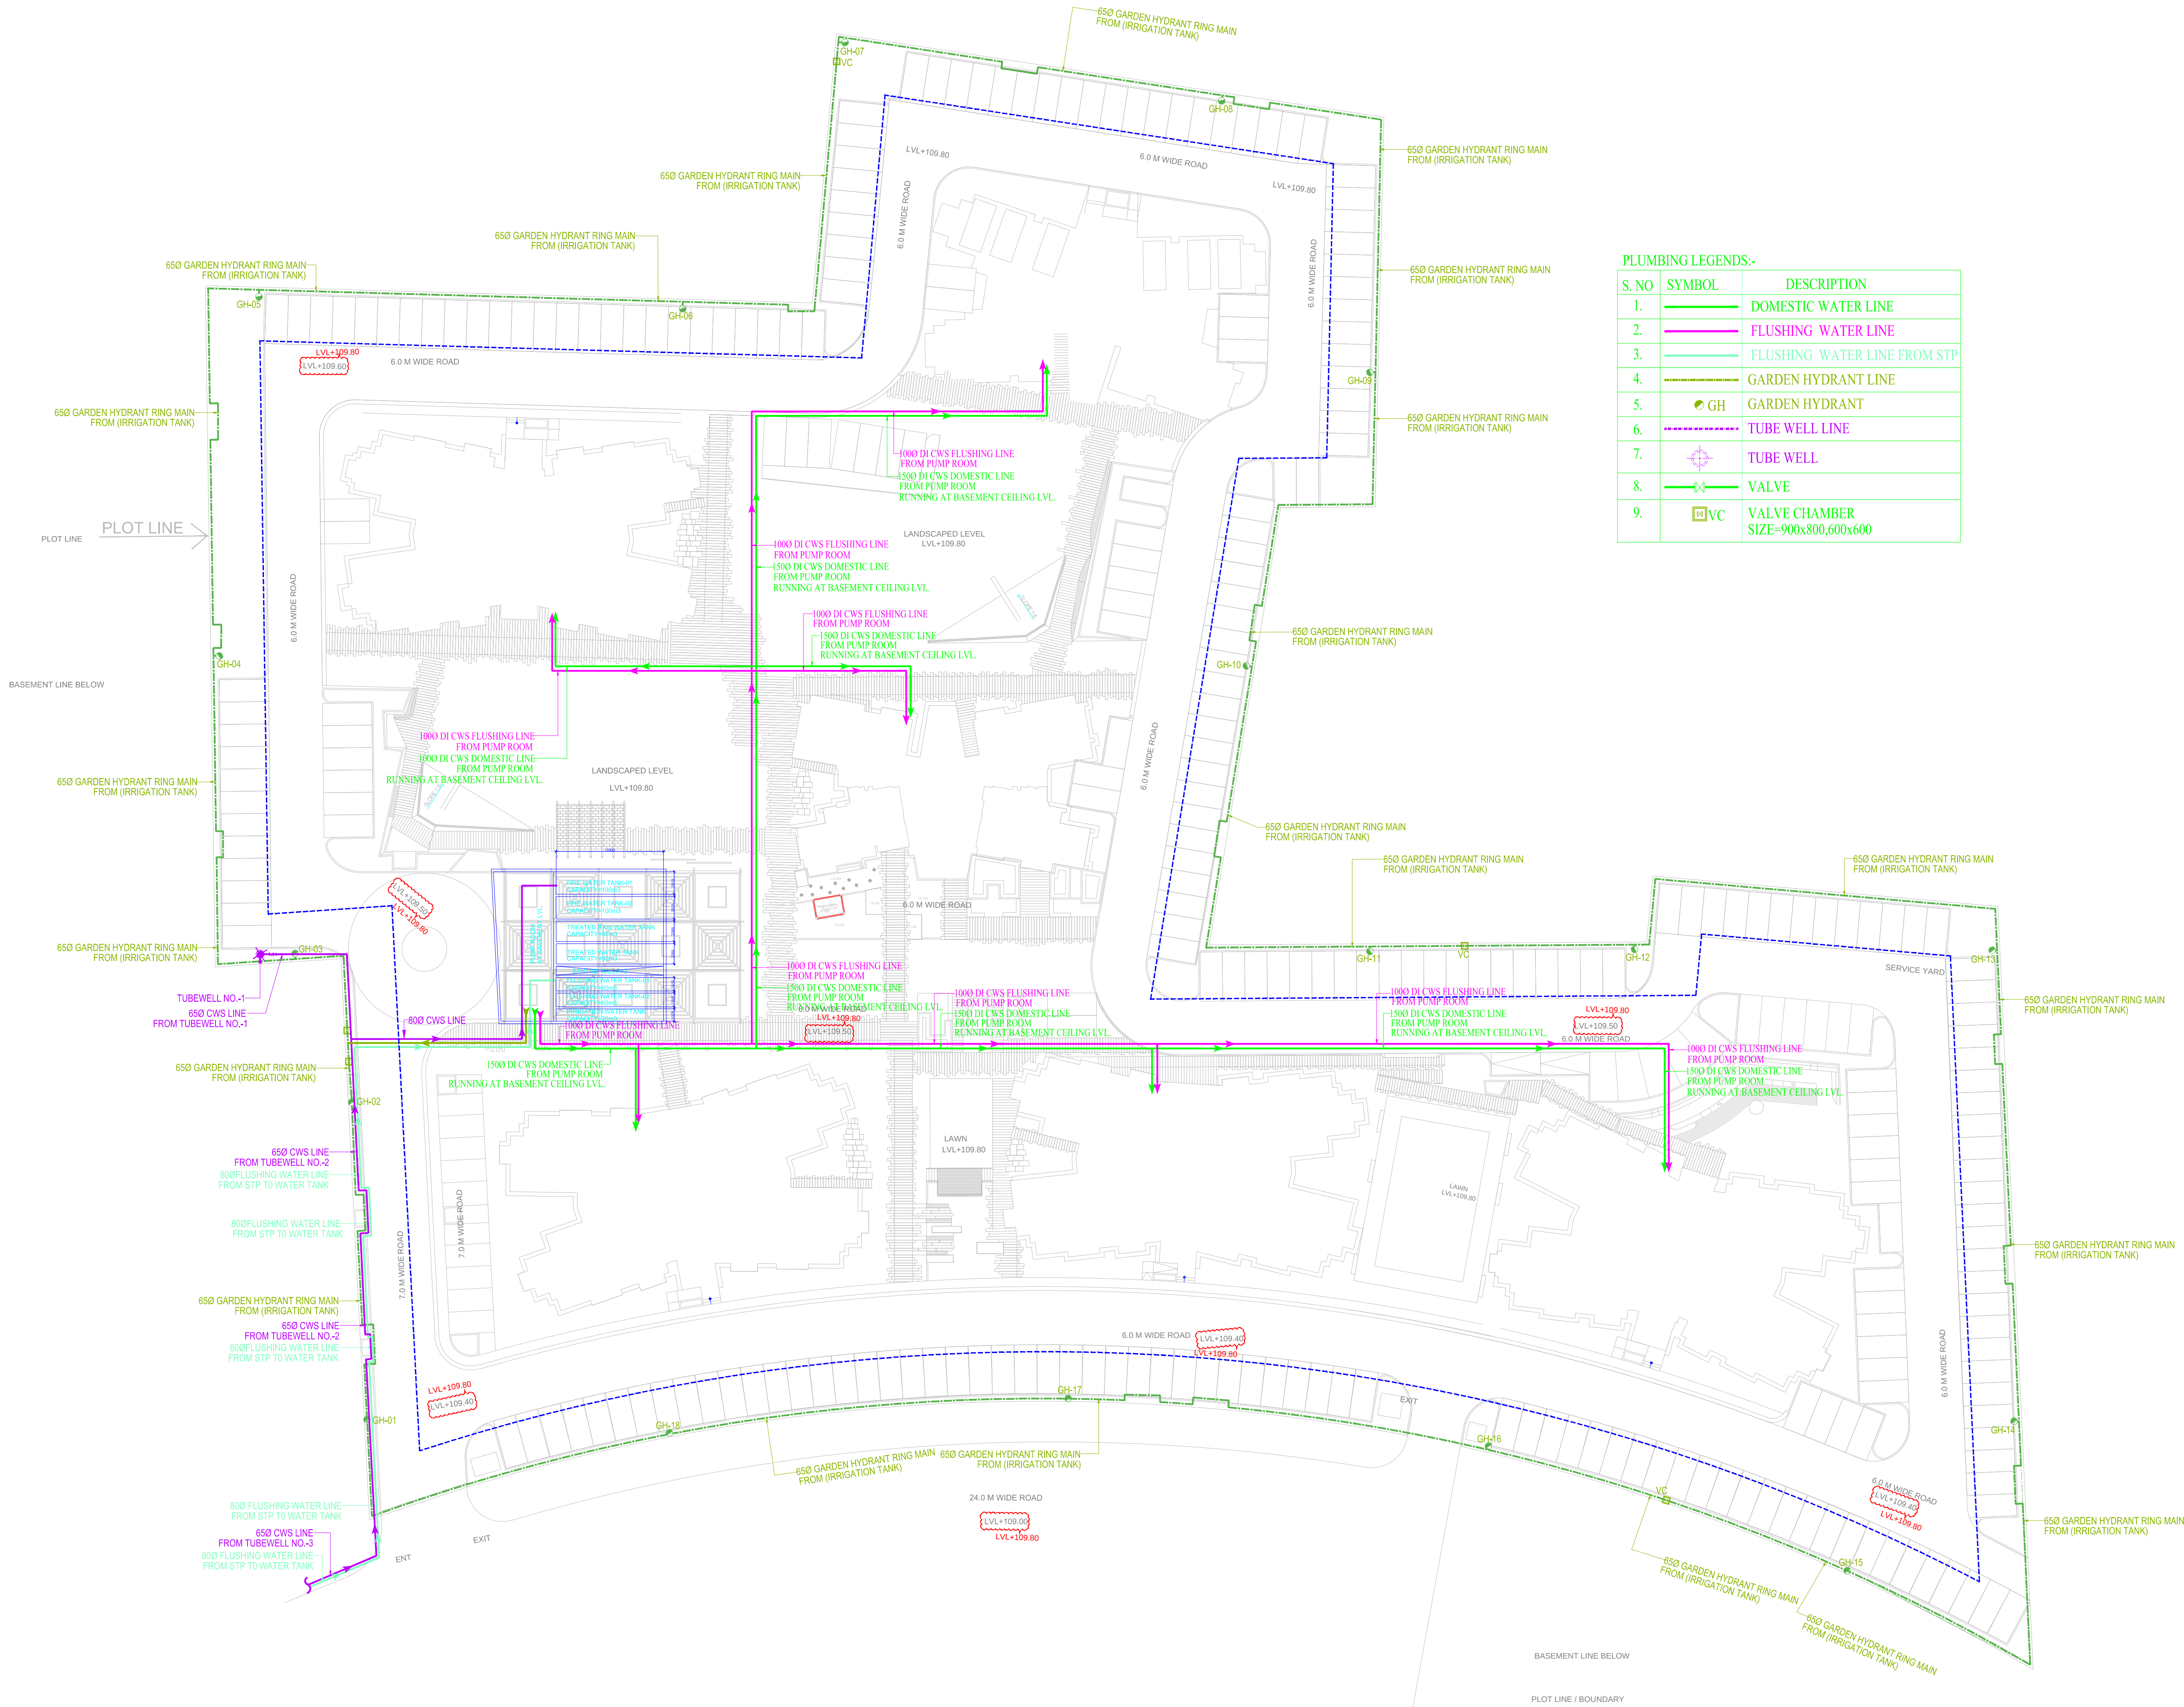


PLUMBING LEGENDS:-

S. NO	SYMBOL	DESCRIPTION
1.		DOMESTIC WATER LINE
2.		FLUSHING WATER LINE
3.		FLUSHING WATER LINE FROM STP
4.		GARDEN HYDRANT LINE
5.		GH GARDEN HYDRANT
6.		TUBE WELL LINE
7.		TUBE WELL
8.		VALVE
9.		VALVE CHAMBER SIZE=900x800,600x600

- NOTES:-
1. ALL DIMENSIONS ARE IN MM.
 2. DO NOT SCALE ANY DIMENSIONS.
 3. THIS DRAWING SHALL BE READ IN CONJUNCTION WITH RELEVANT ARCHITECTURAL AND STRUCTURAL DRAWINGS.

KEY PLAN

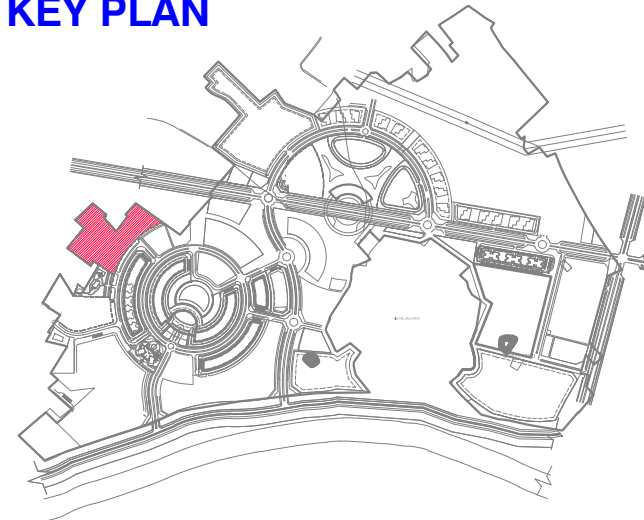

LEGEND

CODE	DESCRIPTION

OWNER	SAS GROUP SAS Hotels & Properties (P) Ltd. Shalimar Square, B N Road , Lailbagh , Lucknow
MASTER PLANNING	ATKINS
COORDINATING ARCHITECT	42mm ARCHITECTURE D 102 Dr. Ambedkar Colony, Andheria Modh, New Delhi
ELECTRICAL	M/s Engineering Services Consultants Plot No. 8, Vardhaman South Plaza, 3rd Floor, L.S.C., Pocket W Market, Saria Vihar, New Delhi-110 076. Tel/Fax : 2994 3394, 4057584
PLUMBING & FIRE	M/s. Techno Engineering Consultants Pocket-A, 30 D, Siddhartha Extension New Delhi - 110014 Phone No. - 91-11-25344655
STRUCTURAL	

LANDSCAPE	
-----------	--

PROJECT	BAGHAMAU INTEGRATED TOWNSHIP DEVELOPMENT, LUCKNOW INDIA
---------	---

ARCHITECT	SAA SIKKA ASSOCIATES ARCHITECTS URBAN DESIGN MASTERPLAN ARCHITECTURE INTERIORS ENGINEERING PROJECT MANAGEMENT A-2/21, AFRICA AVENUE, SAFDARJUNG ENCLAVE, NEW DELHI, INDIA 110 029 T: +91 11 4352 5255 F: +91 11 2625 4481 E: saa@sikkaassociates.net W: www.sikkaassociates.net
-----------	---

SEAL	ISSUED FOR INFORMATION & REVIEW SUBMISSION ☒ GFC
------	---

#	DATE	DESCRIPTION

SCALE	1 : 350	
DATE ISSUED	16.06.2018	
DRAWN BY	SURAJ	
CHECKED BY	SS BHATIA	

DRAWING	SITE PLAN-WATER SUPPLY SYSTEM PHE DRAWING
DWG NO.	GH-01-WS-03