


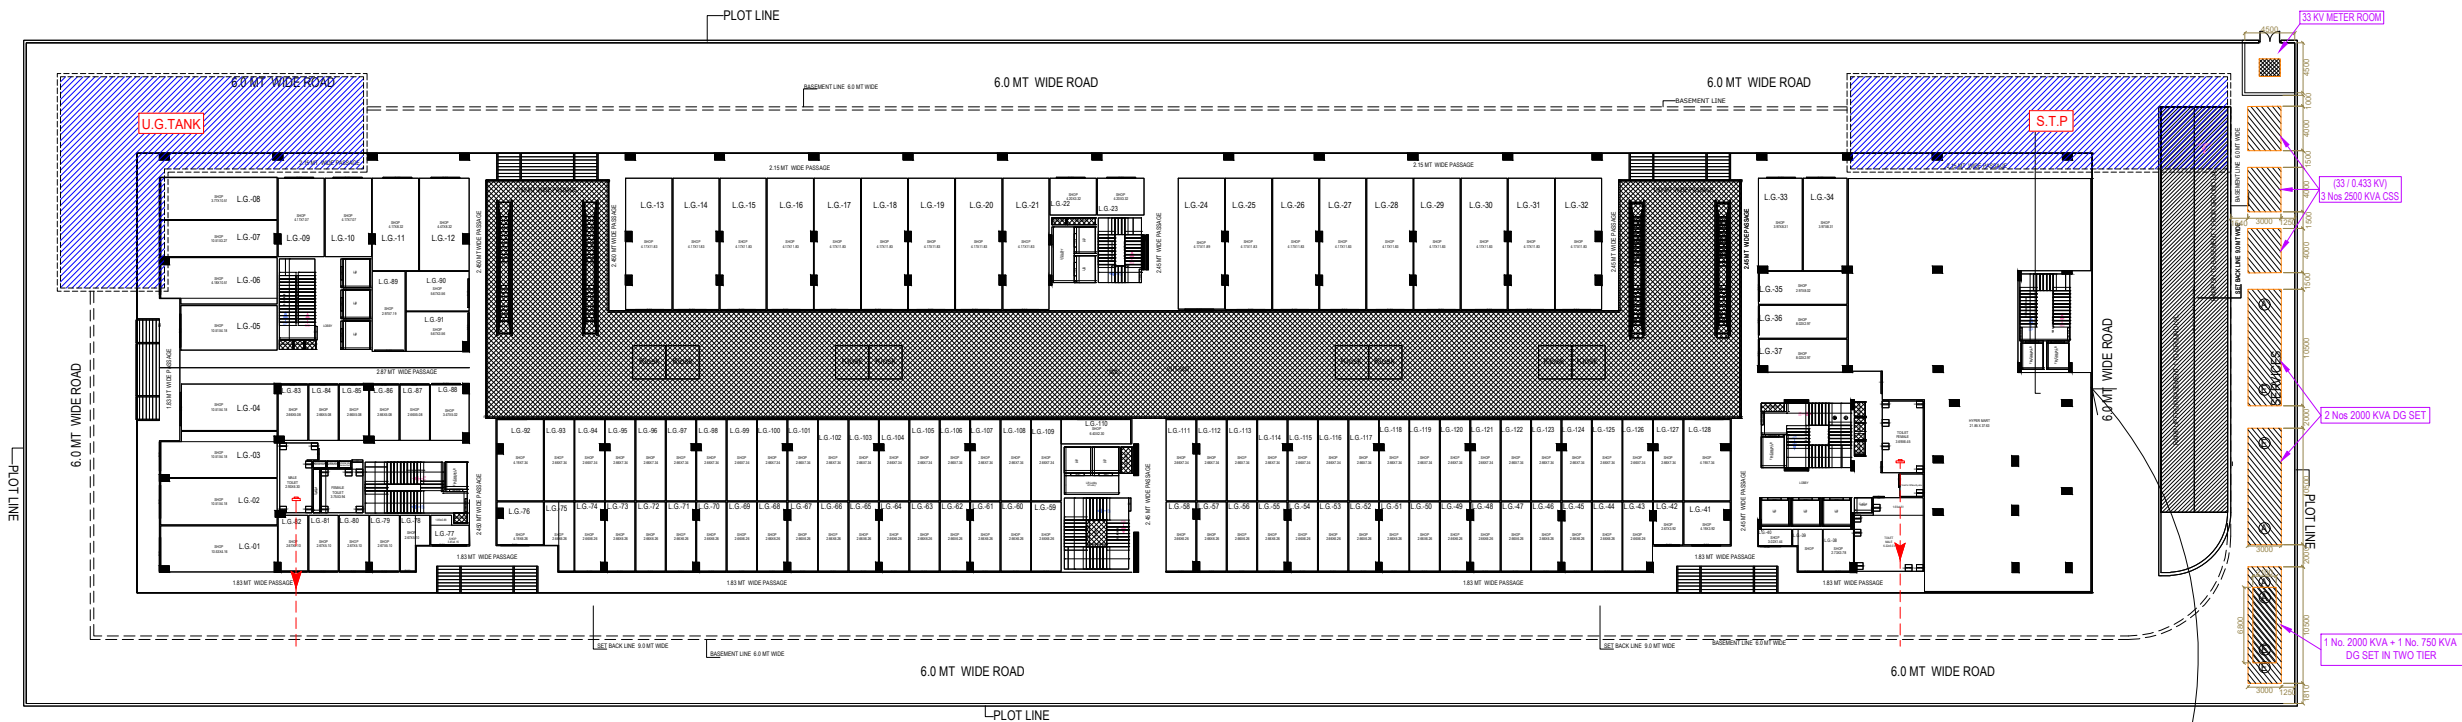

3 Nos DG EXHAUST PIPE OF 450 MM Ø (ID) 600MM Ø (OD) & 1 No. DG EXHAUST PIPE OF 350 MM Ø (ID) 500MM Ø (OD) WITH 75 MM INSULATION ALL AROUND.



DG EXHAUST PIPE SHAFT (3550 x 900 MM) REQUIRED

Clients AURA BUILDCOM LLP,BLD.	architects KATARIA AND ASSOCIATES 	Project : COMMERCIAL PLOT NO-5 SPRING WOOD ENCLAVE SECTOR-4 WAVE CITY	title SITE PLAN subtitle EXTERNAL ELECTRICAL LAYOUT	drawing released for ☐ APPROVAL ☒ SUBMISSION ☐ ADVANCE COPY ☐ CONSTRUCTION	drg. no. CES / AURA / SP / EL-01 scale A1@1:300 date 25.07.2024	drawn by Surjeet designed by Ateeg Ur Rehman checked by ANAND HAVELIA	services consultant Consummate Engineering Services (P) Ltd.  Noida Office : B - 67, Sector - 67, Noida - 201 301 Tel : (0120) 2303500 (24 Lines) Lko. Office : R 006, Rohas Plumeria, Gomti Nagar, Lucknow e mail : mail@cespl.in, website : www.cespl.in
--	--	---	--	--	---	---	--

