
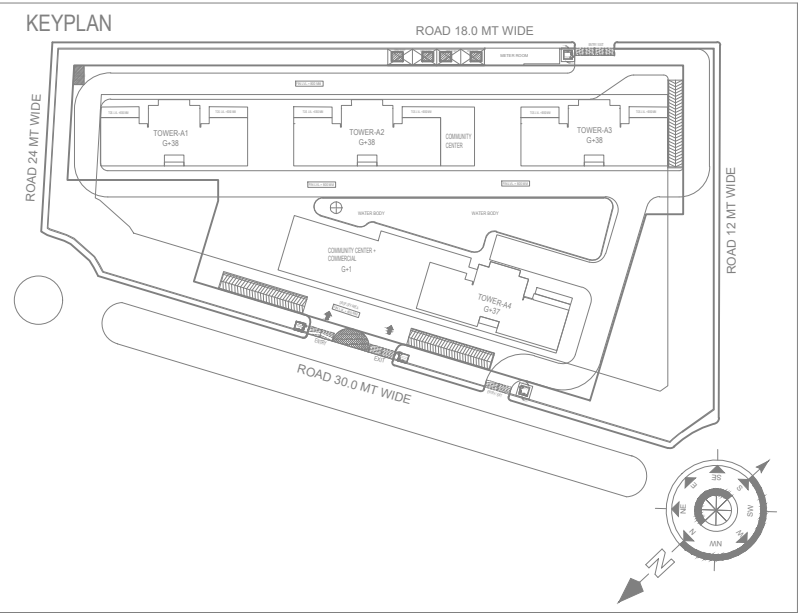


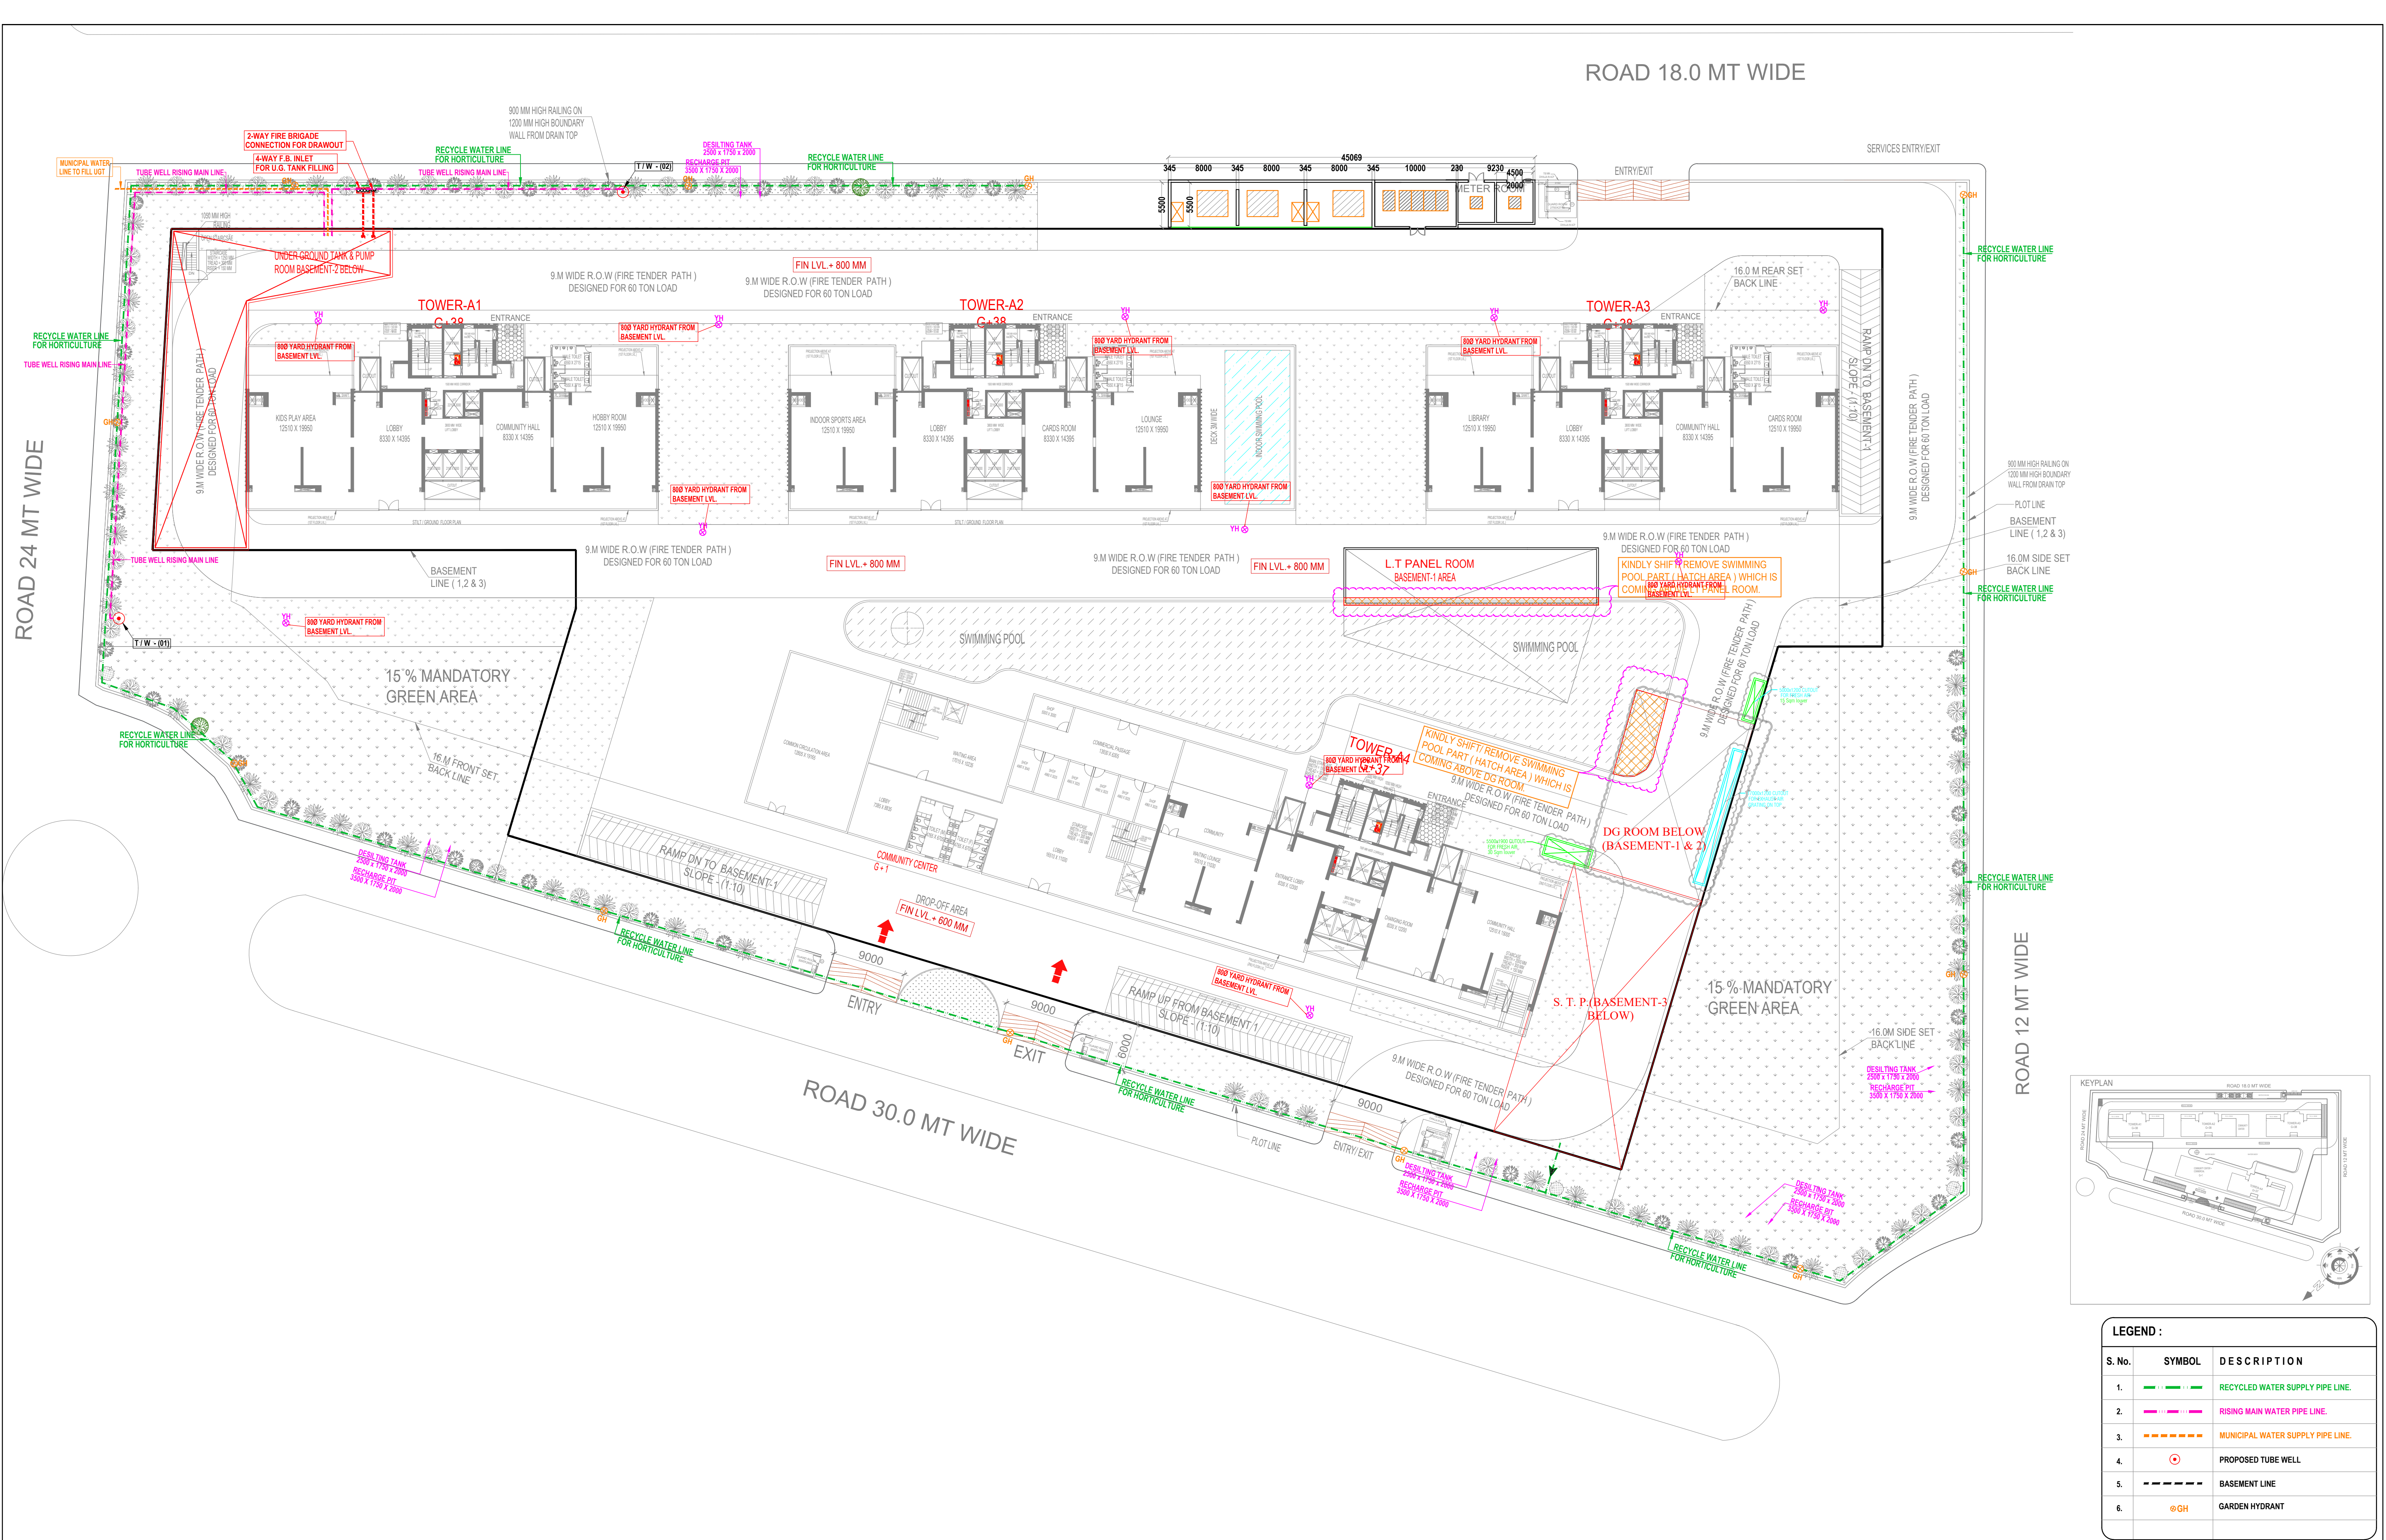

LEGEND :		
S. No.	SYMBOL	DESCRIPTION
1.		RECYCLED WATER SUPPLY PIPE LINE.
2.		RISING MAIN WATER PIPE LINE.
3.		MUNICIPAL WATER SUPPLY PIPE LINE.
4.		PROPOSED TUBE WELL
5.		BASEMENT LINE
6.		GARDEN HYDRANT

Project
PROPOSED GROUP HOUSING (PROJECT NAME - MIRAABILIS)
AT KHASRA NO - 221 M (PART), 222 M (PART), 223M (PART),
224 M (PART), 302 M, 303 M, 304 (PART), 307 (PART),
VILLAGE - MAKANPUR
DIST. - GHAZIABAD (U.P.)

OWNER
M/S Rhomes Miraabilis LLP

Title
SITE PLAN
Subtitle
EXTERNAL WATER SUPPLY SYSTEM

Drawing released for
☐ APPROVAL ☒ SUBMISSION
☐ ADVANCE COPY ☐ CONSTRUCTION

Drg. no.
R HOMES / EX / S-04
Scale
1:370
Date
Jan. 2025

Drawn by
Kulwant
Designed by
R.K.
Checked by
Anand Havelia

architects
Confluence
NEW DELHI, INDIA
F-1, FIRST FLOOR, MIRA CORPORATE SUITES,
ISHWAR NAGAR, NEW DELHI 110065
Ph: +91-11-26925684 cec@confluence.com Member of IBCB
Ph: +91-11-46564768 www.confluence.com ISO - 9001 : 2000
architecture urban design hospitality interiors

Services Consultant
Consummate Engineering Services (P) Ltd.
Noida Office : B - 67, Sector - 67, Noida - 201 301
Tel : (0120) 8943500 (23 Lines)
Lko Office : R 066, Rohtas Plumeria, Gomti Nagar, Lucknow
Tel : (0522) 4025902
e mail : mail@cespl.in, website : www.cespl.in