
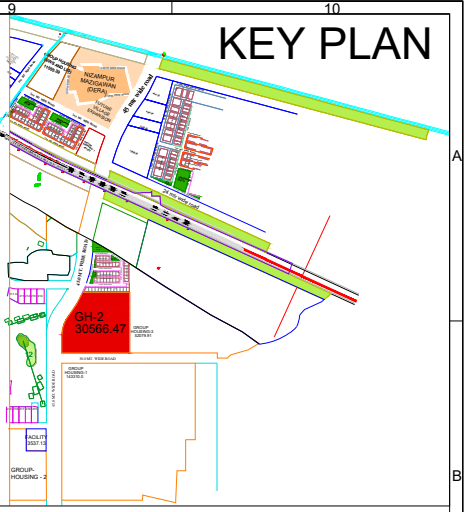


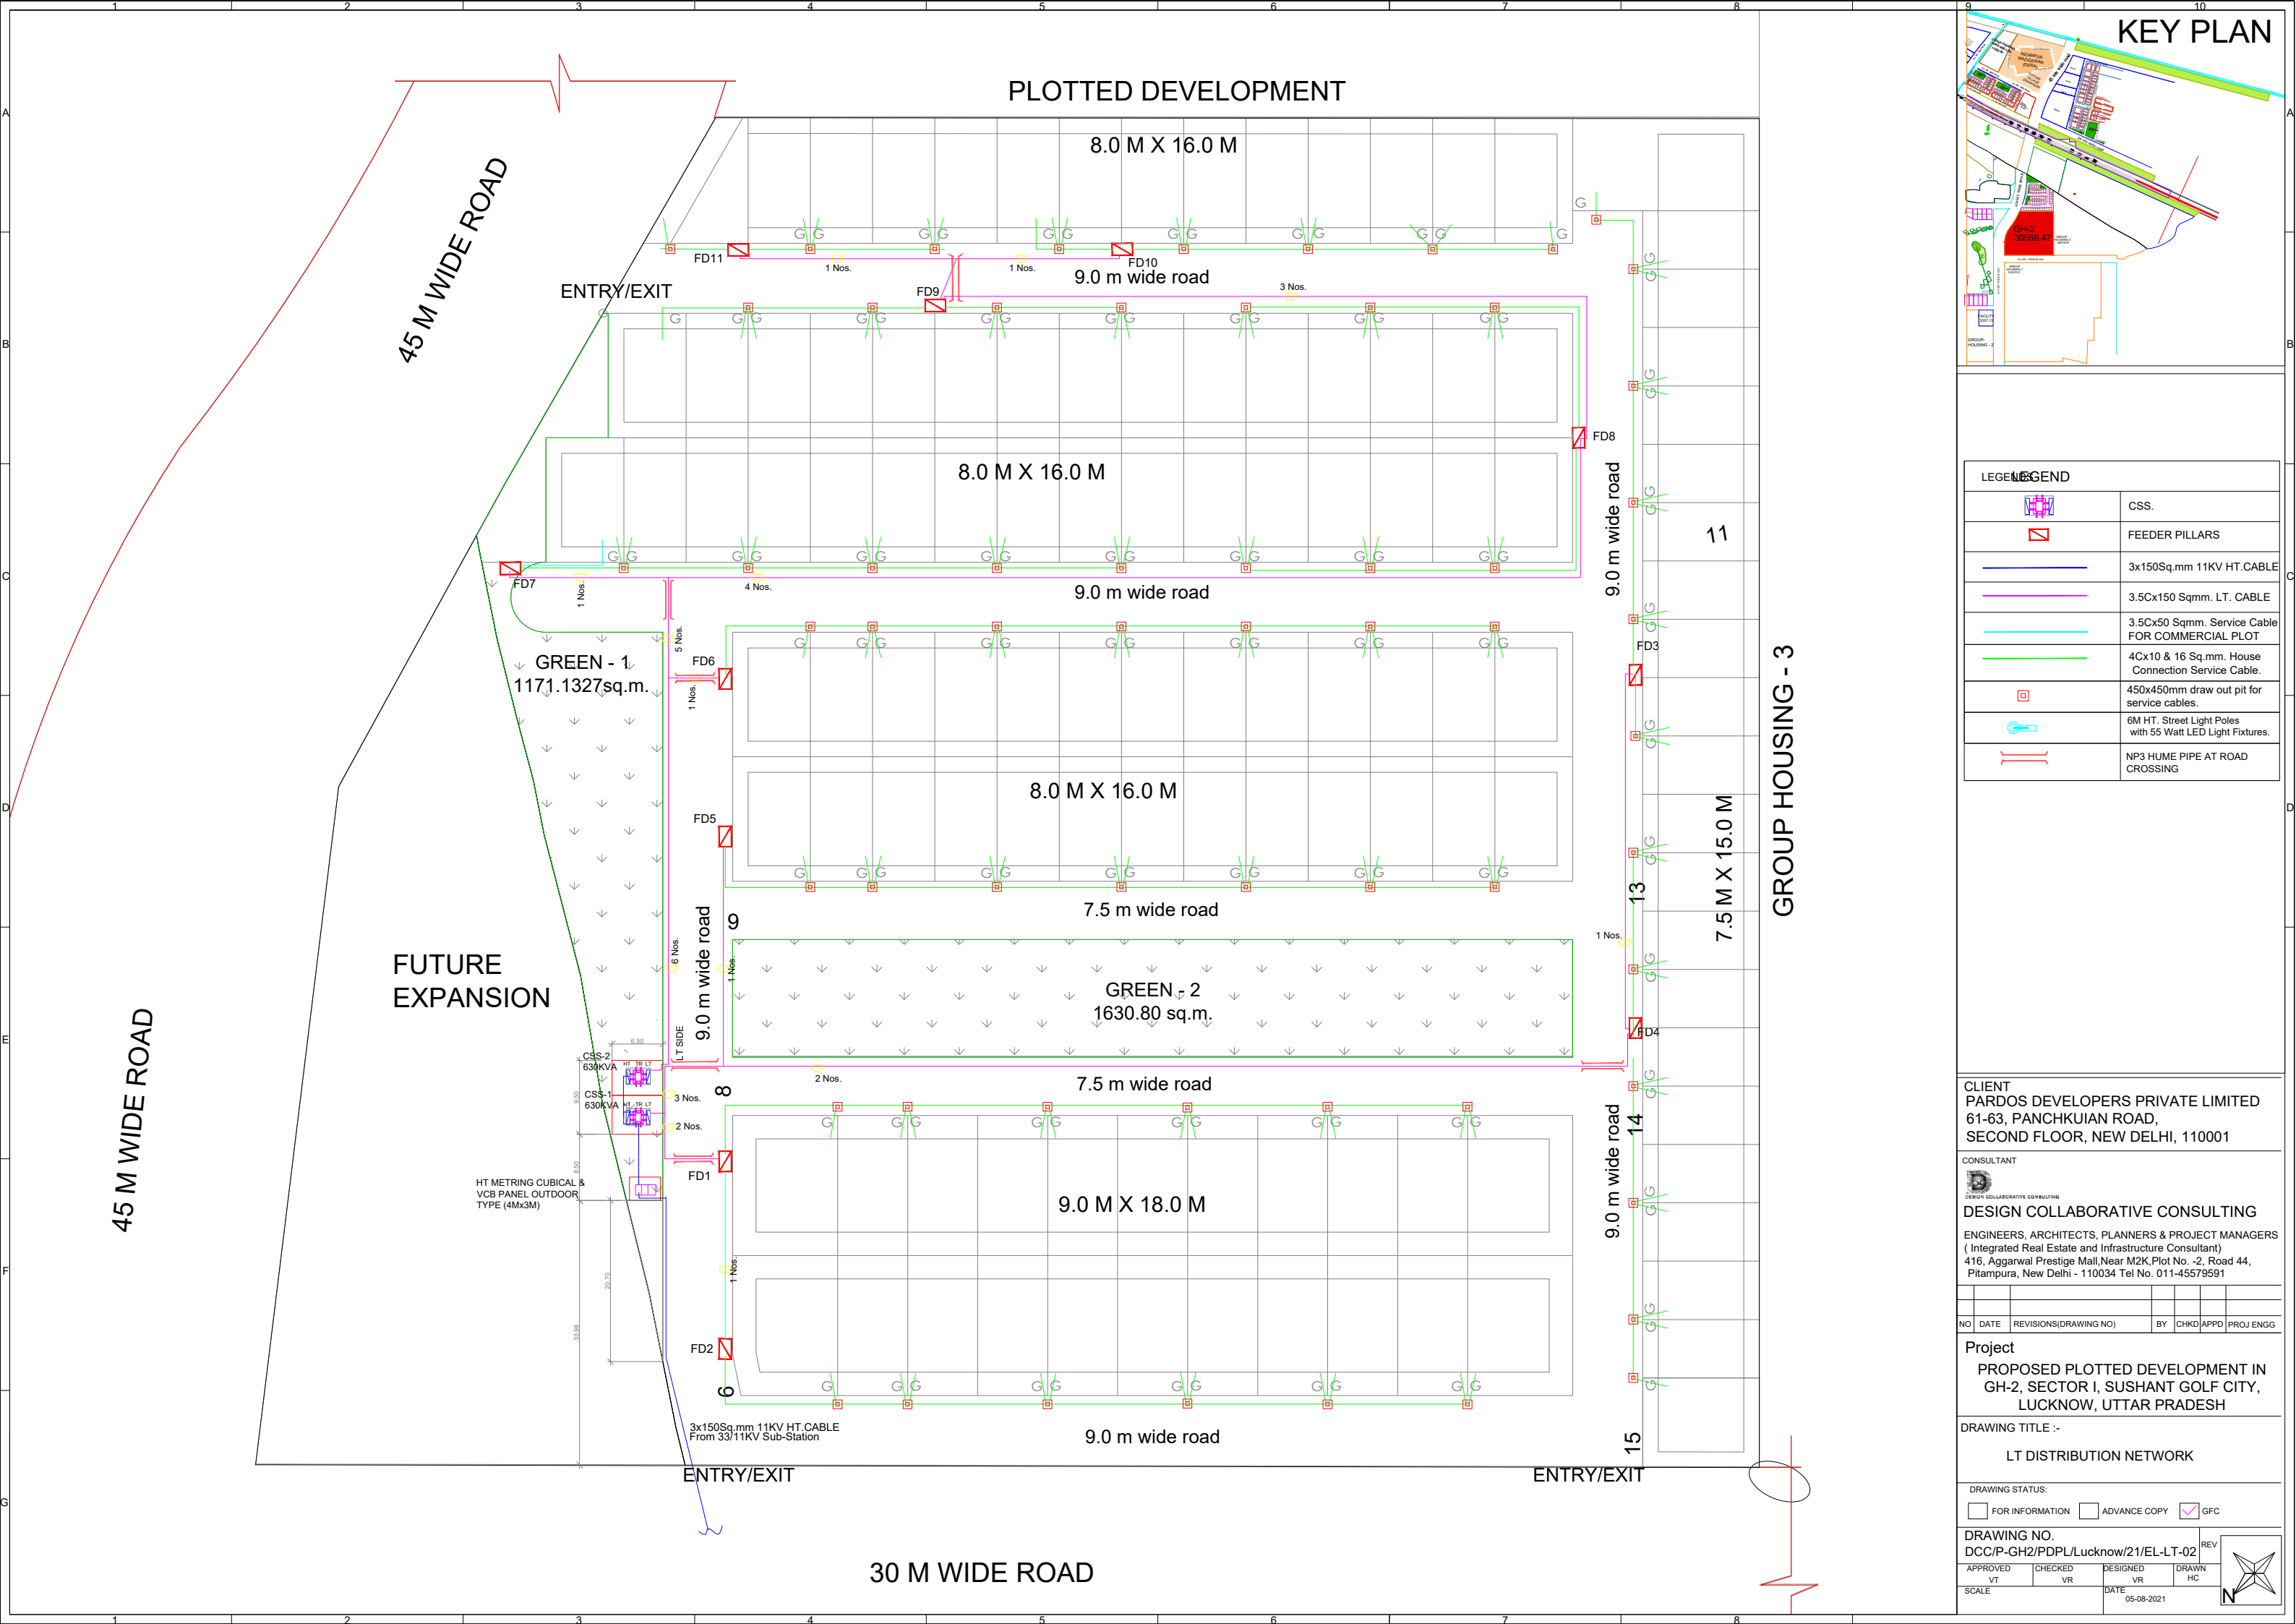

LEGEND	
	CSS.
	FEEDER PILLARS
	3x150Sq.mm 11KV HT.CABLE
	3.5Cx150 Sqmm. LT. CABLE
	3.5Cx50 Sqmm. Service Cable FOR COMMERCIAL PLOT
	4Cx10 & 16 Sq.mm. House Connection Service Cable.
	450x450mm draw out pit for service cables.
	6M HT. Street Light Poles with 55 Watt LED Light Fixtures.
	NP3 HUME PIPE AT ROAD CROSSING

CLIENT
PARDOS DEVELOPERS PRIVATE LIMITED
61-63, PANCHKUIAN ROAD,
SECOND FLOOR, NEW DELHI, 110001

CONSULTANT

DESIGN COLLABORATIVE CONSULTING
ENGINEERS, ARCHITECTS, PLANNERS & PROJECT MANAGERS
(Integrated Real Estate and Infrastructure Consultant)
416, Aggarwal Prestige Mall, Near M2K, Plot No. -2, Road 44,
Pitampura, New Delhi - 110034 Tel No. 011-45579591

NO	DATE	REVISIONS(DRAWING NO)	BY	CHKD	APPD	PROJ	ENGG


Project
PROPOSED PLOTTED DEVELOPMENT IN
GH-2, SECTOR I, SUSHANT GOLF CITY,
LUCKNOW, UTTAR PRADESH

DRAWING TITLE :-
LT DISTRIBUTION NETWORK

DRAWING STATUS:
☐ FOR INFORMATION ☐ ADVANCE COPY ☒ GFC

DRAWING NO. DCC/P-GH2/PDPL/Lucknow/21/EL-LT-02		REV
APPROVED VT	CHECKED VR	DESIGNED VR
SCALE	DATE 05-08-2021	DRAWN HC



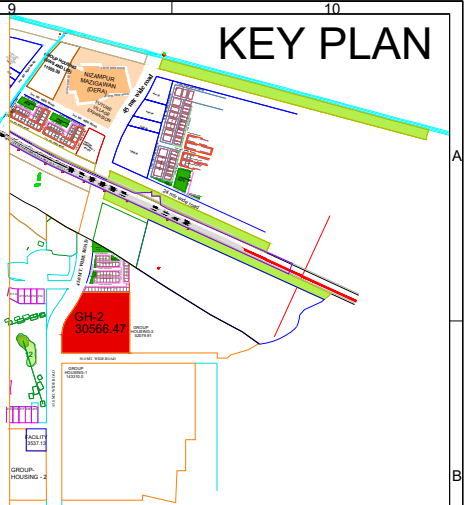

PROPOSED PLOTTED DEVELOPMENT IN GH-2, SECTOR-I, SUSHANT GOLF CITY, LUCKNOW (U.P.) BEING DEVELOPED BY PARDOS DEVELOPER.

LEGEND	
	CSS
	FEEDER PILLARS
	4C x 25 Sq. mm Cable from FD to Street Light Panel.
	4C x 6 Sq. mm Cable for Street Light Poles.
	4C x 10 Sq. mm. cable for Street light poles
	7/6M HT. Street Light Poles with 55 W LED LIGHT FIXTURES. (MODEL K-LITE KP-8122 STREET KING OR KP-7166/67/P1/SA)
	Street Light Panel.



CLIENT
PARDOS DEVELOPERS PRIVATE LIMITED
61-63, PANCHKUIAN ROAD,
SECOND FLOOR, NEW DELHI, 110001

CONSULTANT

DESIGN COLLABORATIVE CONSULTING
ENGINEERS, ARCHITECTS, PLANNERS & PROJECT MANAGERS
(Integrated Real Estate and Infrastructure Consultant)
416, Aggarwal Prestige Mall, Near M2K, Plot No. -2, Road 44,
Pitampura, New Delhi - 110034 Tel No. 011-45579591

NO	DATE	REVISIONS(DRAWING NO)	BY	CHKD	APPD	PROJ ENGG

Project
PROPOSED PLOTTED DEVELOPMENT IN
GH-2, SECTOR I, SUSHANT GOLF CITY,
LUCKNOW, UTTAR PRADESH

DRAWING TITLE :-
STREET LIGHTING LAYOUT

DRAWING STATUS:
☐ FOR INFORMATION ☐ ADVANCE COPY ☒ GFC

DRAWING NO. DCC/P-GH2/PDPL/Lucknow/21/EL-Strt-Light-04		REV
APPROVED VT	CHECKED VR	DESIGNED VR
SCALE	DATE 05-08-2021	DRAWN HC

