




BASEMENT THIRD & SECOND FLOOR PLAN

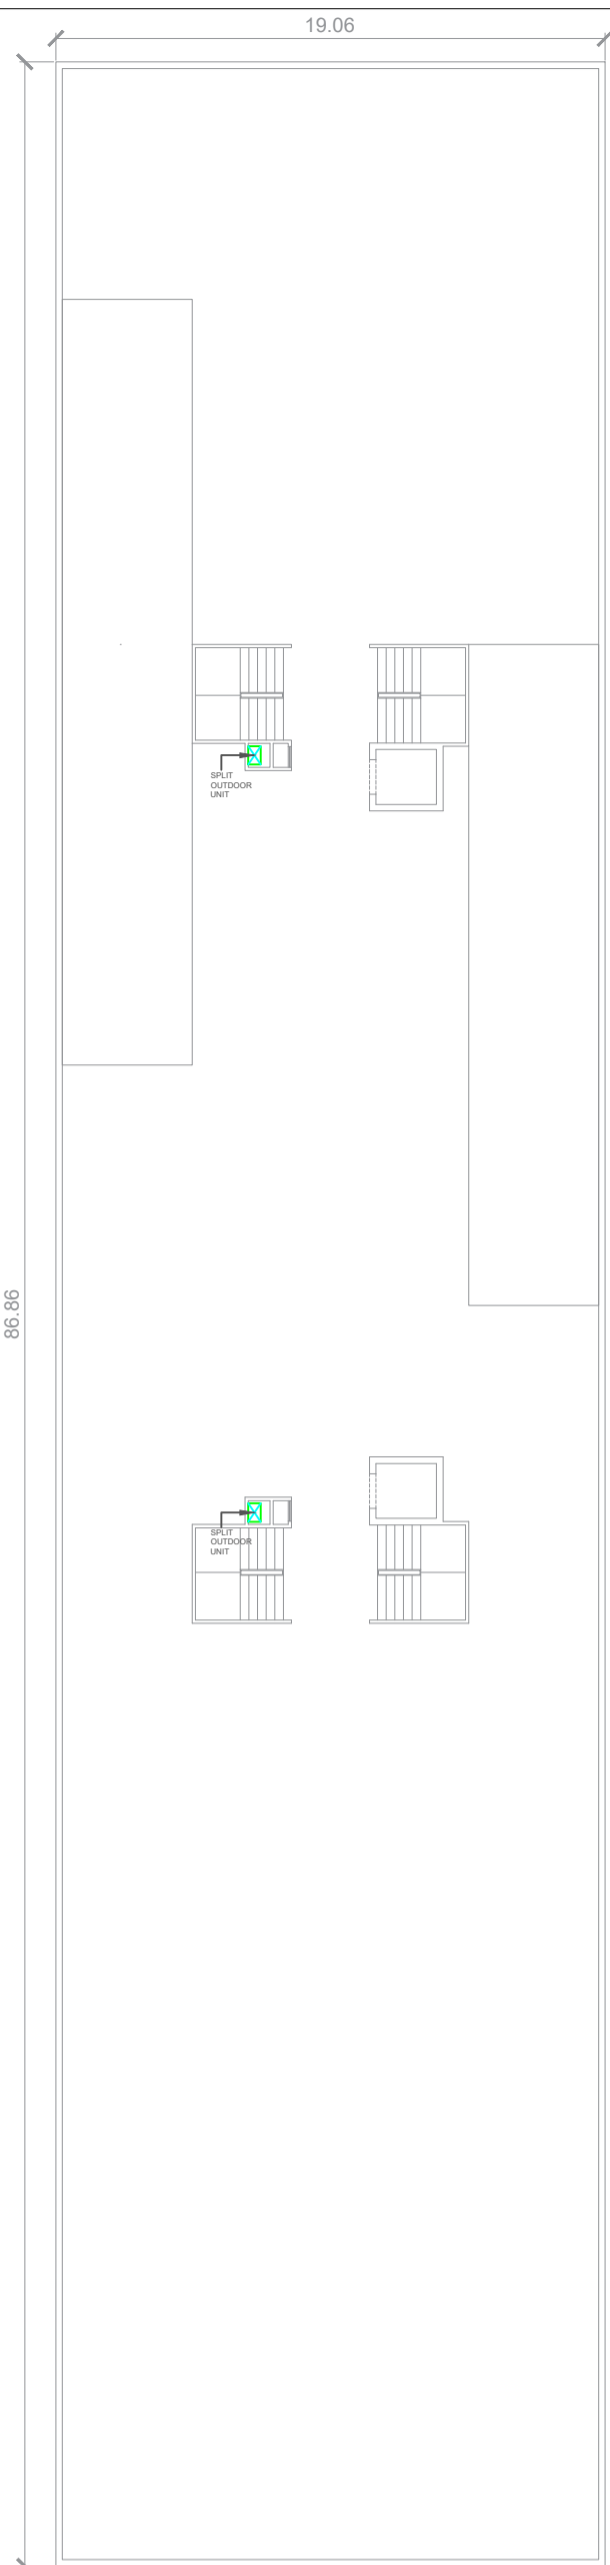


BASEMENT FIRST FLOOR PLAN

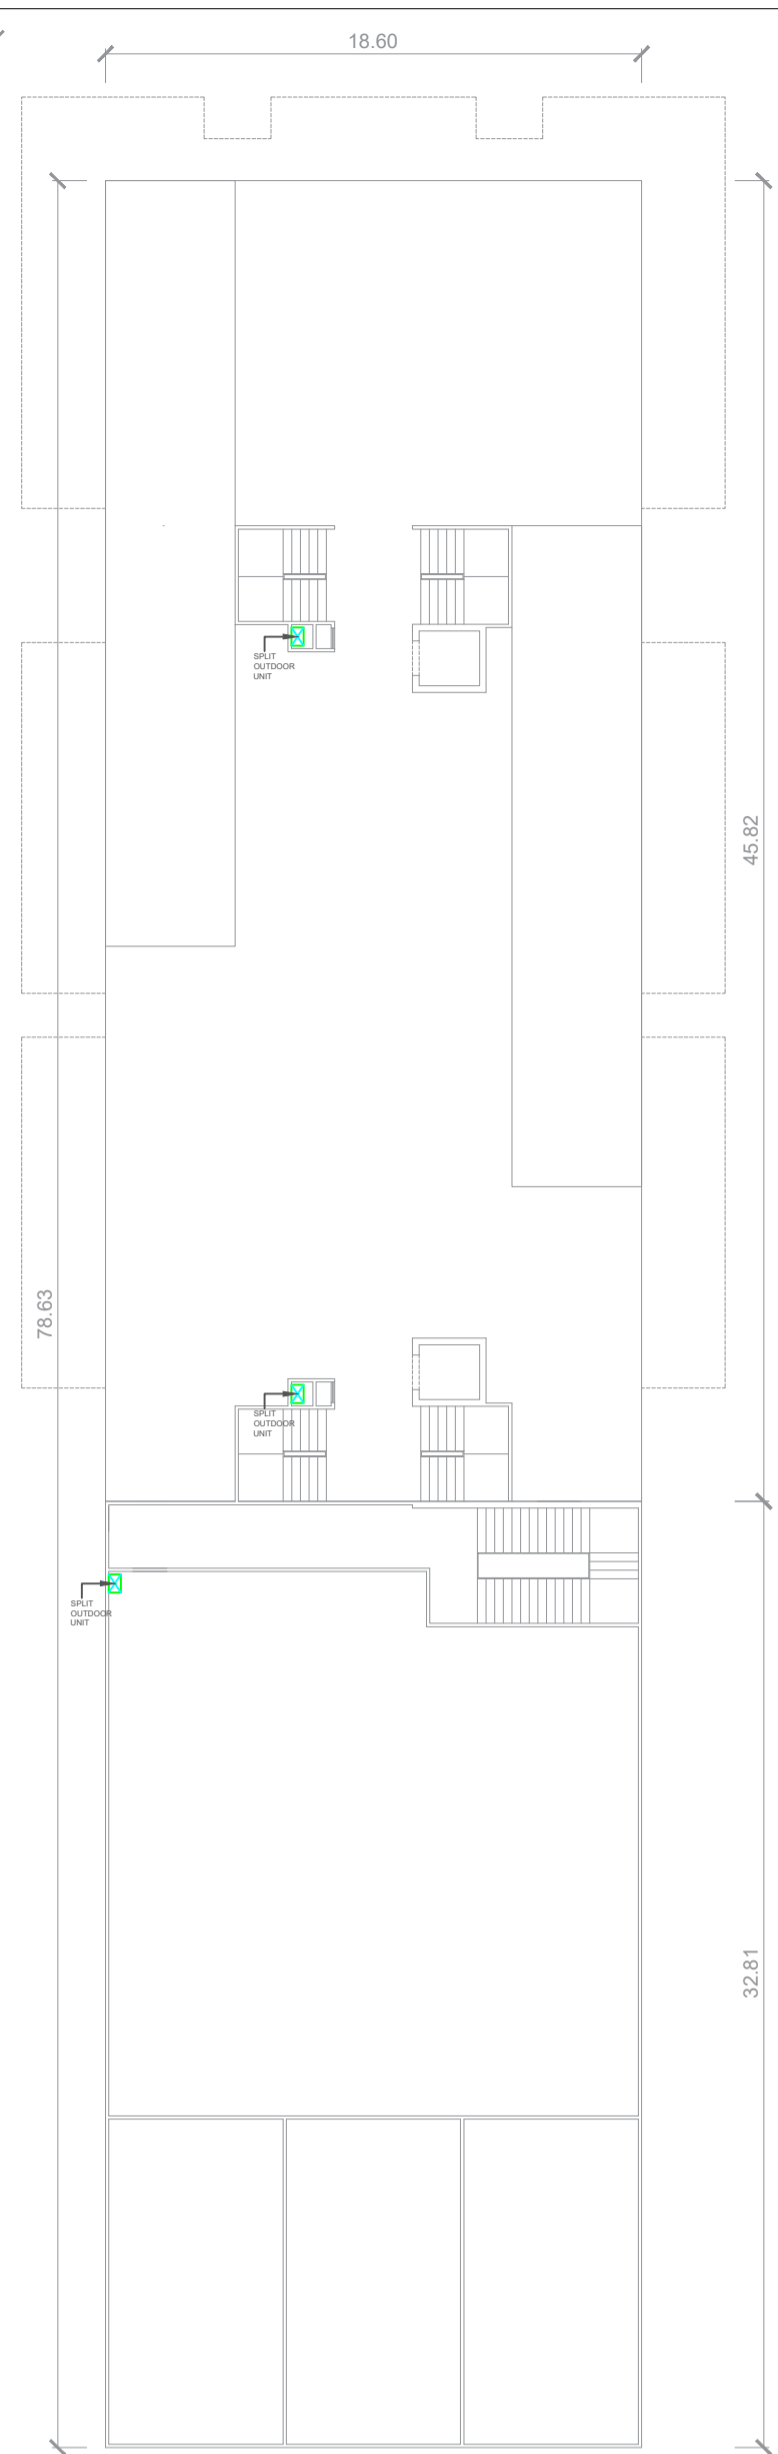


STILT FLOOR PLAN

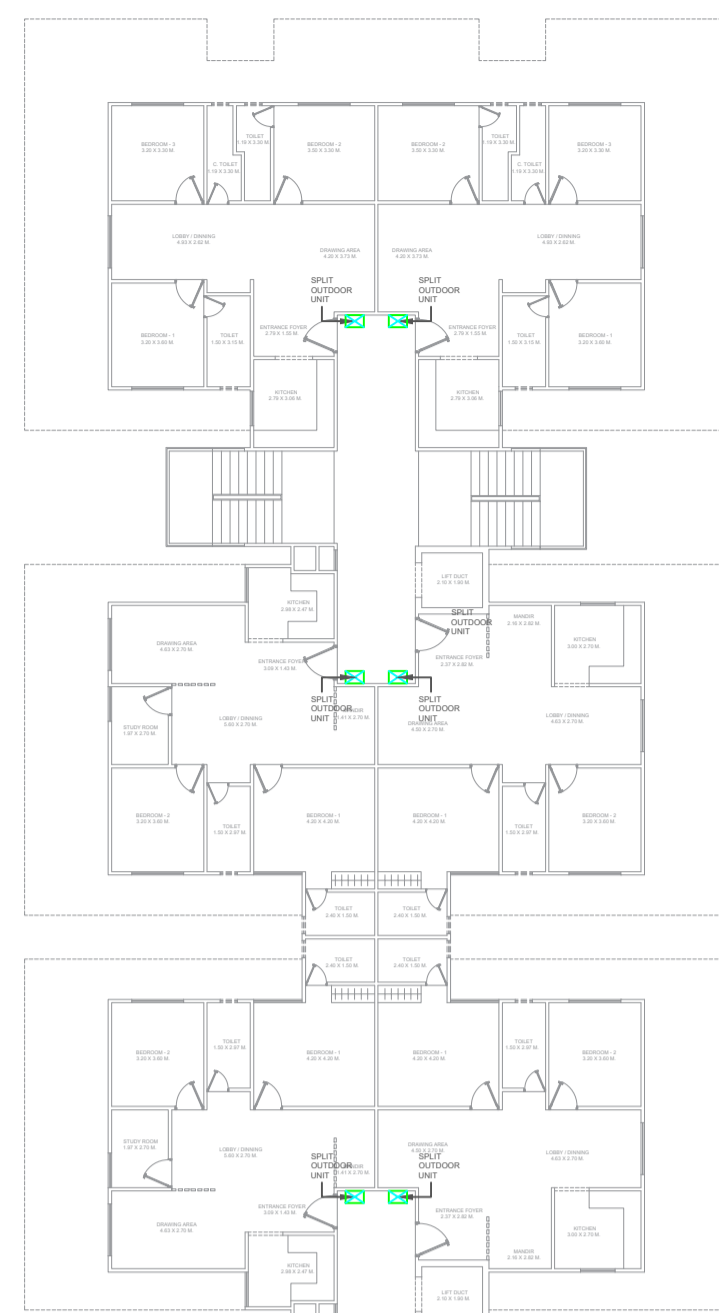


FIRST FLOOR PLAN

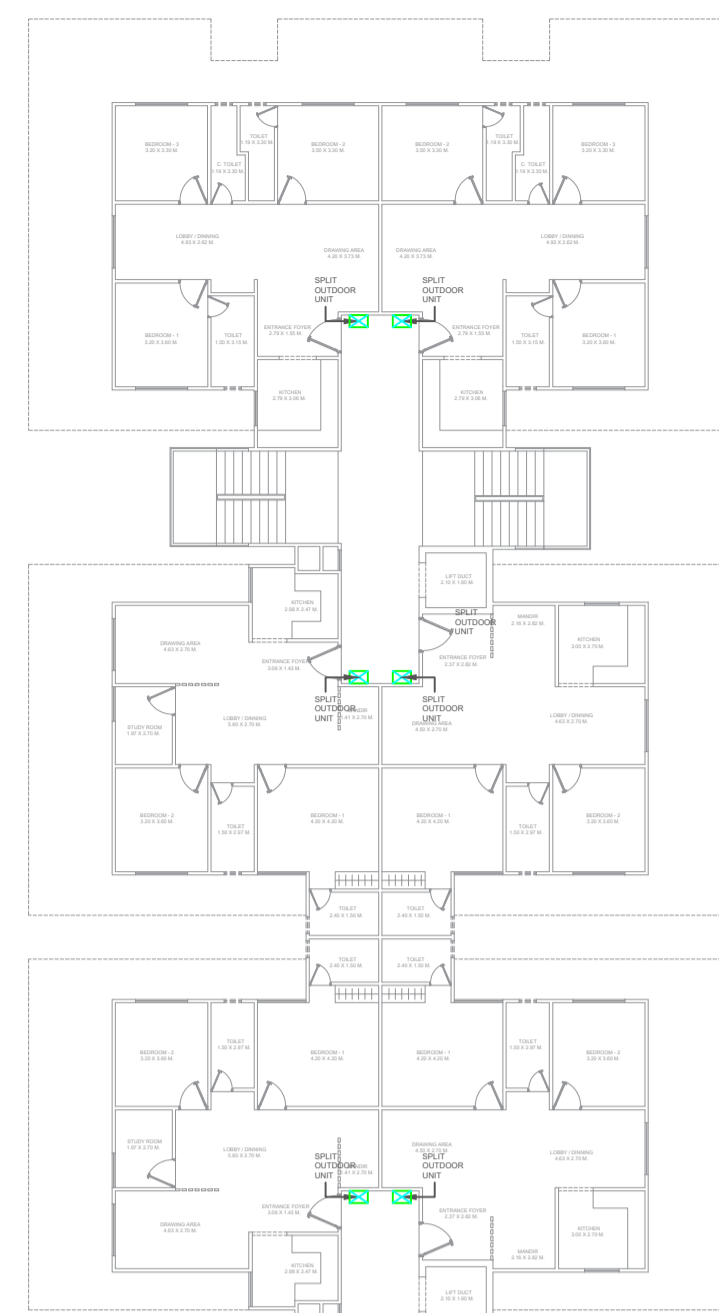

SECOND FLOOR PLAN

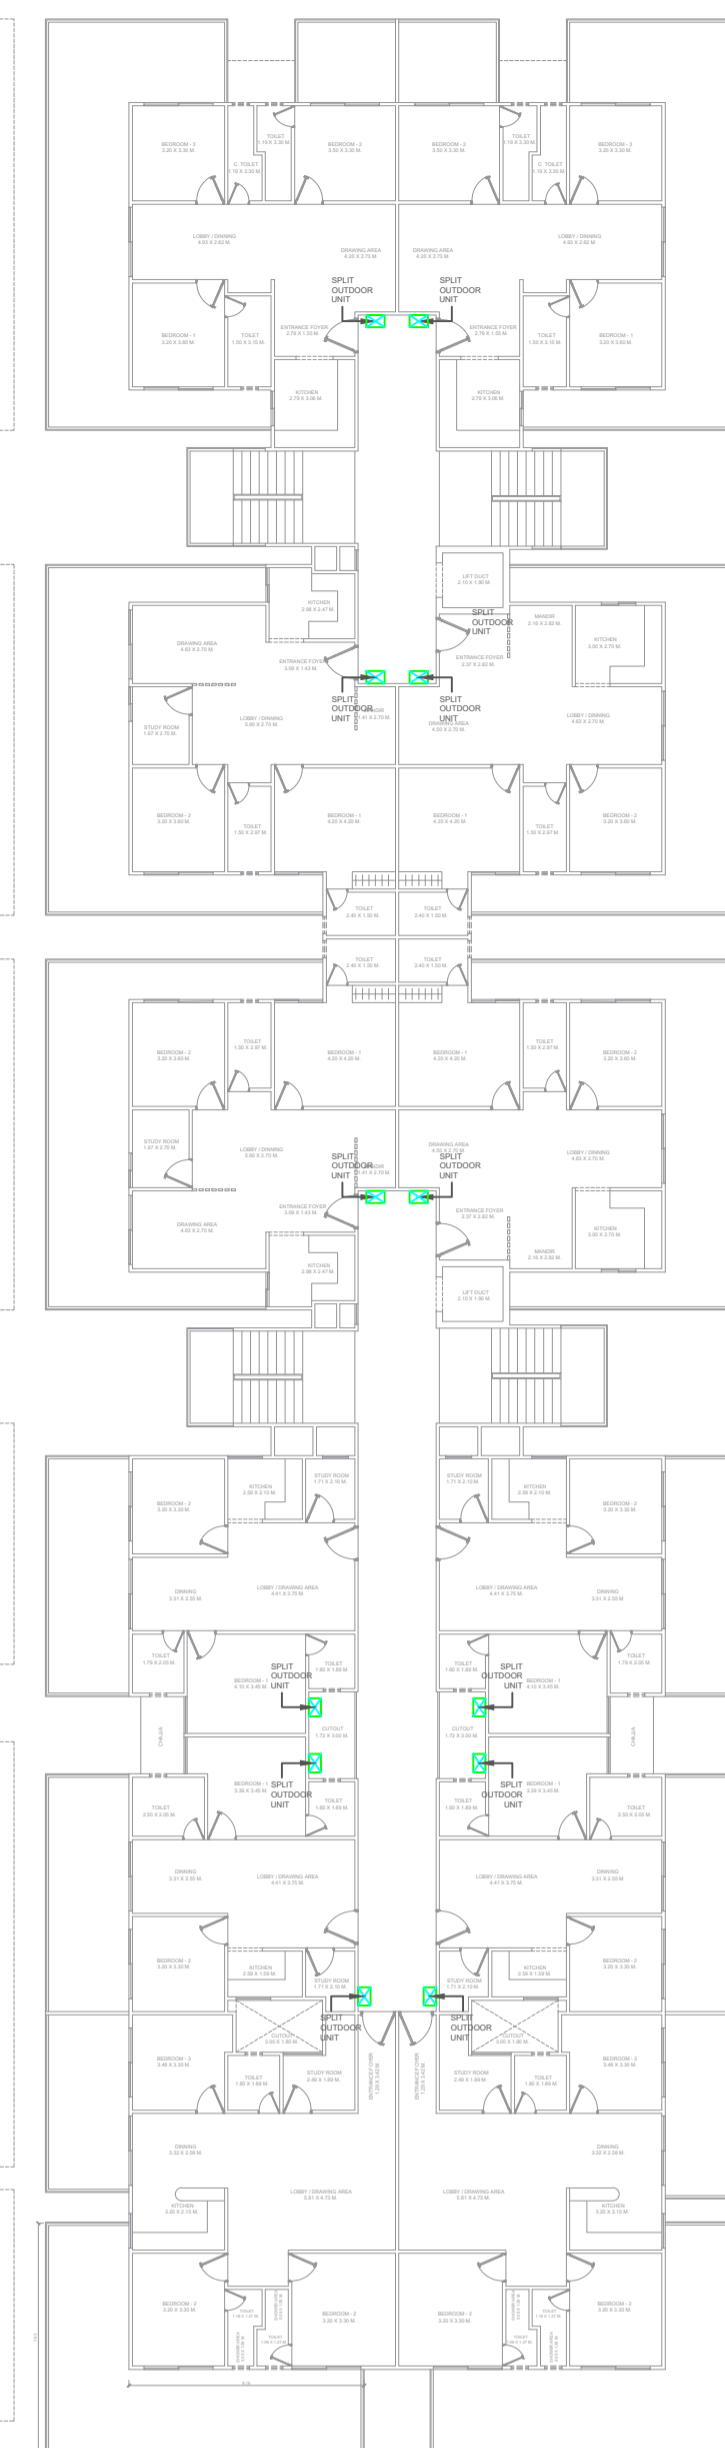

**TYPICAL FLOOR PLAN
(3, 4, 5, & 6)**

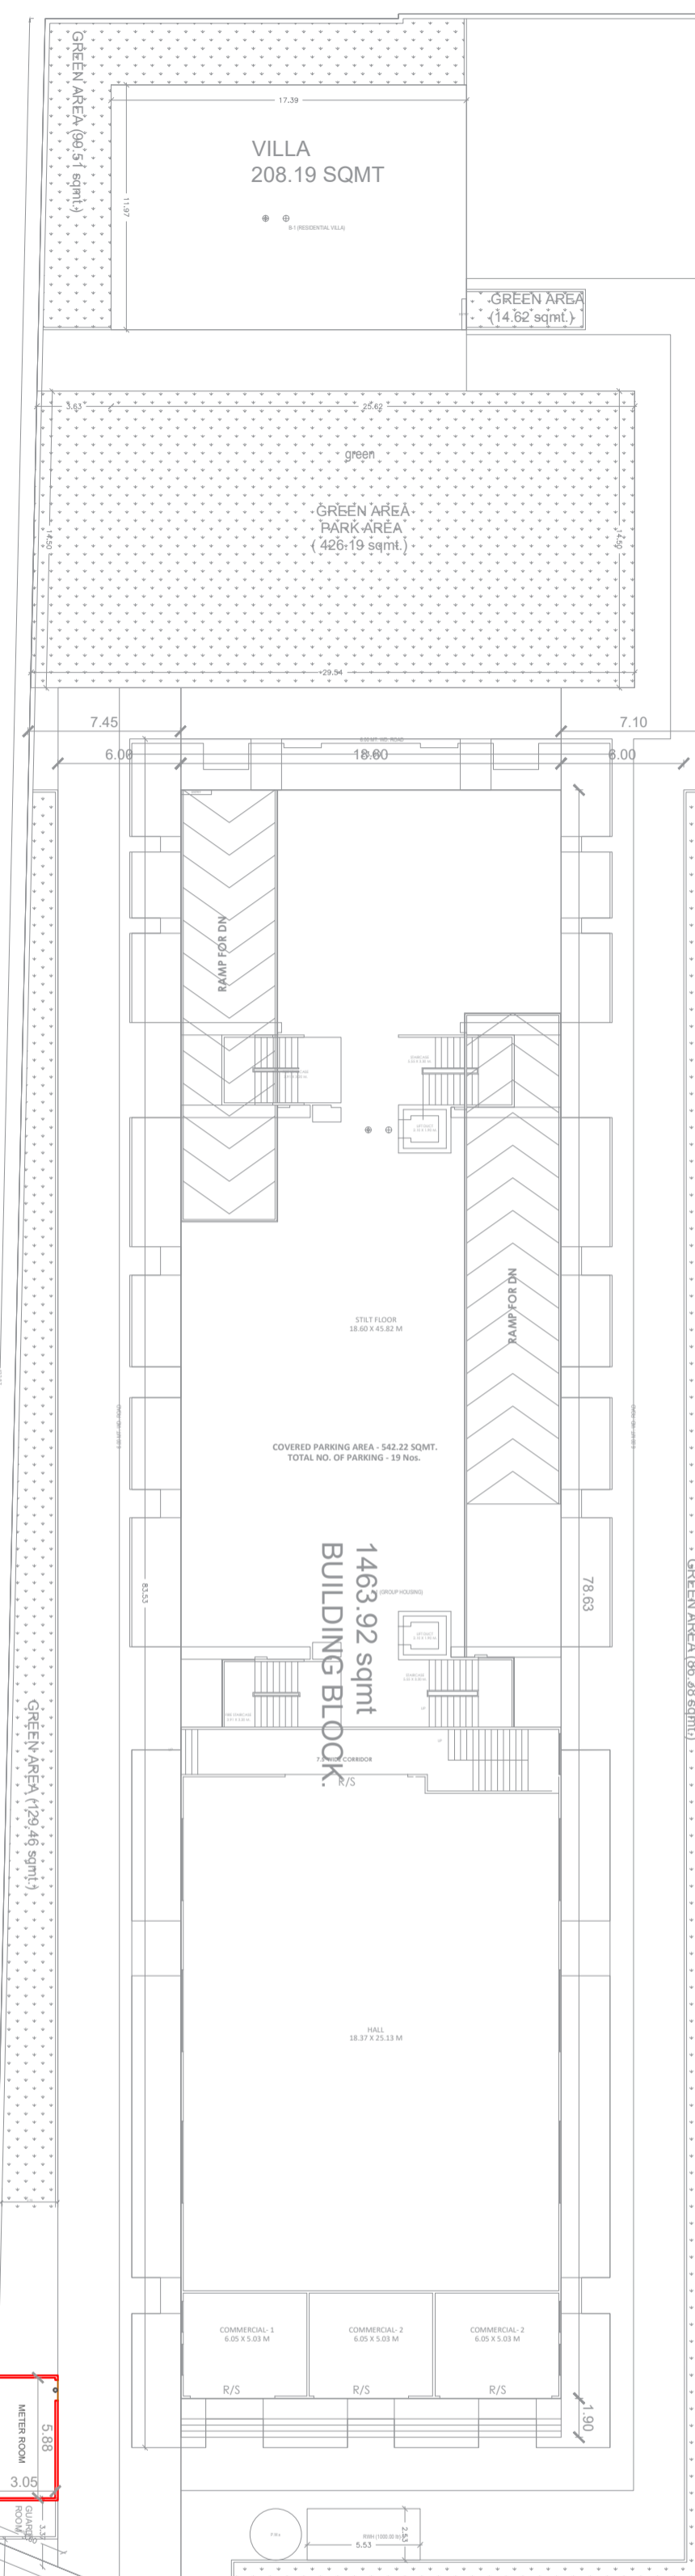

SITE PLAN

Project- GROUP HOUSING

Client-
NARAYAN VRINDAVAN owner
DHRUV NARAIN MEHRA
SITE AT - K.NO.595 (P) GRAM-SAIDPUR HAWKINS,
NEAR RAMPUR ROAD MINI BYEPASS, BAREILLY.

Purpose :
SANCTION DRAWING

GENERAL NOTES:

- All dimensions are in metres and are dimensions unless otherwise specified.
- All levels are in millimetres and are finished unless otherwise specified. All levels are mentioned in the section.
- Do not scale drawings. Only written dimensions shall be followed, any discrepancy noted shall be brought to the notice of the Architect prior to the execution.

LEGEND

	Sprinklers	
	Smoke Detector	
	Fire Extinguishers	
	Hosereel	
Scale: 1:200@ A1	North: 	Drg No: FF-01-01
Checked by: KP	Date: 02.01.23	Dealt by : KP

Title:
ELECTRICITY DISTRIBUTION
PLANS

CONSULTANT :

RAMESHWARAM
ARCHITECTS & INTERIOR DESIGNERS
17, ANAND NAGAR COLONY,
NEAR HARTMANN FLYOVER,
BAREILLY.
Consultant : Ar. Krishna Pathak
E Mail : rameshwaramarch@gmail.com
Contact : +91-6395625576