




01 LIGHTING PLAN
Scale: 1:500

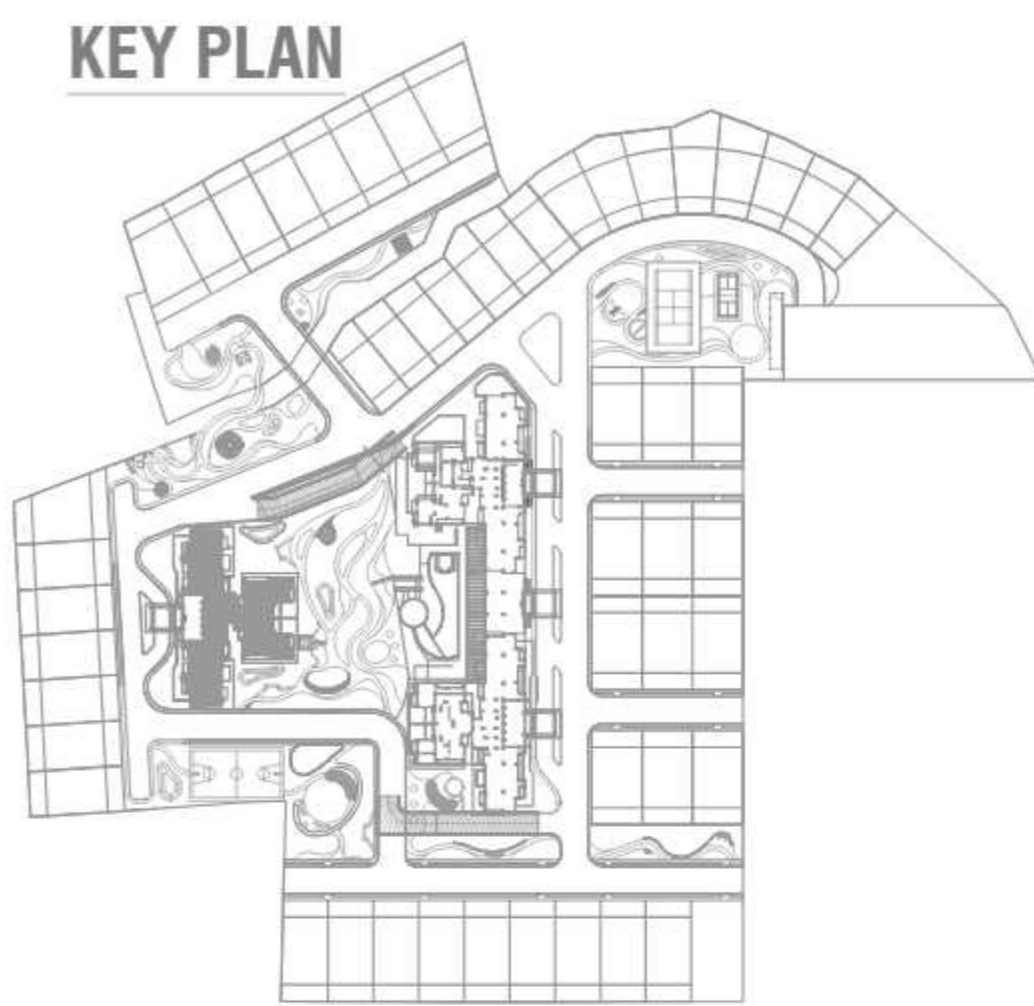

LEGEND FOR WATER SUPPLY LINE

SYMBOL	DESCRIPTION
	FLUSHING RISER
	DOMESTIC RISER
	IRRIGATION PIPE

PRINCIPAL ARCHITECT:

DESIGN FORUM INTERNATIONAL
K-47, KAILASH COLONY, NEW DELHI-110048
PHONE NO.: 011-4656600

OWNER'S SIGNATURE	ARCHITECT'S SIGNATURE
--------------------------	------------------------------

PROJECT NAME:
SOBTI'S GREENPARK

CLIENT NAME AND ADDRESS:
GATA NO.47 VILL-DIBDIBA, TEH-BILASHPUR, DIST-RAMPUR, U.P. AT HOUSING SCHEME FOR OWNERS M/S UNIRUTH PROJECTS PVT LTD., GATA NO. 66 MIN, 67 MIN, 106 MIN, 110 MIN, 113 MIN, VILL-DIBDIBA, TEH-BILASHPUR, DIST-RAMPUR, U.P. AT HOUSING SCHEME FOR OWNERS MR. CHARANPAL SINGH SOBTI S/O LATE HEERA SINGH SOBTI 80-A MODEL TOWN COLONY BAREILLY., GATA NO. 140 MIN, 142 MIN, 143 MIN. VILL-DIBDIBA, TEH-BILASHPUR, DIST-RAMPUR, U.P. HOUSING SCHEME FOR OWNERS M/S AMAR DEVELOPER PVT. LTD.

DRAWING TITLE:
SITE PLAN WATER SUPPLY PLUMBING LAYOUT

SHEET NO.
01

SCALE : 1:400
DATE : 29.02.2022