


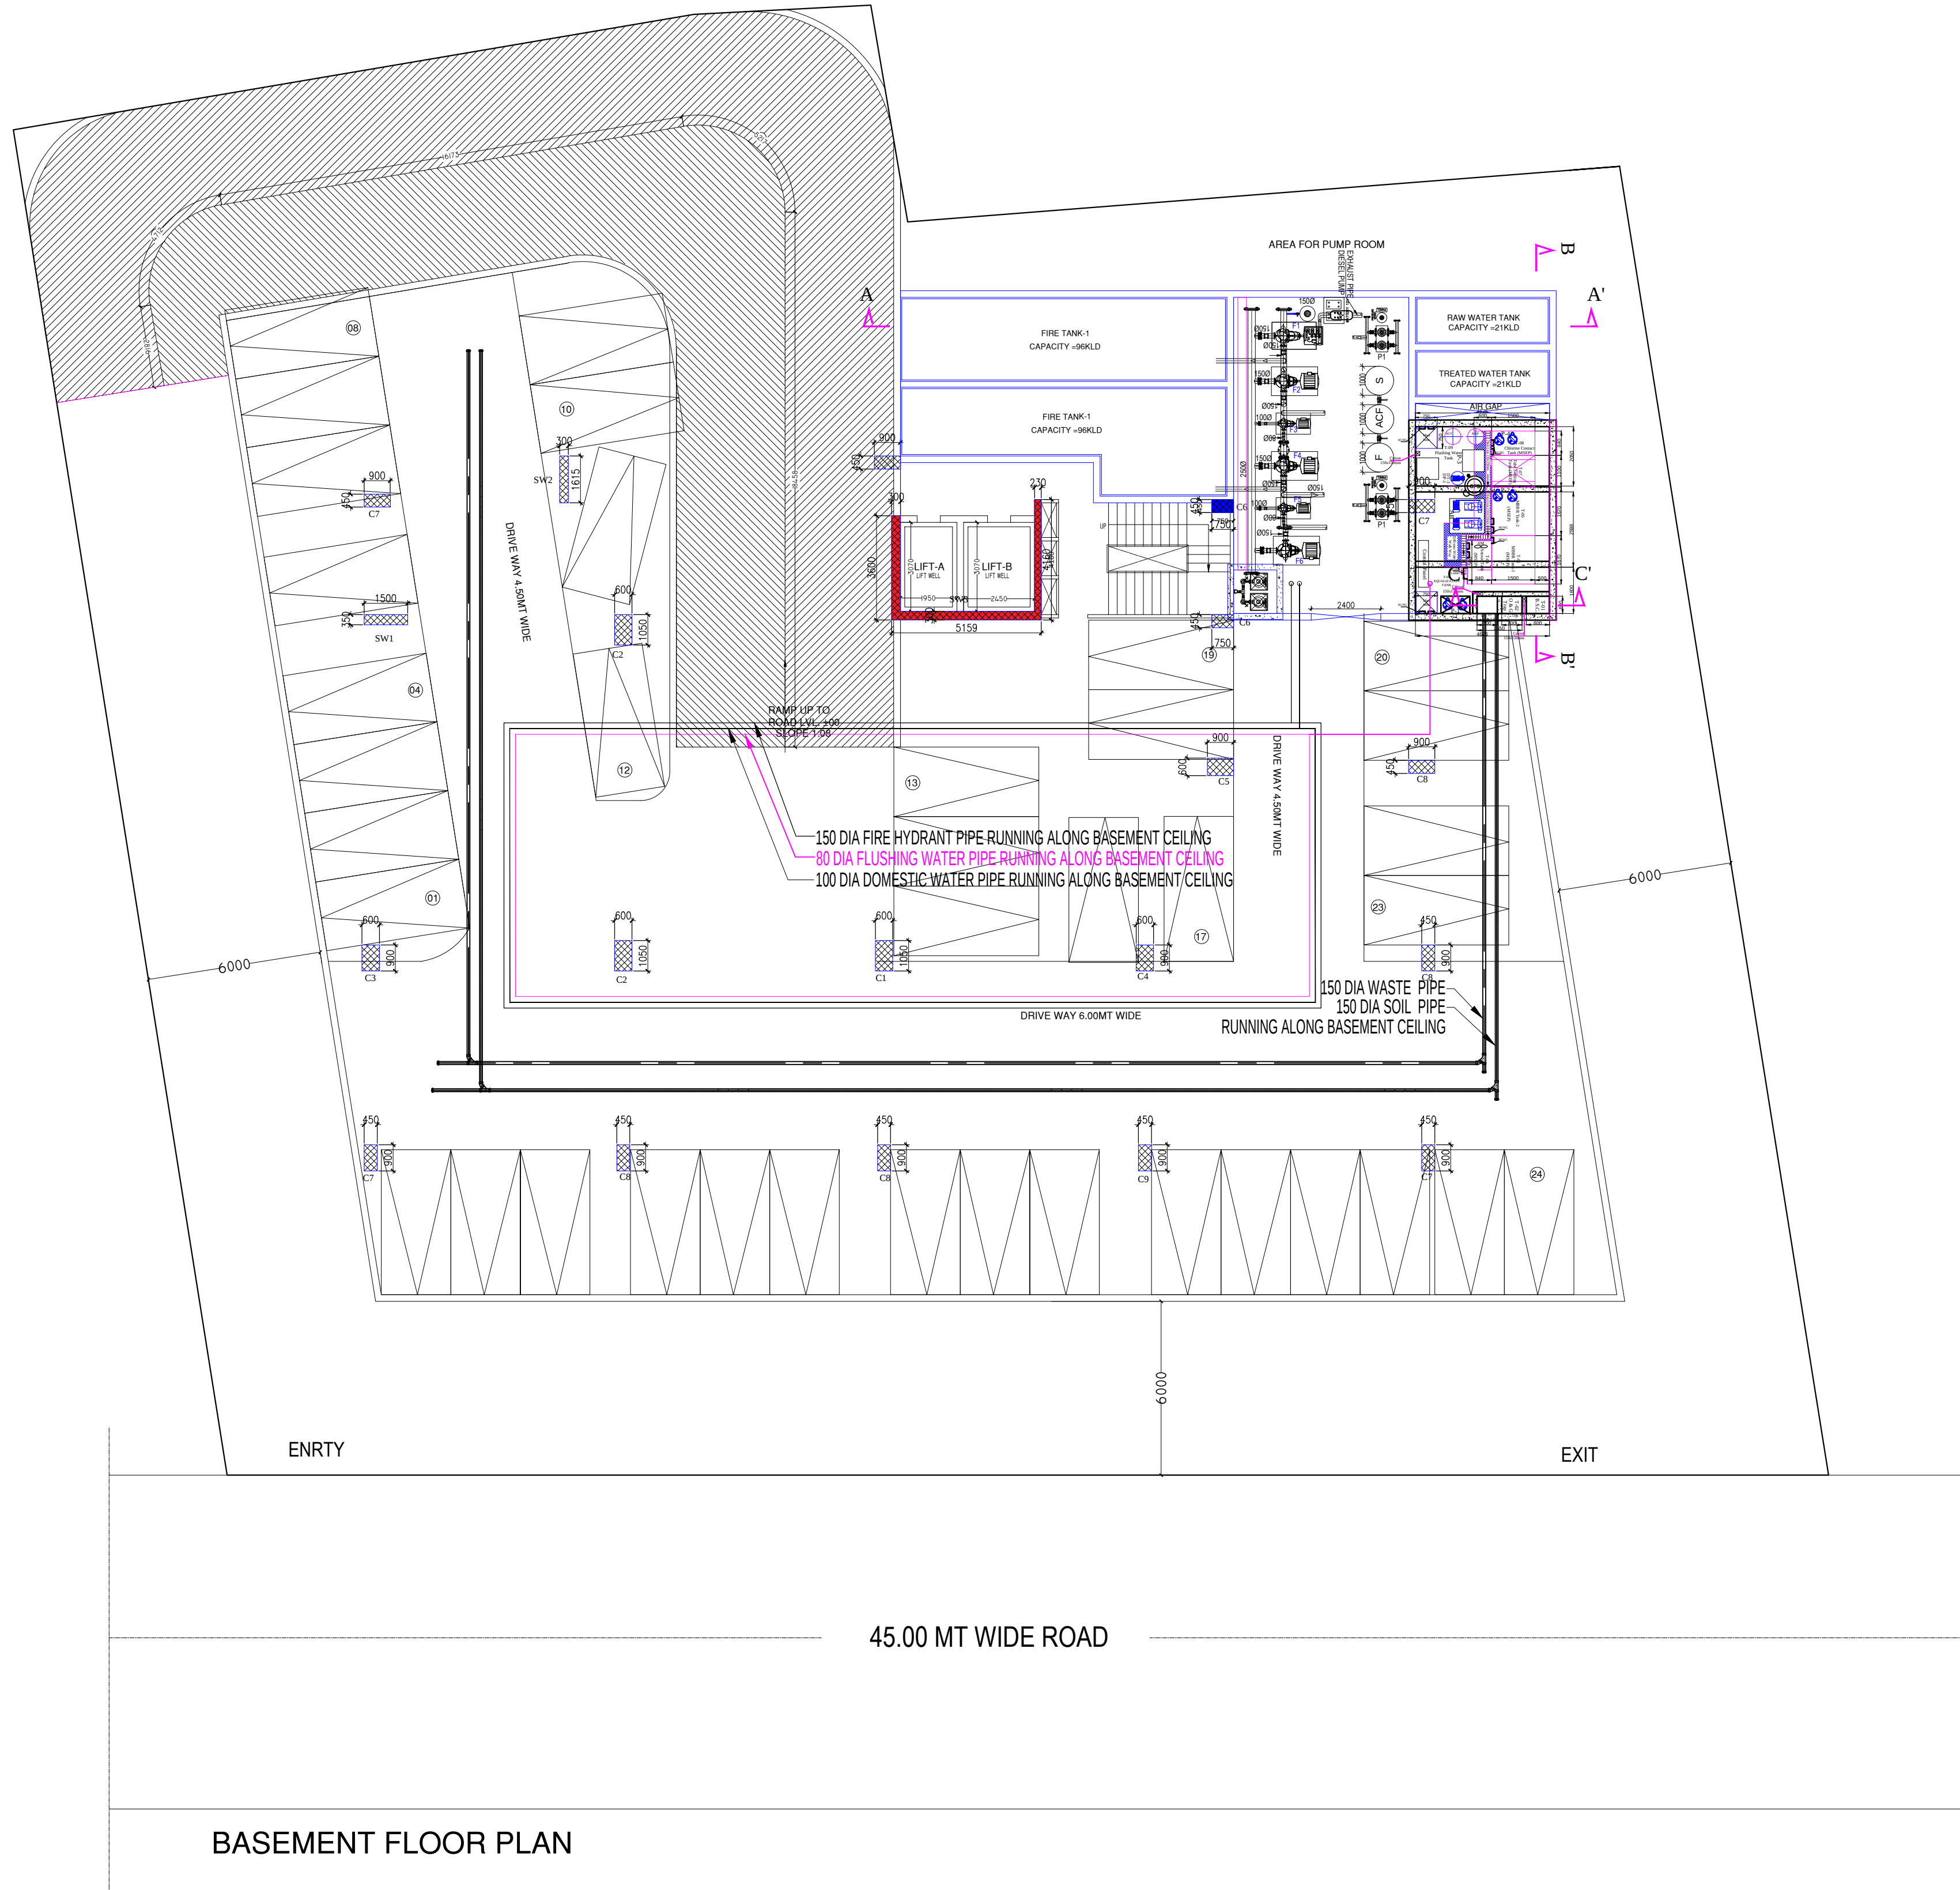

BASEMENT FLOOR PLAN

S.NO. LEGEND:-		
1.	FIRE HYDRANT PIPE	_____
2.	DOMESTIC WATER SUPPLY PIPE	_____
3.	FLUSHING WATER SUPPLY PIPE	_____

PROJECT -

OWNER -

DRAWING TITLE :-

BASEMENT PLUMBING & WATER
SUPPLY LAYOUT PLAN

OWNER SIGN

ARCHITECT SIGN

ARCHITECTS & PLANNERS:

SINGLA ARCHITECTS & ASSOCIATES

EROS MARKET PLACE, PLOT NO- 02, SHOP - 87, 1ST. FLOOR
SHAKTI KHAND - 2, INDIRAPURAM, GHAZIABAD (U.P.)

Mob: 9971998445
e-mail : gsingla32@gmail.com,

MEP Consultant:



DEALT BY:- VIBHOR	CHECKED BY:- DK	SCALE:- 1:150	DATE:- 25.07.2023	DRG. No.:- PL-BF-02
----------------------	--------------------	------------------	----------------------	------------------------