

1. All personnel and the state and their respective responsibilities listed by chapters.
2. Proposed 2005-06 financial report, including the expected for the year and the state and the 2005-06 financial report.

 
FOR APPROVAL
FOR ESTIMATION/TENDER
FOR CONSTRUCTION

No.	Revision	Date
1	1	1

**ELECTRICAL DETAILS
(BLOCK-D2)**



1991
ECCO OF FURNITURE



ELDECO HOUSING &
INDUSTRIES (P) LTD.



Mr. Samuel Hunter Cuyler
108 E. 1st Corporate Chambers,
Waltham Court Hotel,
New York, N.Y.
Mr. Wm. H. Mott
100 West 42nd St.

Driver by:	
Checked by:	
Date:	5/17/2018
Model:	not in order
Sheet No.:	Sheet Supply/Sheet 1.1

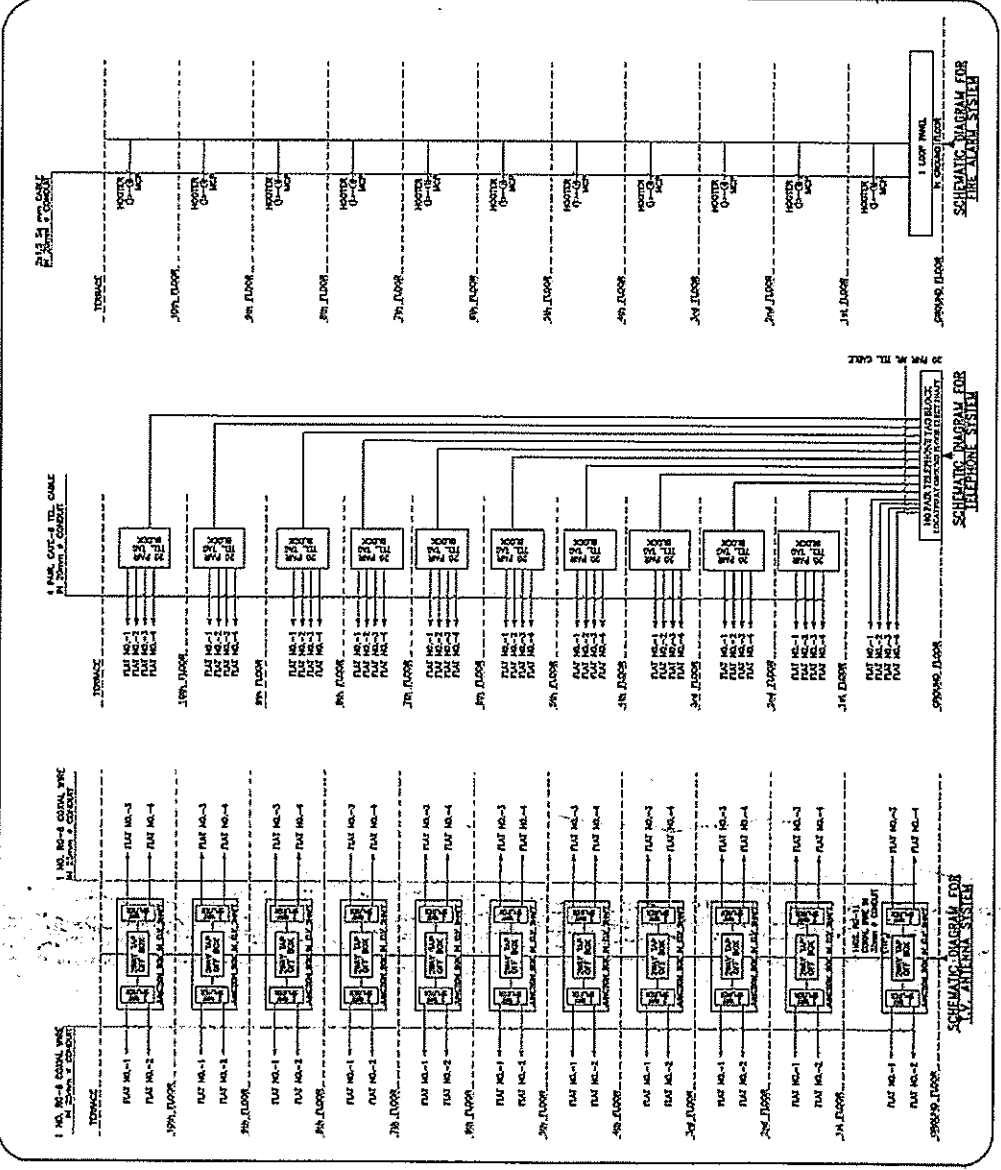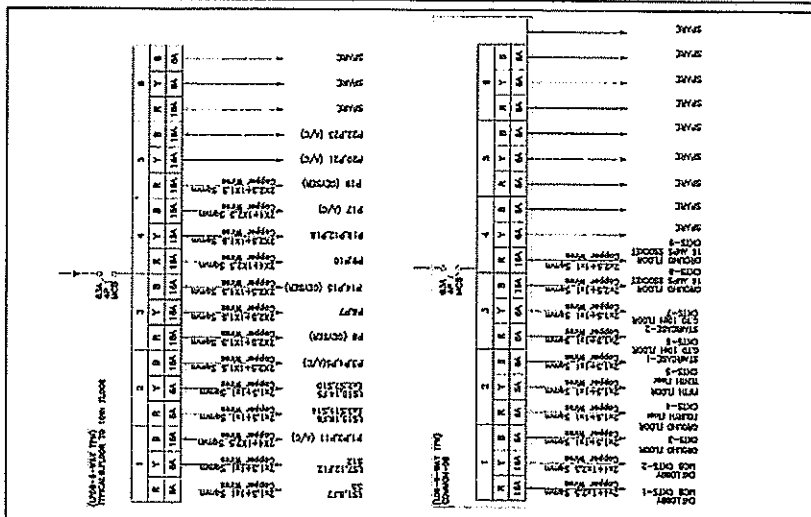

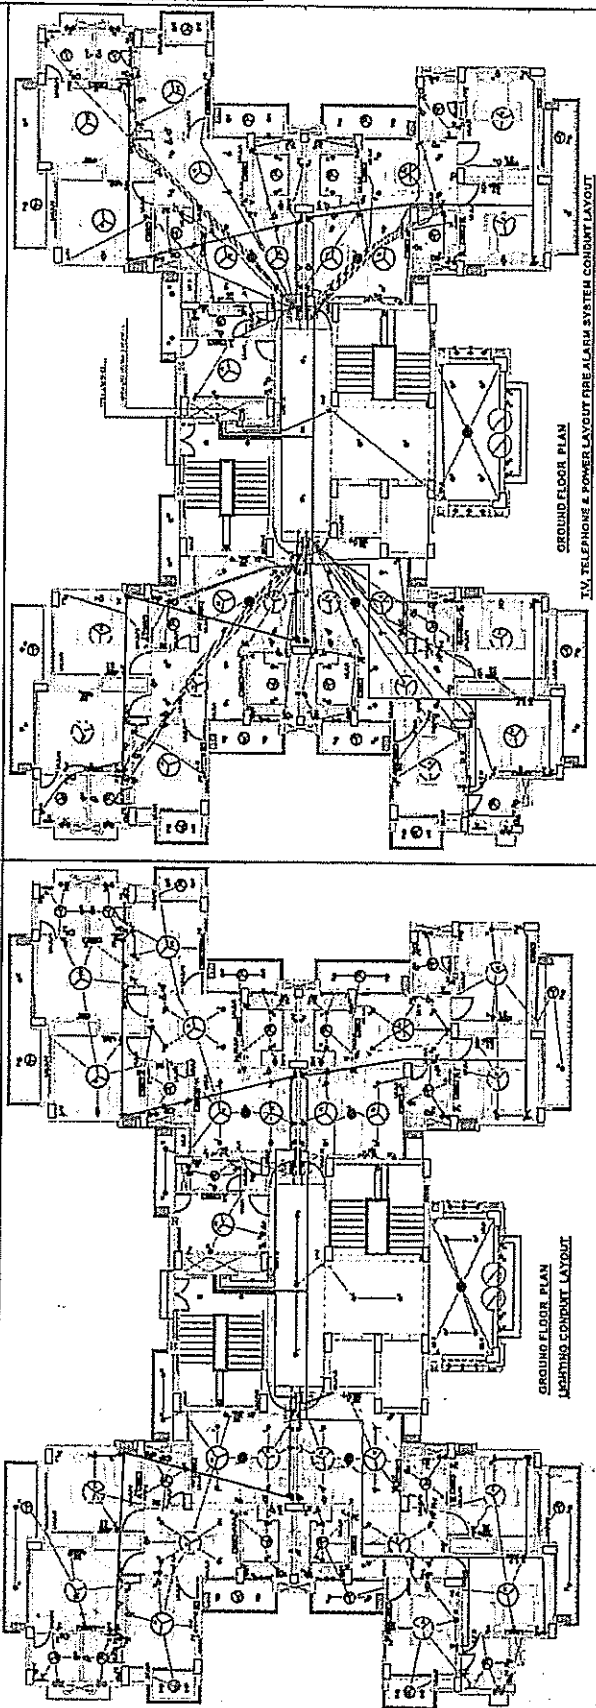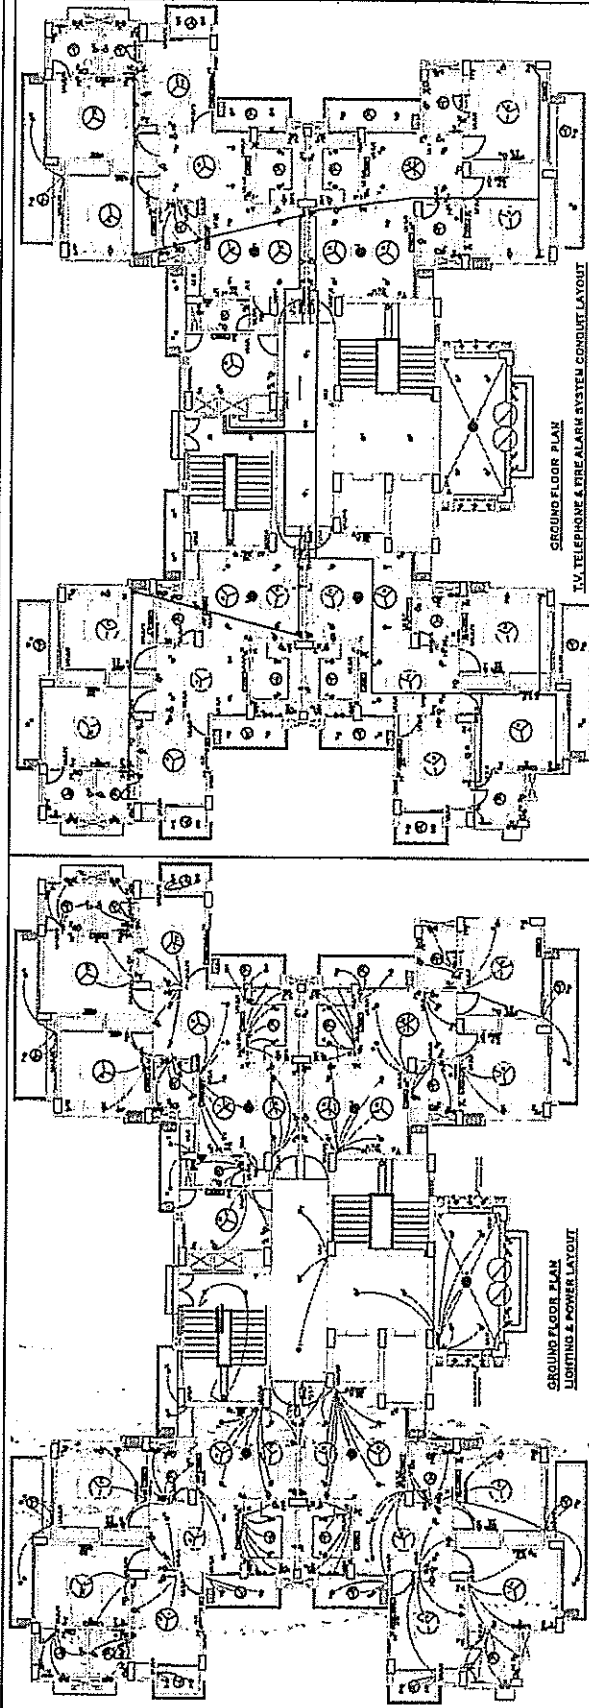

LEGEND:

- FIRE ALARM 300x150x100mm
- TV JUNCTION BOX 250x200x100mm
- LIGHTING & POWER DB 600x250x100mm

REVISIONS:

No.	Revision	Date
01	FOR APPROVAL	
02	FOR ESTIMATION/REMARKS	
03	FOR CONSTRUCTION	

PROJECT INFORMATION:

NAME: ELECTRICAL LAYOUT (GROUND FLOOR) (BLOCK-02)

LOCATION: JALAPA APARTMENT-BLOCK-02 (Building Block No. 101.54)

CLIENT: DECO BUILDING & INDUSTRIES LTD.

DESIGNER: [Signature]

DATE: [Date]