


Plot No. - GC / 3G

Plot No. - GC / 3H

Plot No. - GC / 3H

Plot No. - GC / 3K

NOTE:
THE GARDEN HYDRANT / DRP / IRRIGATION ETC. SHALL BE CONNECTED FROM THE RECYCLE LINE
GIVEN ON THE DRAWING AS REQUIRED BY LANDSCAPE CONSULTANT OR AS PER SITE.

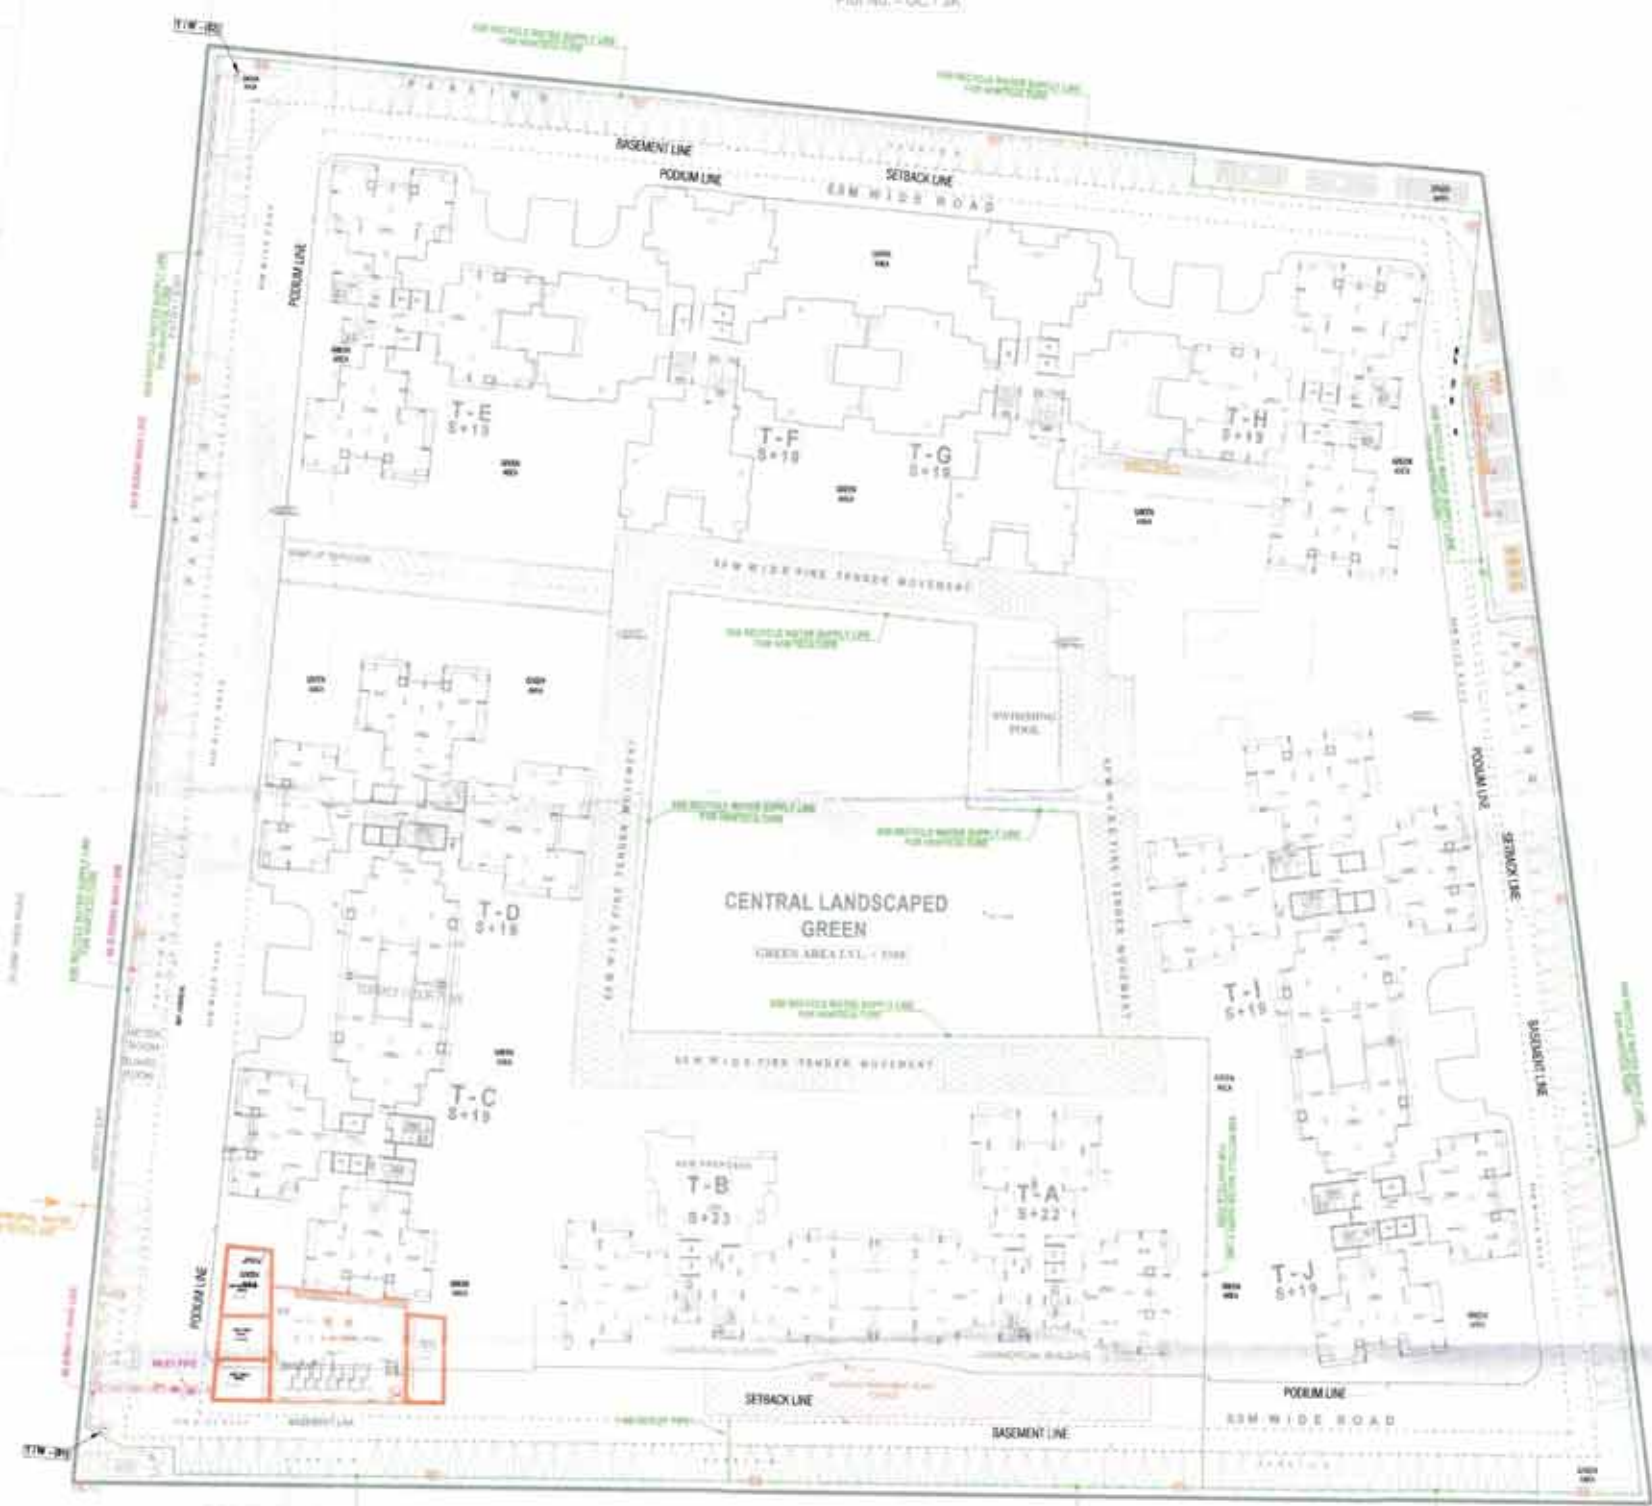

LEGEND:

S. No.	SYMBOL	DESCRIPTION
1	---	RECYCLE WATER SUPPLY LINE FOR WASHING TUB
2	---	RECYCLE WATER SUPPLY LINE FOR WASHING TUB
3	---	RECYCLE WATER SUPPLY LINE FOR WASHING TUB
4	---	RECYCLE WATER SUPPLY LINE FOR WASHING TUB
5	---	RECYCLE WATER SUPPLY LINE FOR WASHING TUB
6	---	RECYCLE WATER SUPPLY LINE FOR WASHING TUB
7	---	ISOLATING VALVE
8	---	ISOLATING VALVE WITH BASIN/CHAMBER
9	---	PROPOSED TUBE WELL
10	---	BASEMENT LINE
11	---	GARDEN HYDRANT

NOTES: WATER SUPPLY

- THE DEPTH OF GRAVITIC WATER SUPPLY MAIN SHALL BE 1000 MM
- THE DEPTH OF FORCE MAIN SHALL BE 1200 MM
- PIPE MATERIAL:
FOR FORCE MAIN: 100% HDPE (1000 MM)
FOR EXTERNAL WATER SUPPLY: 100% HDPE (1000 MM)

REV. NO.	DATE	REVISION
PROJECT VVIP HOMES GREATER NOIDA		
TITLE SITE PLAN		
SUBTITLE EXTERNAL WATER SUPPLY SYSTEM		
DRAWING RELEASED FOR ☐ APPROVAL ☒ SUBMISSION ☐ ADVANCE COPY ☐ CONSTRUCTION		
DWG. NO. VVIP HOMES / EX / S-03	DRAWN BY Kulwant	
SCALE 1:450	DESIGNED BY R.K.	
DATE Mar. 2015	CHECKED BY Anand Harela	
Architects: GIAN T. SINGH ARCHITECTS B. Arch. REG. No. 1111 CA No. 803759		
services consultant Consummate Engineering Services (P) Ltd. Head Office: B-12, Sector-62, Noida-201301 Tel: (0120) 2000000 / 0120 2000001 Fax: (0120) 2000002 / 0120 2000003 E-mail: info@cespi.in website: www.cespi.in		