

45 M WIDE ROAD

30 M WIDE ROAD


20 M WIDE ROAD

LEGEND :

S. No.	SYMBOL	DESCRIPTION
1.		RECYCLED WATER SUPPLY PIPE LINE
2.		RISING MAIN WATER PIPE LINE
3.		MUNICIPAL WATER SUPPLY PIPE LINE
4.		ISOLATING VALVE
5.		PROPOSED TUBE WELL
6.		BASEMENT LINE
7.		GARDEN HYDRANT

LEGEND - FIRE SYSTEM

S. No.	SYMBOL	DESCRIPTION
1.		FIRE LINE
2.		WARD HYDRANT 63 MM DIA. SINGLE BRANCH HYDRANT VALVE FIRE 3 NO. BRANCH PIPE WITH NOZZLE
3.		FIRE BRIGADE CONNECTION
4.		BITTERLY VALVE
5.		NON-RETURN VALVE (CHECK VALVE)
6.		ISOLATING VALVE WITH MASONRY CHAMBER

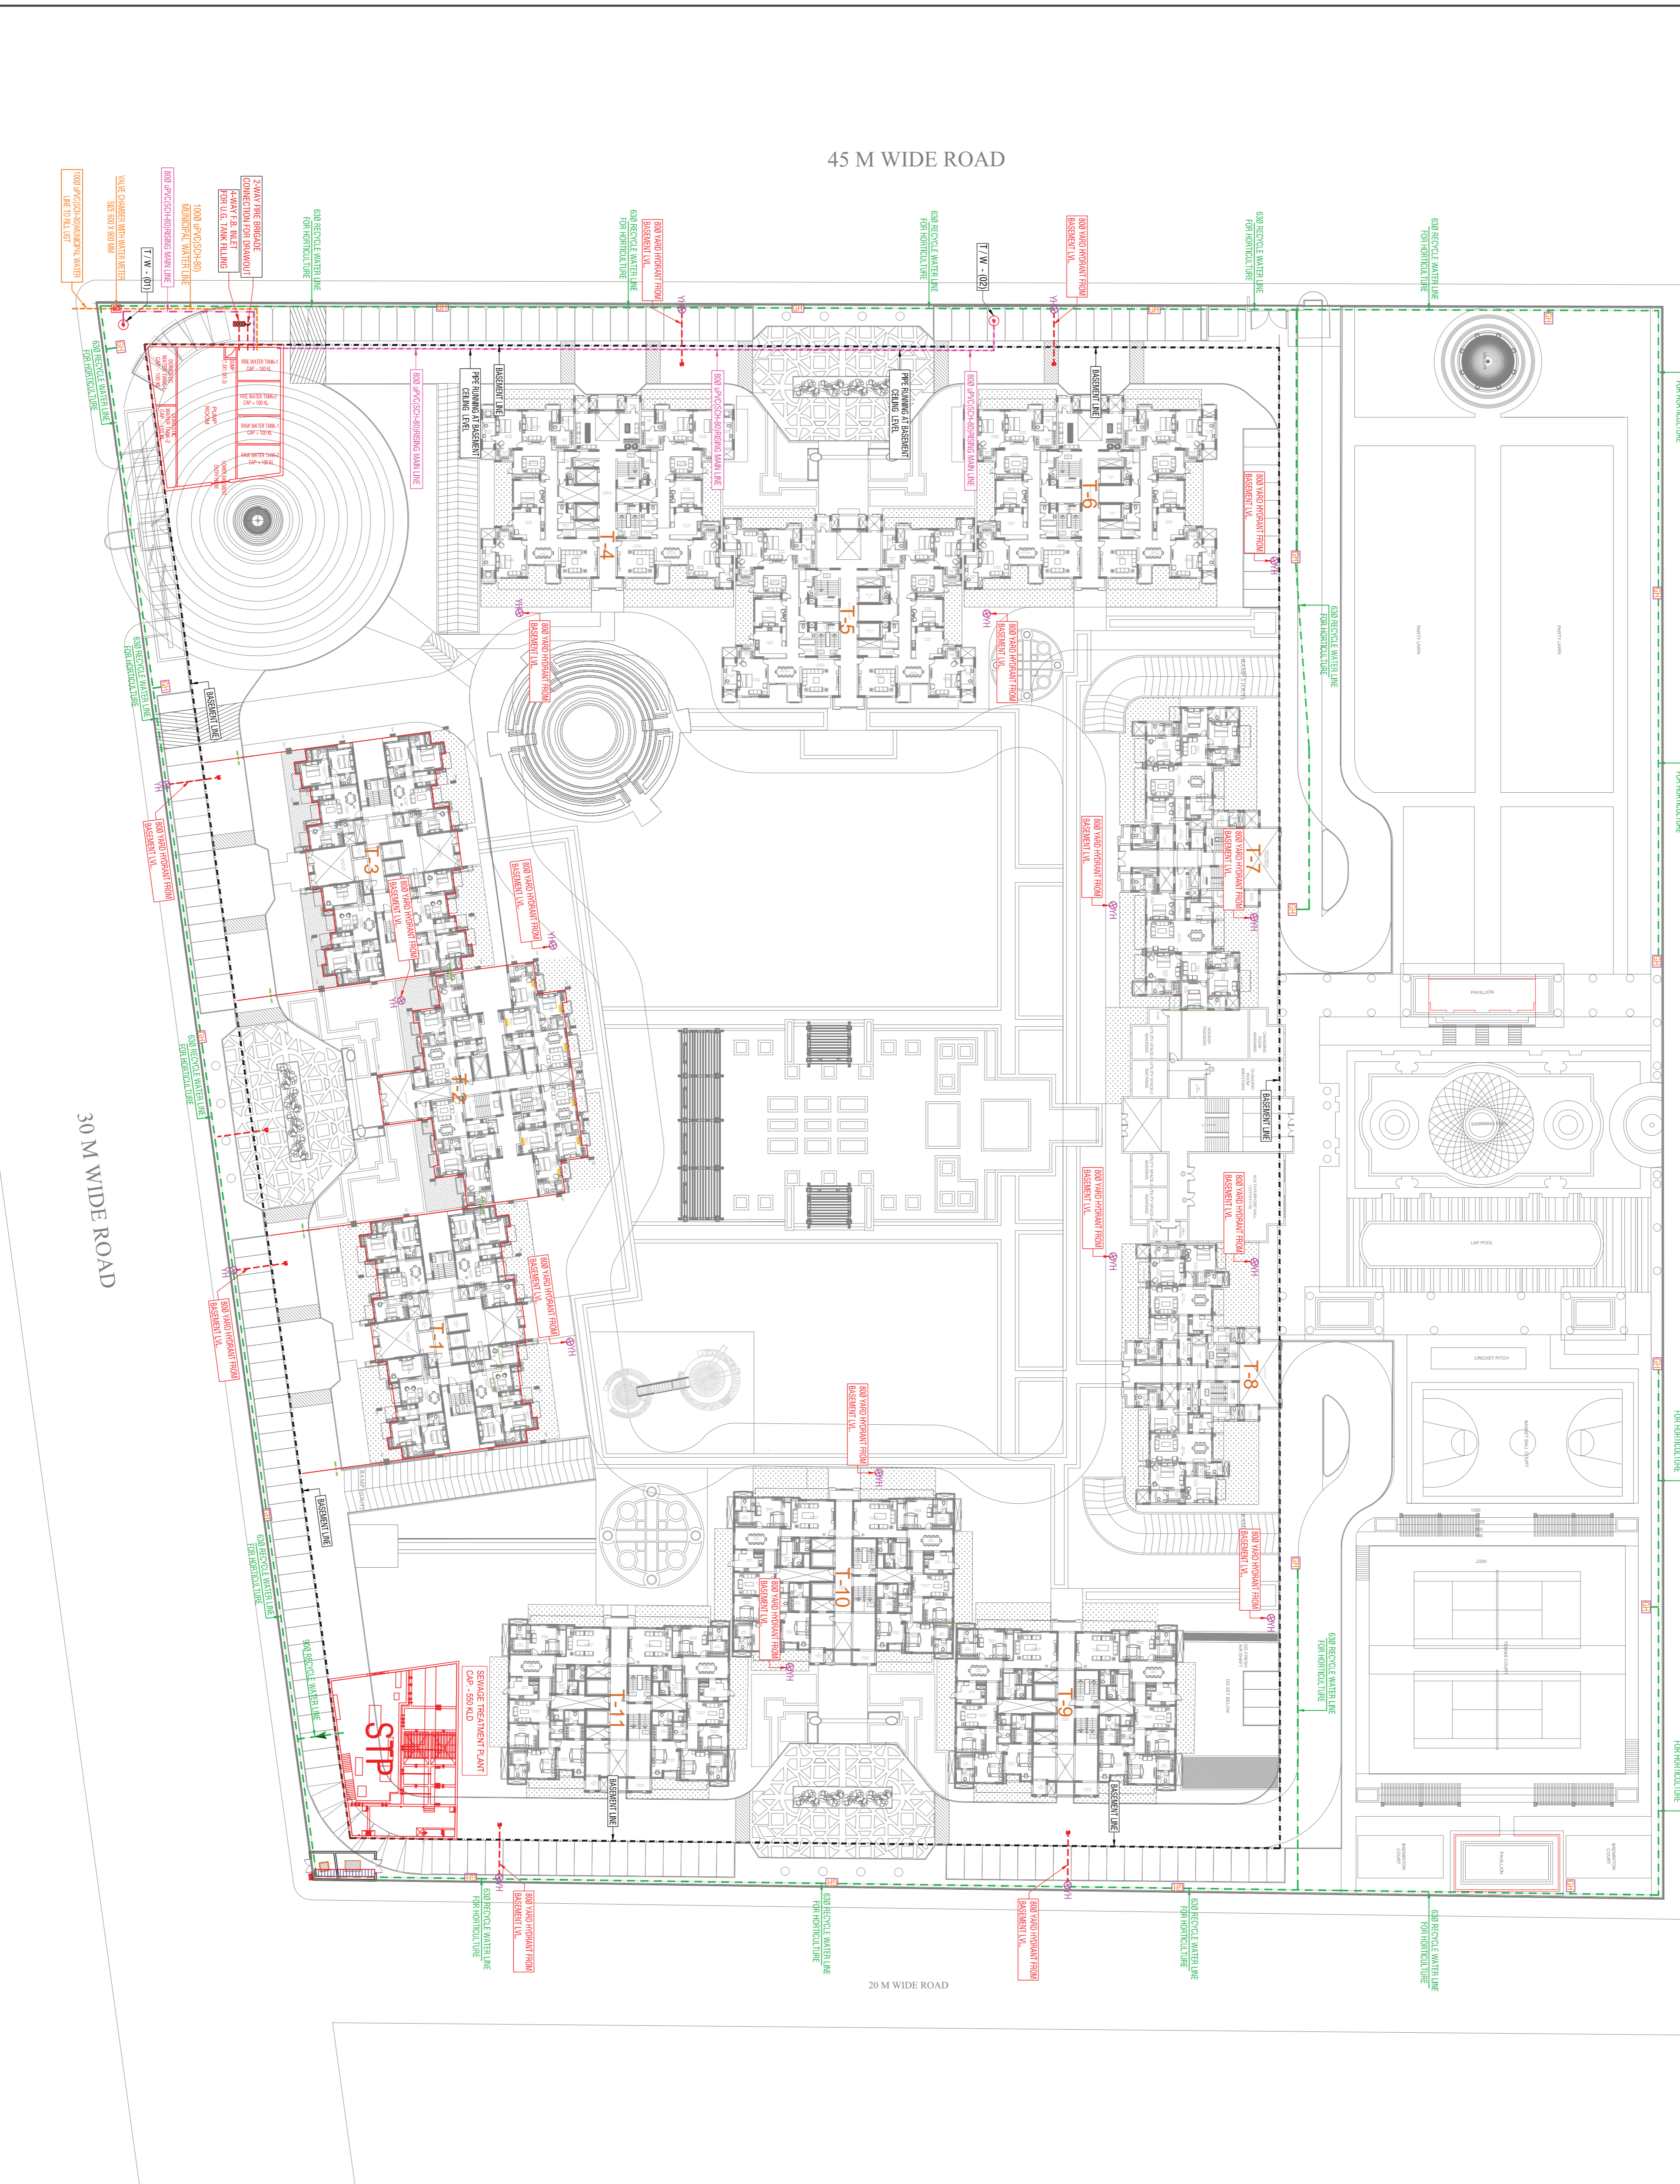

Rev. no.	Date	Revision

Project
ACE PARKWAY
SECTOR 150, NODA

Title
SITE PLAN

Subtitle
EXTERNAL WATER SUPPLY SYSTEM

Drawing released for

APPROVAL SUBMISSION

ADVANCE COPY CONSTRUCTION

Drawn by **Designed by**

Kulwant R.K.

Date **Checked by**

July, 2018 Arund Hanjra

Services Consultant
Consummate Engineering Services (P) Ltd.

cespl

Head Office: B-67, Sector-67, Noida-201 301
Tel: (0120)6688001 (23 Lines)
Data Office: A-906, Indira Park, Gurgaon, Haryana
e mail: mail@cespl.in, website: www.cespl.in