


OTHERS PLOT

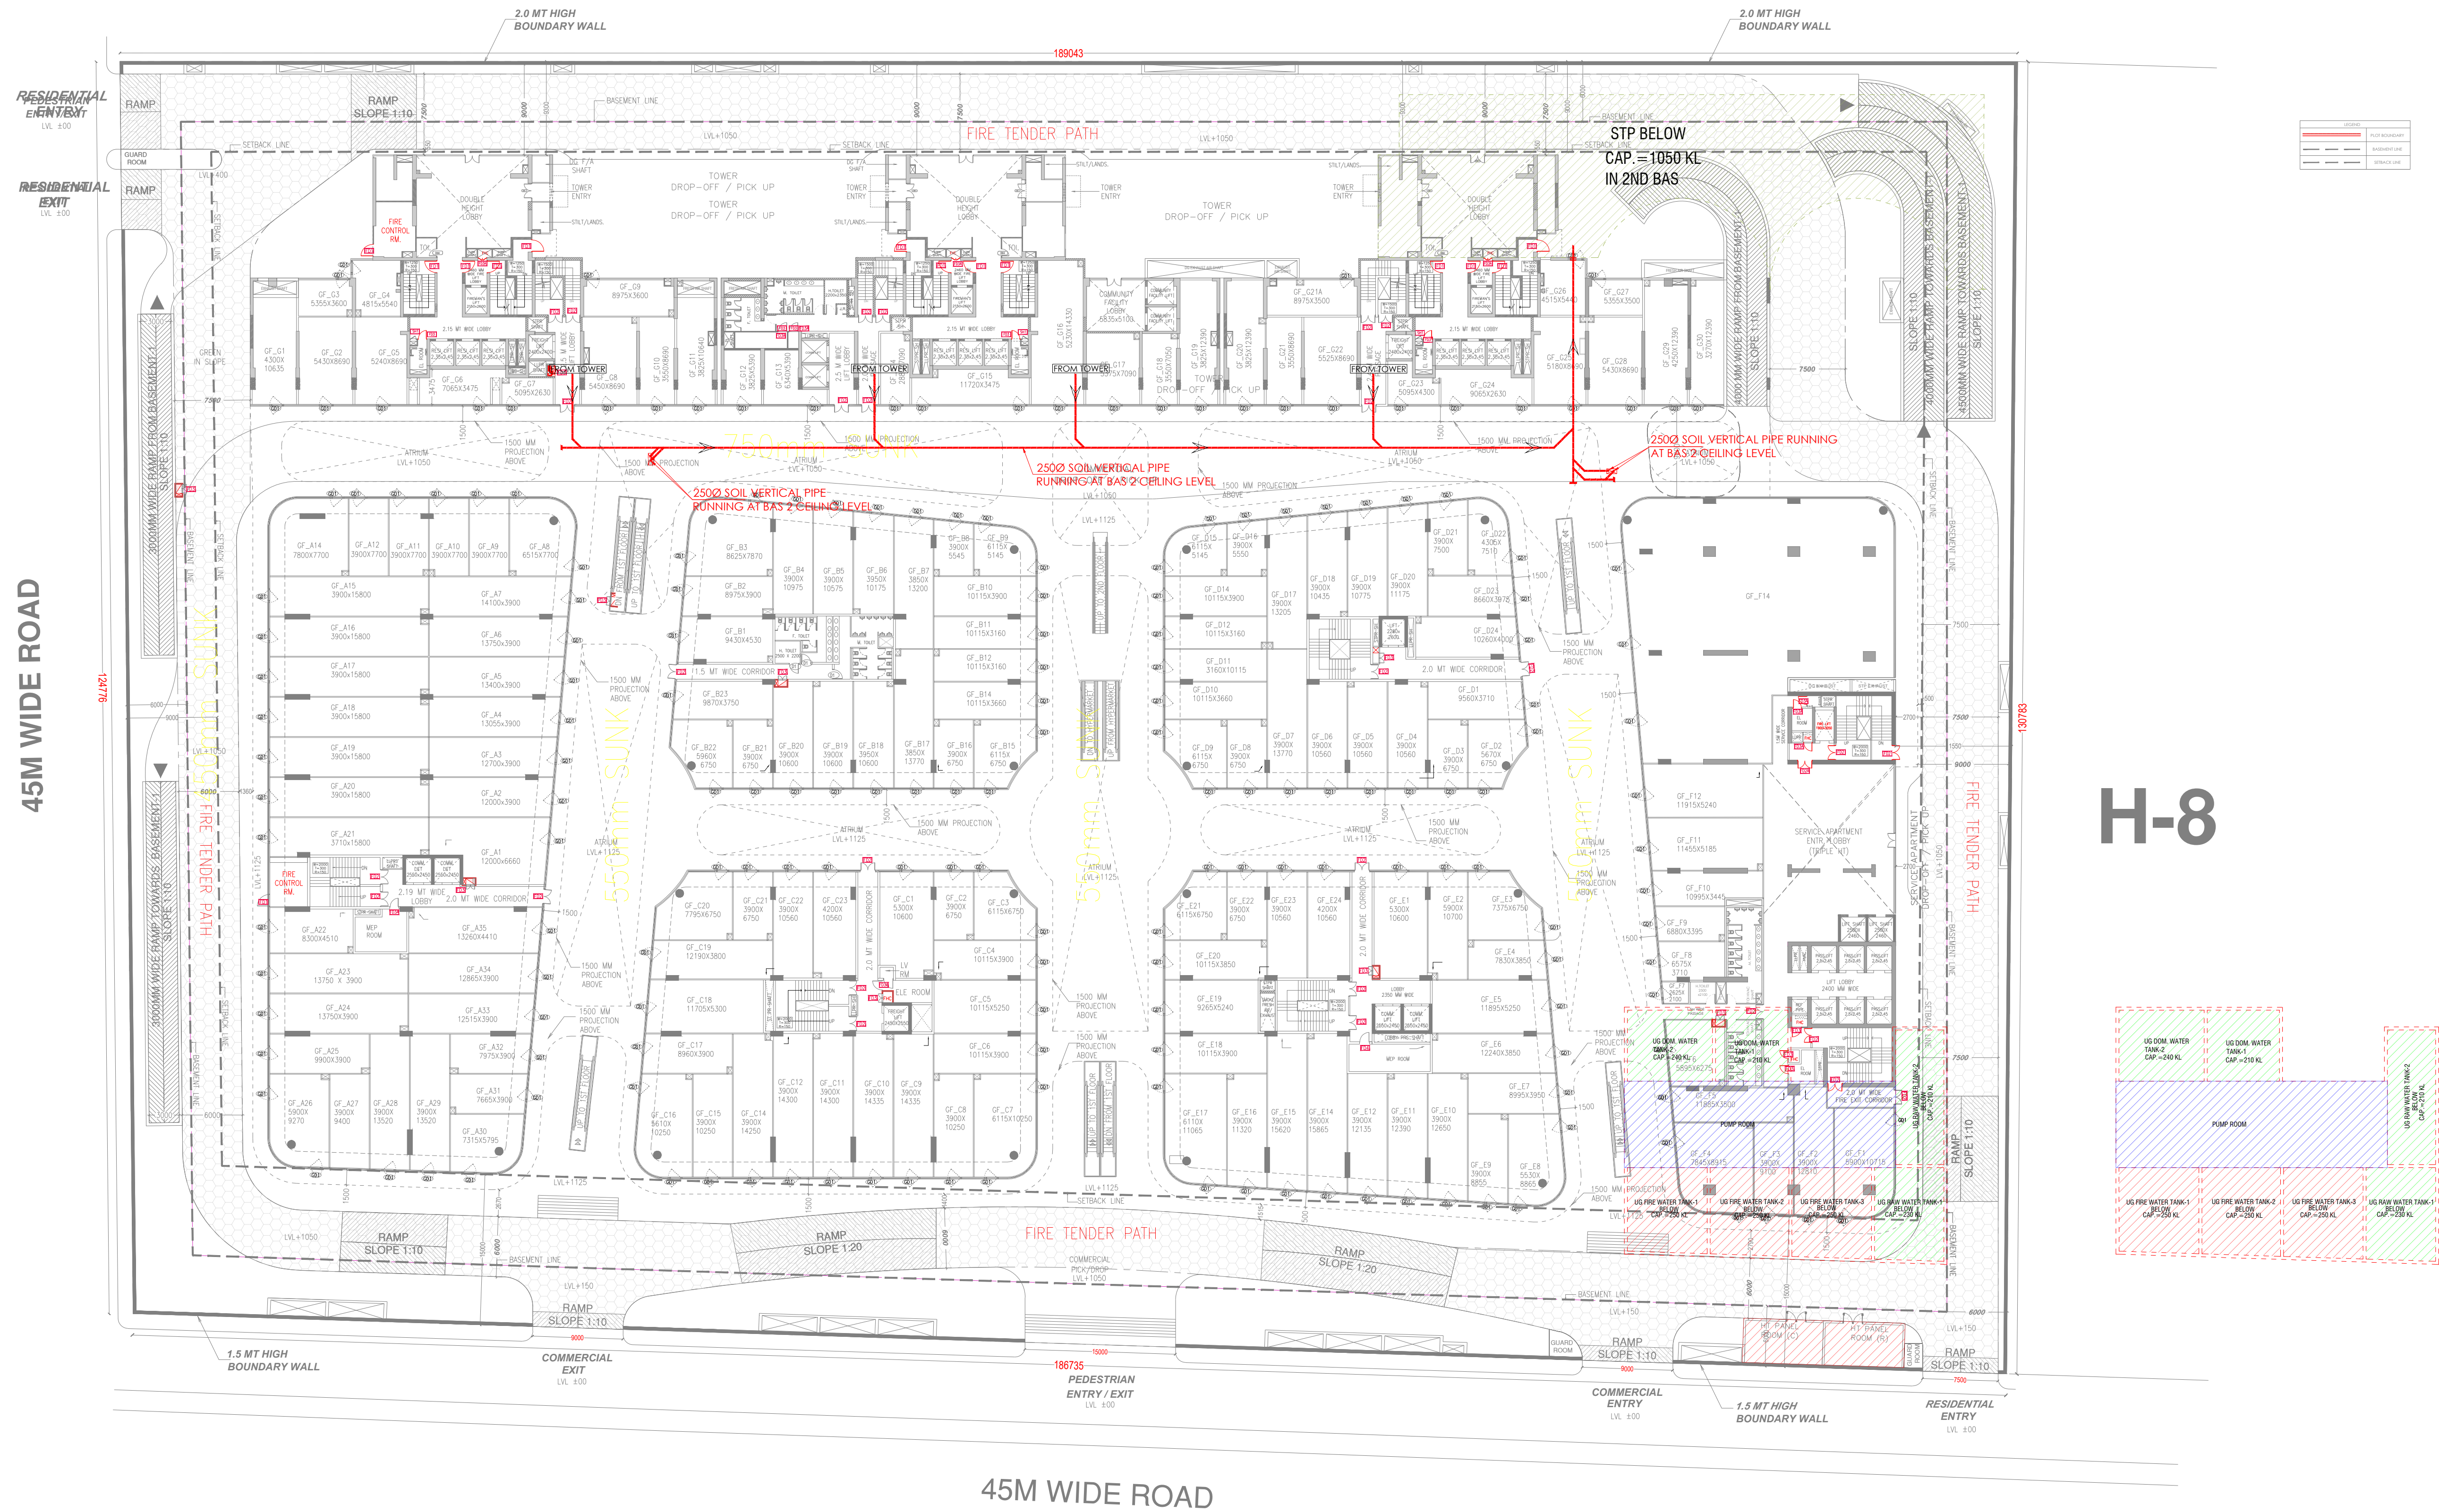


H-8

NOTE :-

1. BUILDING HAS AUTOMATIC SPRINKLER SYSTEM WHEREVER REQUIRED BY NBC.
2. BUILDING WILL BE DESIGNED (STRUCTURES) AS PER RELEVANT IS CODES FOR EARTH QUAKE RESISTANCE.
3. 100% POWER BACKUP/ MECHANICAL VENTILATED SHAFTS.

KEY PLAN

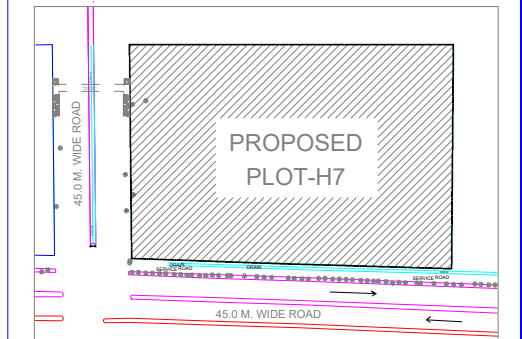

LEGEND	
	PLOT BOUNDARY
	BASEMENT LINE
	SETBACK LINE

PROJECT

FIRE APPROVAL OF BUILDING PLAN OF
MLU PROJECT SMARTWORLD ELIE SAAB
AT PLOT NO H-7, SECTOR-98, NOIDA

FOR M/S BLITZBAY DEVELOPERS
PRIVATE LIMITED

ARCHITECTS

STUDIO SYMBIOSIS

India	I	Germany	I	UK
INDIA 1301, Tower-E, Skymark One Sector 98, Noida, U.P. 201301, Noida TEL: +91 0120 4226979 E-MAIL: info@studio-symbiosis.com www.studio-symbiosis.com				

ARCHITECT'S SEAL & SIGNATURE

OWNER'S SEAL
& SIGNATURE

ARCHITECT'S SEAL
& SIGNATURE

SEP 2025	Scale :-	Drawing No:-
Drawing Title:-		

PL GROUND FLOOR PLAN (SOIL& WASTE)