



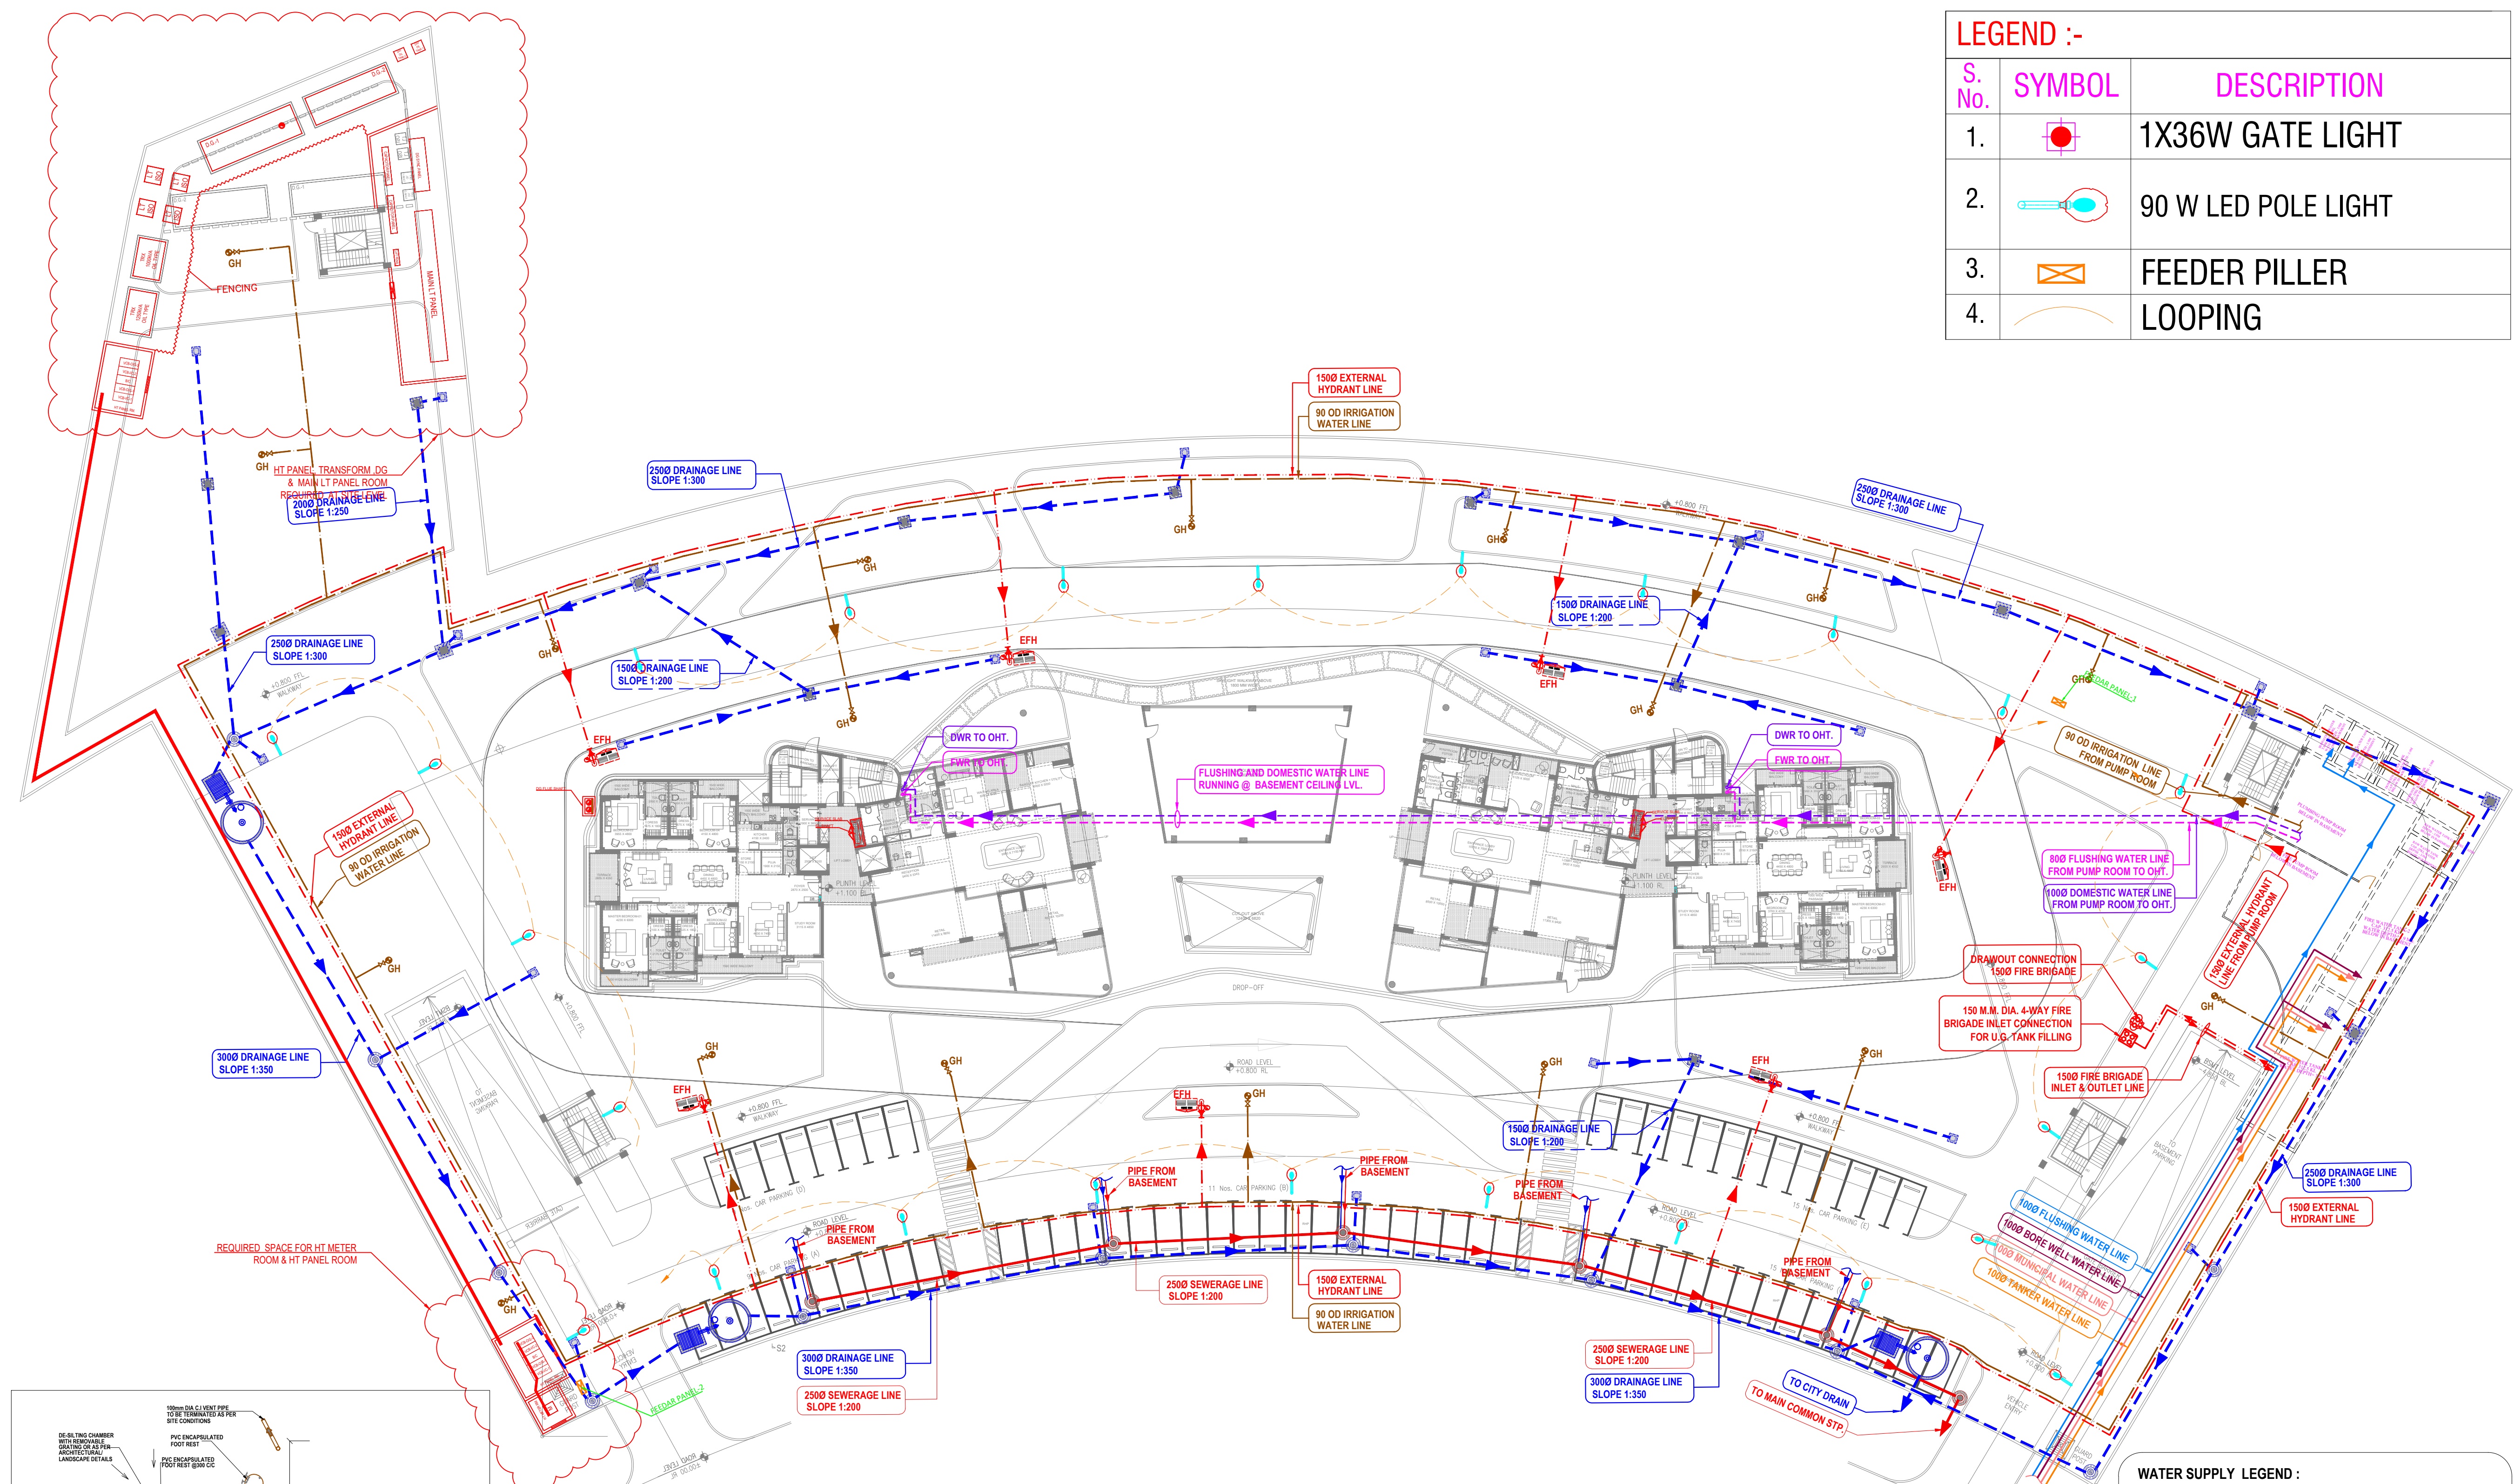

LEGEND :-		
S. No.	SYMBOL	DESCRIPTION
1.		1X36W GATE LIGHT
2.		90 W LED POLE LIGHT
3.		FEEDER PILLER LOOPING
4.		LOOPING

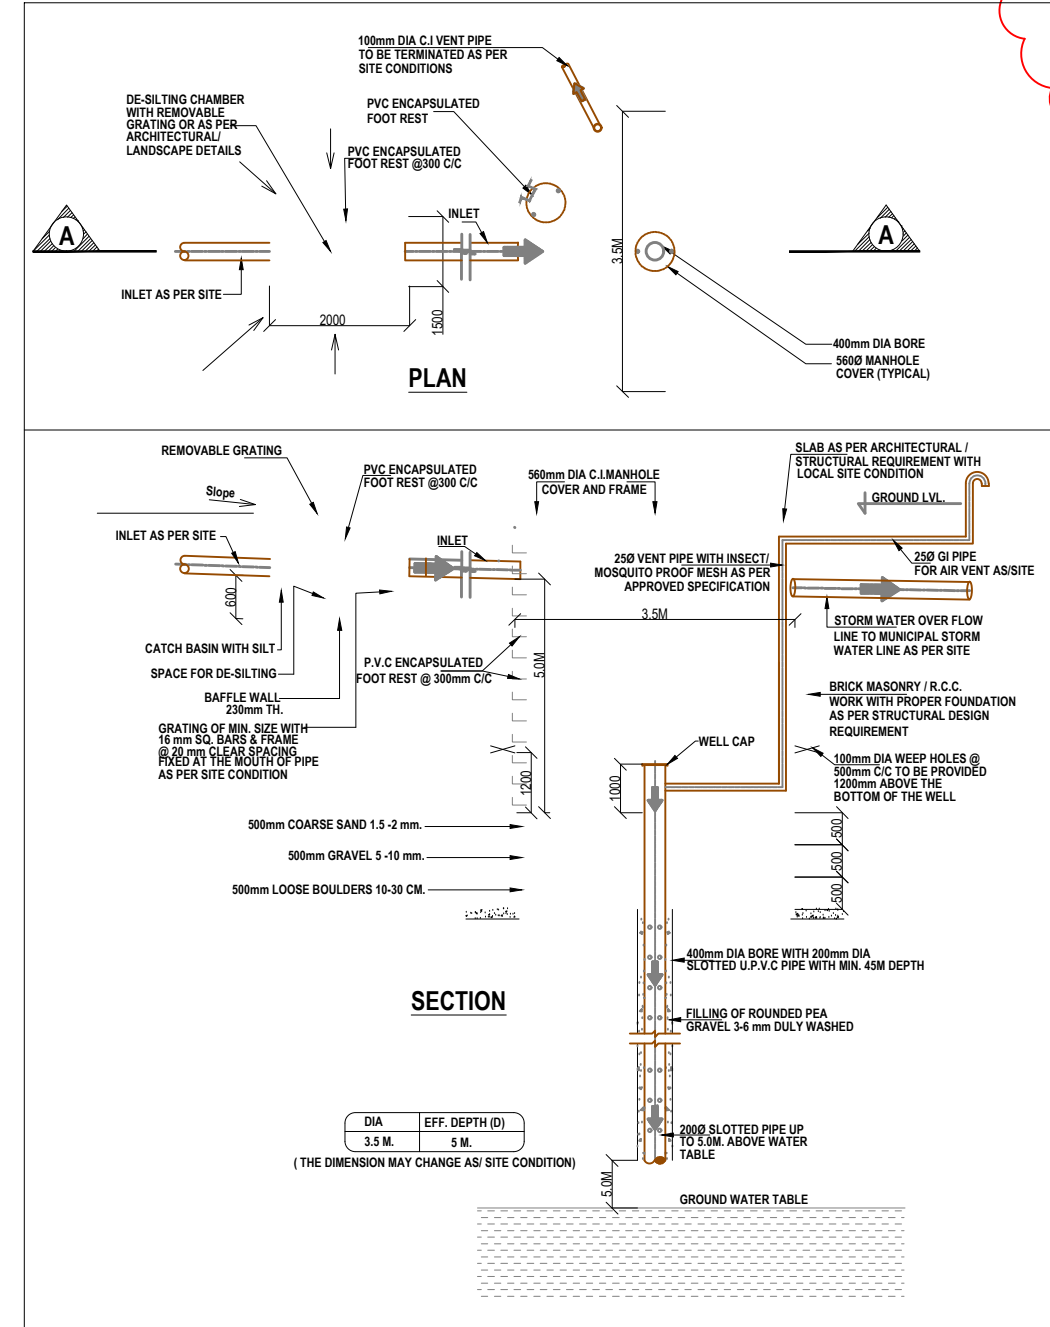

WATER SUPPLY LEGEND :		
S. No.	SYMBOL	DESCRIPTION
1.		GARDAN HYDRANT
2.		GARDAN HYDRANT LINE

EXTERNAL FIRE LEGEND :		
S. No.	SYMBOL	DESCRIPTION
1.		EXTERNAL FIRE HYDRANT
2.		EXTERNAL FIRE HYDRANT LINE
3.		GARBAGE COLLECTION

1
A/1002
GROUND FLOOR PLAN
SCALE 1:300

DRAINAGE LEGEND :		
S. No.	SYMBOL	DESCRIPTION
1.		450X500MM DRAINAGE CATCH BASIN
2.		600X600MM DRAINAGE CHAMBER
3.		800X900 MM DRAINAGE MANHOLE
4.		9100/12000/15000 DRAINAGE MANHOLE
5.		RECHARGE WELL
6.		DRAINAGE LINE

WATER SUPPLY LEGEND :		
S. No.	SYMBOL	DESCRIPTION
1.		RISING MAIN LINE (FROM T/W TO U.G.T.)
2.		MUNICIPAL WATER SUPPLY LINE
3.		TANKER WATER SUPPLY LINE
4.		FLUSHING WATER LINE FROM EXTERNAL
5.		FLUSHING WATER RISER LINE
6.		DOMESTIC WATER RISER LINE

SEWERAGE LEGEND :		
S. No.	SYMBOL	DESCRIPTION
1.		300X300 MM GULLY TRAP
2.		800X900 MM SEWERAGE MANHOLE
3.		9100/12000/15000 SEWERAGE MANHOLE
4.		SEWERAGE LINE

KEY PLAN

GENERAL NOTES
1. THIS DRAWING IS THE COPYRIGHT OF JT+PARTNERS AND MUST NOT BE RETAINED, COPIED OR USED WITHOUT THE ABOVE CONSULTANT'S AUTHORITY.
2. DO NOT SCALE FROM THE DRAWINGS.
3. ALL DIMENSIONS ARE IN MILLIMETERS AND LEVELS IN METERS UNLESS NOTED OTHERWISE. ALL DIMENSIONS TO BE VERIFIED ON SITE & APPROVED BY THE ENGINEER.
4. THIS DRAWING SHOULD BE READ IN CONJUNCTION WITH OTHER RELEVANT ARCHITECTURAL, STRUCTURAL, MECHANICAL, ELECTRICAL, LANDSCAPE AND INTERIOR DESIGN DRAWINGS AND ALL RELEVANT SECTIONS OF THE SPECIFICATIONS.
5. REFER TO MASTERPLAN / SETTING OUT PLAN FOR DIMENSIONS / LENGTH OF BOUNDARY WALL THAT VARIES AS MENTIONED ON THIS DRAWINGS

ISSUE HISTORY
PURPOSE OF ISSUE
REV. DATE AUTHORIZED

REVISION HISTORY
REV. DESCRIPTION DRAWN DATE AUTHORIZED

CLIENT

LEAD CONSULTANT
Jt+P
JT & PARTNERS ARCHITECTURAL AND ENGINEERING CONSULTANT
DUBAI P.O.Box 413606, Tel: +971 (0)4 452 1135 www.jtpartners.com

ARCHITECTS
42mm
ARCHITECTURE
BASEMENT, D-215 SAKET,
NEW DELHI - 110017

MEP CONSULTANT
PDA CONSULTANT
REGD OFFICE
PLOT NO-100 SECOND FLOOR
PATPARGANJ INDUSTRIAL AREA, DELHI-110092, INDIA
TEL : +91-11-4240830/142408302

STRUCTURAL CONSULTANTS
TPC TECHNICAL PROJECTS CONSULTANTS(P) LTD.
H.O- B-74, SECTOR 57, NOIDA
UTTAR PRADESH-201301 (INDIA)
BOARD NO:-91-120-4306800

DESIGN & ENGINEERING * COST & QUALITY MANAGEMENT * RETROFITTING
GURGAON • HYDERABAD • NEWDELHI • NOIDA

PROJECT:
Proposed Group Housing-13 for ANS Developers
(P) Ltd at Khasra No.325P,326P,328P,348P-355P
Situated at Baghamau Integrated Township,
Shalimar One World

DRAWING TITLE:
**CO-ORDINATED
EXTERNAL SITE**

DRAWN B.B. CHECKED P.J. AUTHORIZED A.A. SHEET A1
DATE 09-11-2023 DATE 09-11-2023 DATE 09-11-2023 SCALE AS SHOWN
DRAWING NUMBER
PDA-178-SITE-PL-001 0