



DRG. NO.

FILE NO.

PROJECT :

PROPOSED GROUP
HOUSING
SCHEME AT SECTOR -07
MANDOLA VIHAR
AT GHAZIABAD (U.P.).

DATE	NO.	ISSUED TO	INITIAL
25.01.16	R0	ISSUED FOR APPROVAL	
DATE	REV. NO.	BRIEF RECORD	INITIAL
		REVISION	

NORTH - DRG.NO.-
AED-MV-PH-EX-BD-01

SUB TITLE:

APPROVAL DRAWING

SCALE : 1:400

CHECKED BY : MGP

SCHEME:

MANDOLA VIHAR YOJNA,
AT GHAZIABAD

DRG. TITLE:

BASEMENT FLOOR DRAINAGE
LAYOUT

ARCHITECT'S SIGNATURE

ARCH CONSULTANTS

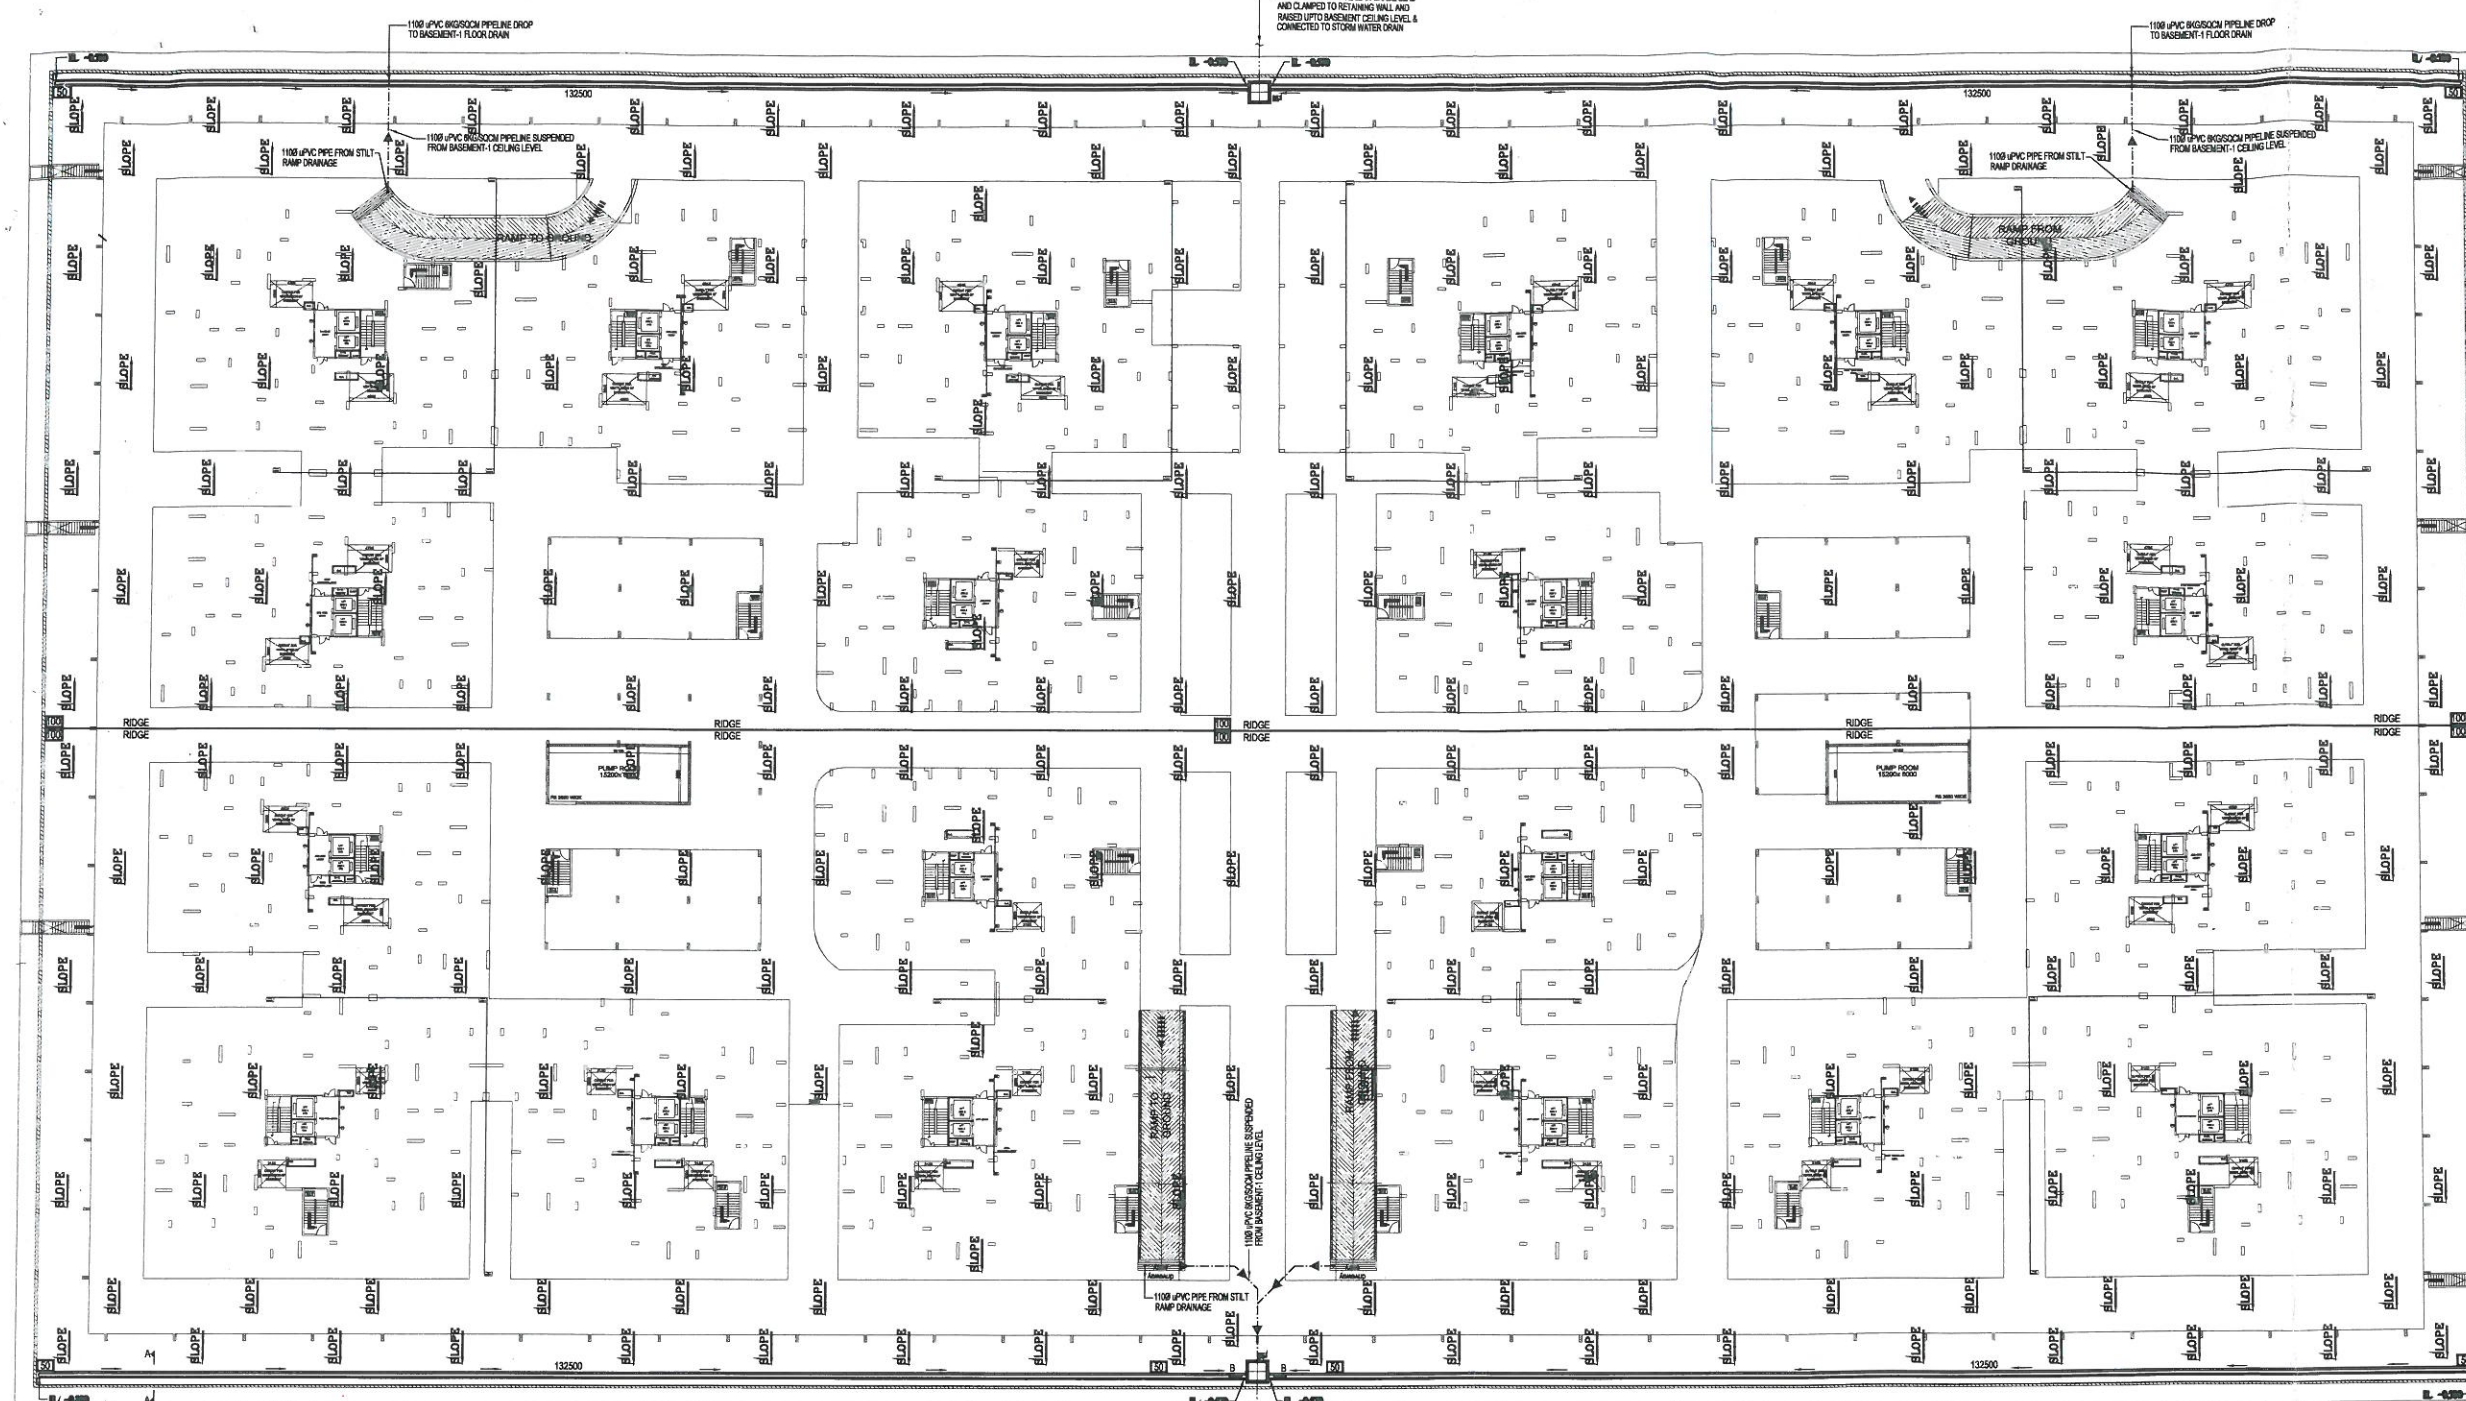
ARCH-EN DESIGN
ARCHITECT ASHOK KUMMAR
DELHI OFF B-1/37, HAUZ KHAS, NEW DELHI-16
PH 011-26510350, 011-45188222
LKO OFF 4/5 VISHAL KHAND
GHUMTI NAGAR, LUCKNOW PH 0522-4088222

ASSTT.ARCH. PLANNER

ARCHITECT PLANNER

CHIEF ARCH. PLANNER

HOUSING COMMISSIONER



BASEMENT DRAINAGE LAYOUT

±0.000 LVL REFERS TO FFL OF BASEMENT NEAR TO DRAIN

LEGEND:

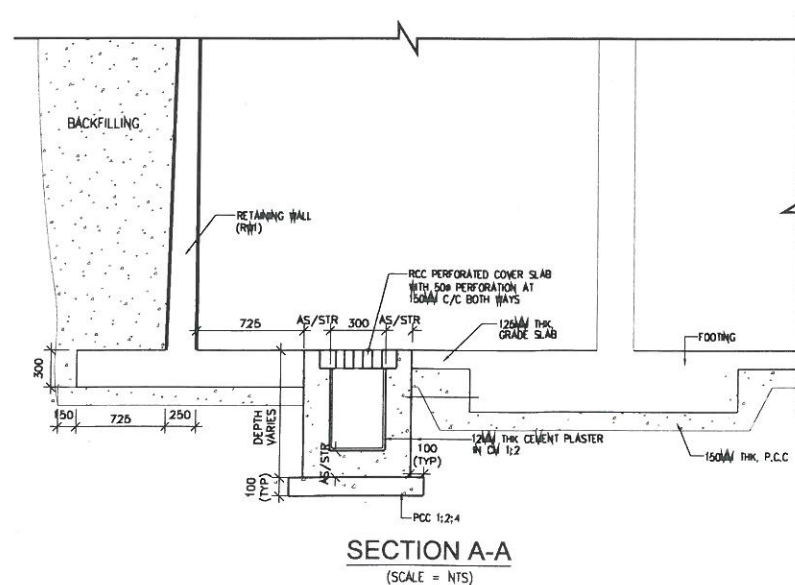
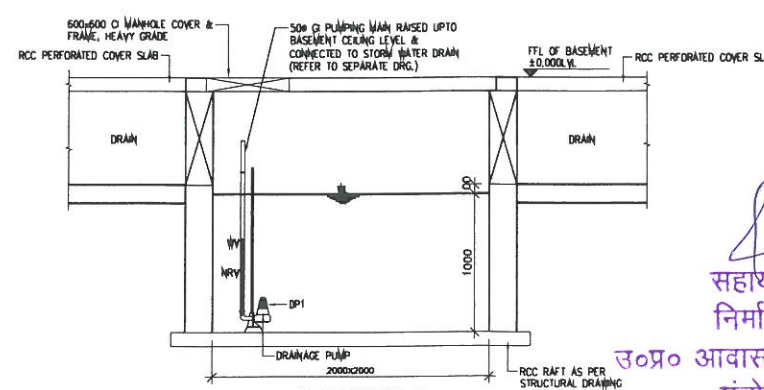
- FFL - FINISHED FLOOR LEVEL
- NRV - NON-RETURN VALVE
- WV - WHEEL VALVE
- IL - INVERT LEVEL
- WL - WATER LEVEL
- DS1 - DRAINAGE SUMP
- DP1 - SUBMERSIBLE DRAINAGE PUMP
- 250mm Ø 10m HEAD
- 300MM WIDE DRAIN
- FLOW DIRECTION
- 50 SCREED THICKNESS IN MM

NOTES:

- ALL DIMENSIONS ARE IN MILLIMETRES AND LEVELS ARE IN METRES UNLESS STATED OTHERWISE.
- NO DIMENSIONS TO BE SCALED FROM THIS DRAWING.
- THIS DRAWING SHALL BE READ IN CONJUNCTION WITH LATEST REVISION OF RELEVANT STRUCTURAL AND ARCHITECTURAL DRGS.

Letter No...../Dt.....

(E.E.C.D-22) (E.E.C.D-38) (S.E.(M))
(M/S. NCC LTD.) UPAVP, Baghat UPAVP, Baghat UPAVP, Baghat

SECTION A-A
(SCALE = NTS)SECTION B-B
(SCALE = NTS)
(TYPICAL SECTION OF DRAINAGE SUMP DS1)

सहायक अभियन्ता
निर्माण खण्ड, 38
उ०प्र० आवास एवम् विकास परिषद्
मंडोला (बागपत)

ARCHITECTING & DEVELOPMENT BOARD
B-1/37, GROUND FLOOR
HAUZ KHAS, NEW DELHI -16
Ph: (011) 45188222, 26510350, 26510355
Fax: 011-26510350, 45188268