


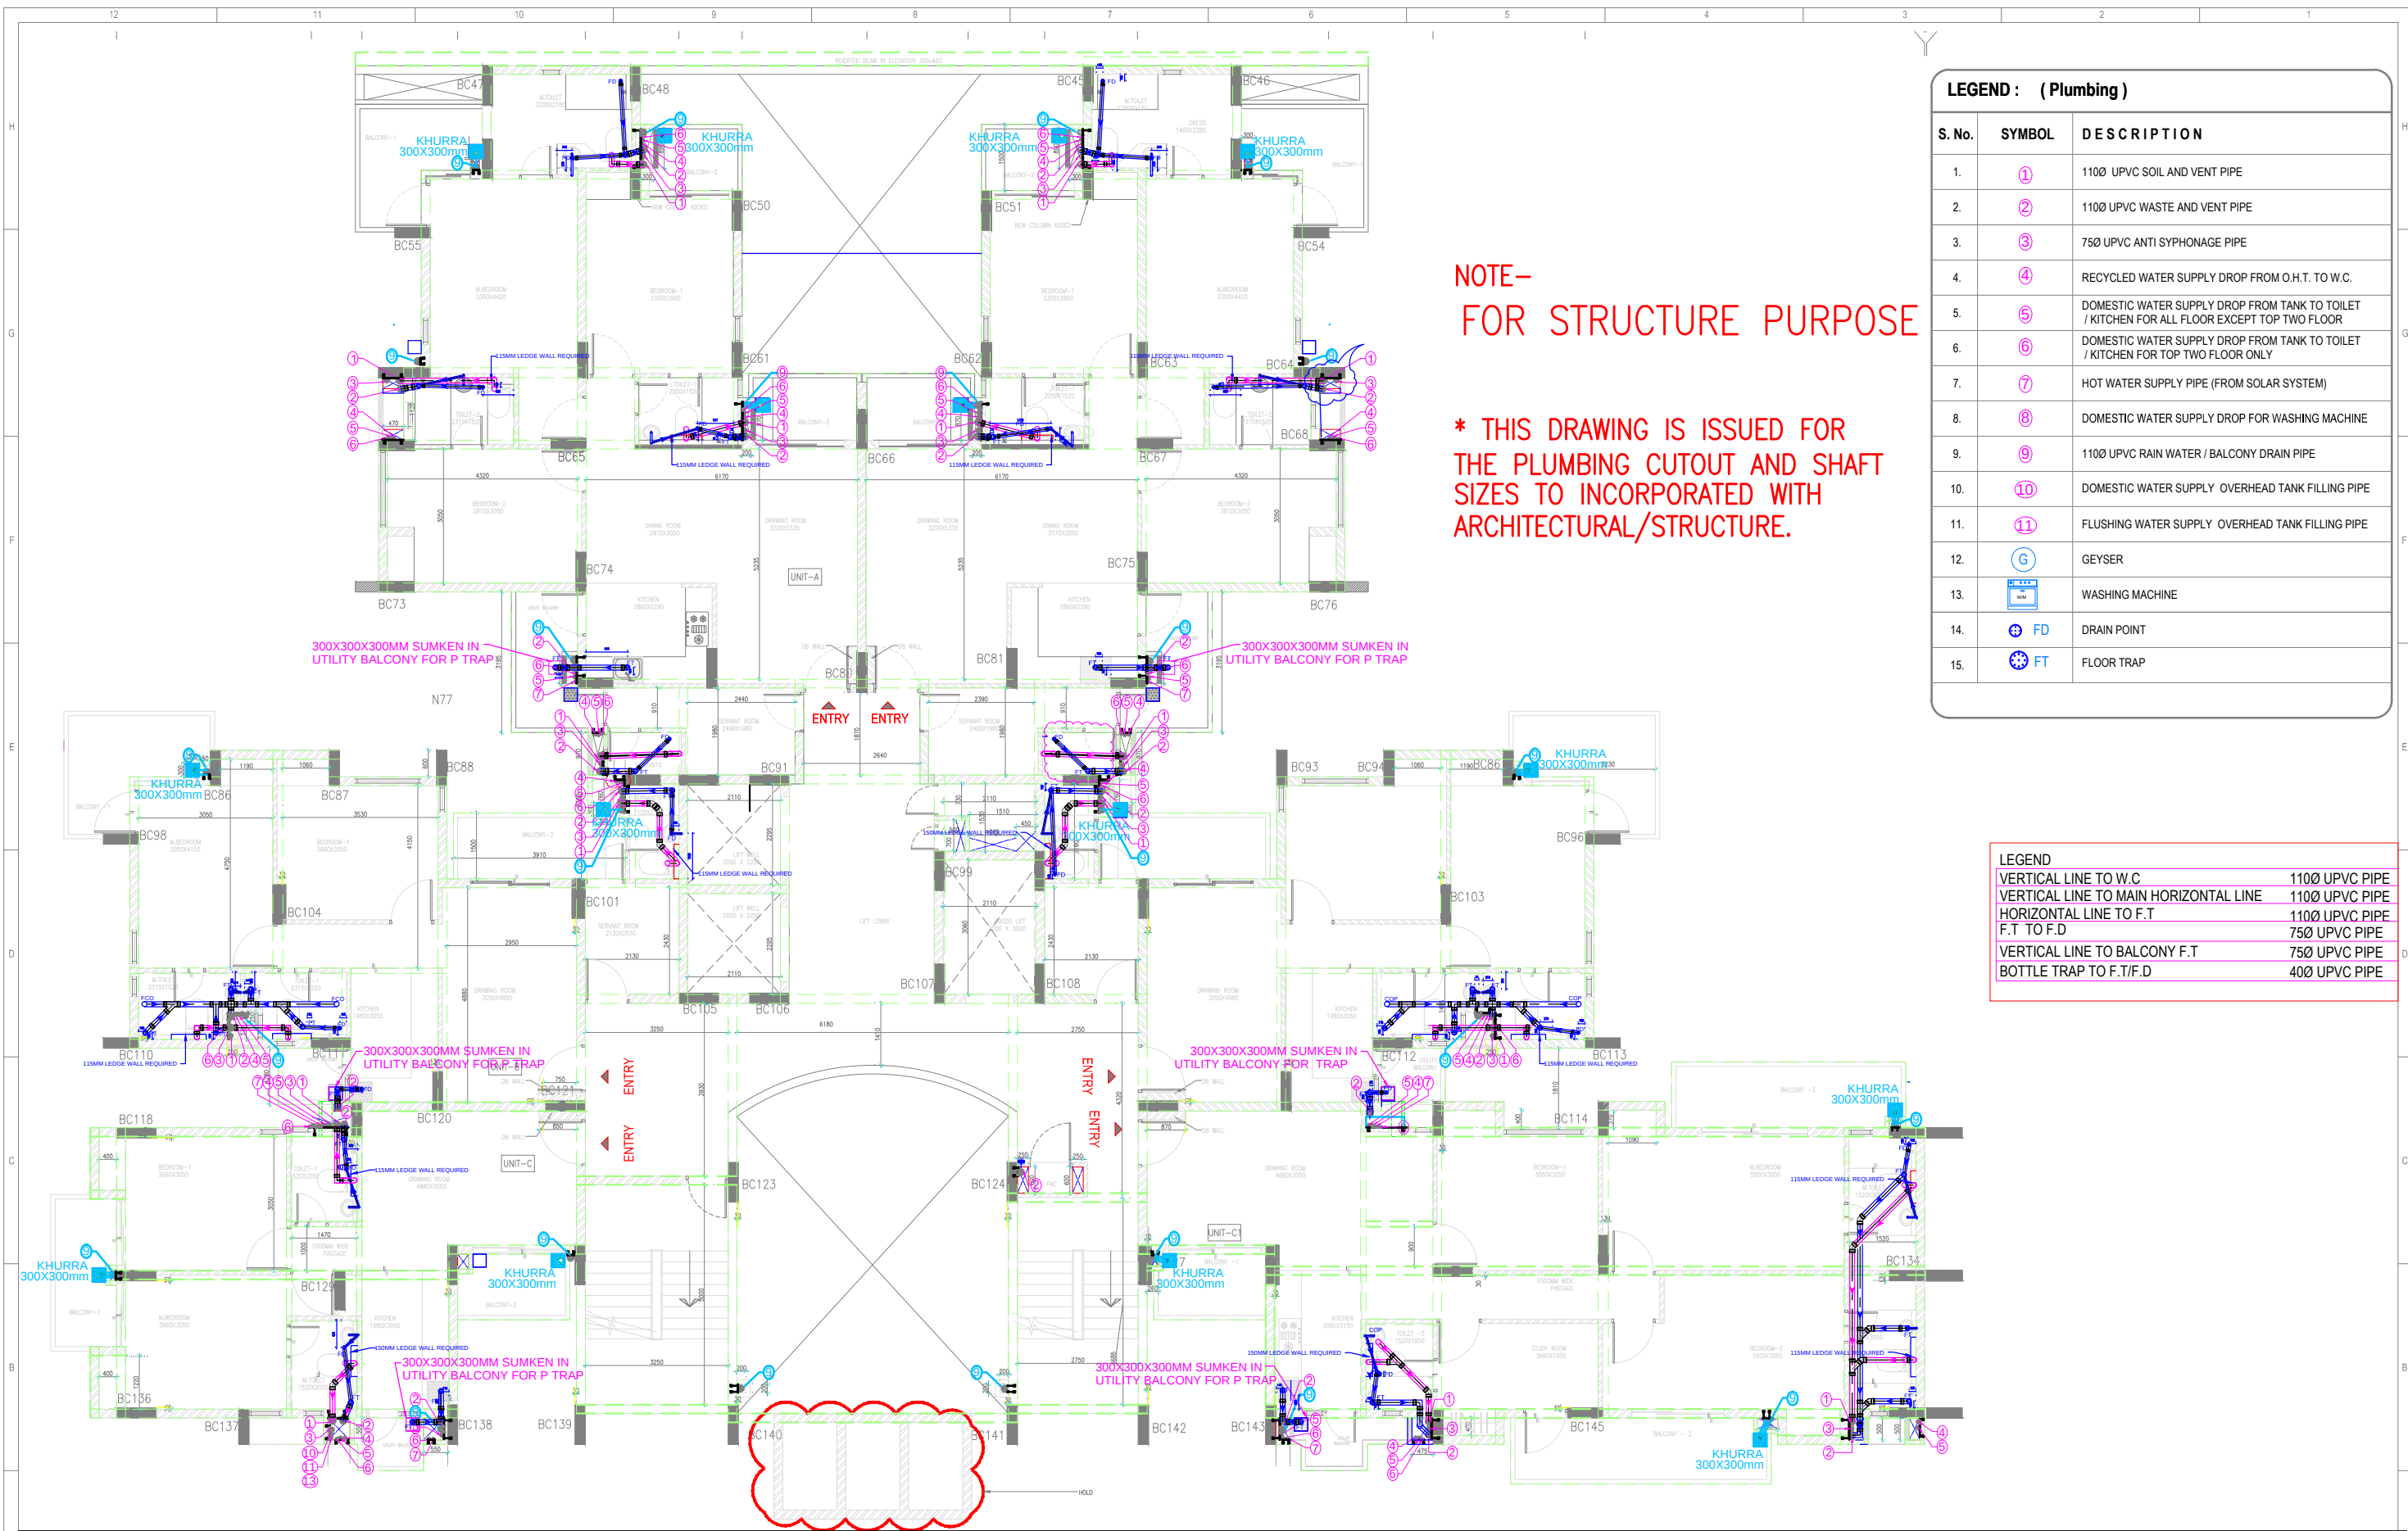

NOTE-
FOR STRUCTURE PURPOSE

* THIS DRAWING IS ISSUED FOR
THE PLUMBING CUTOUT AND SHAFT
SIZES TO INCORPORATED WITH
ARCHITECTURAL/STRUCTURE.

LEGEND : (Plumbing)		
S. No.	SYMBOL	DESCRIPTION
1.	①	110Ø UPVC SOIL AND VENT PIPE
2.	②	110Ø UPVC WASTE AND VENT PIPE
3.	③	75Ø UPVC ANTI SYPHONAGE PIPE
4.	④	RECYCLED WATER SUPPLY DROP FROM O.H.T. TO W.C.
5.	⑤	DOMESTIC WATER SUPPLY DROP FROM TANK TO TOILET / KITCHEN FOR ALL FLOOR EXCEPT TOP TWO FLOOR
6.	⑥	DOMESTIC WATER SUPPLY DROP FROM TANK TO TOILET / KITCHEN FOR TOP TWO FLOOR ONLY
7.	⑦	HOT WATER SUPPLY PIPE (FROM SOLAR SYSTEM)
8.	⑧	DOMESTIC WATER SUPPLY DROP FOR WASHING MACHINE
9.	⑨	110Ø UPVC RAIN WATER / BALCONY DRAIN PIPE
10.	⑩	DOMESTIC WATER SUPPLY OVERHEAD TANK FILLING PIPE
11.	⑪	FLUSHING WATER SUPPLY OVERHEAD TANK FILLING PIPE
12.	ⓖ	GEYSER
13.	Ⓢ	WASHING MACHINE
14.	Ⓜ	DRAIN POINT
15.	Ⓜ	FLOOR TRAP

LEGEND	
VERTICAL LINE TO W.C	110Ø UPVC PIPE
VERTICAL LINE TO MAIN HORIZONTAL LINE	110Ø UPVC PIPE
HORIZONTAL LINE TO F.T	110Ø UPVC PIPE
F.T TO F.D	75Ø UPVC PIPE
VERTICAL LINE TO BALCONY F.T	75Ø UPVC PIPE
BOTTLE TRAP TO F.T/F.D	40Ø UPVC PIPE

project
PROPOSED GROUP HOUSING FOR
RATAN BUILDTECH PVT. LTD. AT LAND MEASURING
16854.57 SQ.MT. AT PLOT NO. GH-01D,
GREATER NOIDA WEST, U.P

title
PHE DETAIL LAYOUT
subtitle
3rd FLOOR PLAN (TOWER-B)

drawing released for
☐ APPROVAL
☐ ADVANCE COPY
☐ SUBMISSION
☒ CONSTRUCTION

drg. no.
ART/TB/PHE/3rd-02
scale
NTS
date
13.02.2017

drawn by
J.K
designed by
J.K
checked by
J.K

architects
3/83,vishnupuri Kanpur U.P-2008002
Tel: 0512-3095240 A-5C DDA MIG FLATS MAYA PURI
New Delhi-110029, India. Tel: 011-25497190
KA KHARE Associates
Architects, Planners, Designers

art consultants "MEP Consultation"
301-B, Una Apartment, 03-I.P. Extension, Delhi-92
Email - artconsultant@gmail.com
"P" - 011-45640983, 08826126663