


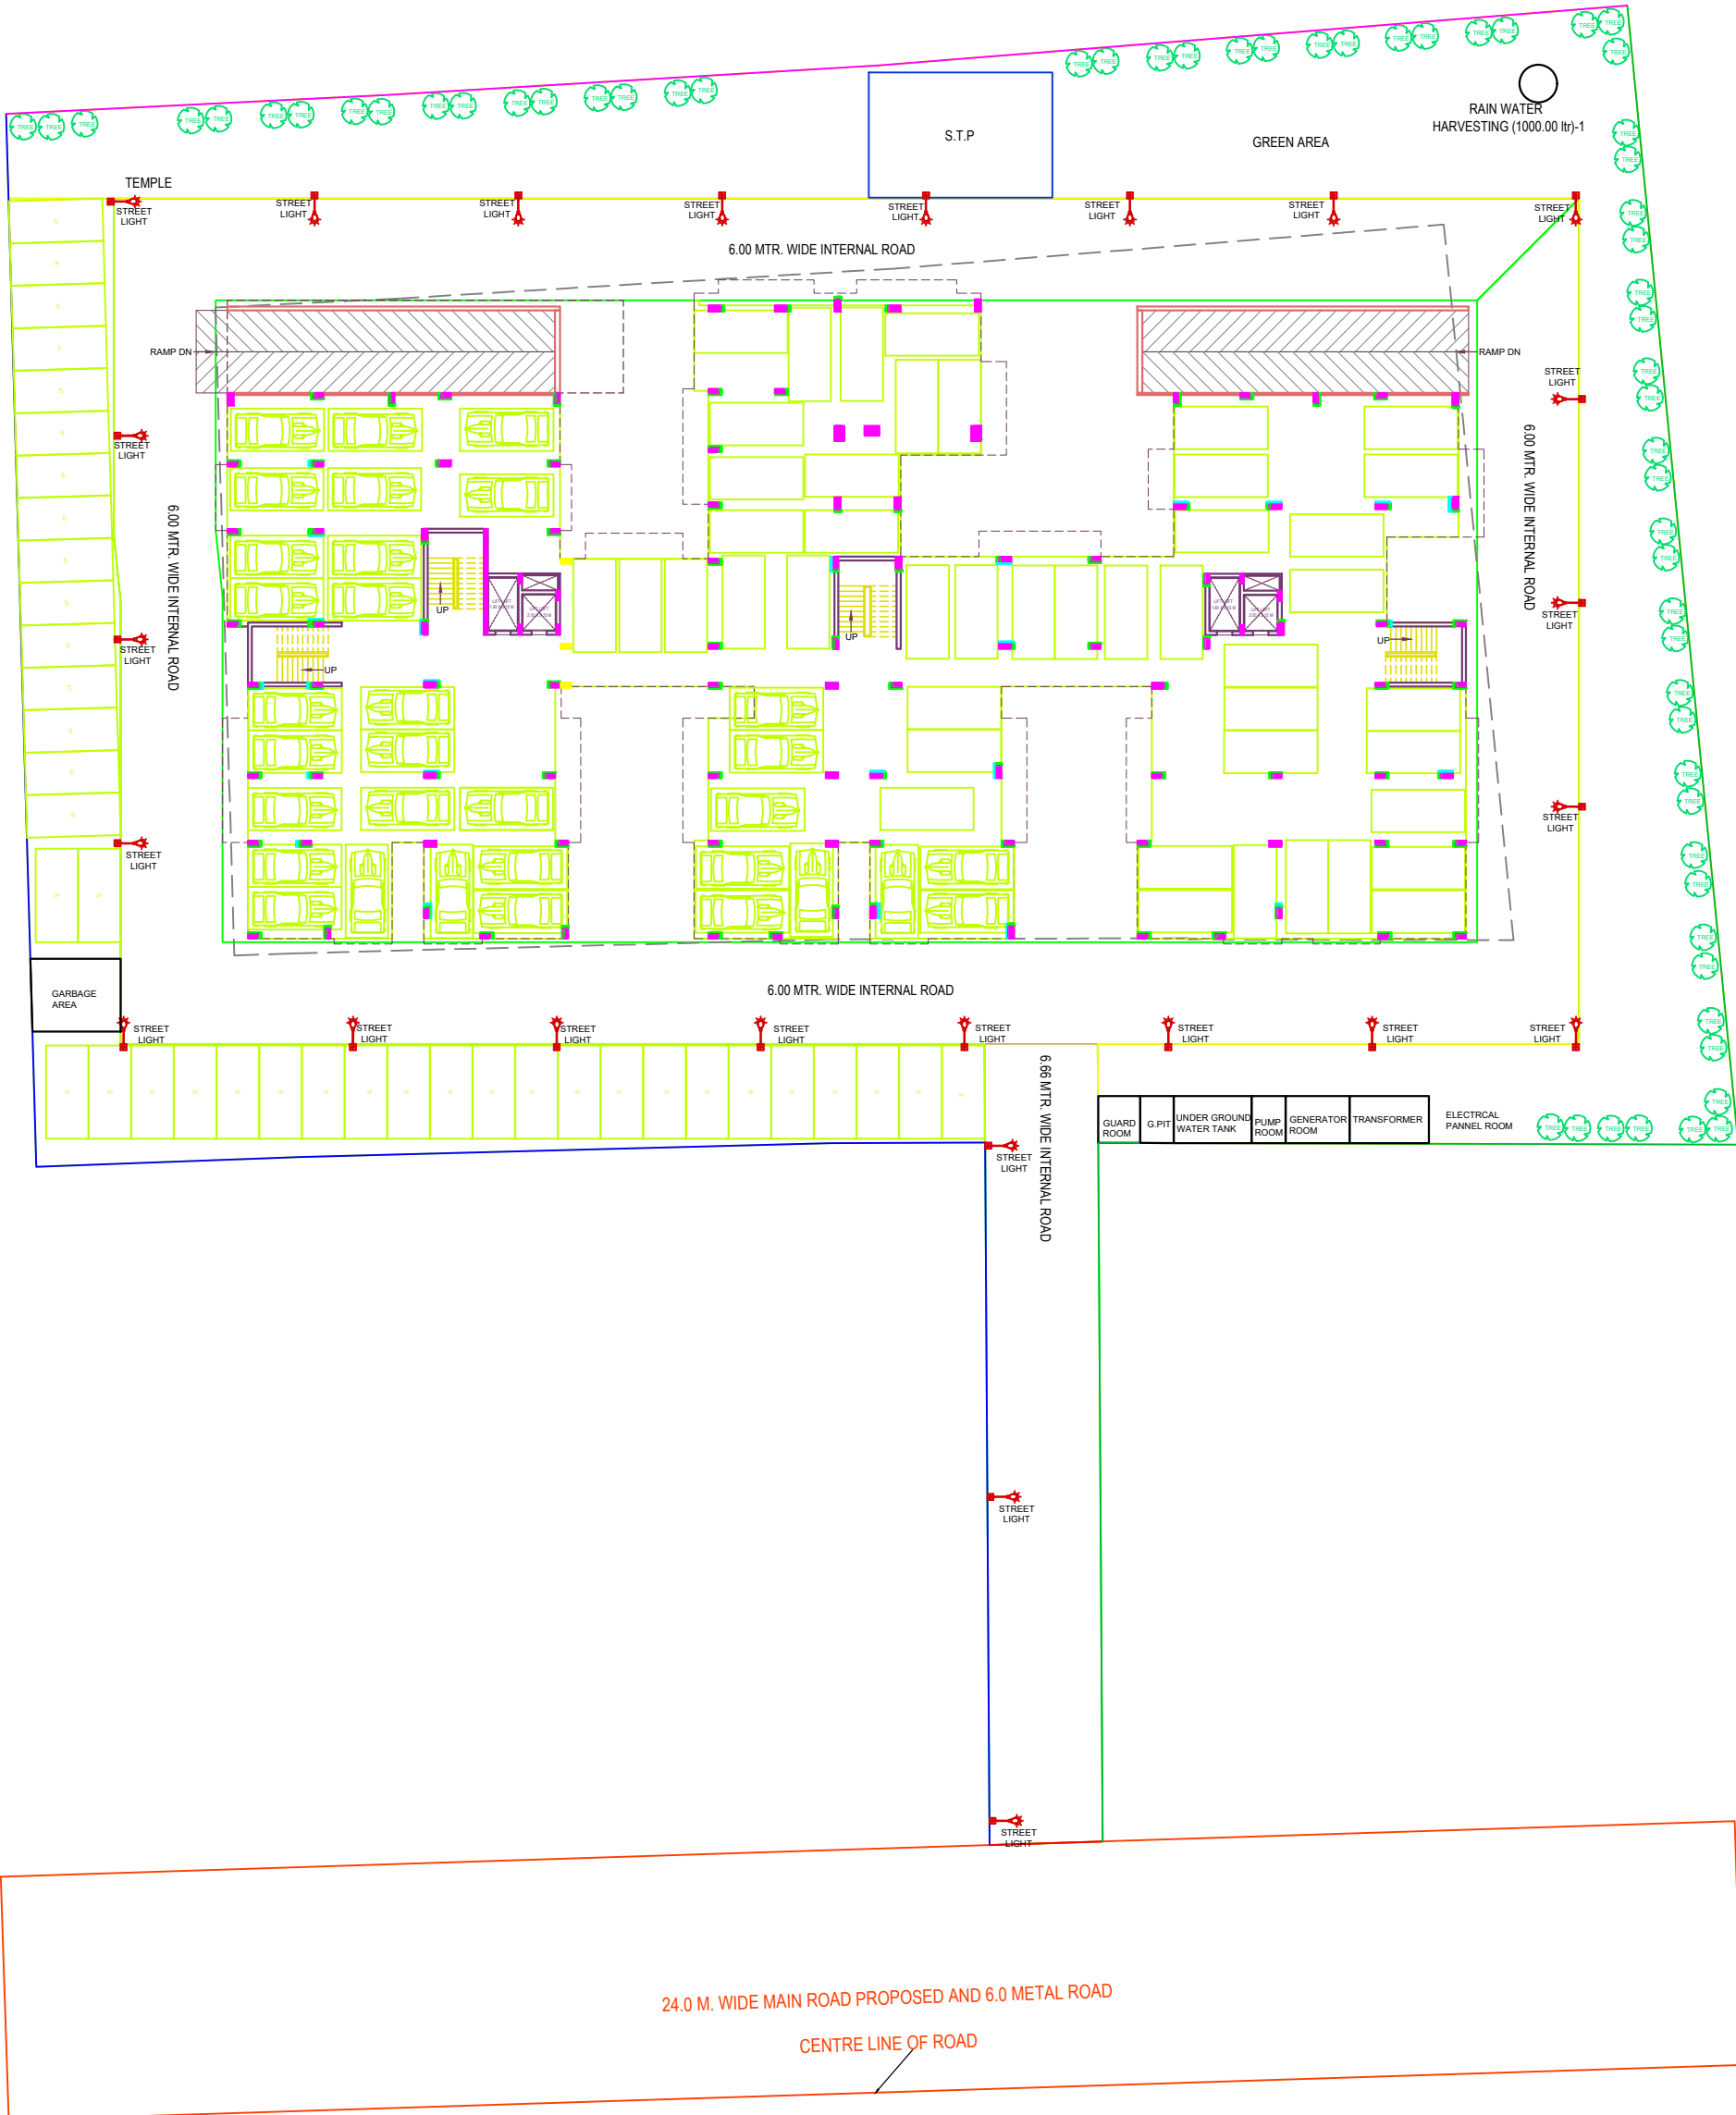

PROJECT

RAJENDRA PRASAD SINGH, SURENDRA NARAYAN SINGH, SHIV KUMAR SINGH, NISHA DEVI, DEEPAK SINGH, GIRISH KUMARI, PRAMOD KUMAR RAI, LOVKUSH SINGH, AWADH BUILDCON THROUGH DIRECTOR SUSHIL KUMAR RAI



DRAWING TITLE

SITE PLAN (ELECTRICAL)

DRAWING STATUS

DATE RIV 20-05-2025

SHEET NO. 01

DRAWN BY RAHUL


CHECKED BY

ARCHITECT AR. AJAY SINGH




DESIGN CENTRE
ESTABLISHED - 1995
MAKE IDEAS HAPPEN

ARCHITECTURE | PROJECT MANAGEMENT | INTERIORS | ENGINEER
WEB :- www.designcentreindia.in
E-MAIL :- ajaysingh@designcentreindia.in
S, 10/8-3K, P, Maqbool Alam Rd, Khajuri Colony, Varanasi - 221002
PHONE - 9628932134

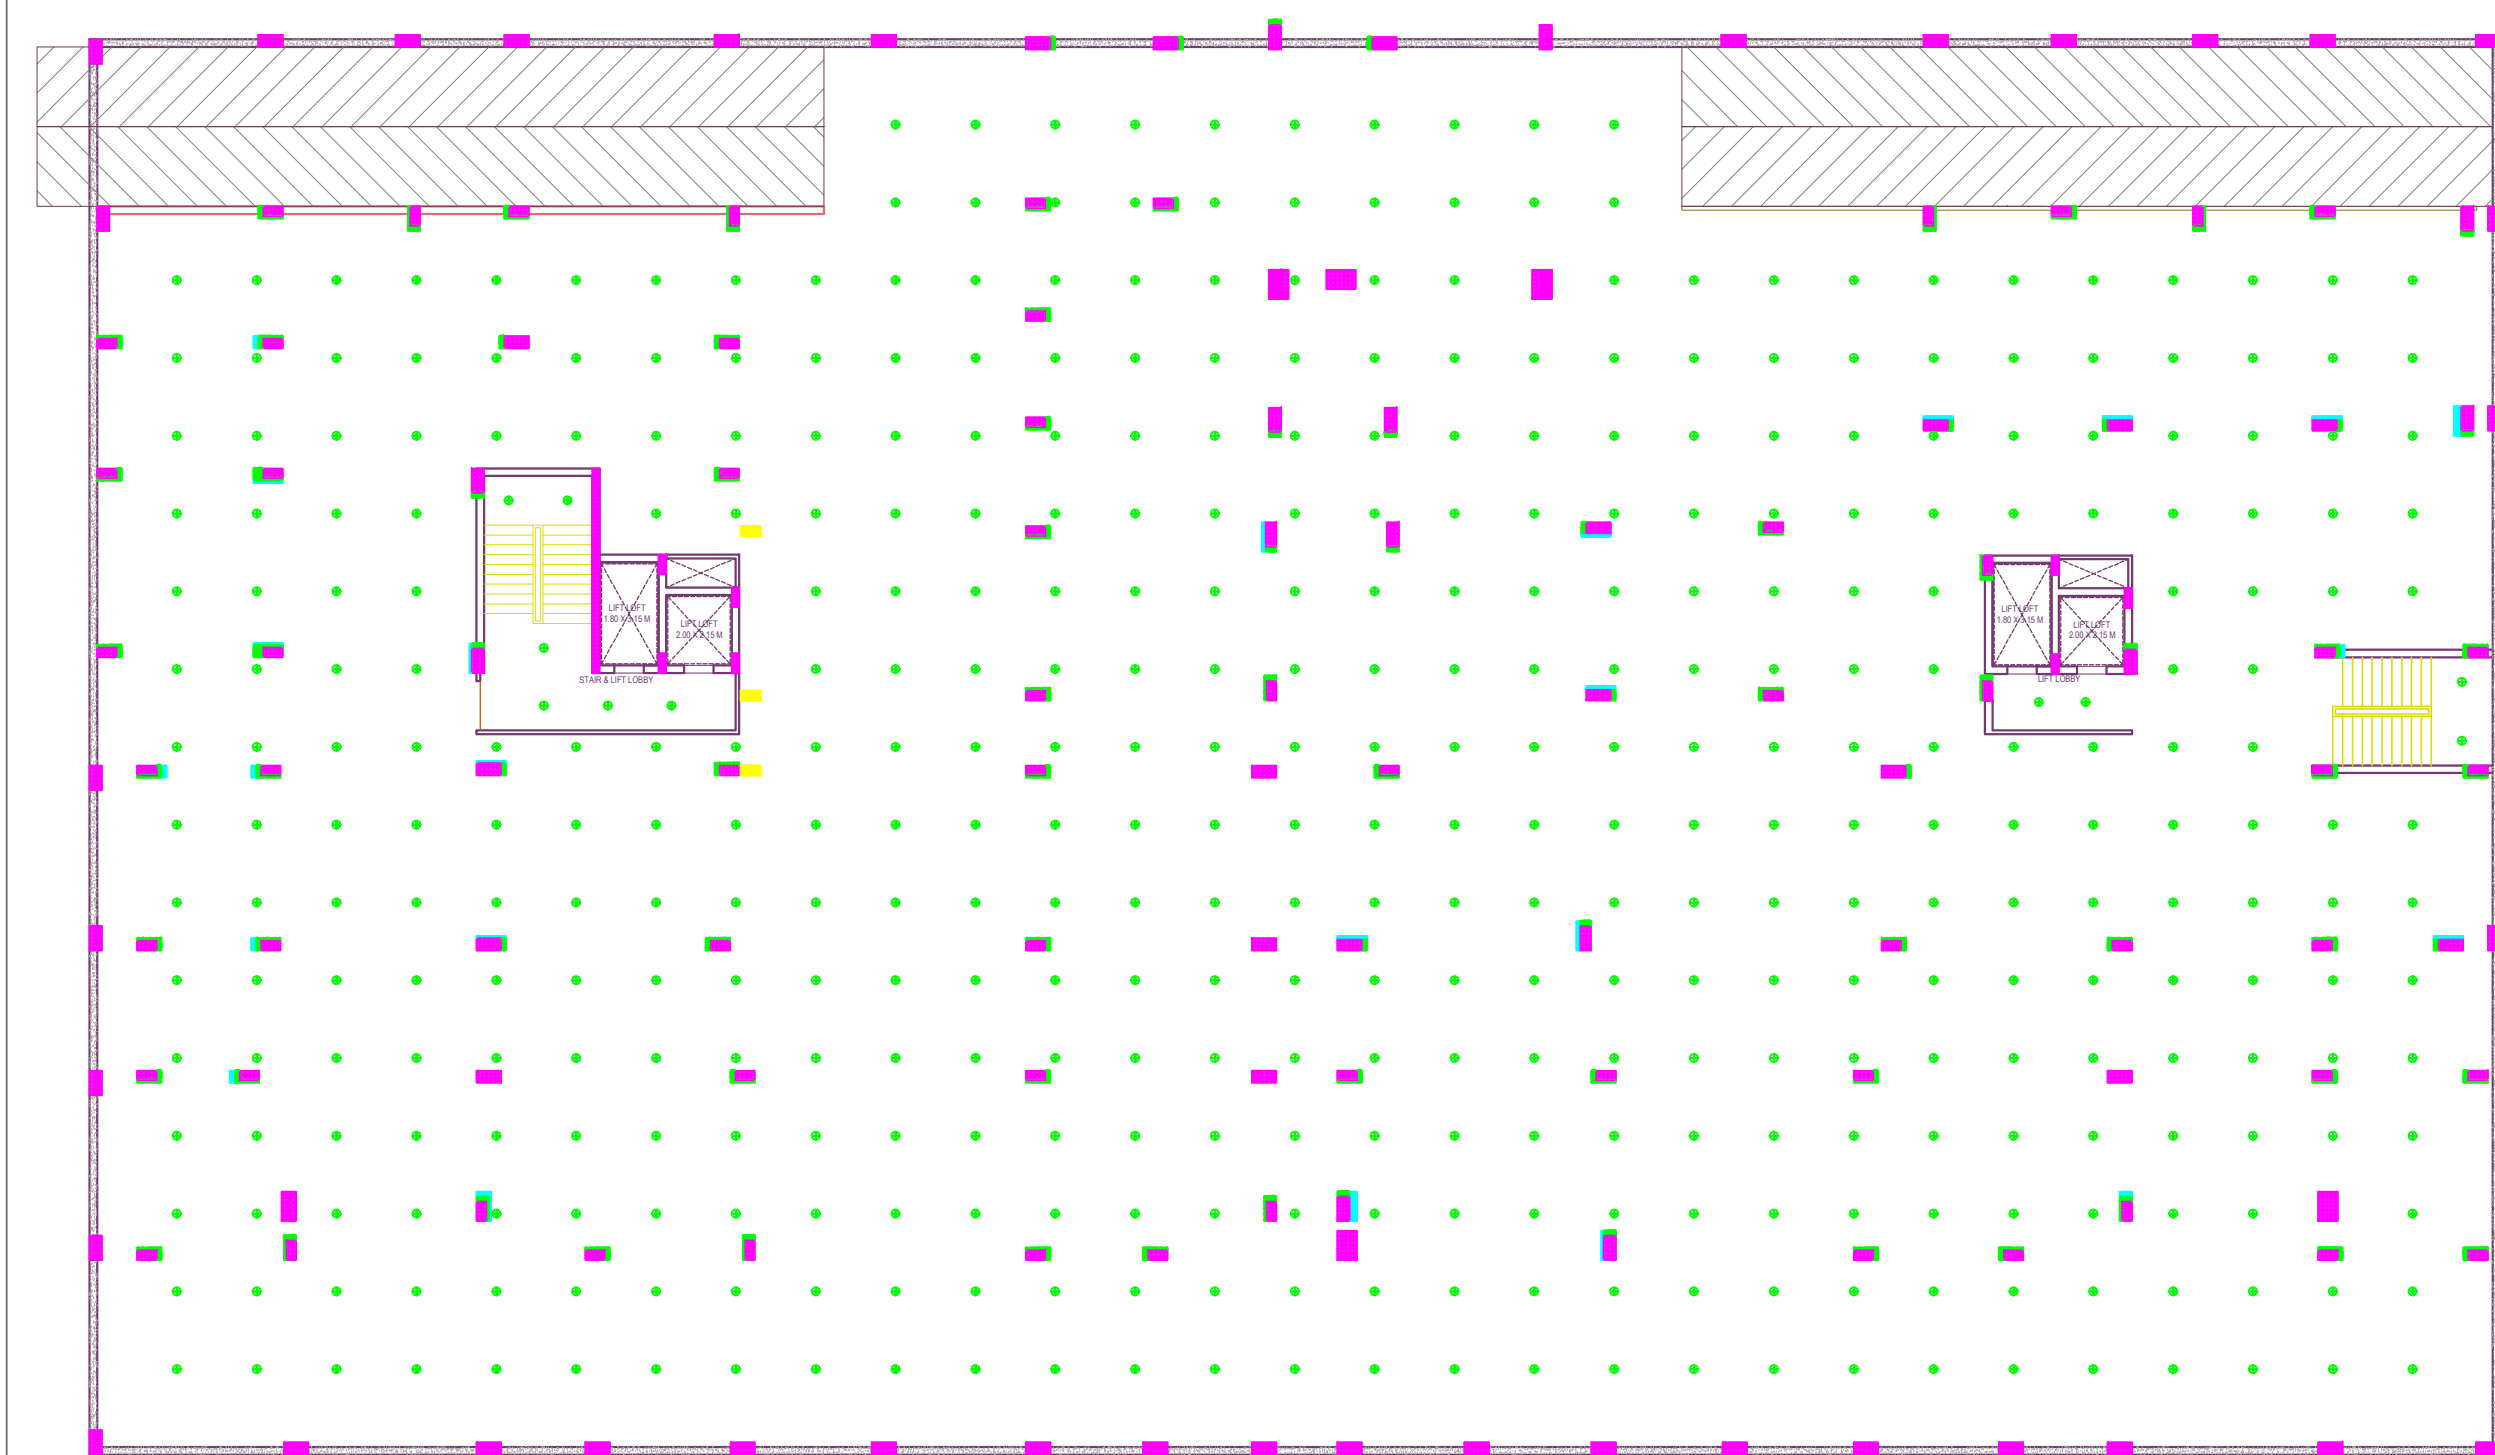

PROJECT RAJENDRA PRASAD SINGH, SURENDRA NARAYAN SINGH, SHIV KUMAR SINGH, NISHA DEVI, DEEPAK SINGH, GIRISH KUMARI, PRAMOD KUMAR RAI, LOVKUSH SINGH, AWADH BUILDCON THROUGH DIRECTOR SUSHIL KUMAR RAI		DRAWING TITLE BASEMENT FLOOR SLAB ELECTRICAL	DATE RIV 20-05-2025	ARCHITECT AR. AJAY SINGH	DESIGN CENTRE ESTABLISHED - 1996 MAKE IDEAS HAPPEN ARCHITECTURE PROJECT MANAGEMENT INTERIORS ENGINEER WEB :- www.designcentreind.in E-MAIL :- ajaysingh@designcentreind.in S, 10/8-3K, P, Maqbool Alam Rd, Khajuri Colony, Varanasi - 221002 PHONE - 9628932134
		DRAWING STATUS	SHEET NO. 01		
			DRAWN BY PRIYA BARANWAL	CHECKED BY	

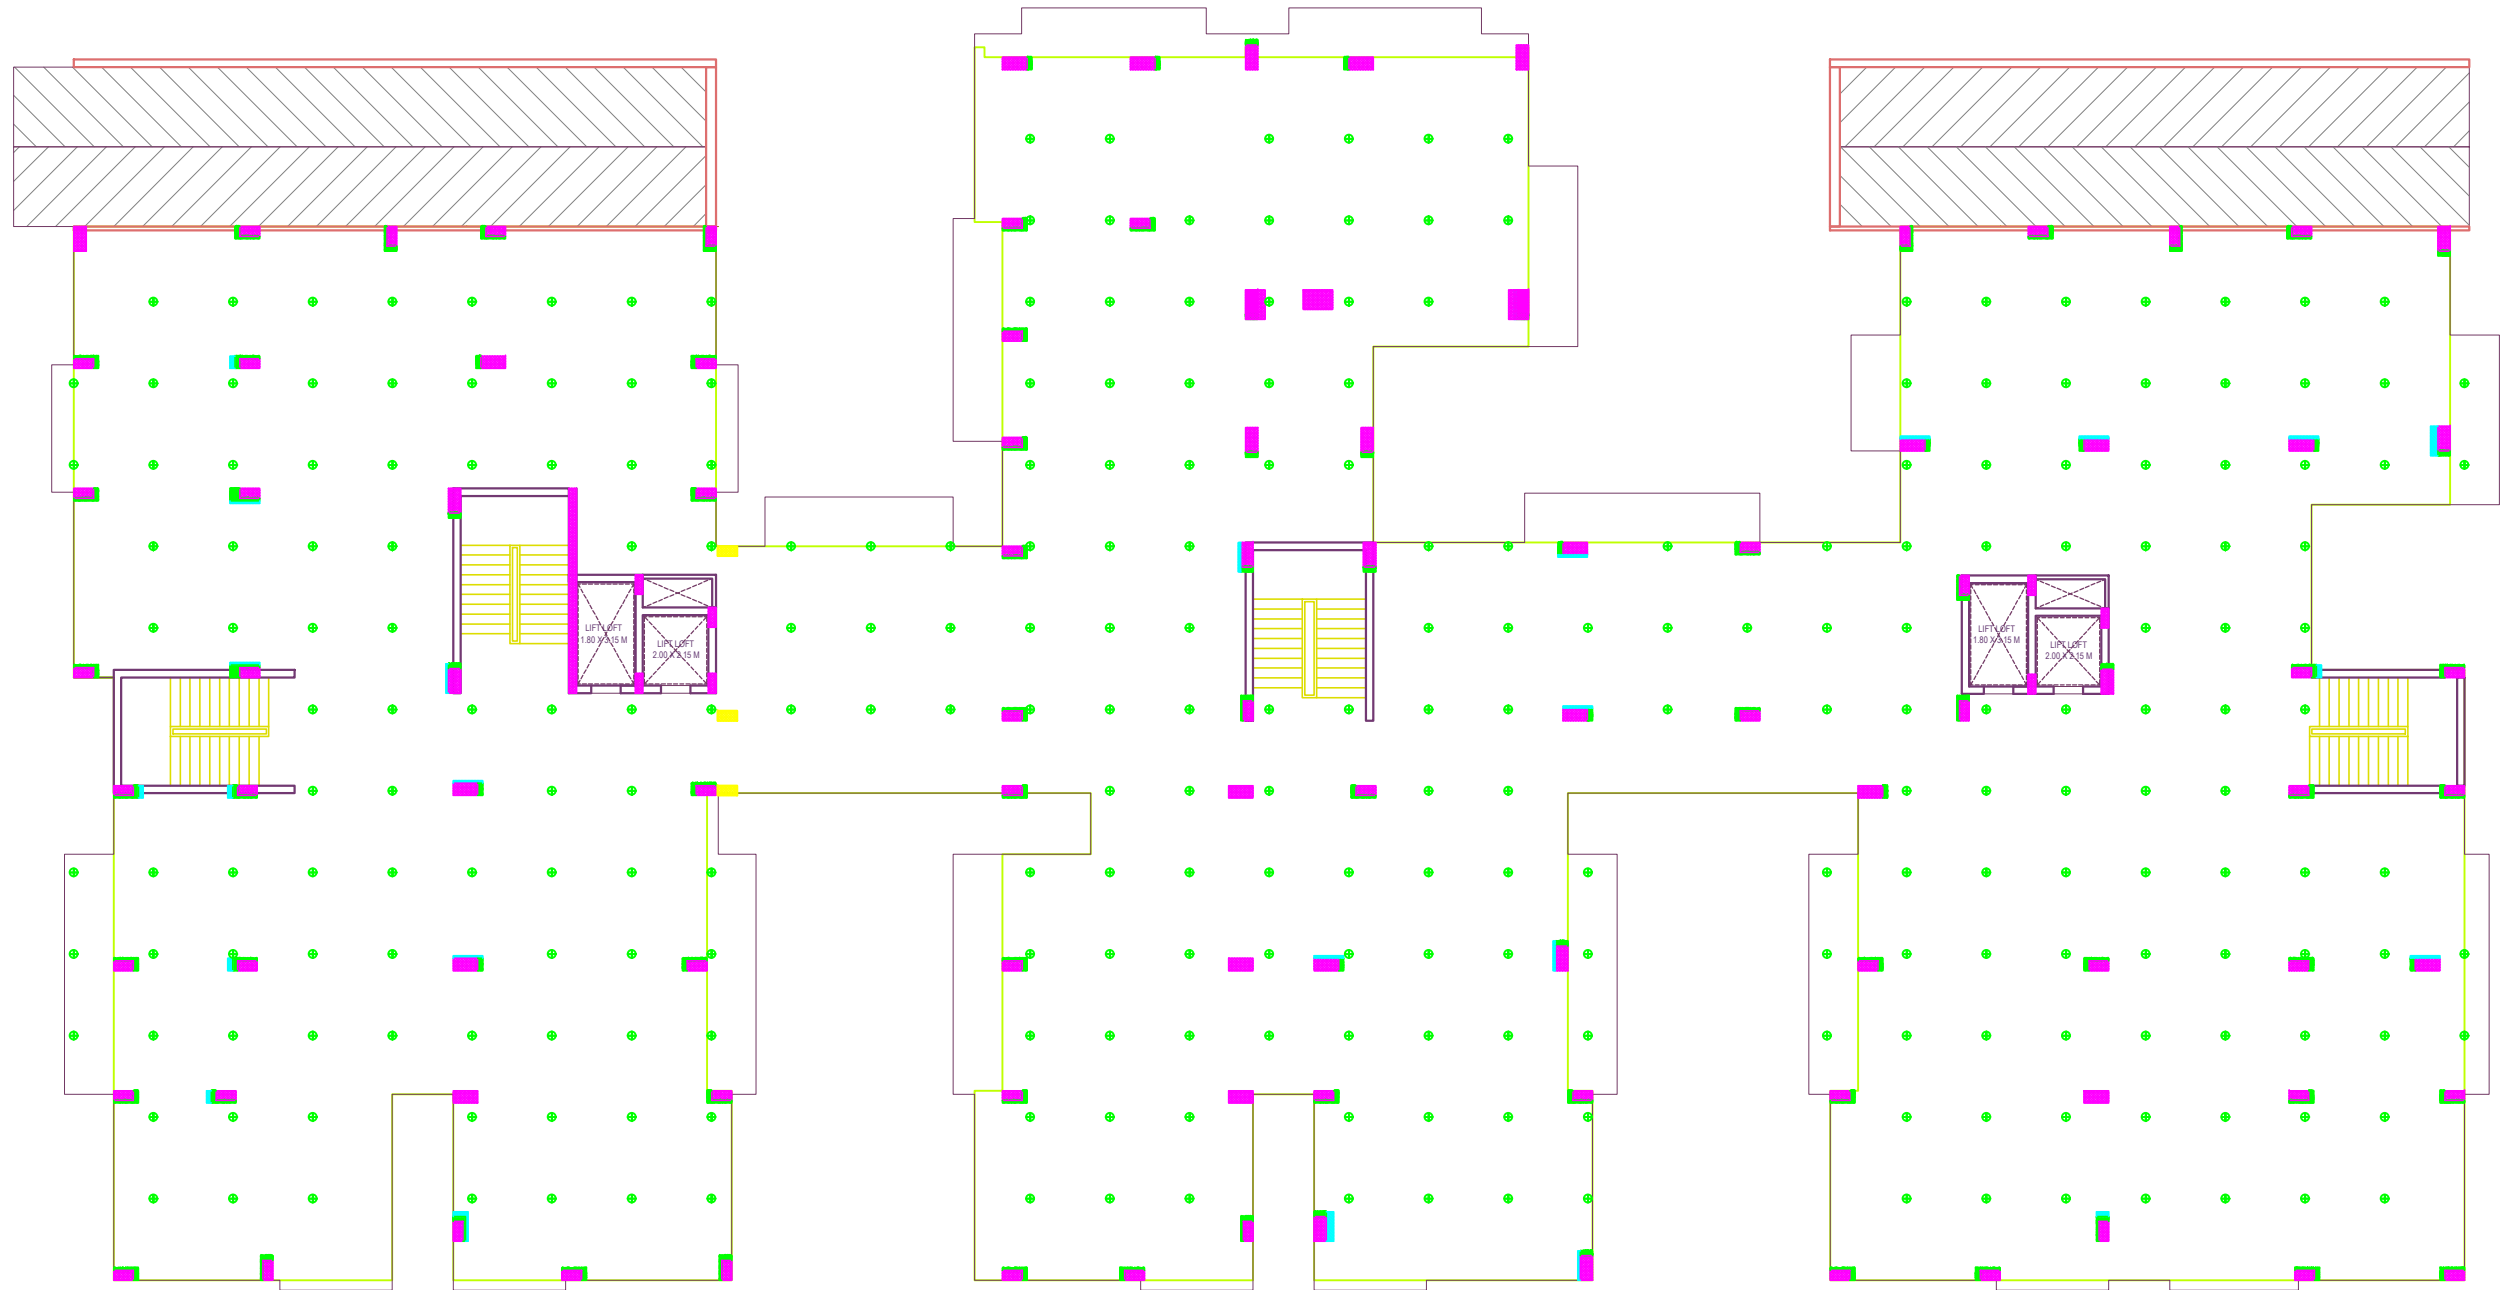

PROJECT

RAJENDRA PRASAD SINGH, SURENDRA NARAYAN SINGH,
SHIV KUMAR SINGH, NISHA DEVI, DEEPAK SINGH,
GIRISH KUMARI, PRAMOD KUMAR RAI,
LOVKUSH SINGH, AWADH BUILDCON THROUGH
DIRECTOR SUSHIL KUMAR RAI



DRAWING TITLE
STILT FLOOR
SLAB ELECTRICAL

DRAWING STATUS

DATE RIV 20-05-2025

SHEET NO. 01

DRAWN BY
PRIYA BARANWAL

CHECKED BY

ARCHITECT
AR. AJAY SINGH




DESIGN CENTRE
ESTABLISHED - 1996
MAKE IDEAS HAPPEN

ARCHITECTURE | PROJECT MANAGEMENT | INTERIORS | ENGINEER

WEB :- www.designcentreind.in

E-MAIL :- ajaysingh@designcentreind.in
S, 10/8-3K, P, Maqbool Alam Rd, Khajuri Colony,
Varanasi - 221002

PHONE - 9628932134

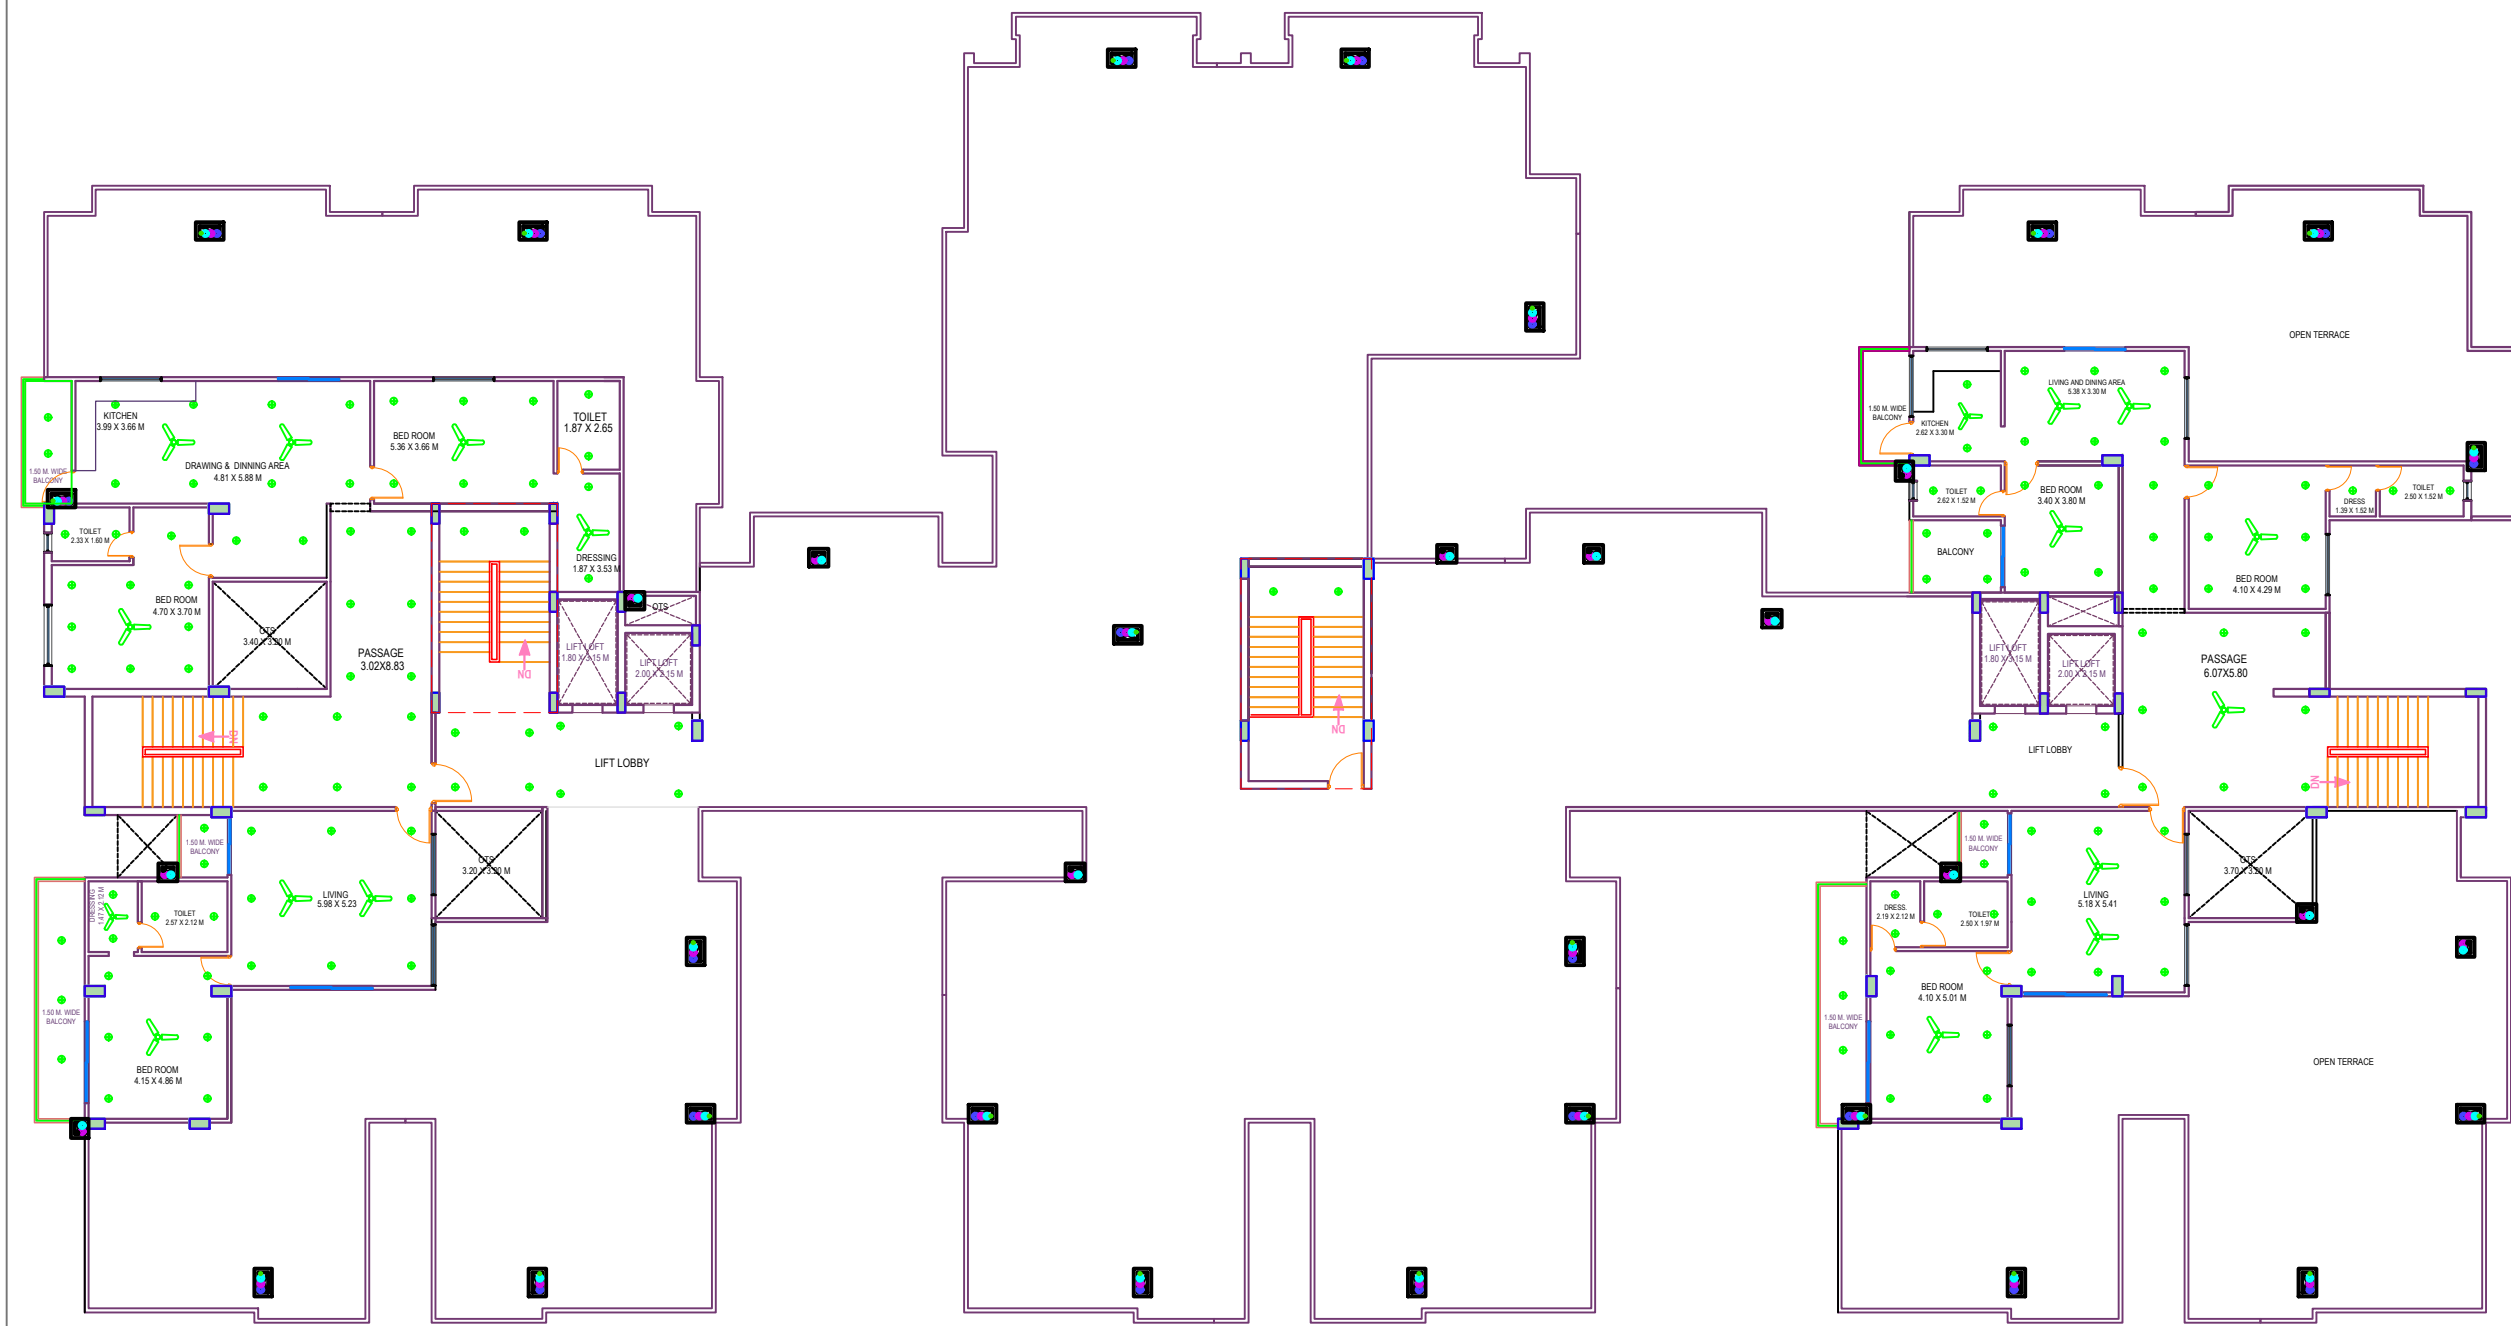

PROJECT		DRAWING TITLE	DATE RIV 21-05-2025		ARCHITECT AR. AJAY SINGH	 DESIGN CENTRE ESTABLISHED - 1995 MAKE IDEAS HAPPEN ARCHITECTURE PROJECT MANAGEMENT INTERIORS ENGINEER WEB :- www.designcentreind.in E-MAIL :- ajaysingh@designcentreind.in S, 10/8-3K, P, Maqbool Alam Rd, Khajuri Colony, Varanasi - 221002 PHONE - 9628932134
		TERRACE FLOOR SLAB ELECTRICAL	SHEET NO. 01			
		DRAWING STATUS	DRAWN BY PRIYA BARANWAL	CHECKED BY		