



APPROVAL OF G.D.A.:

गोरखपुर विकास प्राधिकरण
गोरखपुर
मानचित्र नं. 124/2024
दिनांक 22-4-2025 से दिनांक.....
स्वीकृत
1-मानचित्र इस स्तं के साथ स्वीकृत किया जाता है कि प्रत्येक निर्माण कर्ता अपने आवारा के आगे या आवाराय परिसर में 2 वृक्षों का आरोपण अवश्य करेगा।
2-मानचित्र की स्वीकृति से किसी के स्वामित्व पर कोई प्रतिबन्ध प्रभाव नहीं होगा।

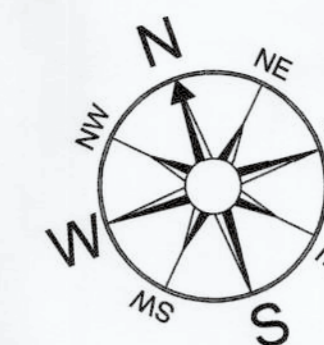


PROPOSED LAYOUT "GALLANT ANANDAM" AT MAUZA- BARGDWA, VILLAGE- BARGDWA, POST- FERTILIZER TOWN, DISTRICT- GORAKHPUR, ARAZI NUMBER-142 MI, 147, 148, 149 MI, 150, 151, 152 FOR GALLANT ISPAT LIMITED (SHRI CHANDRA PRAKASH AGARWAL AND ERSTWHILE M/S GOVIND MILLS LIMITED)

AREA DETAIL	SQ.FT.	SQ.MT.
TOTAL PLOT AREA AS PER Ownership	119464.00	11102.60
TOTAL PLOT AREA AS PER SITE	116159.76	10795.51
		100%
PARK AREA	17438.10	1620.64
ROAD AREA	29916.17	2780.31
		25.75%
PLOT AREA	68805.49	6394.56
		59.25%

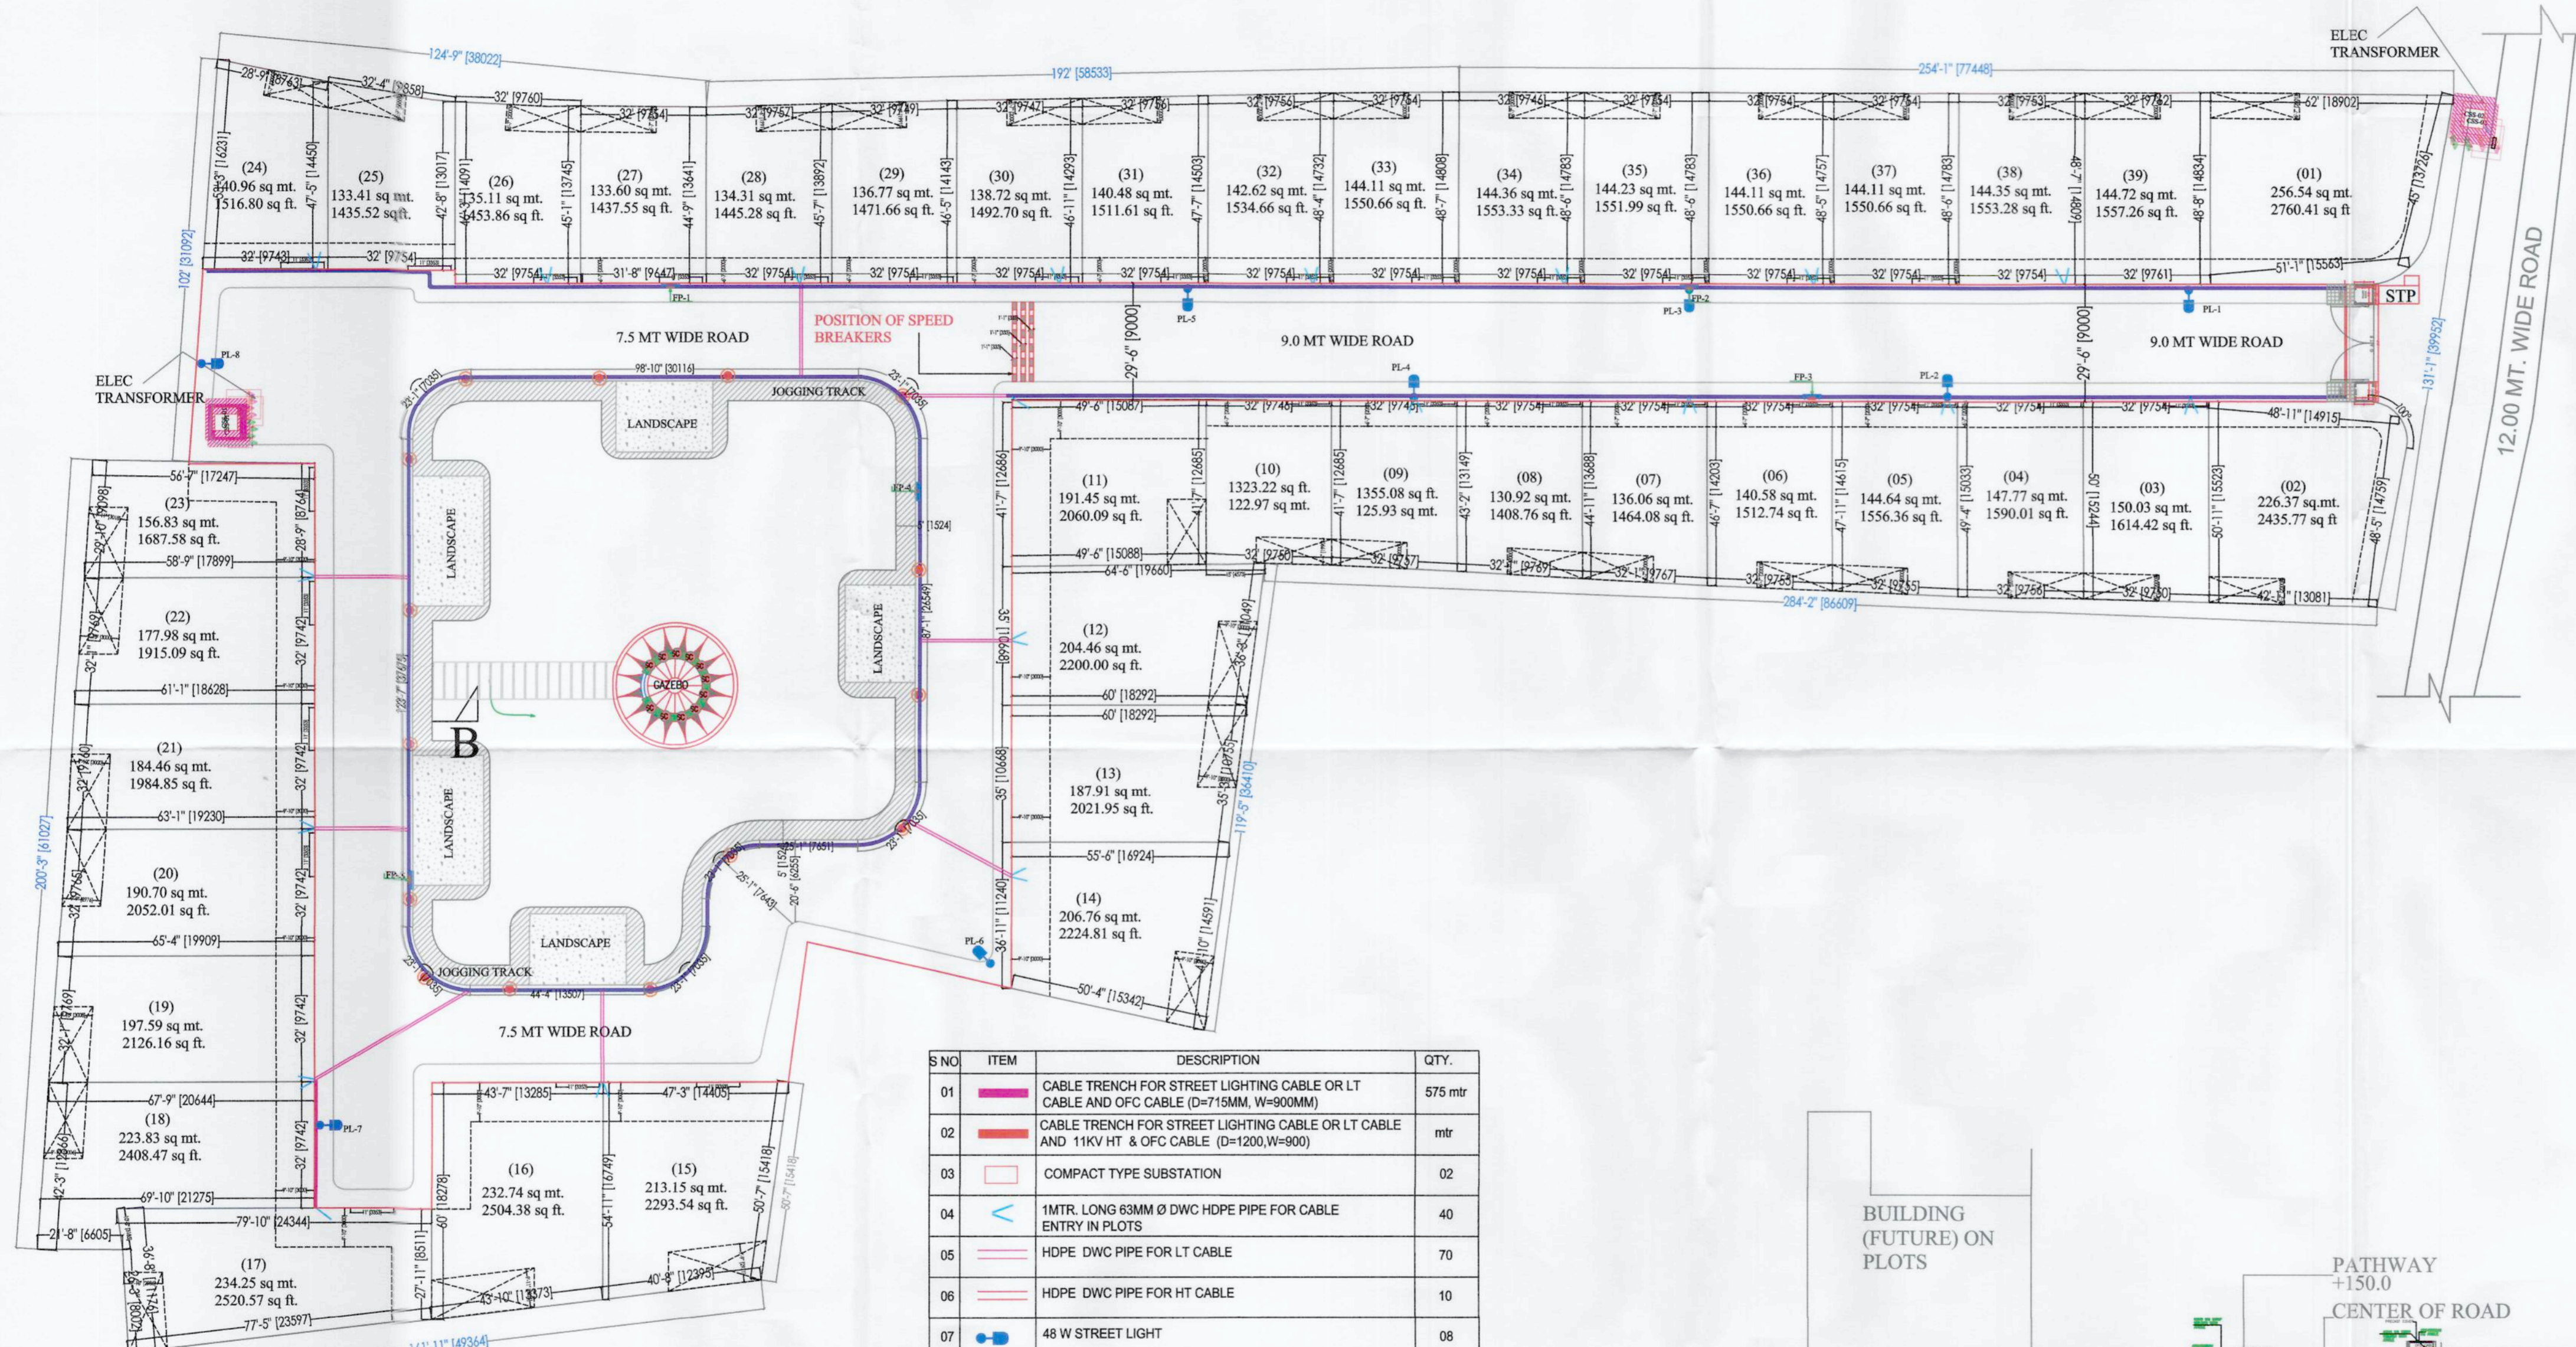

LAYOUT MAP
Scale: 1"=8'-0"

S NO	ITEM	DESCRIPTION	QTY.
01		CABLE TRENCH FOR STREET LIGHTING CABLE OR LT CABLE AND OFC CABLE (D=715MM, W=900MM)	575 mtr
02		CABLE TRENCH FOR STREET LIGHTING CABLE OR LT CABLE AND 11KV HT & OFC CABLE (D=1200, W=900)	mtr
03		COMPACT TYPE SUBSTATION	02
04		1MTR. LONG 63MM Ø DWC HDPE PIPE FOR CABLE ENTRY IN PLOTS	40
05		HDPE DWC PIPE FOR LT CABLE	70
06		HDPE DWC PIPE FOR HT CABLE	10
07		48 W STREET LIGHT	08
08		48 W BOLLARD POLE LIGHT	15
09		FEEDER PILLER	

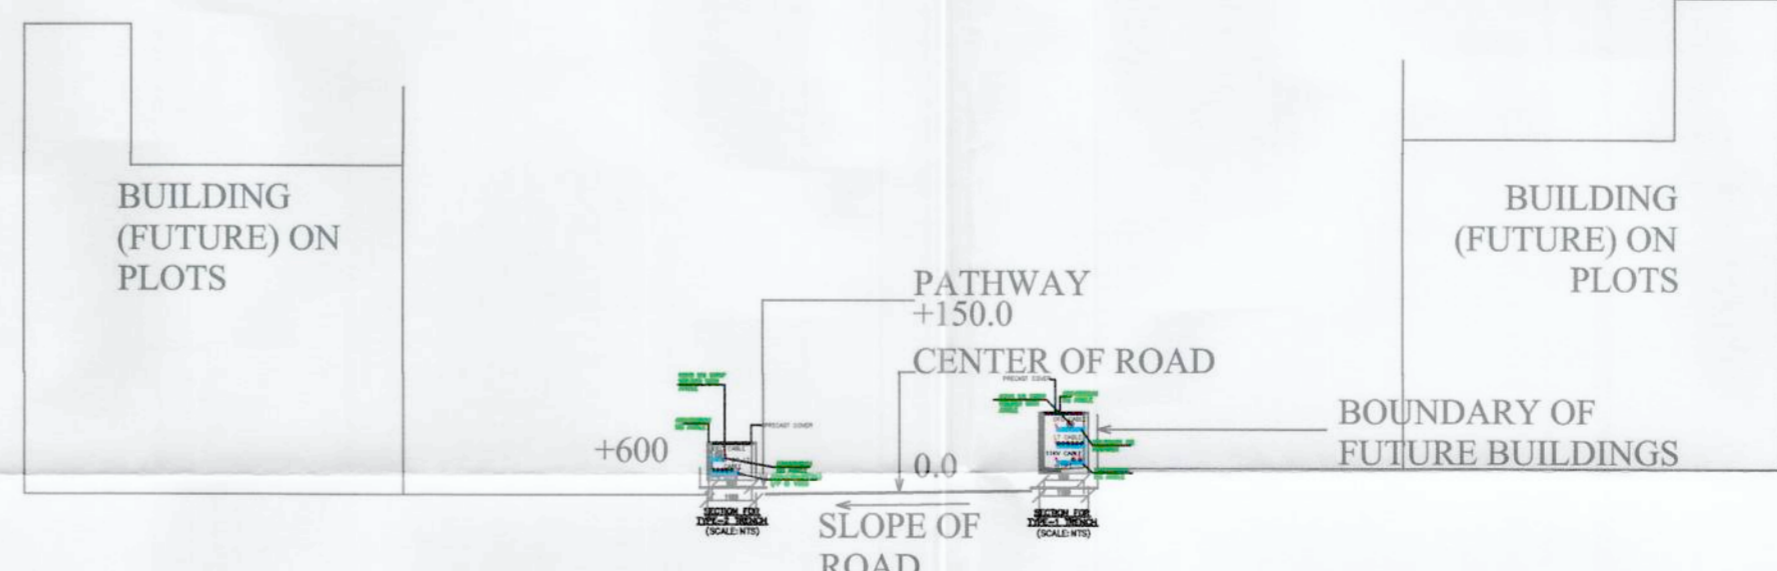

ELECTRICAL PLAN SHOWING STREET LIGHT, PARK LIGHTING SCHEME, TRANSFORMER,

Sheet number- 04

DWN BY: SCALE: CKD BY: ashish

OWNER SIGN:
ACORE ARCHITECTURAL SERVICES PVT. LTD
ARCHITECT:ASHISH SRIVASTAVA (B.ARCH) ASHISH SRIVASTAVA (B.ARCH) A.I.A.
BRANCH OFFICE : 935/D MTRI ANCHAL NEAR HITECT GORAKHNATH RAILWAY CROSSING GORAKHPUR CA/57/21013

TEL: OFF:3294813,RESI:2255290, MOBILE:9415321836.