


This drawing is a "COPYRIGHT"
contents of this drawing or
part thereof may not be used
or reproduced without the
permission of the Architect


OWNER SIGN

ARCHITECT SIGN

TOWN PLANNER

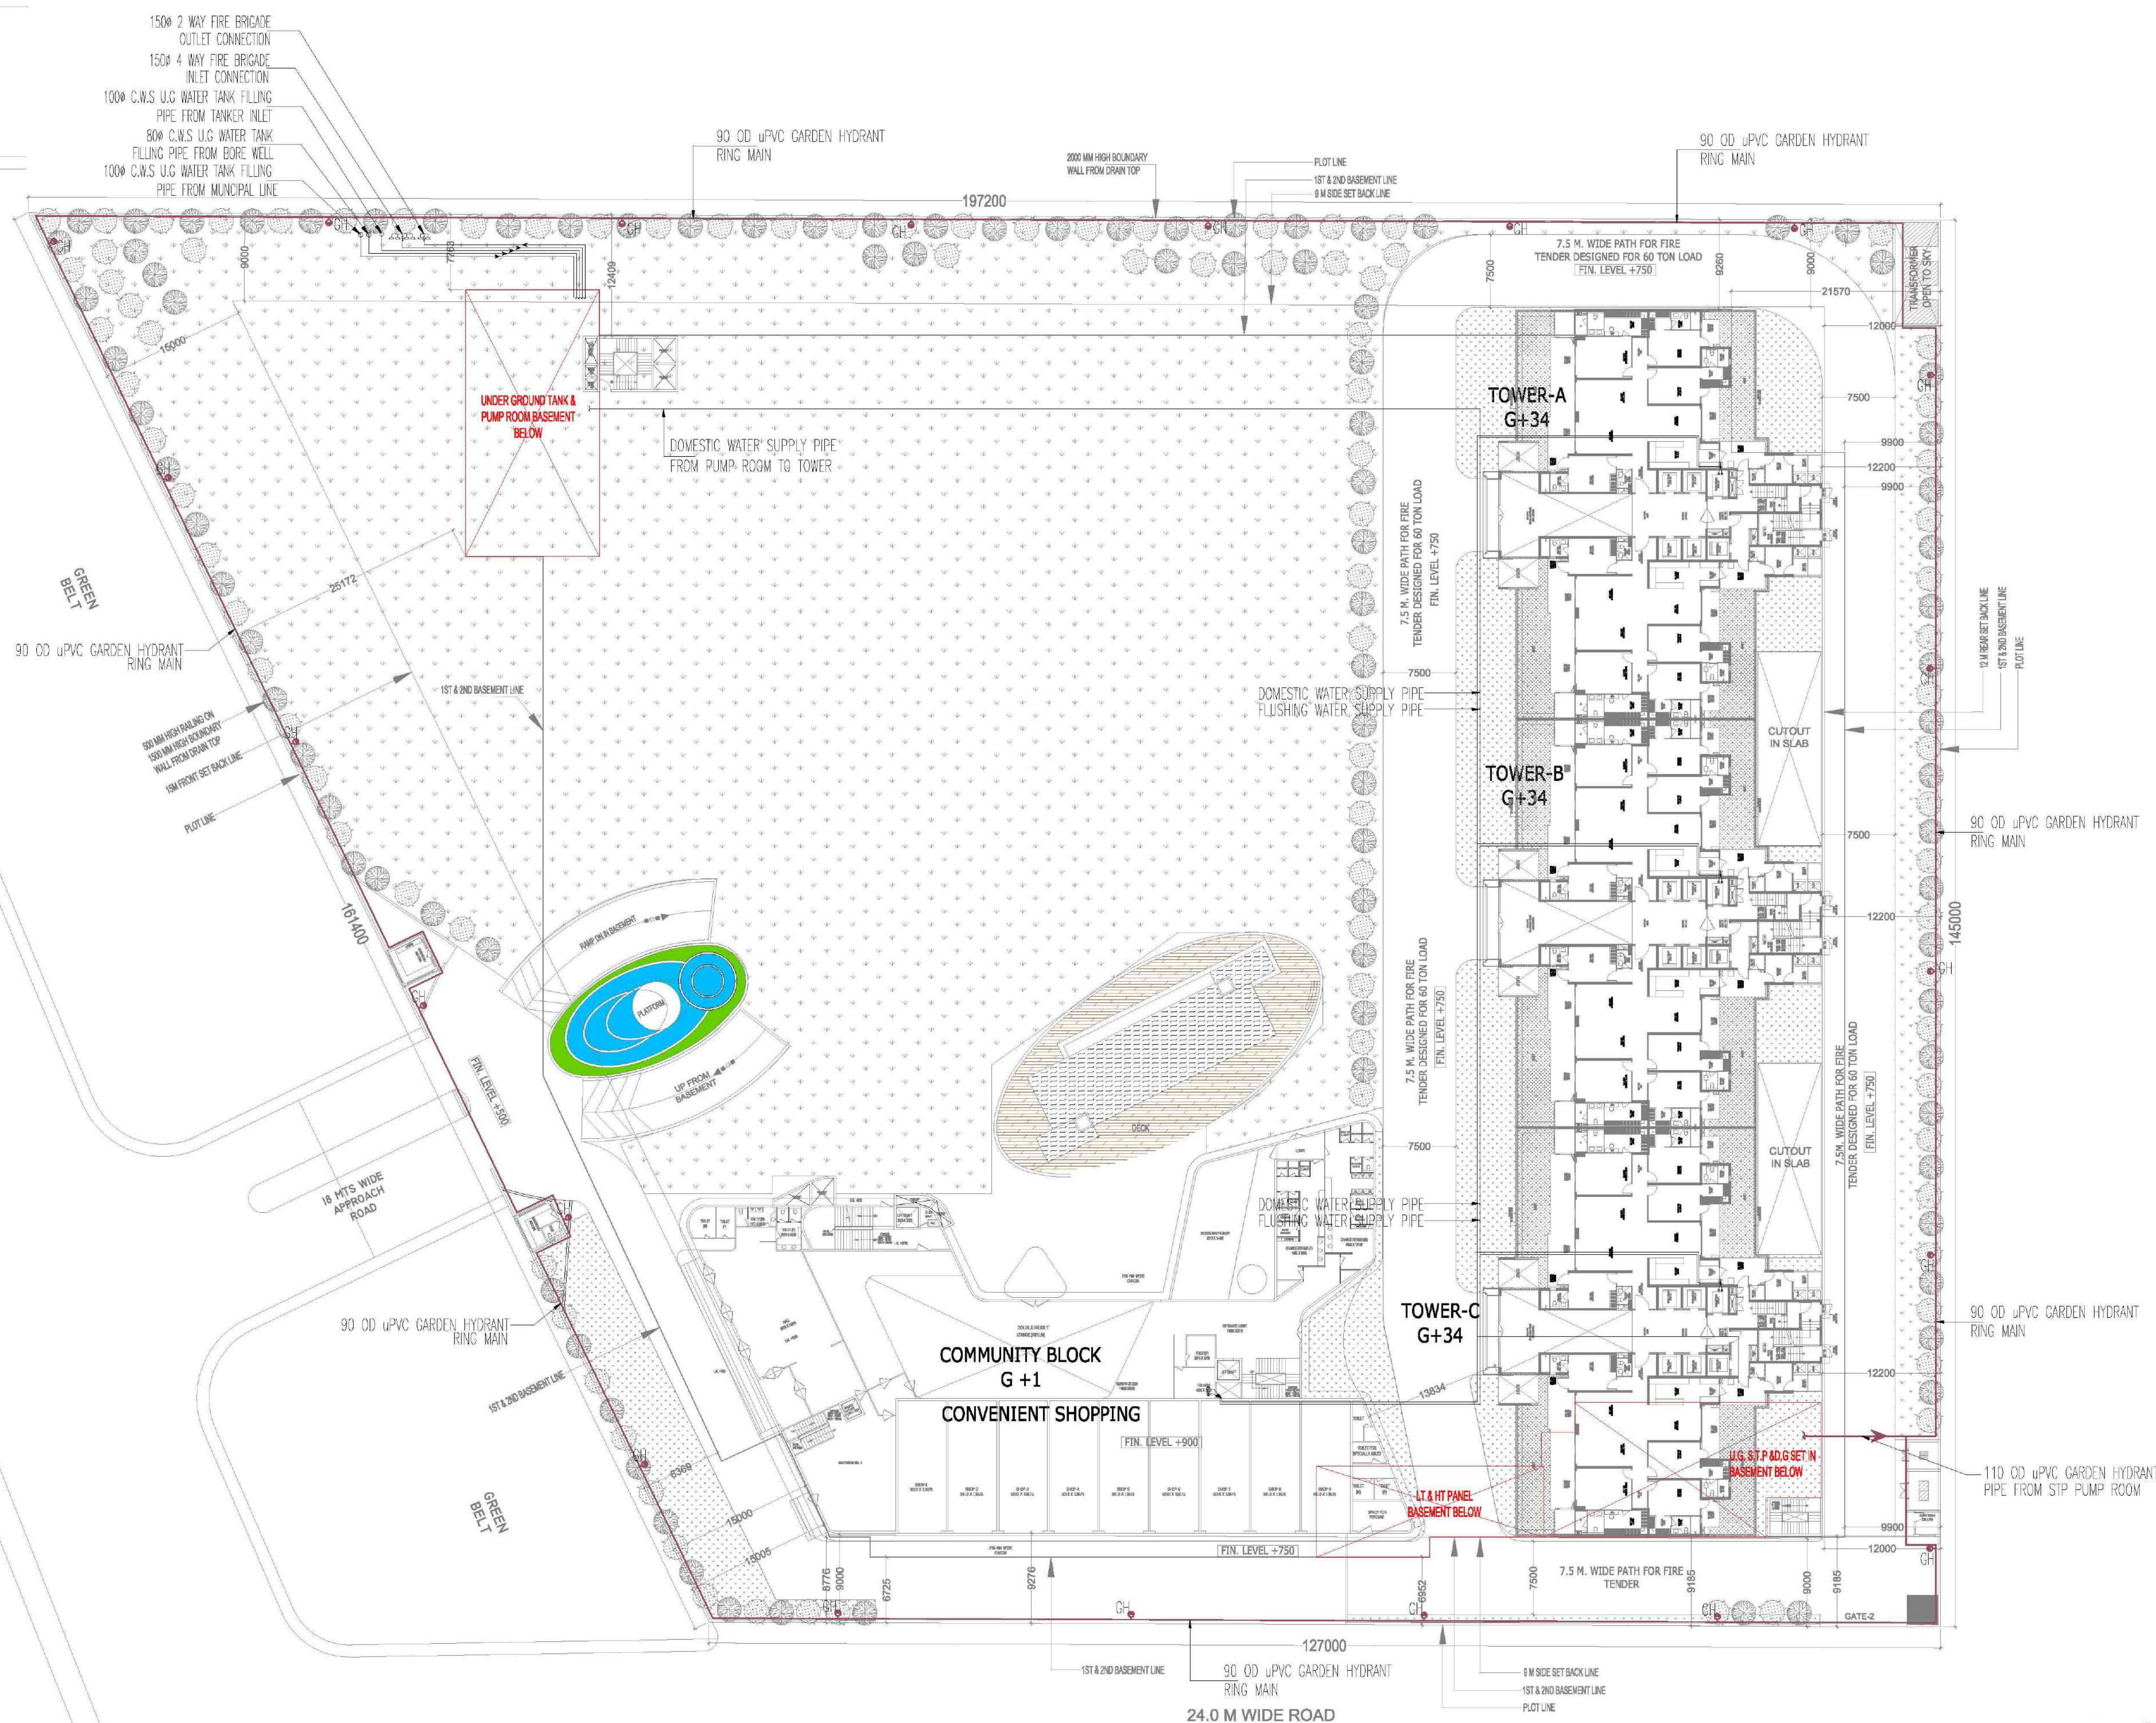

LEGEND FOR PLUMBING	
	COLD WATER SUPPLY LINE
	COLD WATER SUPPLY LINE
	FLUSHING WATER SUPPLY LINE
	BORE WELL LINE
	IRRIGATION LINE
	G.H. GARDEN HYDRANT
	BALL VALVE / BUTTER FLY VALVE
	NO-RETURN VALVE

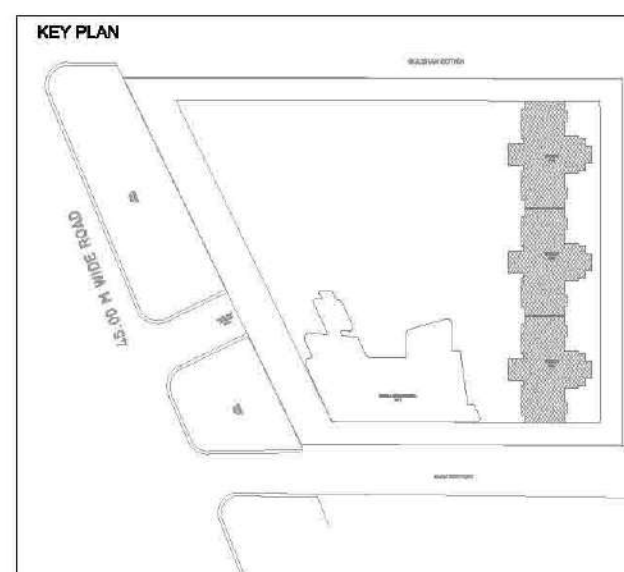

OWNER
FOR GULSHAN HOMZ PVT. LTD.

SUBMISSION DRAWING

PROJECT
PROPOSED GROUP HOUSING FOR
GULSHAN HOMZ PVT. LTD. AT PLOT NO-GH-03D
SECTOR-144, NOIDA, UP

DATE	PROJECT INCH.	CHECKED BY
15-06-2019	BALRAJ SINGH	BALRAJ SINGH
SCALE	DEALT BY	APPROVED BY
1:100	ABOHESH JHA	VINEETA P. SINGHAWA
DRAWING TITLE	SITE PLAN WATER SUPPLY PLUMBING LAYOUT	

SERVICE CONSULTANT

B-50, Basement, Soami Nagar
New Delhi-110017
Tel No: 011-49848197 & 49849205
Email: info@vconsulting.co.in

ARCHITECTS

Confluence

B-431, HFC, Ph-12-11-2816008, con@confluence.com, Member of IAS
N.C.A.B./C.O.A. Ph-43-1-4334718, www.confluence.com, ISO-9001:2008
architecture urban design hospitality interiors

DRAWING NO. S-03 REVISION

For Gulshan Homz Pvt. Ltd.
Authorised Signatory
Authorised Signatory