

Project- GROUP HOUSING


Client-
NARAYAN VRINDAVAN owner
DHRUV NARAIN MEHRA

Purpose :
SANCTION DRAWING

GENERAL NOTES:

1. All dimensions are in metres and are dimensions unless otherwise specified.
2. All levels are in millimetres and are finished unless otherwise specified. All levels are mentioned in the section.
3. Do not scale drawings. Only written dimensions shall be followed, any discrepancy noted shall be brought to the notice of the Architect prior to the execution.


LEGEND

Scale: 1:200@ A1	North: 	Drg No: FF-01-02
Checked by: KP	Date: 03.01.22	Dealt by : KP


Title:
WATER SUPPLY PLANS

CONSULTANT :


RAMESHWARAM
ARCHITECTS & INTERIOR DESIGNERS
17, ANAND NAGAR COLONY,
NEAR HARTMANN FLYOVER,
BAREILLY.
Consultant : Ar. Krishna Pathak
E Mail : rameshwaramarch@gmail.com
Contact : +91-6395625576

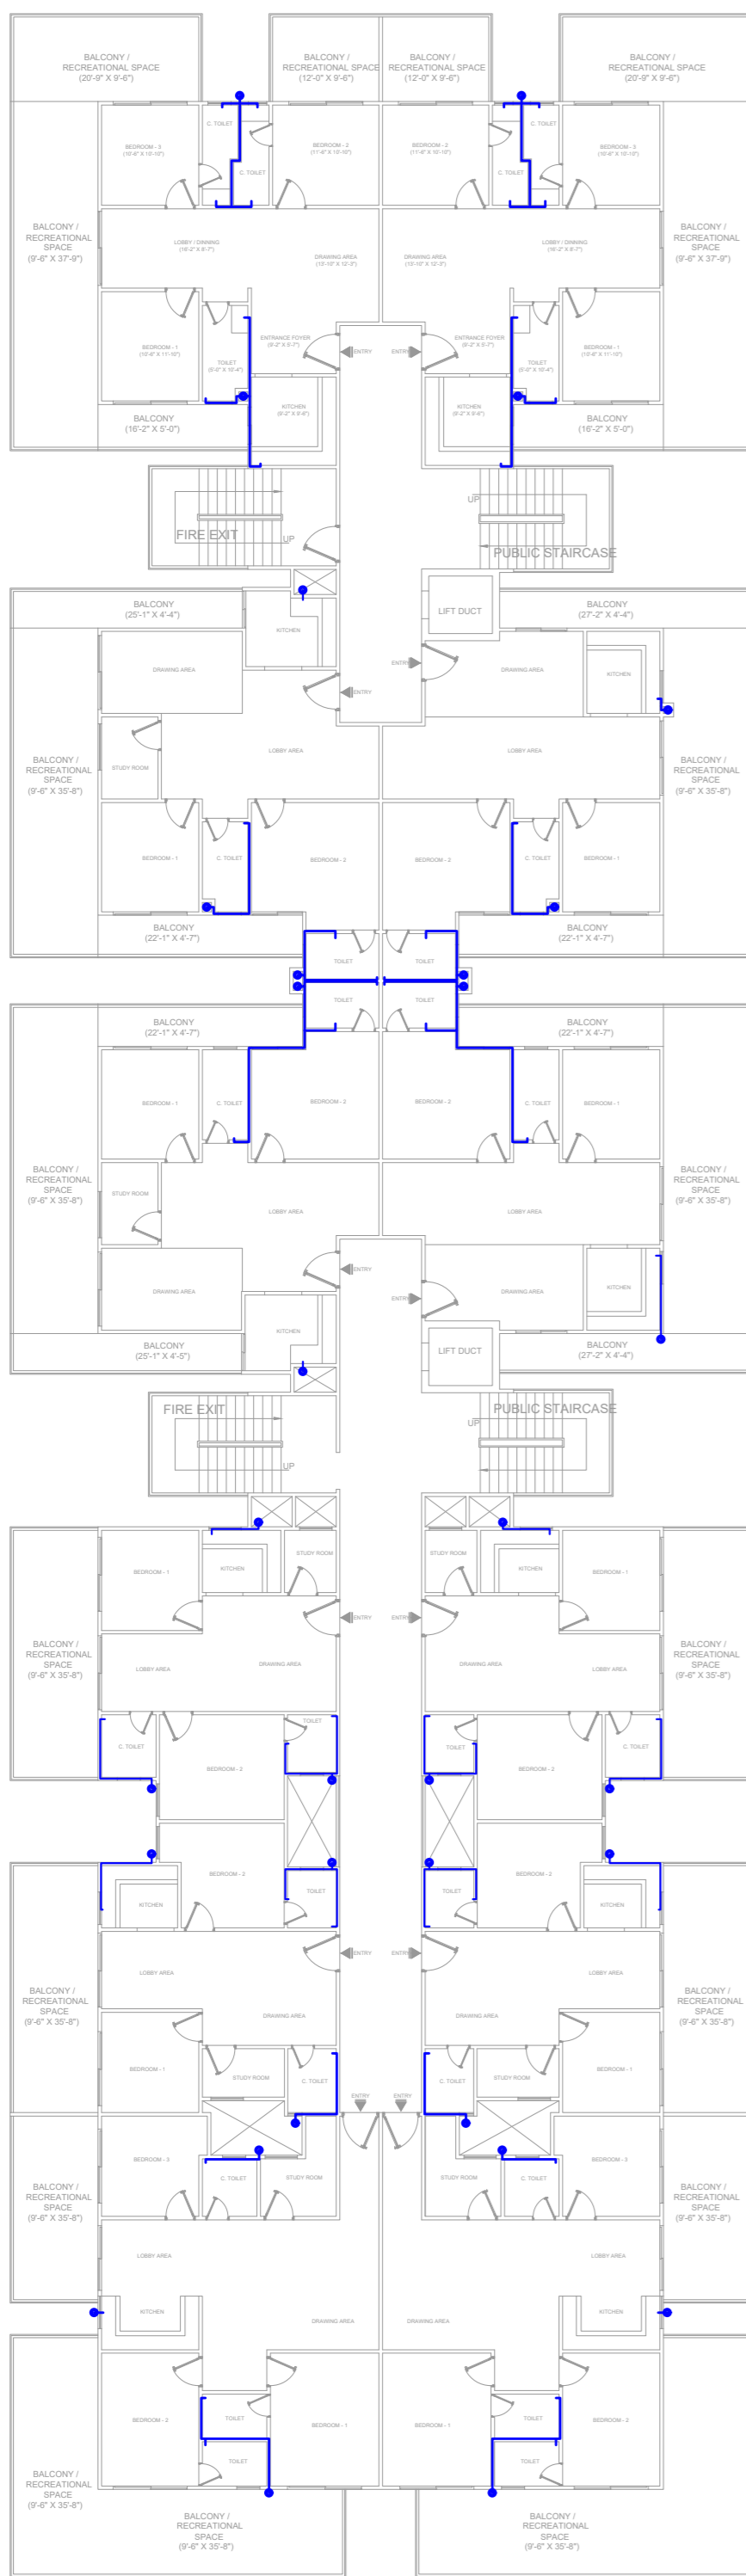

TYPICAL FLOOR PLAN
(3rd, 4th, 5th & 6th FLOOR PLANS)

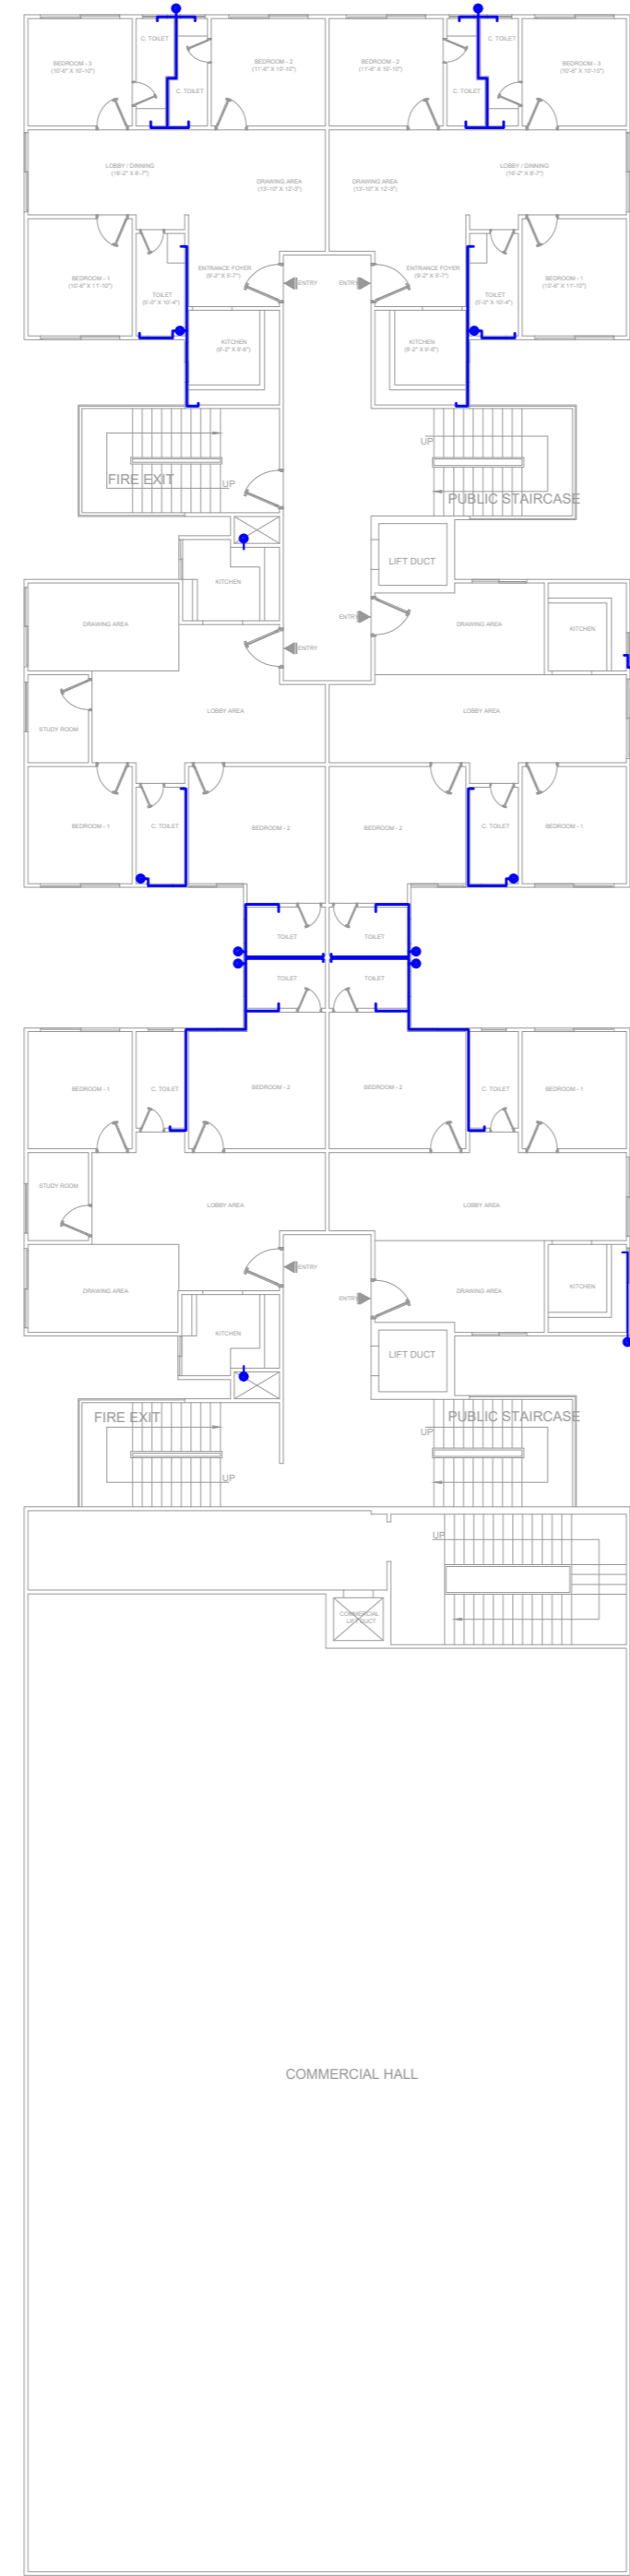

FIRST & SECOND FLOOR PLAN

WATER SUPPLY LEGEND		
S.NO.	DESCRIPTION	SYMBOL
1.	COLD WATER SUPPLY LINE	
2.	COLD WATER PIPE JUNCTION	