



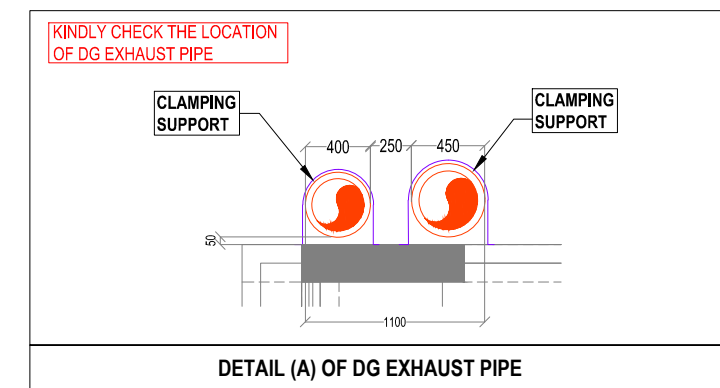

1. TRANSFORMER & DG SETS FOUNDATION SHALL BE GIVEN BY VENDOR.
2. EXACT LOCATION OF CABLE TRENCH SHALL BE FINALIZE AFTER GETTING THE DETAIL OF GLAND PLATE IN HT PANEL.

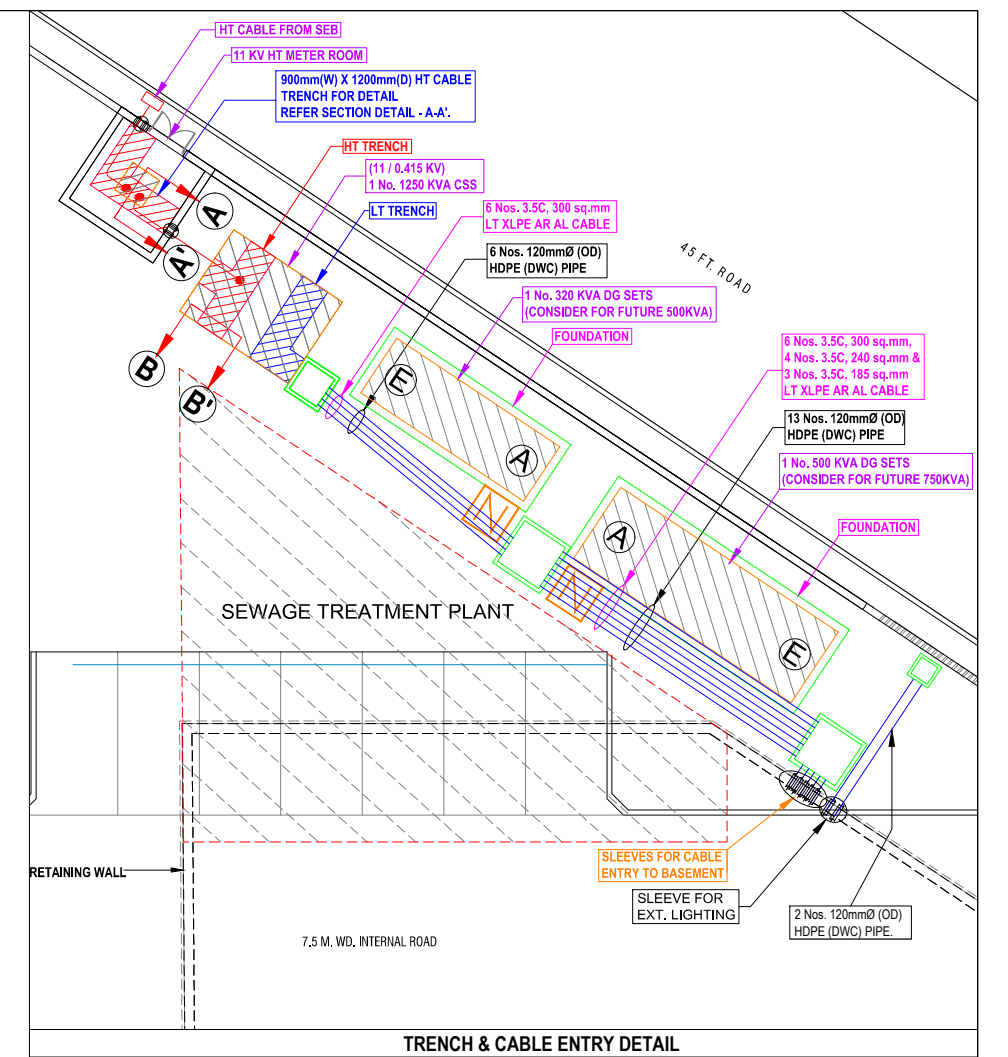

NOTES : FOR HT, LT & VCB ROOM

- 1) Clear height of 11 KV Meter room shall be minimum 3.6 mtr. below clear beam.
- 2) Plinth Level of Meter room shall be 450 mm above final finished ground level.
- 3) Trench detail shall be finalized after receiving foundation detail of HT Meter Panel & 11 KV VCB Panel.
- 4) Ventilation is to be planned as per architecture surrounding level.

project
PANCHSHEEL PEBBLES
AT VAISHALI, GHAZIABAD

title
ELECTRICAL DRAWING

subtitle
SETTING-OUT LAYOUT
AT SITE PLAN.

drawing released for

☐ APPROVAL	☐ SUBMISSION
☐ ADVANCE COPY	☒ CONSTRUCTION

drg. no. PEBBLES / ELEC / EXT / 01	drawn by Najmul
scale 1 : 300 @ A1	designed by Ateeq Ur Rehman
date September, 2017	checked by Anand Havelia

architects
OASIS DESIGNS INCORPORATED
3172, SEC-A, PKT-B, VASANT KUNJ, NEW DELHI-70
PH: 26122440, 26122044 FAX - 2612325
EMAIL : design.oasis@gmail.com

services consultant
Consummate Engineering Services (P) Ltd.

cespl
design, supply, fabricate & install

Noida Office : B - 67, Sector - 67, Noida - 201 301
Tel : (0120) 6943500 (24 Lines)

Lko. Office : R 006, Rohtas Plumeria, Gomti Nagar, Lucknow
e mail : mail@cespl.in, website : www.cespl.in