


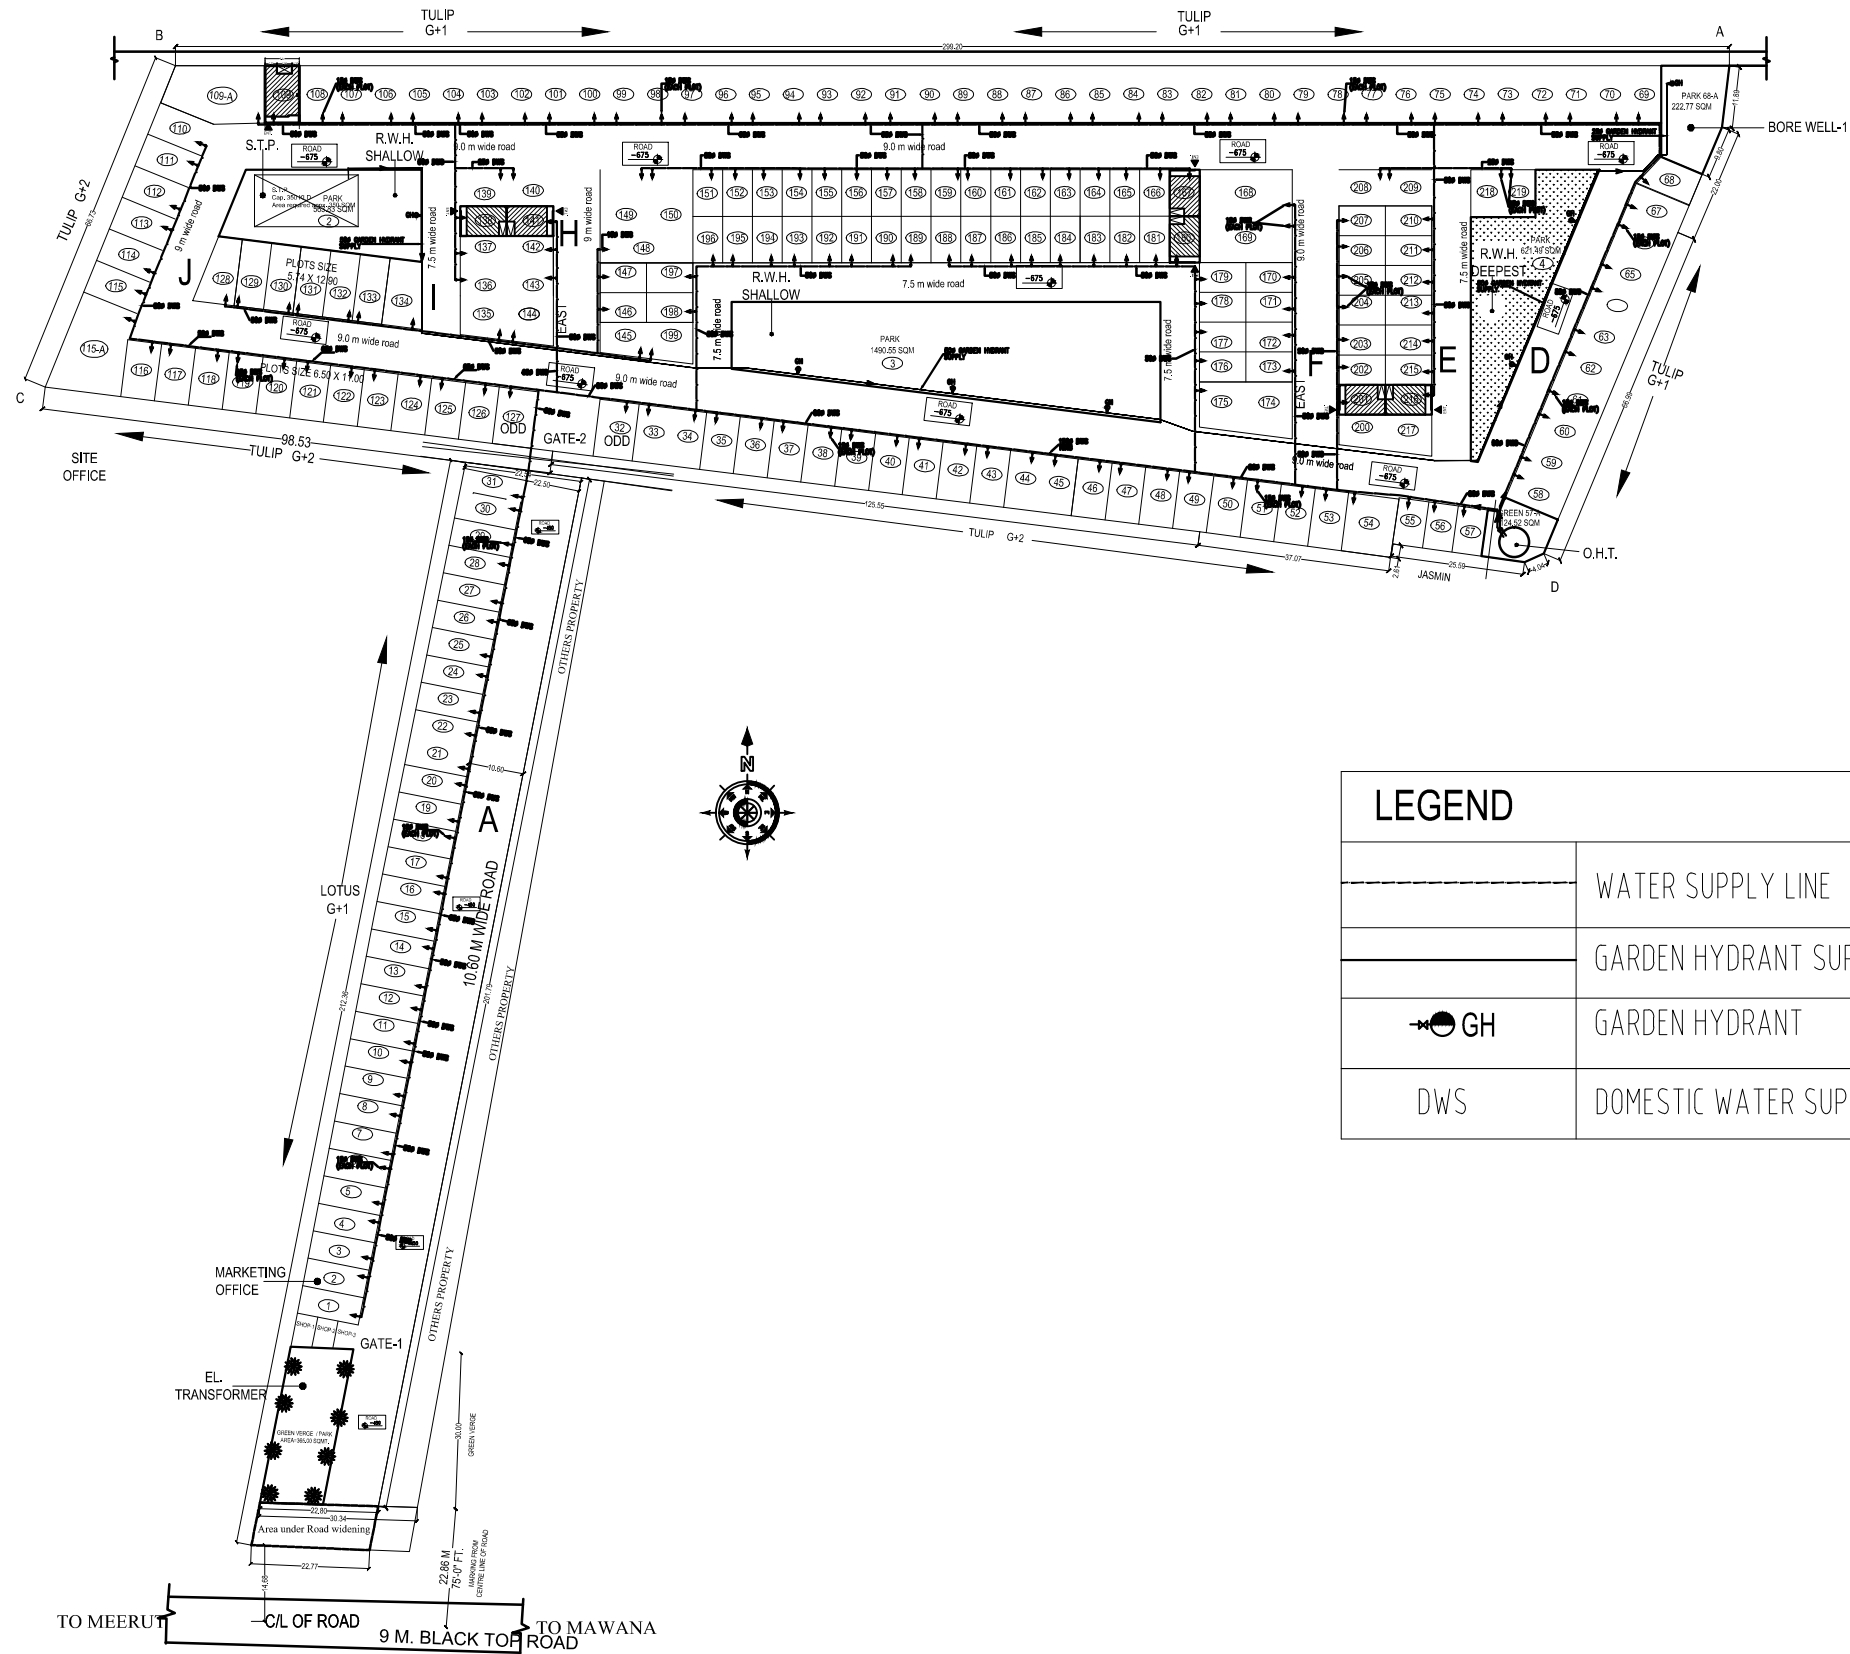

LEGEND	
	WATER SUPPLY LINE
	GARDEN HYDRANT SUPPLY LINE
	GARDEN HYDRANT
DWS	DOMESTIC WATER SUPPLY

OWNER :	ARCHITECTS : AE STUDIO B4/225, SAFDURJUNG ENCLAVE, NEW DELHI-110029. 20161136 EmAil - info@Aestudio.in	SERVICE CONSULTANT:- INTEGRAL DESIGNS E-90 ANAND NIKETAN, NEW DELHI -110021 PHONE:- 41518300, 41518301 E-mail : mep@integraldesigns.in	TITLE : HOUSING @ MAWANA	TITLE : EXTERNAL SITE PLAN FOR WATER SUPPLY SYSTEM	SCALE 1:100 DATE:- 09-06-2016 (R3)	DEALT BY: CHECKED BY:- B.MATHUR	DRG.NO :- PL-WS-01
---------	---	---	------------------------------------	--	--	---------------------------------------	------------------------------