
UPAVP
 ARCHITECTURAL & PLANNING CONSULTANTS
 UTTAR PRADESH
 Email : uphd@sanchamel.in

NOTES:-
 1- ALL DIMENSIONS ARE IN MM
 2- WRITTEN DIMENSIONS ARE TO BE FOLLOWED
 3- ANY DISCREPANCY IN THIS DWG. SHOULD BE BROUGHT TO THE NOTICE
 OF CONCERNING ARCHITECT PLANNER/CHEF ARCHITECT PLANNER.
 4- THE UNIT DESIGN HAS BEEN PROVIDED AND CHECKED. CONFIRMING THAT THERE HAVE BEEN FREQUENTY ERRORS AND CORRECTED THROUGH REGISTRATION BROUGHT IN CONCERN DATED 01 DEC TO 31 DEC 2011.

प्र. संख्या-1076/2014 09 दिनांक 14.12.14
 के तहत के अन्तर्गत
 (भारत पी. ए. राय)
 श्रीमती अश्विनी श्री
 पंचसुखी नगर, लखनऊ


SUBMISSION DRAWING
 DRAWING NO. - 1212161K-RG-01-867-01P01

FILE NO. - 1212161K SHEET NO.-4
 DRAWING TITLE - TYPICAL FLOOR PLAN BRICKSET. (FIRE FIGHTING AND FIRE ALARM SYSTEM)

S.No.	SYMBOL	LEGEND	DESCRIPTION
1	[Symbol]	INDICATE	INDICATE THE POSITION OF FIRE FIGHTING AND FIRE ALARM SYSTEM
2	[Symbol]	INDICATE	INDICATE THE POSITION OF FIRE FIGHTING AND FIRE ALARM SYSTEM
3	[Symbol]	INDICATE	INDICATE THE POSITION OF FIRE FIGHTING AND FIRE ALARM SYSTEM
4	[Symbol]	INDICATE	INDICATE THE POSITION OF FIRE FIGHTING AND FIRE ALARM SYSTEM
5	[Symbol]	INDICATE	INDICATE THE POSITION OF FIRE FIGHTING AND FIRE ALARM SYSTEM
6	[Symbol]	INDICATE	INDICATE THE POSITION OF FIRE FIGHTING AND FIRE ALARM SYSTEM
7	[Symbol]	INDICATE	INDICATE THE POSITION OF FIRE FIGHTING AND FIRE ALARM SYSTEM
8	[Symbol]	INDICATE	INDICATE THE POSITION OF FIRE FIGHTING AND FIRE ALARM SYSTEM
9	[Symbol]	INDICATE	INDICATE THE POSITION OF FIRE FIGHTING AND FIRE ALARM SYSTEM
10	[Symbol]	INDICATE	INDICATE THE POSITION OF FIRE FIGHTING AND FIRE ALARM SYSTEM

DATE	SCALE	BY	CHECKED
JANUARY 2014	SCALE 1/4	ARCHITECT	ARCHITECT
		ASST. ARCHITECT	ASST. ARCHITECT
		ARCHITECT PLANNER	ARCHITECT PLANNER
		CHIEF ARCHITECT PLANNER	CHIEF ARCHITECT PLANNER
		MANAGING PARTNER/OWNER	MANAGING PARTNER/OWNER



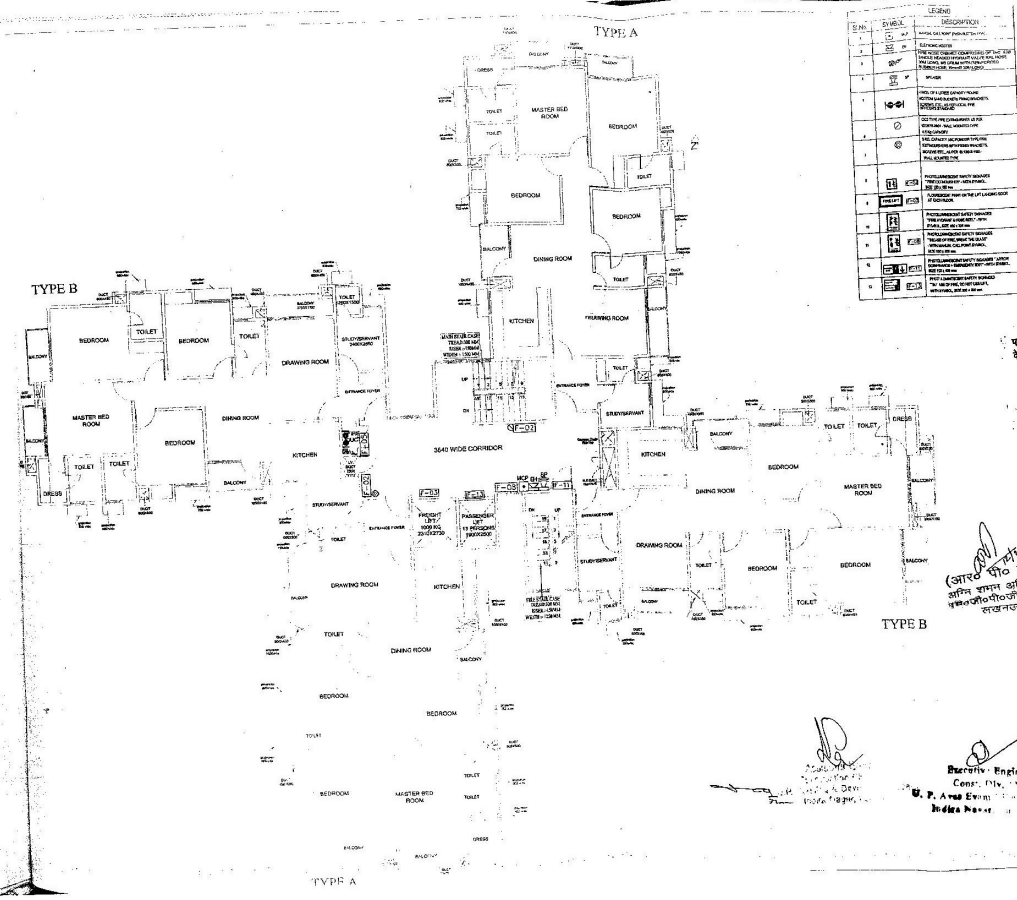

Sl. No.	Symbol	Description
1	10-01	Architectural Drawing
2	10-02	Structural Drawing
3	10-03	MEP Drawing
4	10-04	Site Plan
5	10-05	Section Drawing
6	10-06	Foundation Drawing
7	10-07	Roof Plan
8	10-08	Detail Drawing
9	10-09	Contract Documents
10	10-10	Other Documents

UPAVP
 ADDRESS: 101, PUNE DISTRICT
 URBAN DEVELOPMENT
 ISO-9001:2008
 Email: upavp@sancharnet.in

NOTES
 1. ALL DIMENSIONS ARE IN M.M.
 2. ANY DISCREPANCY IN THIS DRAWING SHOULD BE REPORTED TO THE ARCHITECT PLANNER.
 3. THE UNIT DESIGN HAS BEEN PREPARED AND CHECKED/CONSIDERED THAT THESE HAVE BEEN PREVIOUSLY PUBLISHED AND CIRCULATED THROUGH REGISTRATION BUREAU'S CONCERN GATED BY DEC TO 31 DEC 2011.

पर मंडल-107/2014 (2) दिनांक 11.11.15
 के तहत के अनुसार
 (अतिरिक्त रूप से)
 जम्मा
 फाउंडेशन, प्लान, प्रोफाइल
 एंड अन्य सबमिशन

(आपको फोन पर
 सविनियमित अतिरिक्त
 प्रमाणित प्रमाणित)
 सचिव

SUBMISSION DRAWING	
DRAWING NO. 12121616/RD-41-SIF-02/01	SHEET NO-3
FILE NO. 12121616	
DRAWING TITLE: INITIAL FLOOR PLAN (TYPE-B) (FIRE FIGHTING AND FIRE ALARM SYSTEM)	
PROJECT: EVEREST ENCLAVE SECTIONS-18, GROUP HOUSING AT MIDC/ANAN SCHEME LUDHIANA.	
DATE: JANUARY 2014	SCALE: AS SHOWN
ARCHITECT: MARINEM <small>101, PUNE DISTRICT URBAN DEVELOPMENT LUDHIANA-141002, PUNJAB THE INFORMATION CONTAINED IN THIS DRAWING IS THE PROPERTY OF MARINEM ARCHITECTS & ENGINEERS. IT IS TO BE USED ONLY FOR THE PROJECT AND SITE SPECIFICALLY MENTIONED THEREIN.</small>	
DESIGNER: ARCH ASST.	
EXECUTIVE ENGINEER Const. Div. U.P. Ludhiana	ASST. ARCHITECT PLANNER
	ARCHITECT PLANNER
	CHIEF ARCHITECT PLANNER
	HOUSING COMMISSIONER