


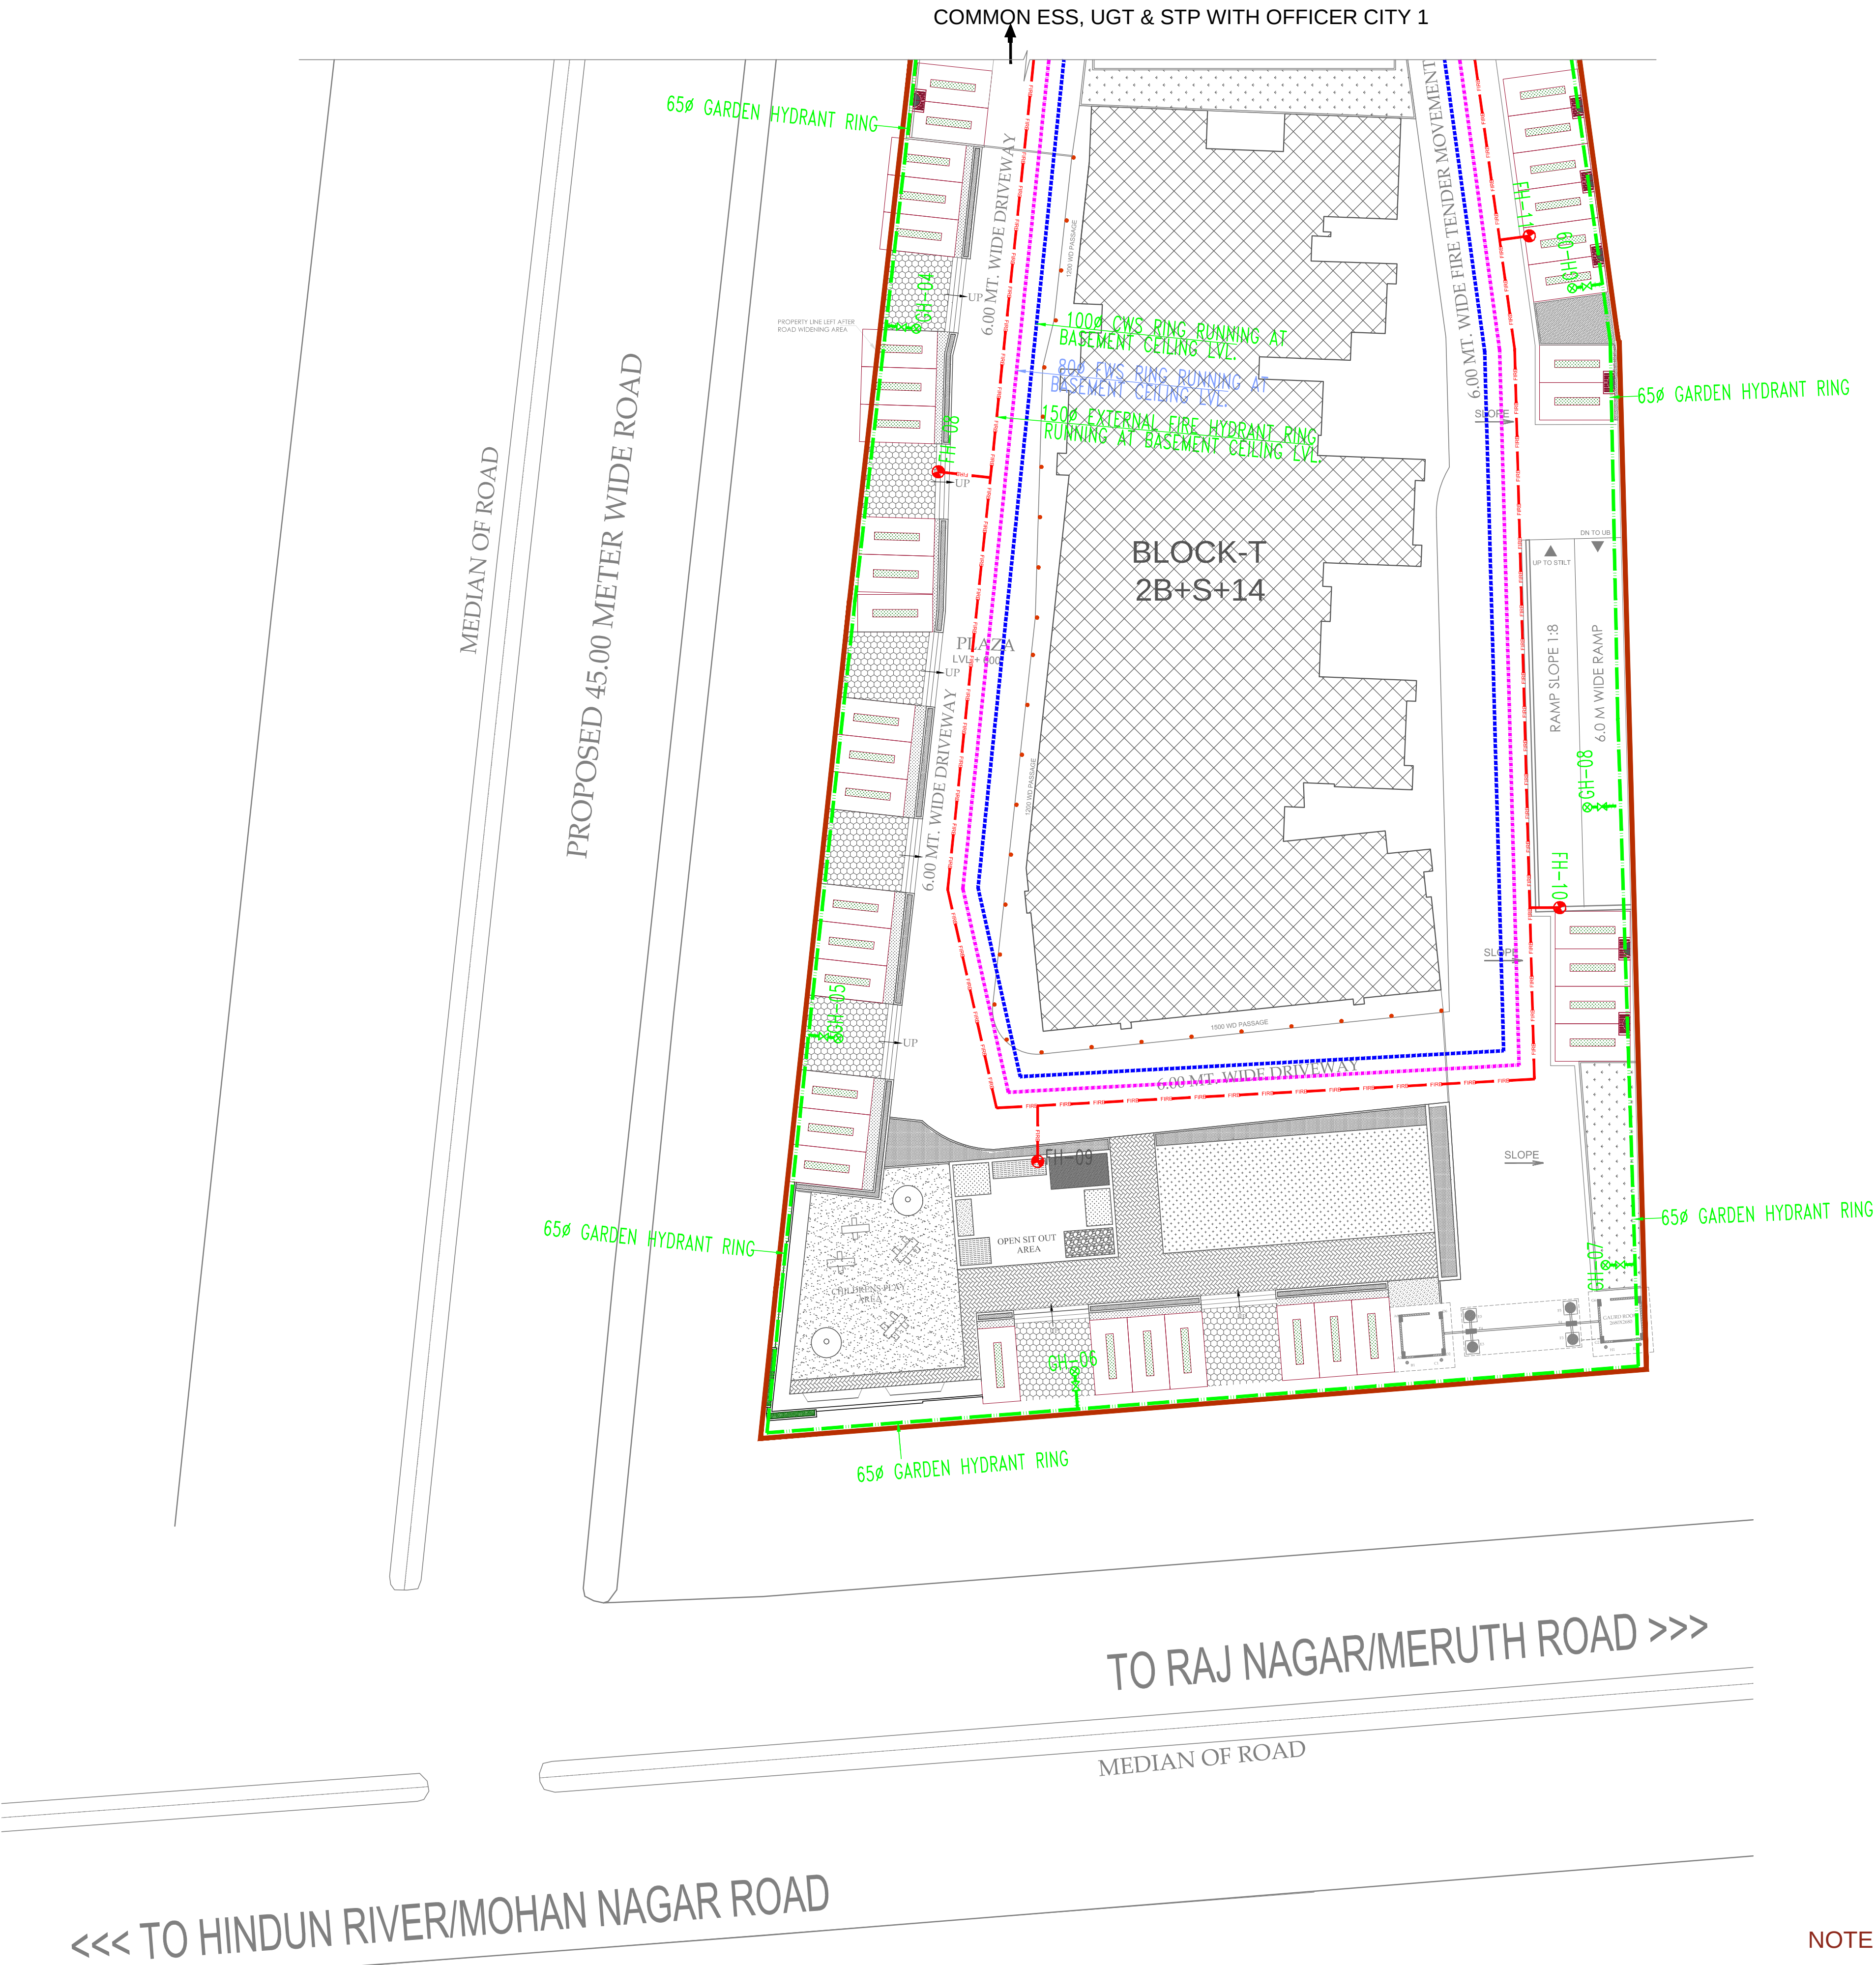

PLUMBING LEGEND:-	
MW	DOMESTIC WATER SUPPLY FILLING LINE FROM MUNICIPAL / TANKER LINE.
65mm GH	65mm GARDEN HYDRANT RING
TW	TUBE WELL WATER SUPPLY LINE
FH	EXTERNAL FIRE HYDRANT LINE
Flushing	FLUSHING WATER SUPPLY
CWS	COLD WATER SUPPLY
FH	FIRE HYDRANT (80mm TO FH)
2-Way	2-WAY FIRE BRIGADE WITHDRAWAL CONNECTION.
3-Way	3-WAY FIRE BRIGADE INLET CONNECTION.
GH	GARDEN HYDRANT (25mm TO GH)

PROJECT :-

REV.SUBMISSION DRAWING FOR THE PROPOSED GROUP HOUSING "OFFICER CITY-1" , HERITAGE & NITYA HOMES AT KHASRA NO. 1052 , 1059 & 1060 , 1098 VILLAGE NOORNAGAR GHAZIABAD (U.P.)

PROMOTER :-

M/S. R.K.S.BUILDCON INDIA P.Ltd.
M/S. LOTOUS ENTERPRISES
M/S. PROVIV INFRASTRUCTURE (P.)Ltd.

DIRECTOR:
Mr. PUNEET TYAGI

DRAWING TITLE : **SERVICES PLAN**
(water supply & fire services)

OWNER'S SIGN

ARCHITECT'S SIGN

ANUJ AGARWAL ARCHITECTS
OFFICE- A-214 KAUSHAMBI GHAZIABAD (U.P.)
Ph.-0120 - 6454182 / 84, 4166716, TEL. FAX - 2773592
e-mail : arch.anujagarwal@gmail.com

SCALE	DEALT BY A. CHAUHAN	DATE
DESIGN BY	CHECKED BY	DRG. No. DG-02A

NOTE :- ESS , STP & UGT ARE COMMON FOR OFFICER CITY-1 & M.R HERITAGE